


PROPOSED SITE PLAN
SCALE 1:100

GENERAL NOTES

Use written dimensions only, do not scale from drawing. Use latest revision of all referenced information.

A	20.07.21	New BT Streethub Structure	MD	JE
Rev	Date	Description	Drawn	Chkd

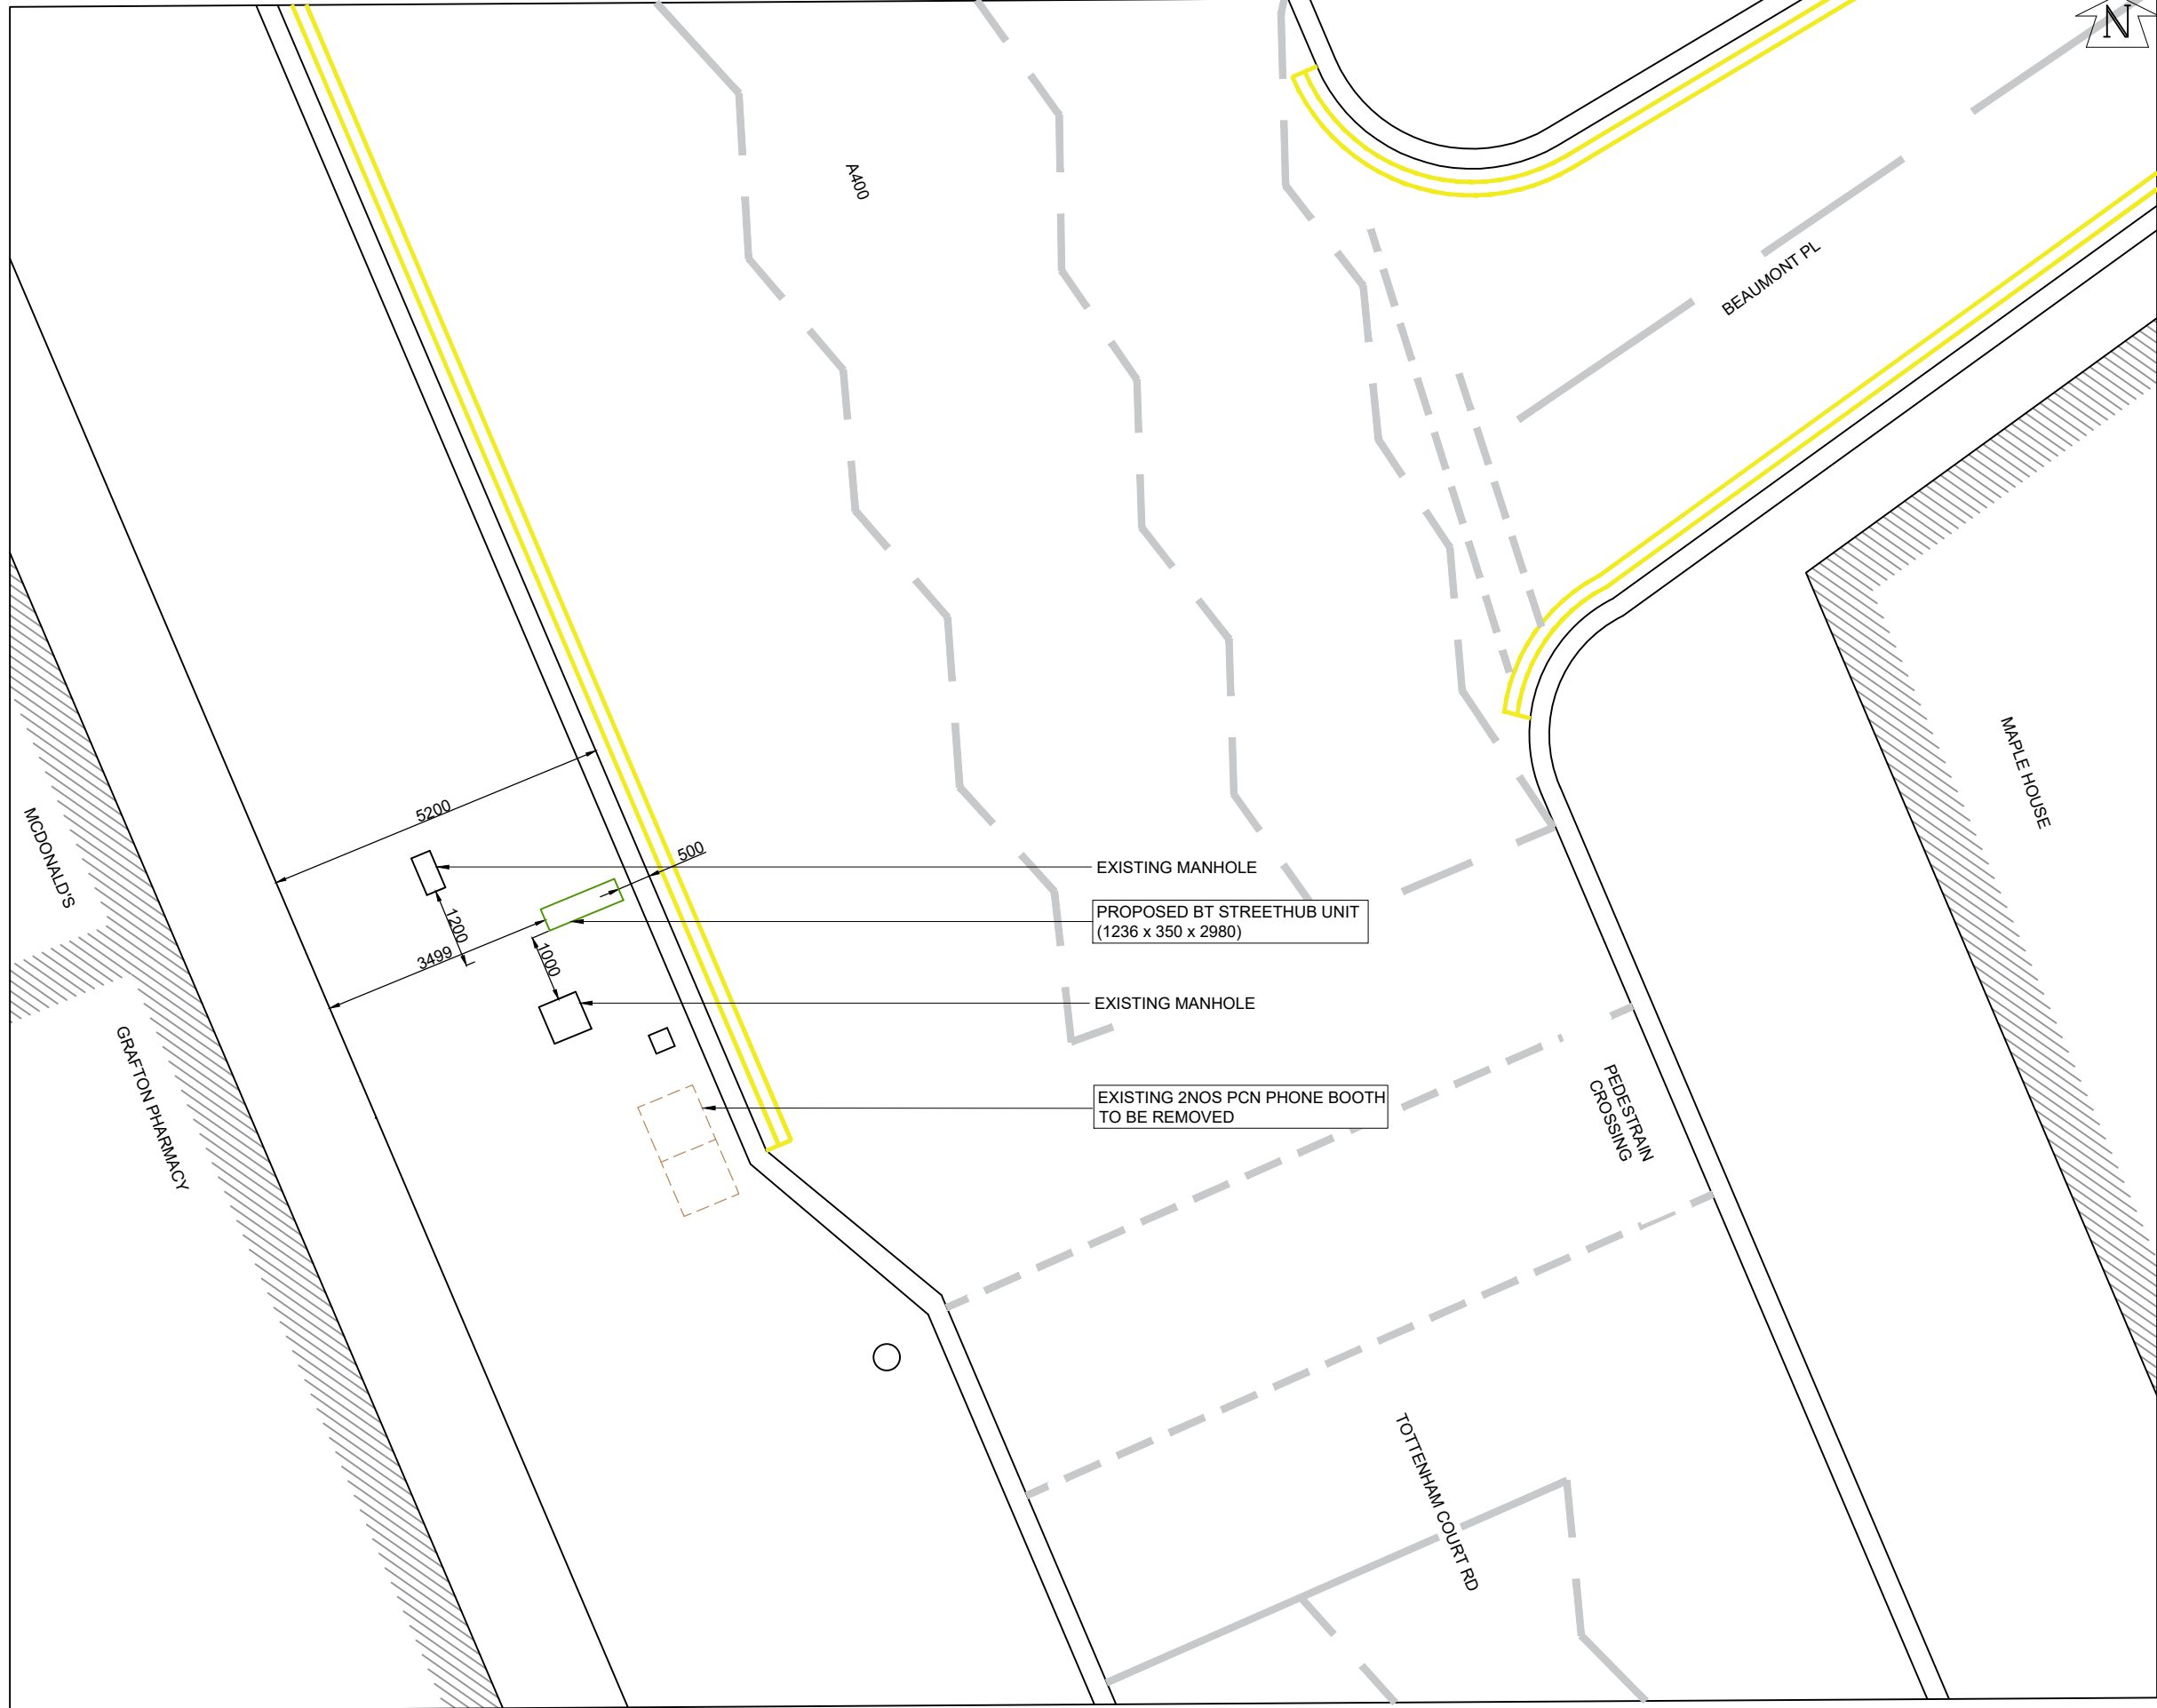

MONO CONSULTANTS LIMITED
70-76 Steam Packet House
Cross Street
Manchester, M2 4JG
t. 44 (0)161 839 8839
www.monoconsultants.com



Drg Status
PLANNING

Cell No. & Name

CAM009

Site Name & Address

Pavement o/s 132 Tottenham Court Rd, London W1T 5AZ

Drawing Title
PROPOSED SITE PLAN

Scale	1:100	Date	20.07.21
Drawn By	MD	Checked By	JE

Drawing Number	Revision
002	A