



REVISION SCHEDULE		DATE	DRAWN BY
REV	REVISION DETAILS	13.08.21	DMA
P1	DRAFT FOR REVIEW AND COMMENT	10.09.21	DMA
P2	UPDATED FOLLOWING COMMENTS 08.09.21	13.09.21	DMA
P3	PLANNING SUBMISSION		

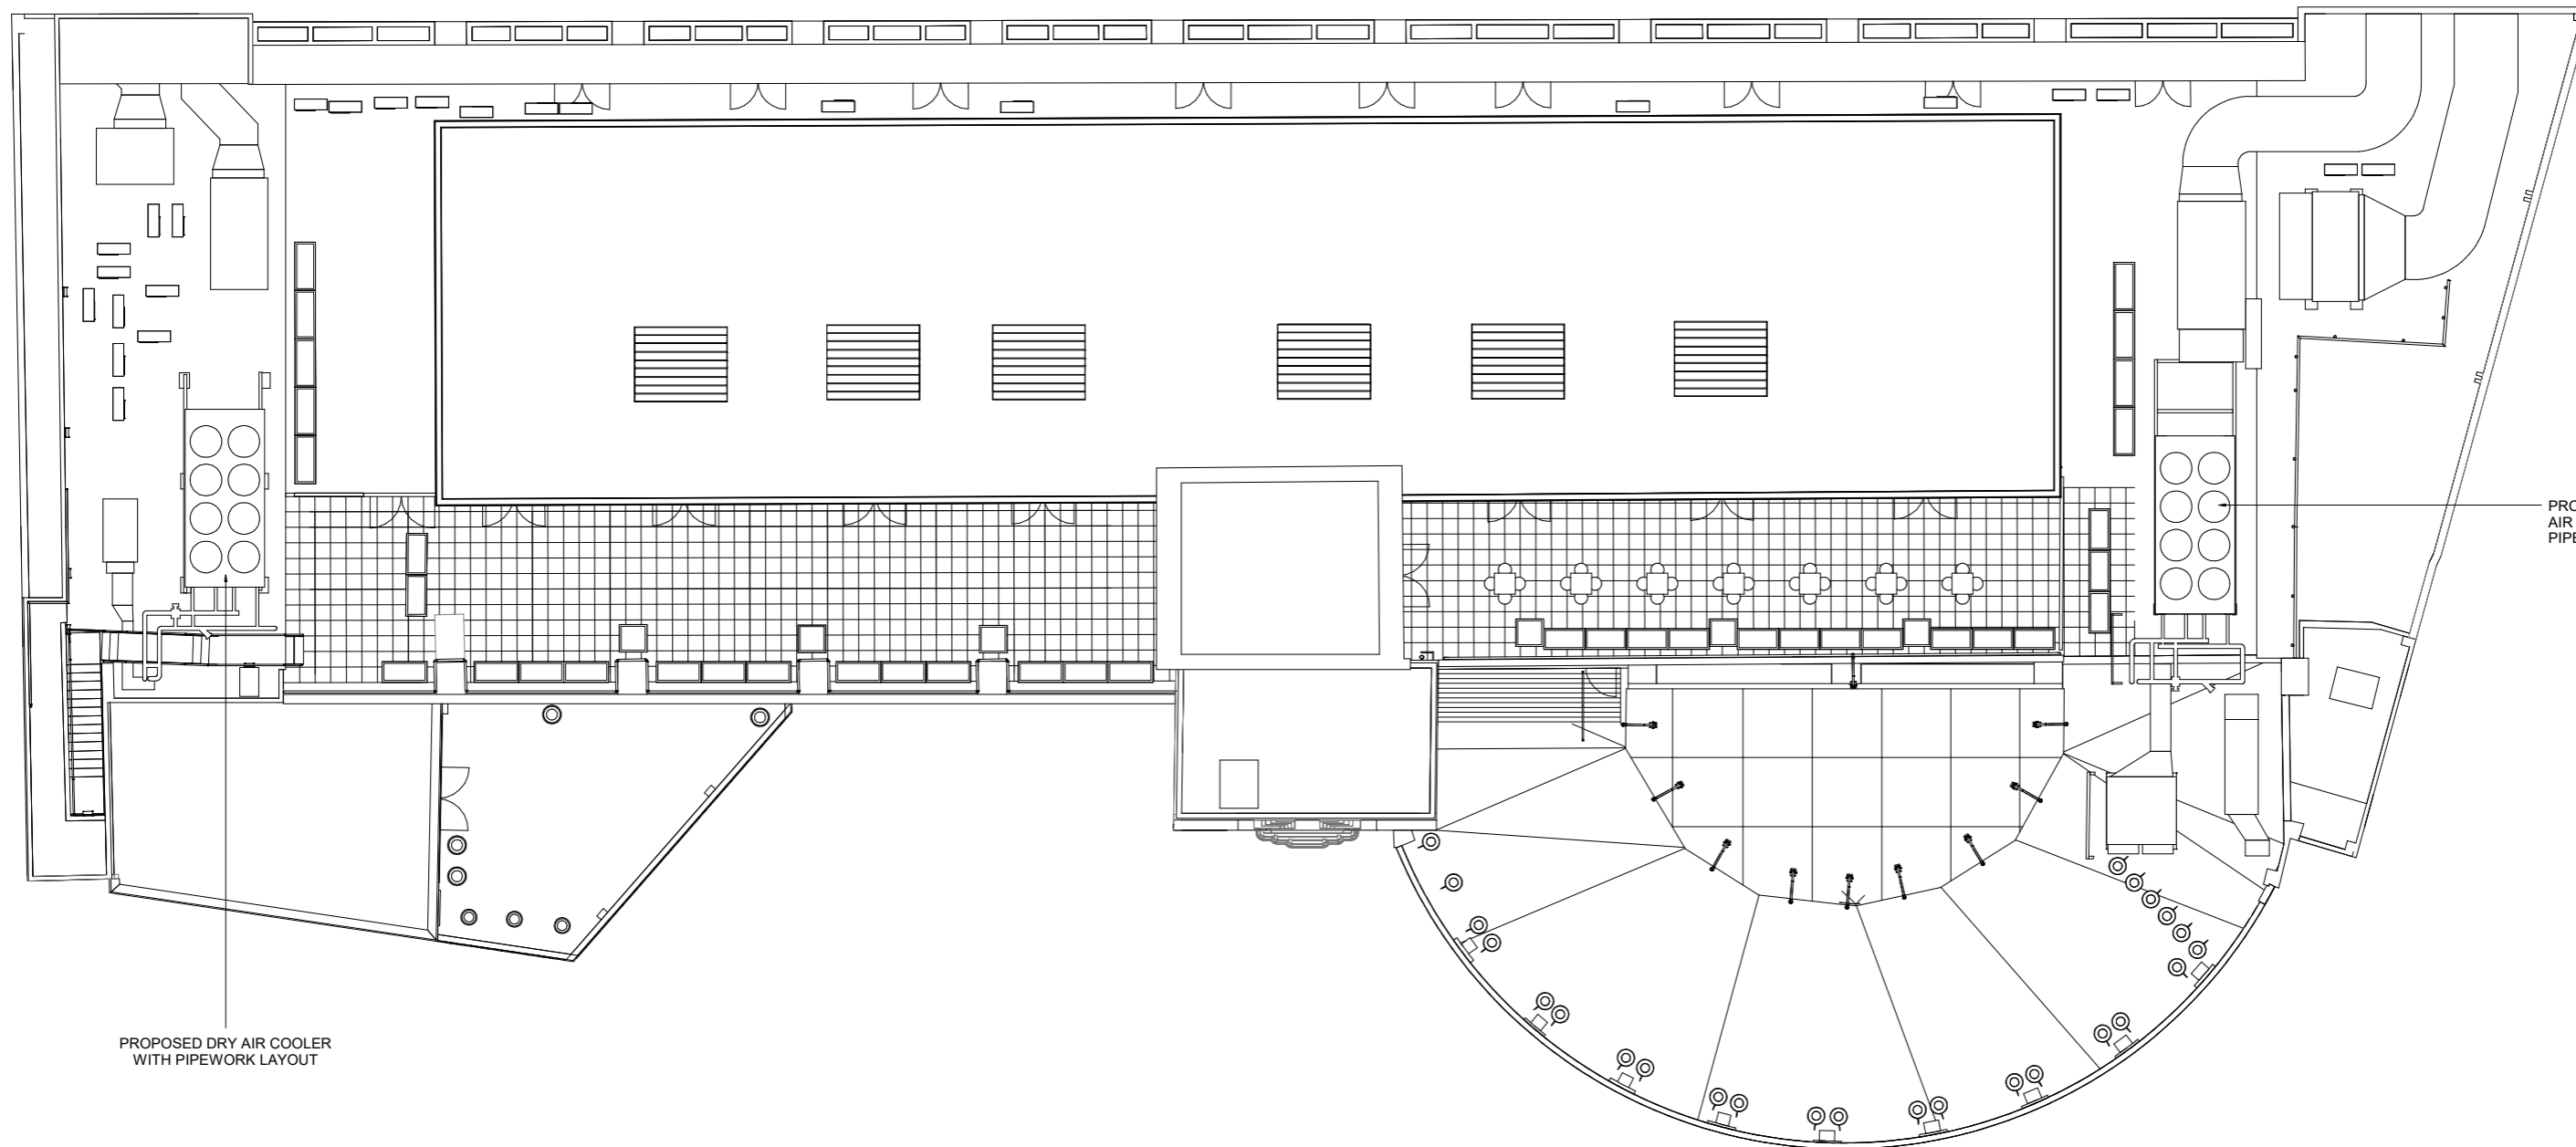

PROPOSED DRY AIR COOLER
WITH PIPEWORK LAYOUT

PROPOSED DRY AIR COOLER WITH
PIPEWORK LAYOUT

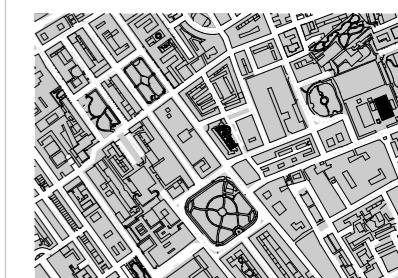

KEY PLAN

ORIGINATOR: **DMA** TITLE: **GA PROPOSED PLANS - ROOF PLAN**

PROJECT: **LABS - LHB HERBRAND ST LONDON** PURPOSE OF ISSUE: **FOR PLANNING** STATUS: **S2** REVISION: **P3**

JOB NO.: **577** SCALE: **1:100@A1** DRAWN: **CS** CHECKED: **DAS** APPROVED: **DMA**

PROJECT ORIGINATOR: **LHB DMA** VOLUME: **XX** LEVEL: **ZZ** TYPE: **DR** ROLE: **A** DOC NO: **021008**



GRAPHIC SCALE 1:50