
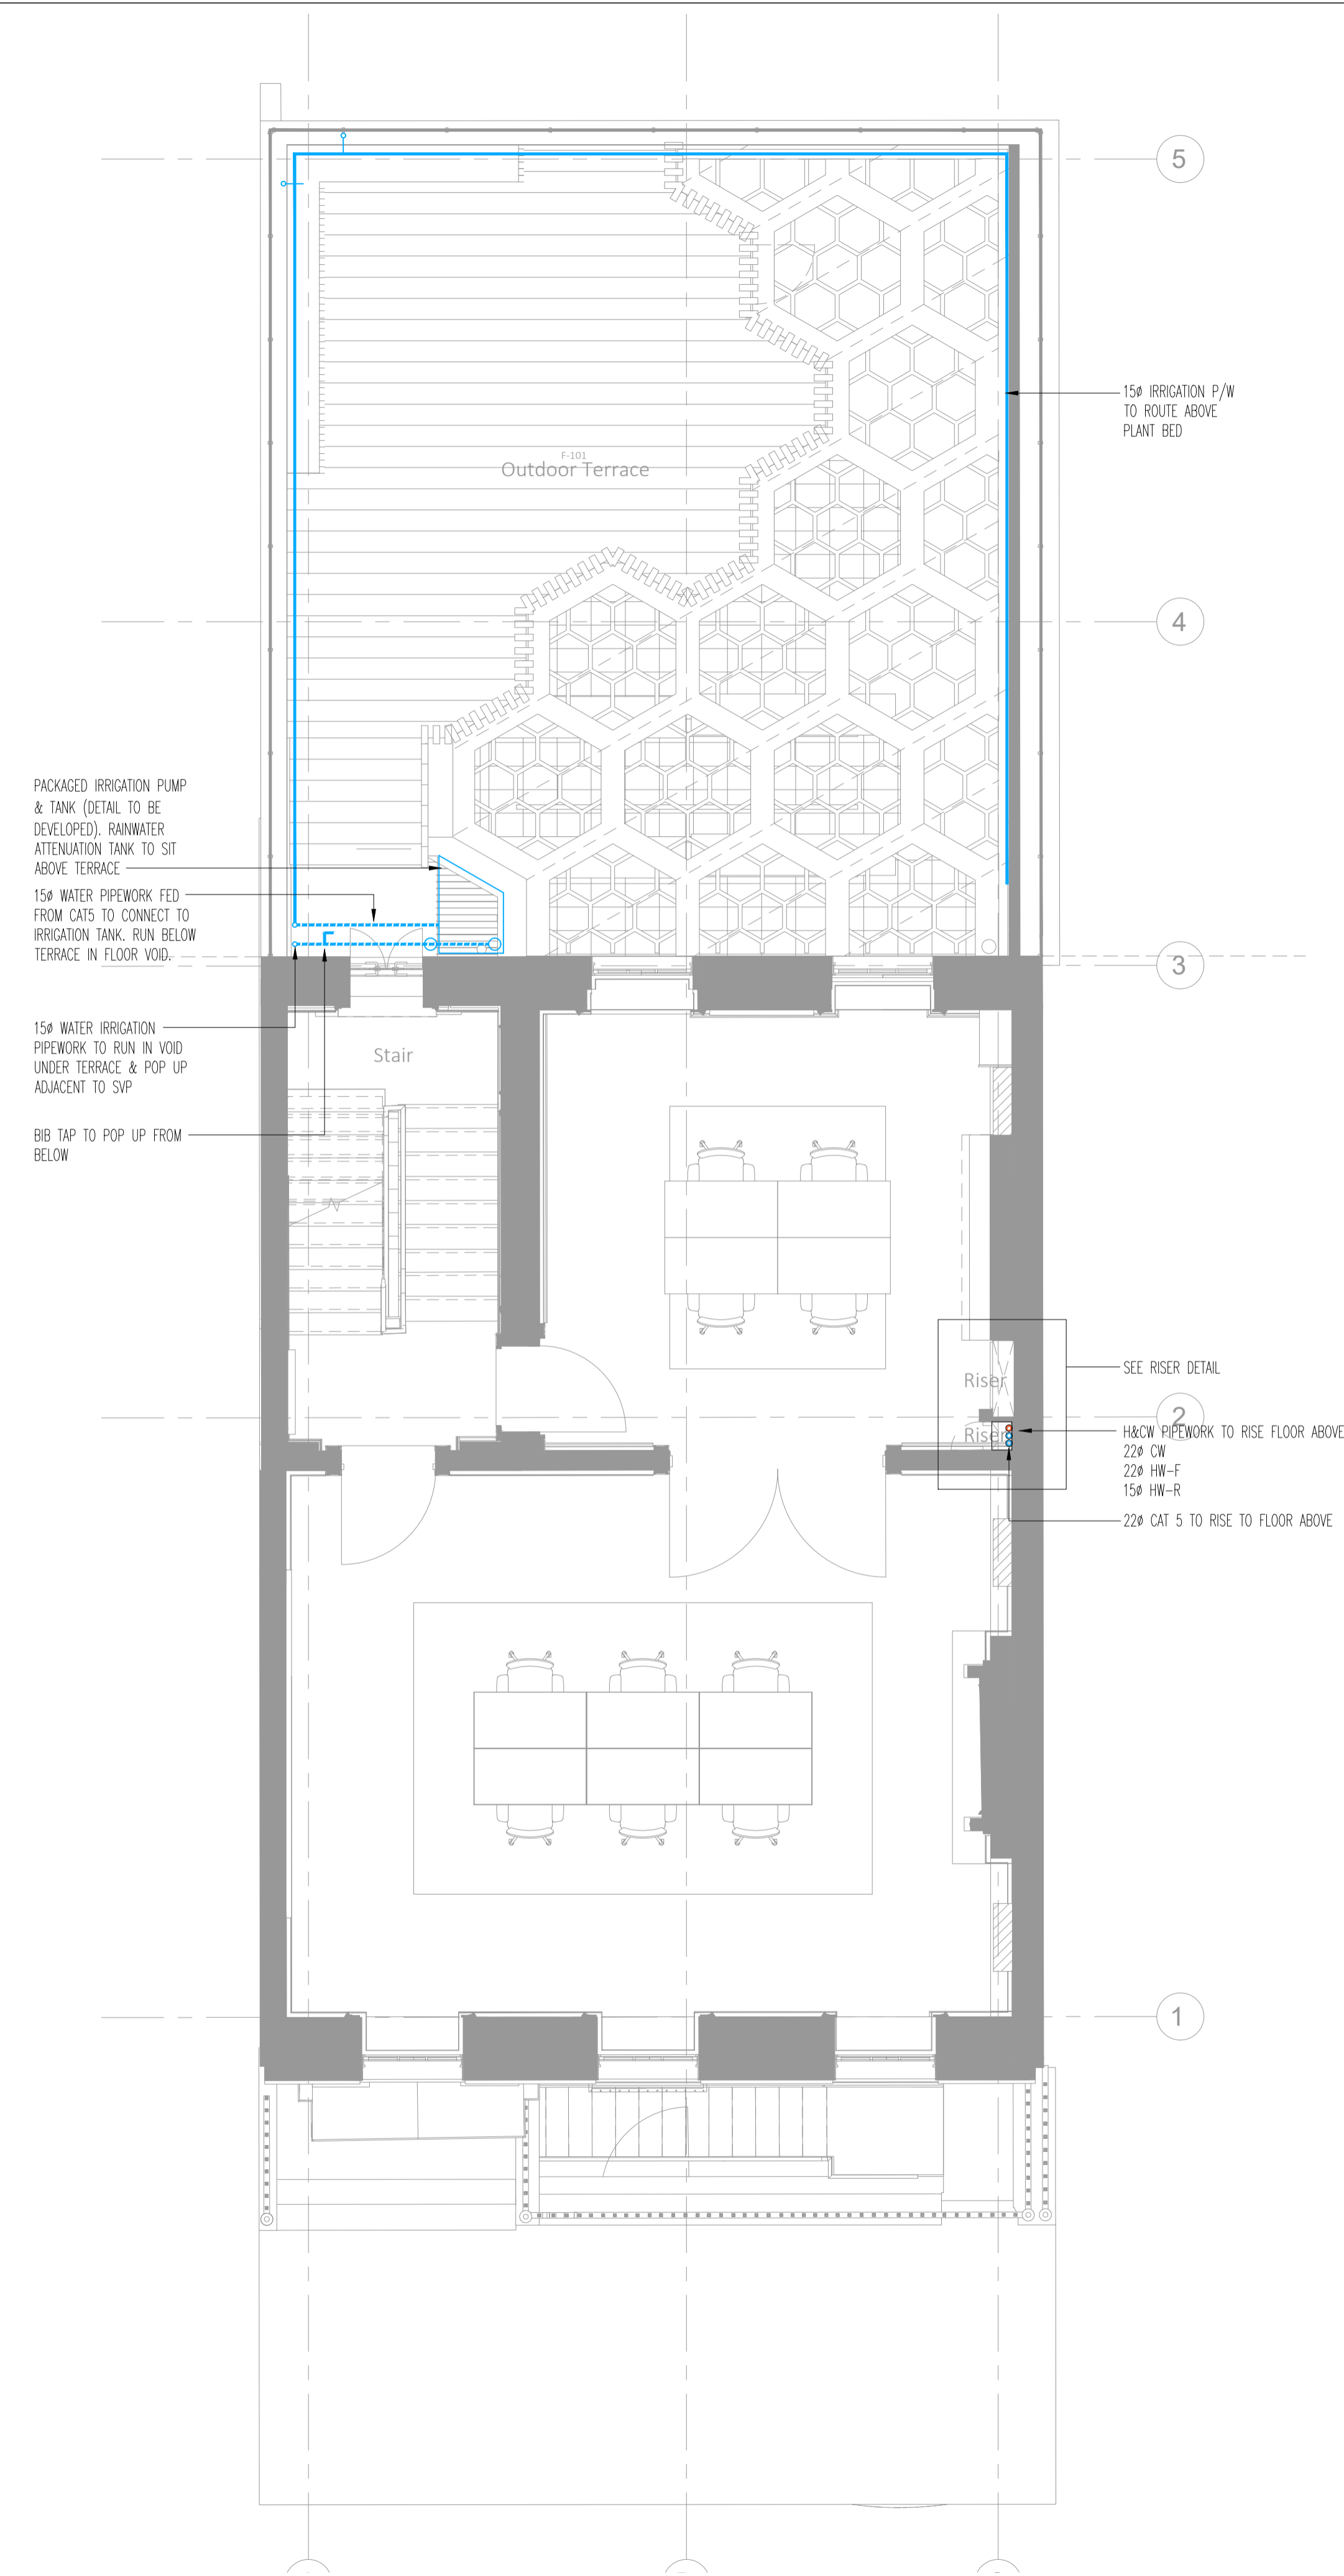


GENERAL NOTES

1. REFER TO SCHEMATICS FOR ALL VALVES
2. REFER TO MECHANICAL SCHEDULES
3. SANITARYWARE SPECIFIED BY ARCHITECT. CONTRACTOR TO ALLOW INSTALL ONLY.

LEGEND

- HOT WATER
- COLD WATER
- HIGH LEVEL PIPEWORK
-  QUOOKER TAP
- W/M - WASHING MACHINE
- D/W - DISHWASHER



PACKAGED IRRIGATION PUMP & TANK (DETAIL TO BE DEVELOPED). RAINWATER ATTENUATION TANK TO SIT ABOVE TERRACE

150 WATER PIPEWORK FED FROM CATS TO CONNECT TO IRRIGATION TANK. RUN BELOW TERRACE IN FLOOR VOID.

150 WATER IRRIGATION PIPEWORK TO RUN IN VOID UNDER TERRACE & POP UP ADJACENT TO SWP

BIB TAP TO POP UP FROM BELOW

150 IRRIGATION P/W TO ROUTE ABOVE PLANT BED

SEE RISER DETAIL


220 HW-F

220 CAT 5 TO RISE TO FLOOR ABOVE

NO SERVICES SHALL BE RUN ON SURFACE/EXPOSED AND MINI TRUNKING SHALL NOT BE INSTALLED IN ANY ROOM.

ALL SERVICES RUNS TO BE REVIEWED ON SITE FOLLOWING STRIP OUT AND OPENING UP.

NEW SERVICE ROUTES TO BE INSTALLED WITHIN EXISTING BUILDERS WORK & UTILISED WHEREVER POSSIBLE.

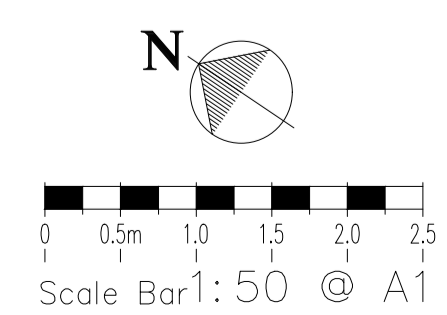

STAGE 4

Rev	Date	Description
A	APR.21	REVISED TO SUIT UPDATED BACKGROUNDS
0	JUN.19	STAGE 4 ISSUE

TPS.
Taylor Project Services LLP

No.1 Cornhill
London, EC3V 3ND
Tel 020 7743 6602
www.taylorprojectservices.com

SKAGEN
CONSCIENCE CAPITAL

Project
30 PERCY STREET
LONDON

Drawing Title
FIRST FLOOR
WATER SERVICES LAYOUT

Scale 1:50@A1 Date 21.01.19
Drawn D.F. Checked C.M.

Drawing Status
STAGE 4

Revision 0 A

Drawing No. TPS/30PS/1/WS