


GENERAL NOTES

1. REFER TO SCHEMATICS FOR ALL VALVES
2. REFER TO MECHANICAL SCHEDULES
3. SANITARYWARE SPECIFIED BY ARCHITECT. CONTRACTOR TO ALLOW INSTALL ONLY.

LEGEND

- HOT WATER
- COLD WATER
- - - - HIGH LEVEL PIPEWORK
- Q QUOOKER TAP
- W/M - WASHING MACHINE
- D/W - DISHWASHER

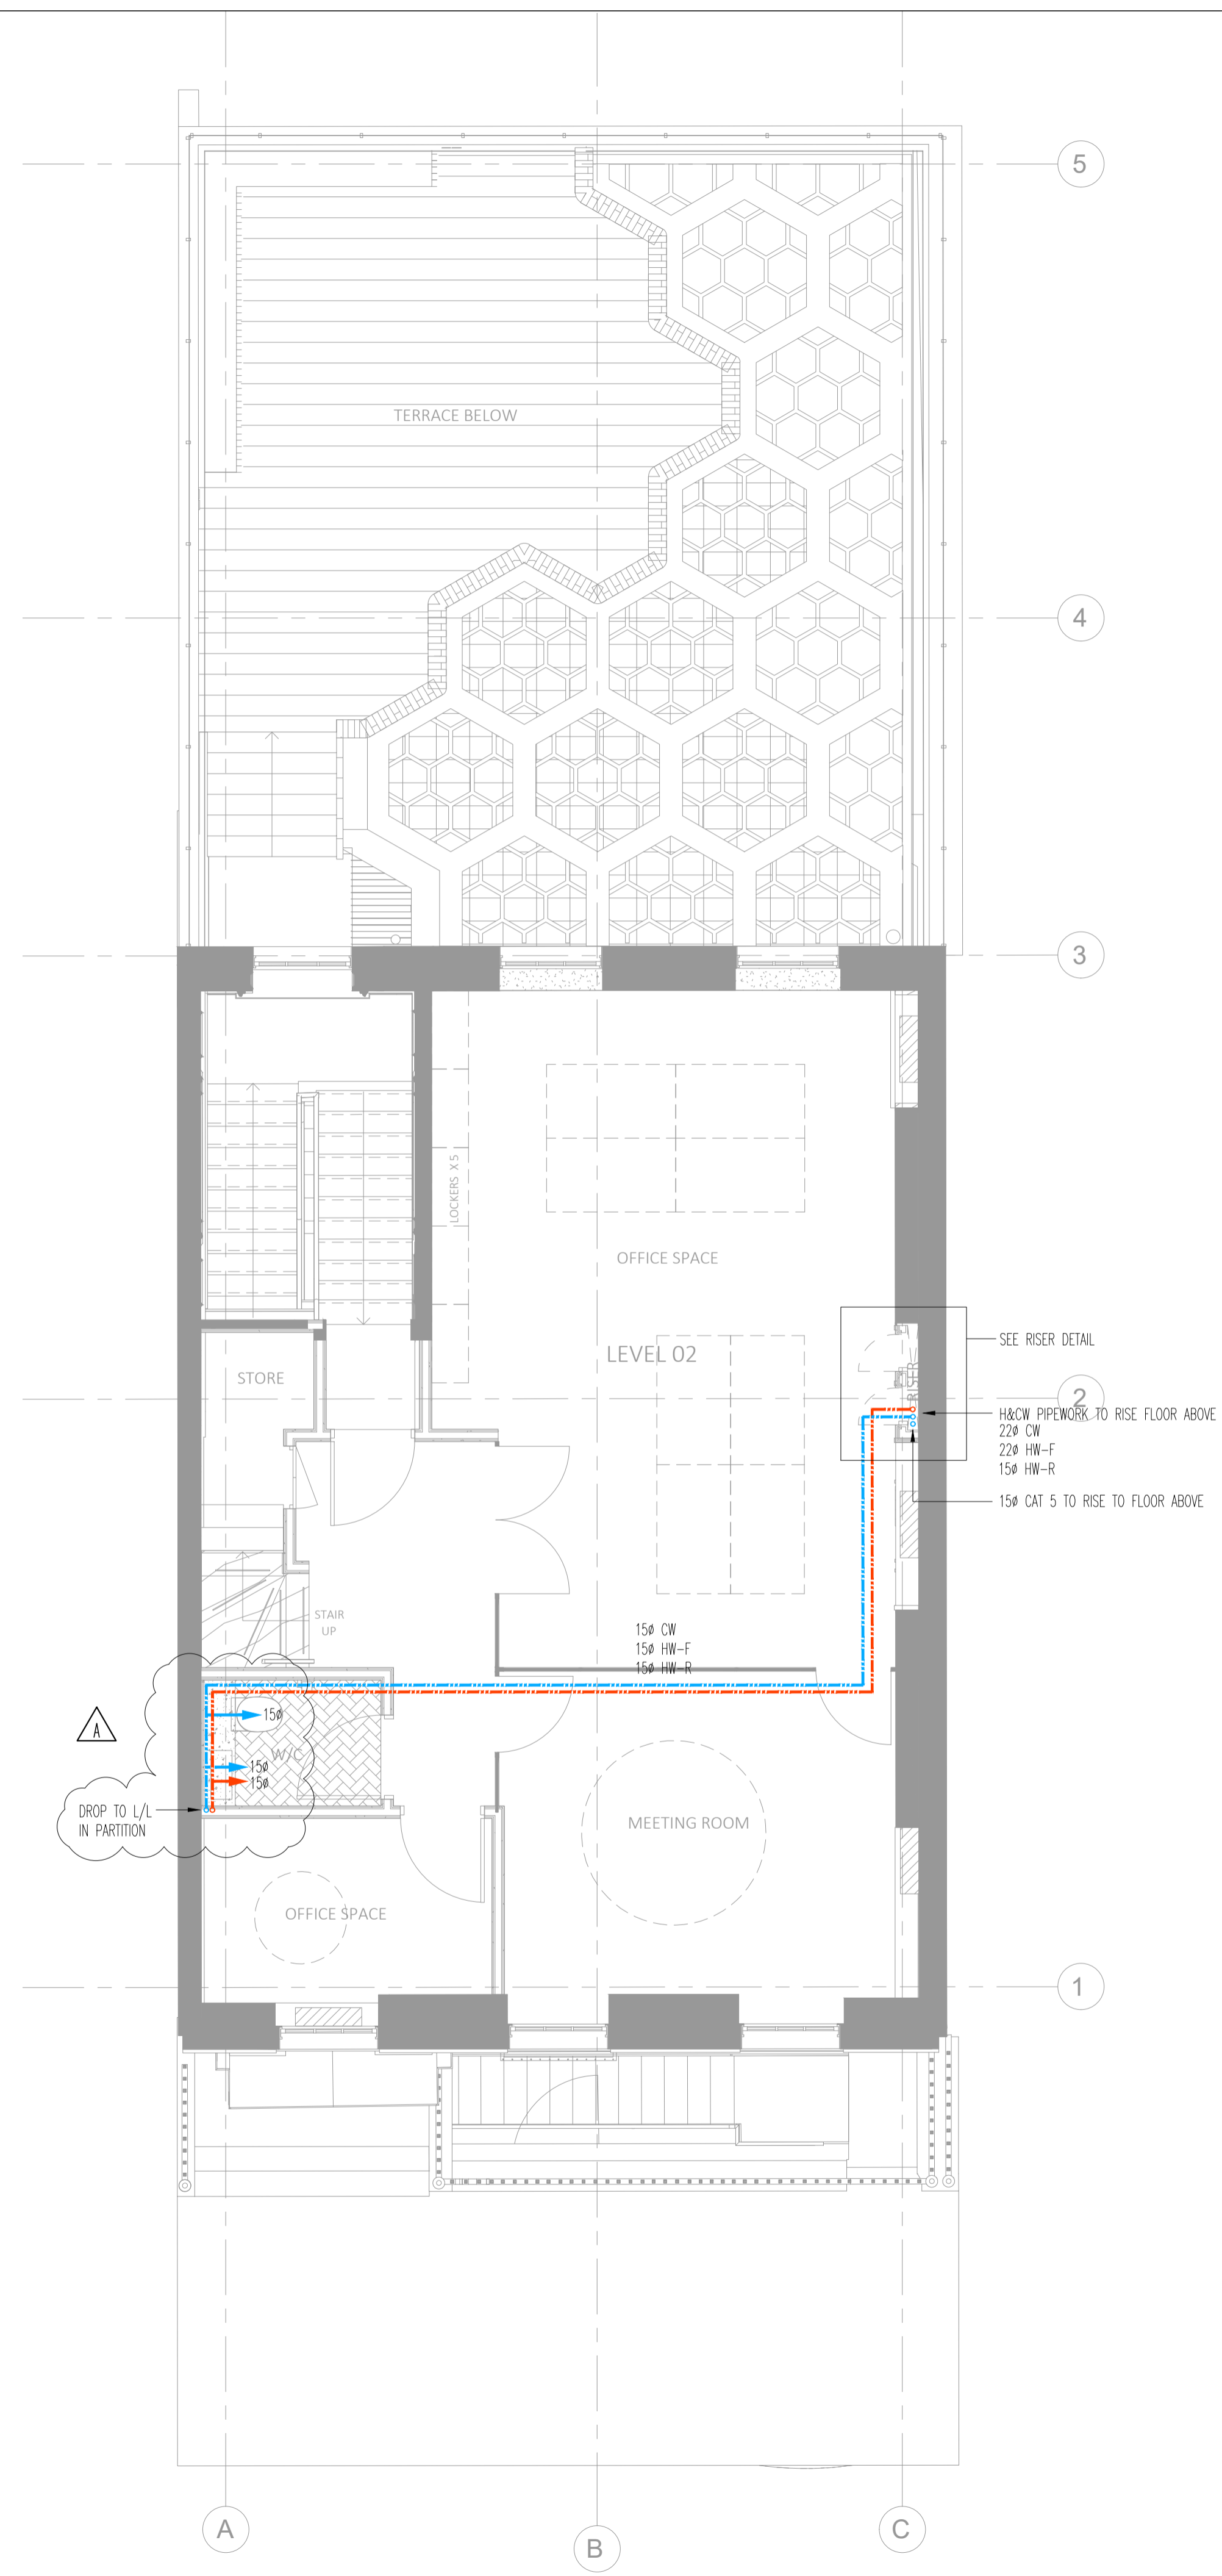

STAGE 4

Rev	Date	Description
A	APR.21	REVISED TO SUIT UPDATED BACKGROUNDS
0	JUN.19	STAGE 4 ISSUE

TPS.
Taylor Project Services LLP
No.1 Cornhill
London, EC3V 3ND
Tel 020 7743 6602
www.taylorprojectservices.com

Client
SKAGEN
CONSCIENCE CAPITAL

Project
30 PERCY STREET
LONDON

Drawing Title
SECOND FLOOR
WATER SERVICES LAYOUT

Scale	1:50@A1	Date	21.01.19
Drawn	D.F.	Checked	C.M.
Drawing Status	STAGE 4		
Revision	0 A		
Drawing No.	TPS/30PS/2/WS		

NO SERVICES SHALL BE RUN ON SURFACE/EXPOSED AND MINI TRUNKING SHALL NOT BE INSTALLED IN ANY ROOM.
ALL SERVICES RUNS TO BE REVIEWED ON SITE FOLLOWING STRIP OUT AND OPENING UP.
NEW SERVICE ROUTES TO BE INSTALLED WITHIN EXISTING BUILDERS WORK & UTILISED WHEREVER POSSIBLE.

