


GENERAL NOTES

- NOTES
1. No. OF DEVICES IS INDICATIVE ONLY
 2. ALL ELECTRICAL WORK SHALL BE CARRIED OUT IN ACCORDANCE WITH THE REQUIREMENTS OF BS767
 3. ALL WORKS TO BE UNDERTAKEN IN ACCORDANCE WITH THE REQUIREMENTS OF BS 5839-1: 2013 FIRE DETECTION & FIRE ALARM SYSTEMS FOR BUILDING
 4. ALL SERVICES ROUTES ARE INDICATIVE ONLY
 5. ALL LAYOUTS SUBJECT TO FINAL DESIGN & CO-ORDINATION
 6. ALL SERVICES TO BE CO-ORDINATED WITH OTHER SERVICES AND STRUCTURE
 7. ALL LAYOUTS SUBJECT TO FINAL DESIGN & CO-ORDINATION
 8. ALL SERVICES TO BE CO-ORDINATED WITH OTHER SERVICES AND STRUCTURE
 9. ALL SETTING OUT OF SERVICES SHALL BE BASED ON SITE MEASUREMENT. BUILDING DIMENSIONS SHOWN MAY DIFFER TO SCALE INDICATED ON THIS DRAWING
 10. ALL LIGHTING CONTROL UNITS TO BE DALI 2 COMPATIBLE.

LEGEND

- M-BUS
- T-BUS
- 3A FUSED DOWN FCU

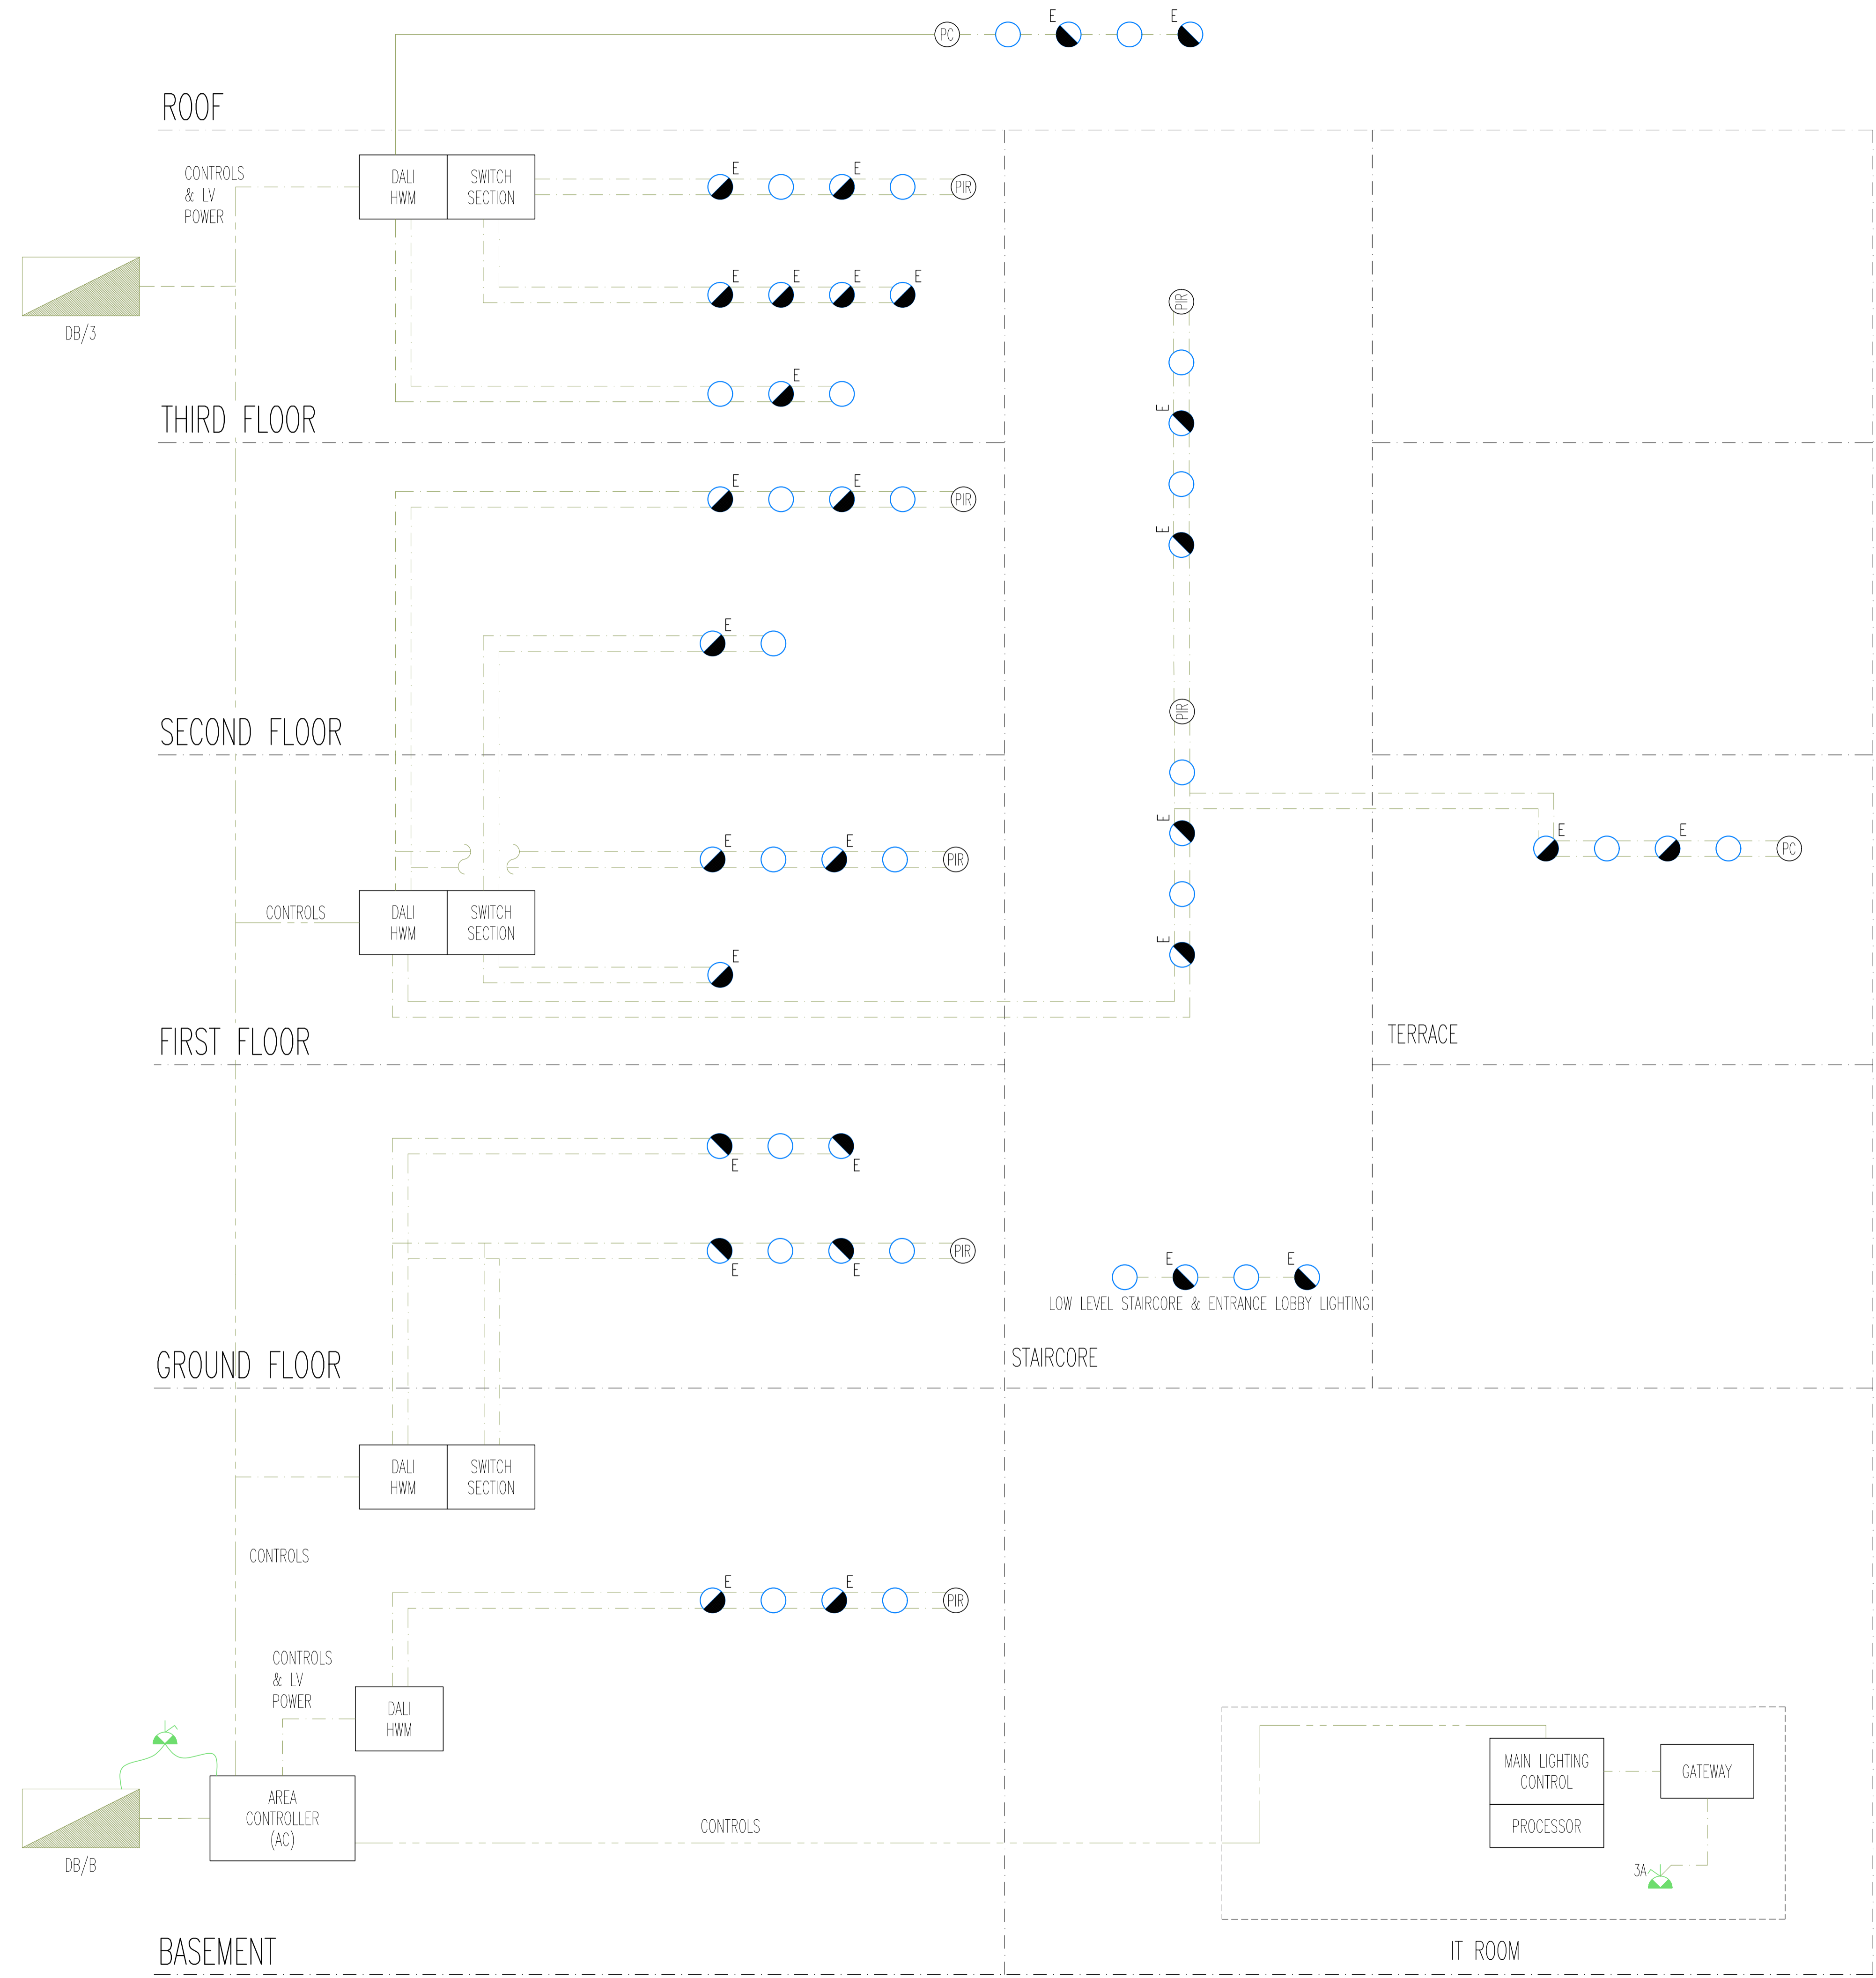

STAGE 4

Rev	Date	Description
B	JUL.21	REVISED WATER PIPEWORK LOCATION
A	APR.21	REVISED TO SUIT UPDATED BACKGROUNDS
0	JUN.19	STAGE 4 ISSUE

TPS.
Taylor Project Services LLP
No.1 Cornhill
London, EC3V 3ND
Tel 020 7743 6602
www.taylorprojectservices.com



Client:
Project:
30 PERCY STREET
LONDON

Drawing Title:
LIGHTING CONTROL
SCHEMATIC

Scale	N.T.S. @ A1	Date	31.01.19
Drawn	T.S.	Checked	C.M.
Drawing Status	STAGE 4		
Revision	0	A	B
Drawing No.	TPS/30PS/LCS		

NO SERVICES SHALL BE RUN ON SURFACE/EXPOSED AND MINI TRUNKING SHALL NOT BE INSTALLED IN ANY ROOM.
ALL SERVICES RUNS TO BE REVIEWED ON SITE FOLLOWING STRIP OUT AND OPENING UP.
NEW SERVICE ROUTES TO BE INSTALLED WITHIN EXISTING BUILDERS WORK & UTILISED WHEREVER POSSIBLE.