


NOTES:
The drawing contains information from more than one source and must be read in conjunction with all relevant specifications

THIS DRAWING MUST NOT BE SCALED. ALL SETTING CUT MUST BE CHECKED ON SITE. ALL DIMENSIONS MUST BE CHECKED ON SITE. THIS DRAWING MUST BE READ IN CONJUNCTION WITH THE RELEVANT SPECIFICATION CLAUSES. THIS DRAWING MUST NOT BE USED FOR LAND TRANSFER PURPOSE

COPYRIGHT © LEECH GROUP'S SERVICES, LEECH MECHANICAL SERVICES & POSITIVE FACILITIES MAINTENANCE

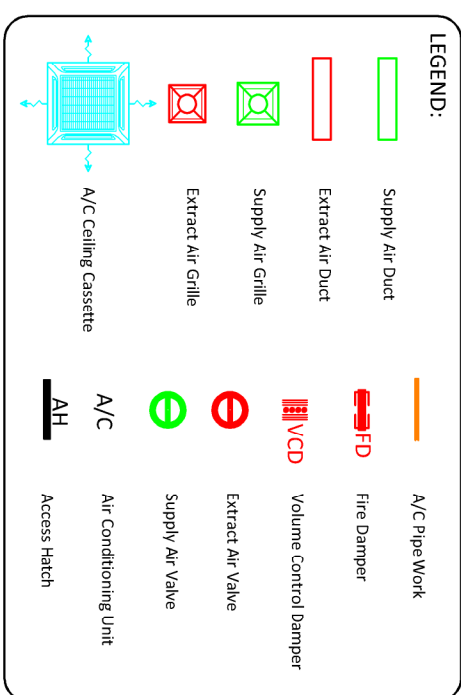


LEECH
GROUP SERVICES
Unit 17, Meplesden Works, Maldon
Road, Latchingdon, Essex, CM3 6LG
Tel: +44 (0)1621 742424.
Email: help@leechgroupservices.co.uk
www.leechgroupservices.co.uk

Rev	Rev by	Description	Date
H.			
G.			
F.			
E.			
D.			
C.			
B.			
A.	.	.	.

Deliveroo
Swiss Cottage
Finchley Road, London
NW3 6HY

TITLE: HVAC Layout UVO retrofit


PRODUCT NUMBER:	P00000027
DATE:	01/02/2019
DRAWN BY:	MS
CHECKED BY:	RR
DRAWING NO:	P0000027/001 Rev 0
SCALE	1:50@ A1:1:100@A3

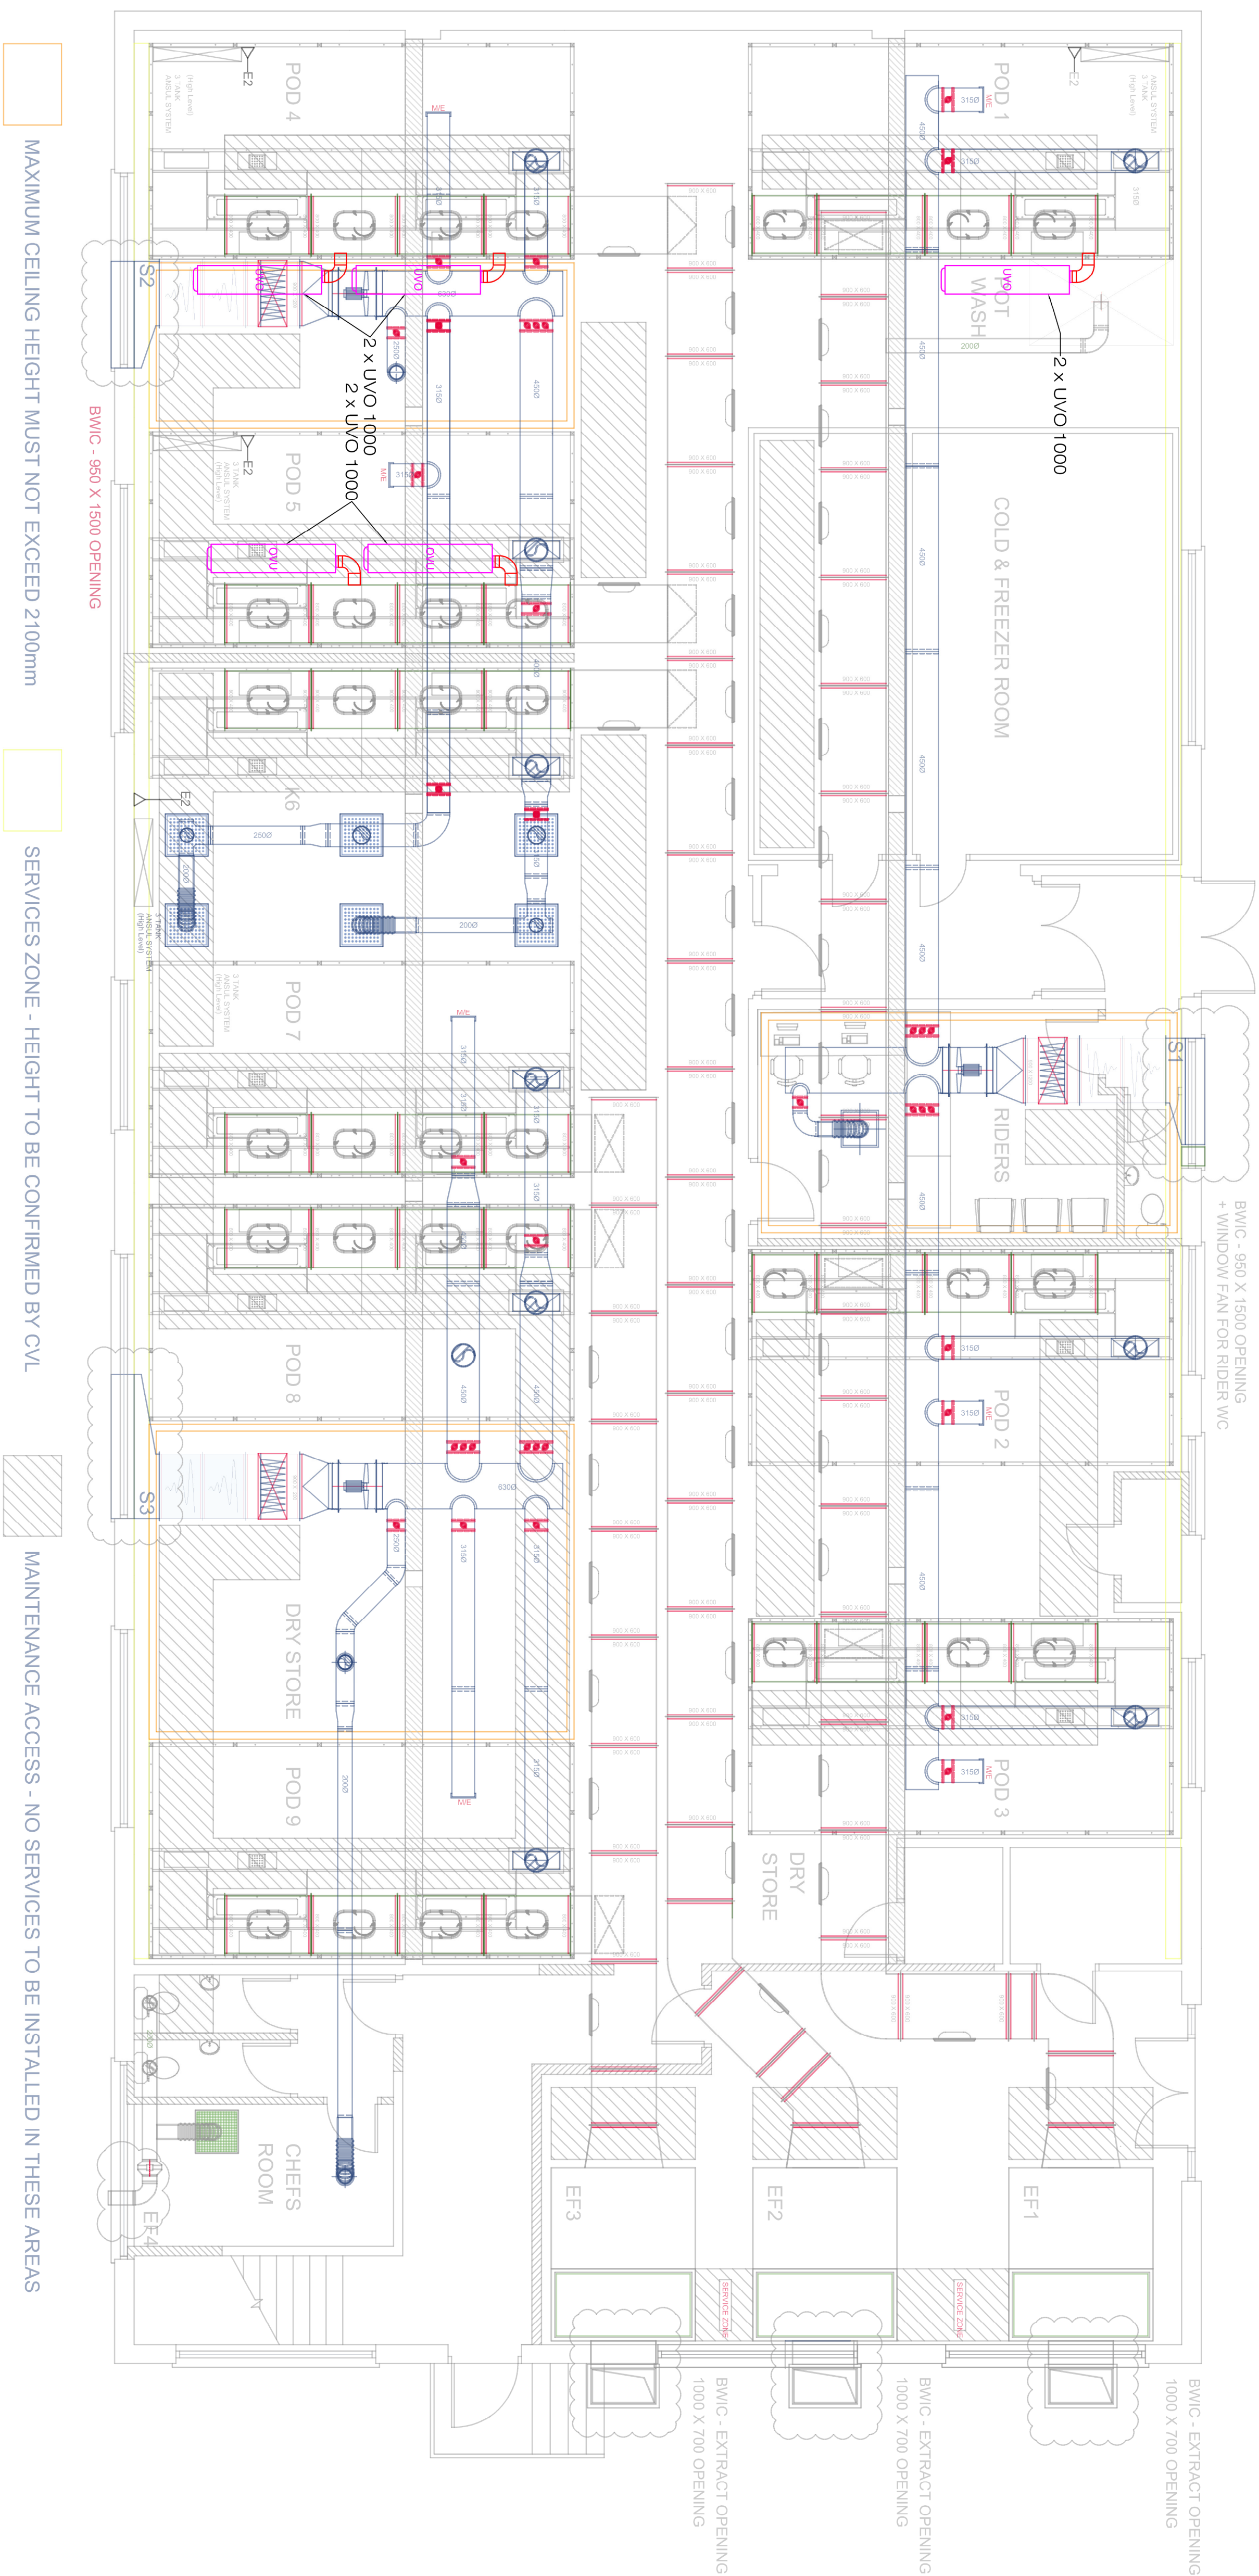

LF DWG REFERENCE	2011-07-04D2OPTION 7	REV	NA	EXTRACT DUCTWORK	800 X 400 = 43.15M 900 X 400 = 87.30M	SUPPLY VDUCTWORK	6300 = 6.7M 4500 = 24.3M
CATVING REFERENCE	Not reviewed - 110707	REV			2000 SPTRA - 4.5M		3150 = 35.3M 1200 = 1.5M

NOTE: Existing kitchen extract duct to be removed by others

NOTE: Existing kitchen extract duct to be removed by others

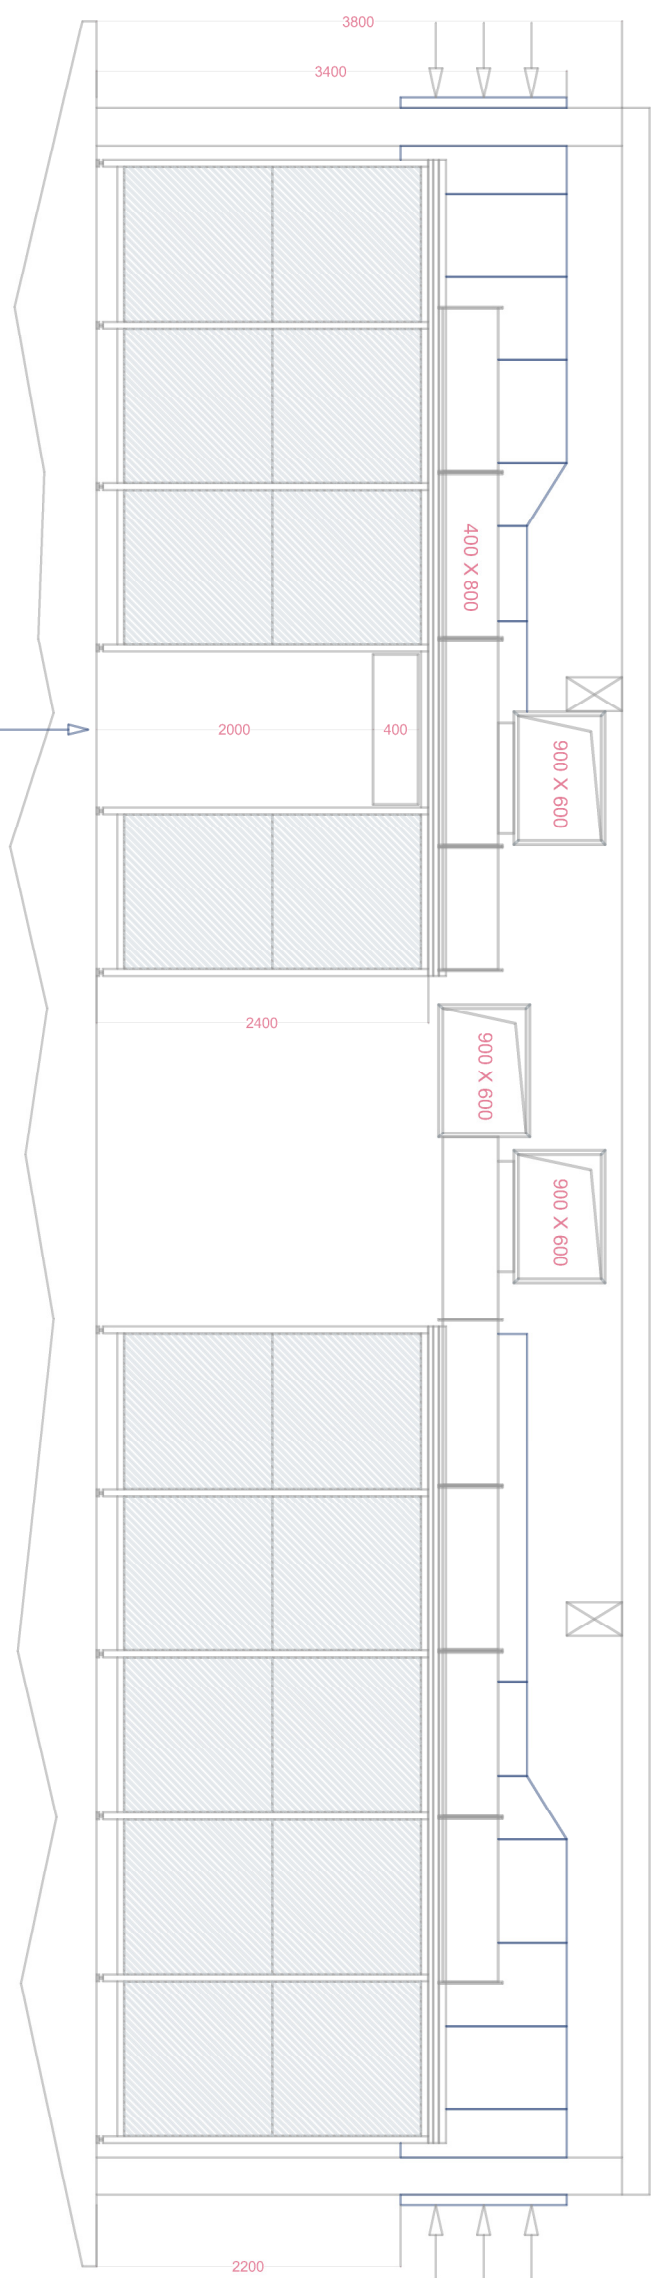

NOTE: CUTOUT TO SHOW CANDY ONLY - FOR VISUAL PURPOSES ONLY