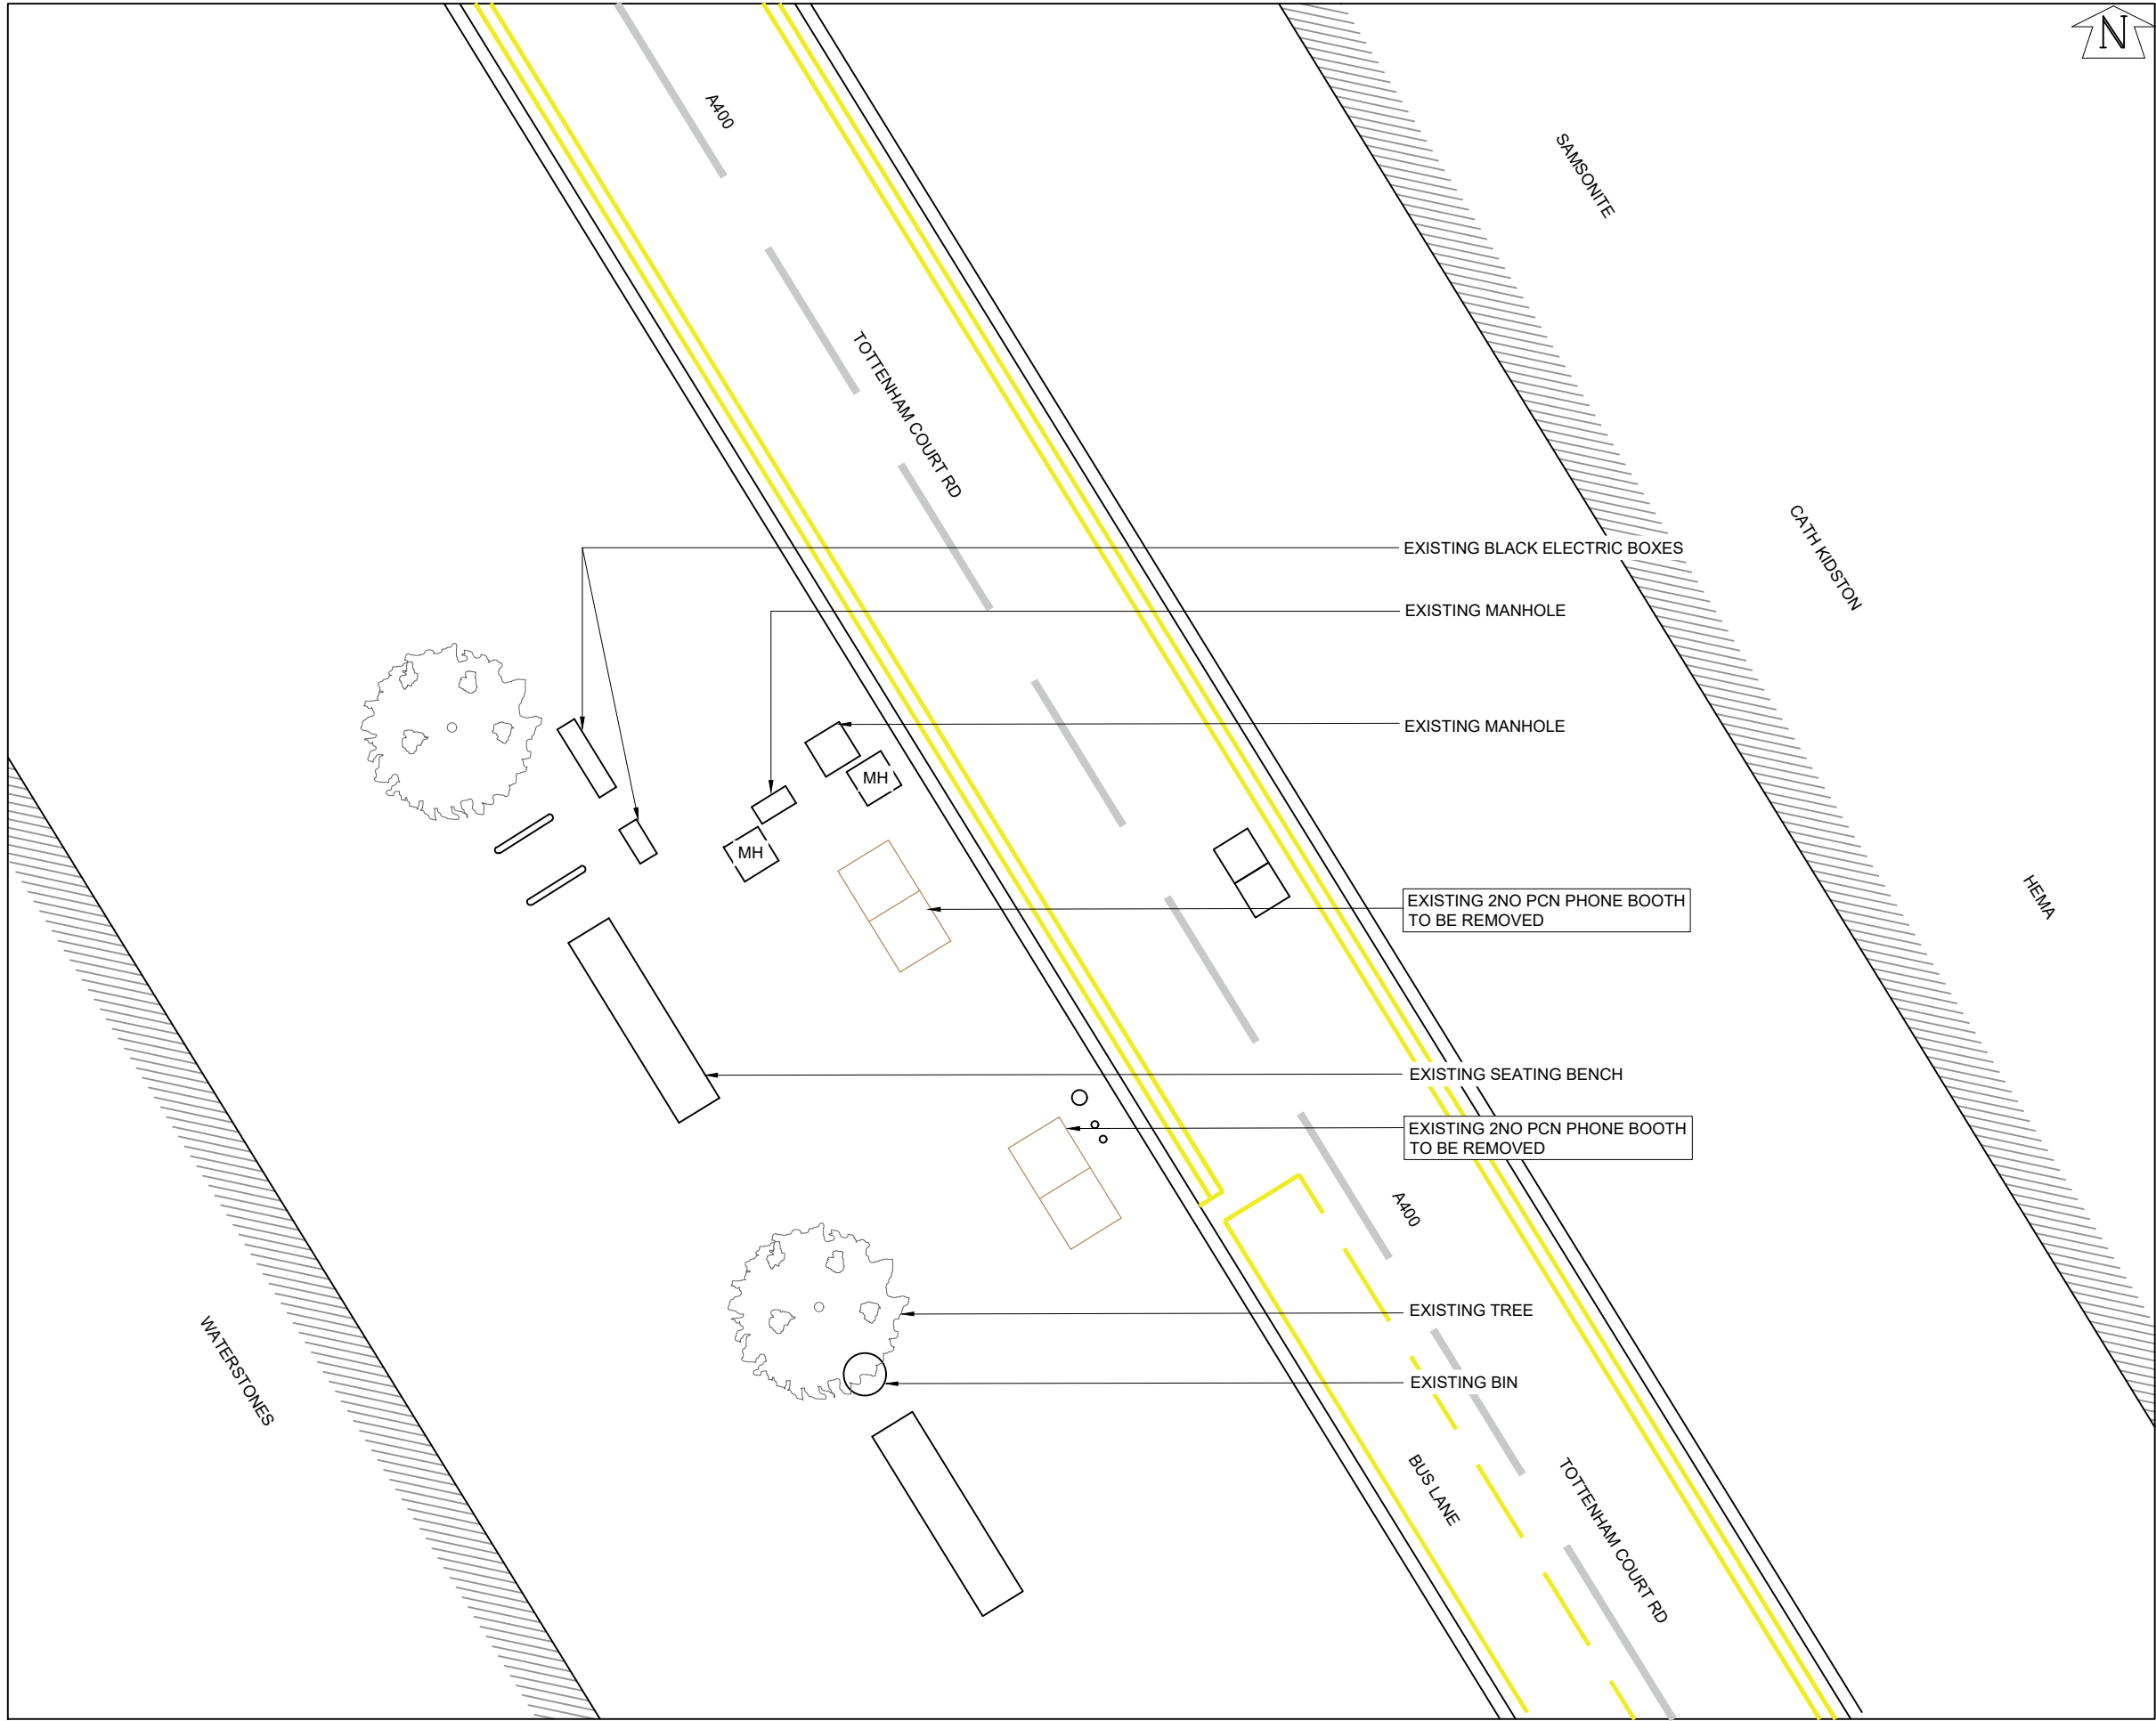


EXISTING SITE PLAN
SCALE 1:100

GENERAL NOTES

Use written dimensions only, do not scale from drawing. Use latest revision of all referenced information.

A	20.09.21	Amend - New BT Streethub Structure	MD	JE
Rev	Date	Description	Drawn	Chkd

MONO CONSULTANTS LIMITED
70-76 Steam Packet House
Cross Street
Manchester, M2 4JG
t. 44 (0)161 839 8839
www.monoconsultants.com

Drg Status
PLANNING

Cell No. & Name
1-CAM001

Site Name & Address
**Pavement o/s Waterstones, 19-21
Tottenham Court Rd, London
W1T 1BJ**

Drawing Title
EXISTING SITE PLAN

Scale	1:100	Date	20.09.2021
Drawn By	MD	Checked By	JE
Drawing Number	002	Revision	A