

In addition to the hazards/risks normally associated with the types of work detailed on this drawing, note the following:


ASBESTOS - REVIEW REFURBISHMENT AND DEMOLITION SURVEY FOR THE EXISTING BUILDING BEFORE WORK CAN COMMENCE IN THESE AREAS.

ASBESTOS - REVIEW REFURBISHMENT AND DEMOLITION SURVEY FOR THE EXISTING BUILDING BEFORE WORK CAN COMMENCE IN THESE AREAS.

ASBESTOS - REVIEW REFURBISHMENT AND DEMOLITION SURVEY FOR THE EXISTING BUILDING BEFORE WORK CAN COMMENCE IN THESE AREAS.

It is assumed that all works will be carried out by a competent contractor working, where appropriate, to an approved method statement

1. REFER TO DRAWING 5206133-ATK-ZA-SB-DR-E-3026 FOR NOTATION.

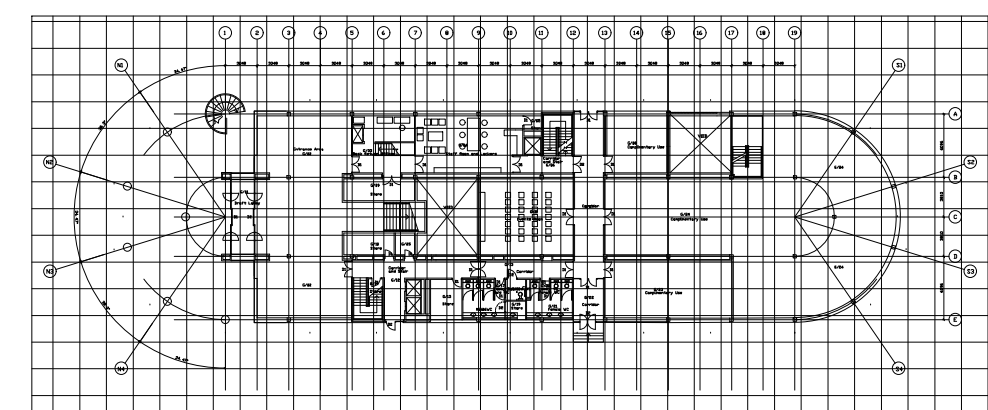

P1	17/08/2021	ISSUED FOR TENDER	GS	KR	TC
Rev.	Date	Description	By	Chkd	App

Drawing Status	Suitability
FIT FOR TENDER	D2

SNC ATKINS LOGO.PNG

500 Park Avenue
Aztec West
Almondsbury
BRISTOL
BS32 4RZ
T: +44 (0)1454 662000
F: +44 (0)1454 663333
www.atkinsglobal.com
© SNC-Lavalin (2021)

Client

\\.\.\OneDrive Corp\OneDrive - Atkins Ltd\Documents\CAMDENPING

Drawing Title

GROUND FLOOR FLOOR
LIGHTING LAYOUT
OPTION B

Scale NTS	Designed AS	Drawn GS	Checked KR	Authorised TG
Original Size A0	Date 07/06/2021	Date 07/06/2021	Date 07/06/2021	Date 07/06/2021
Drawing Number 5206133-ATK-ZA-GF-DR-E-3028				Revision P1

Internal Project Number: 5206133

