
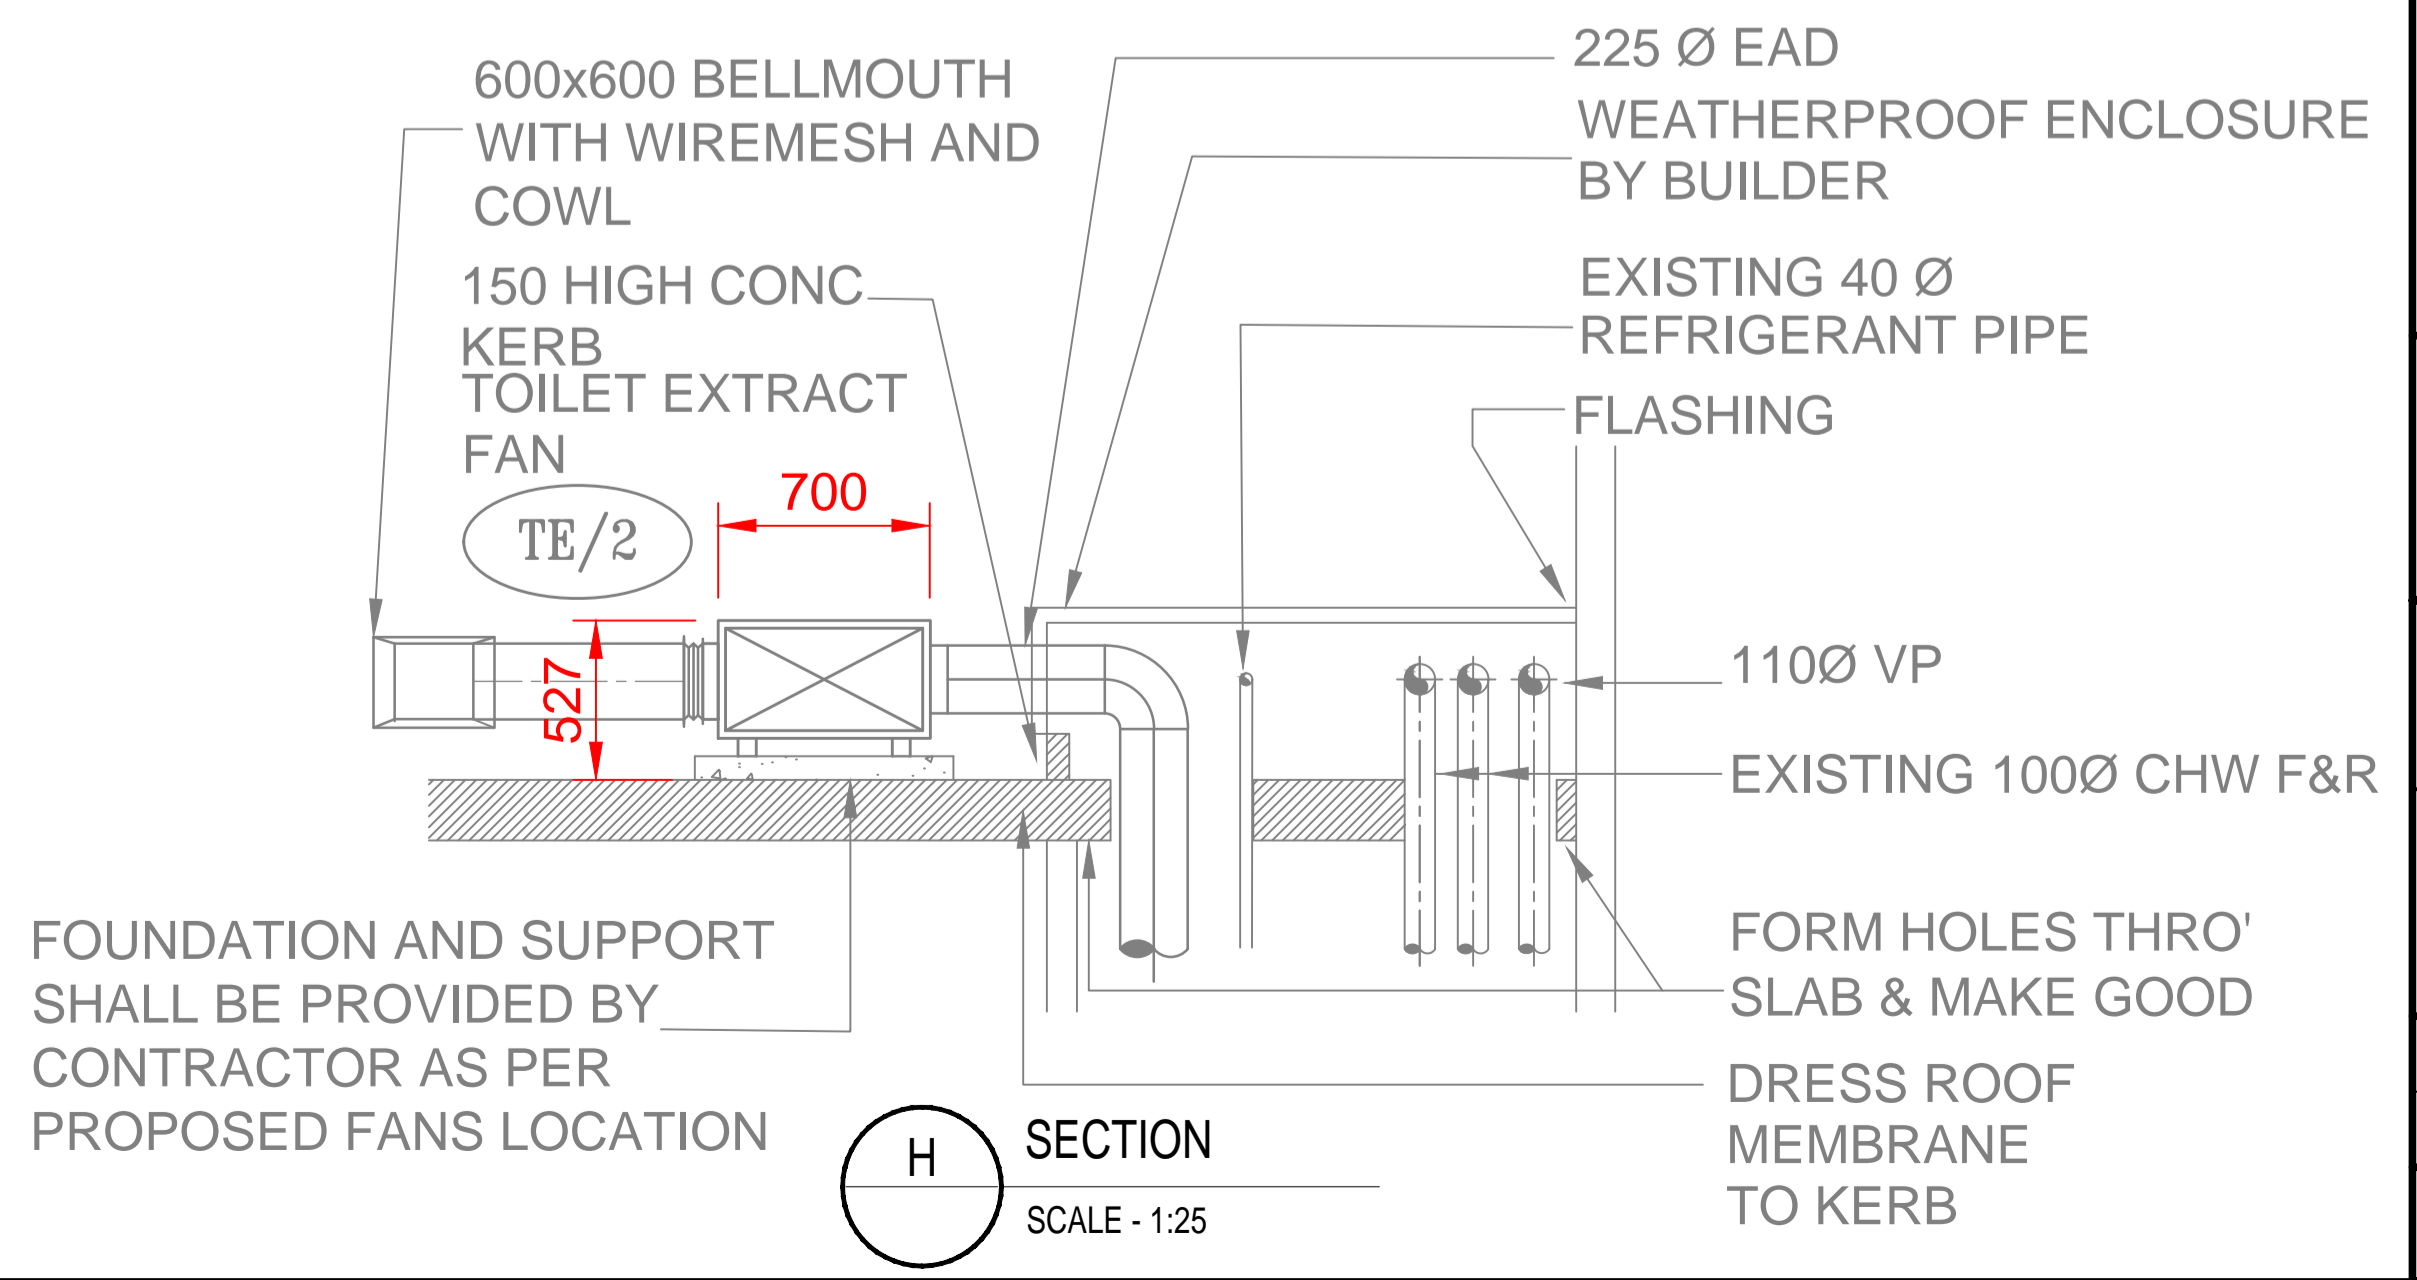
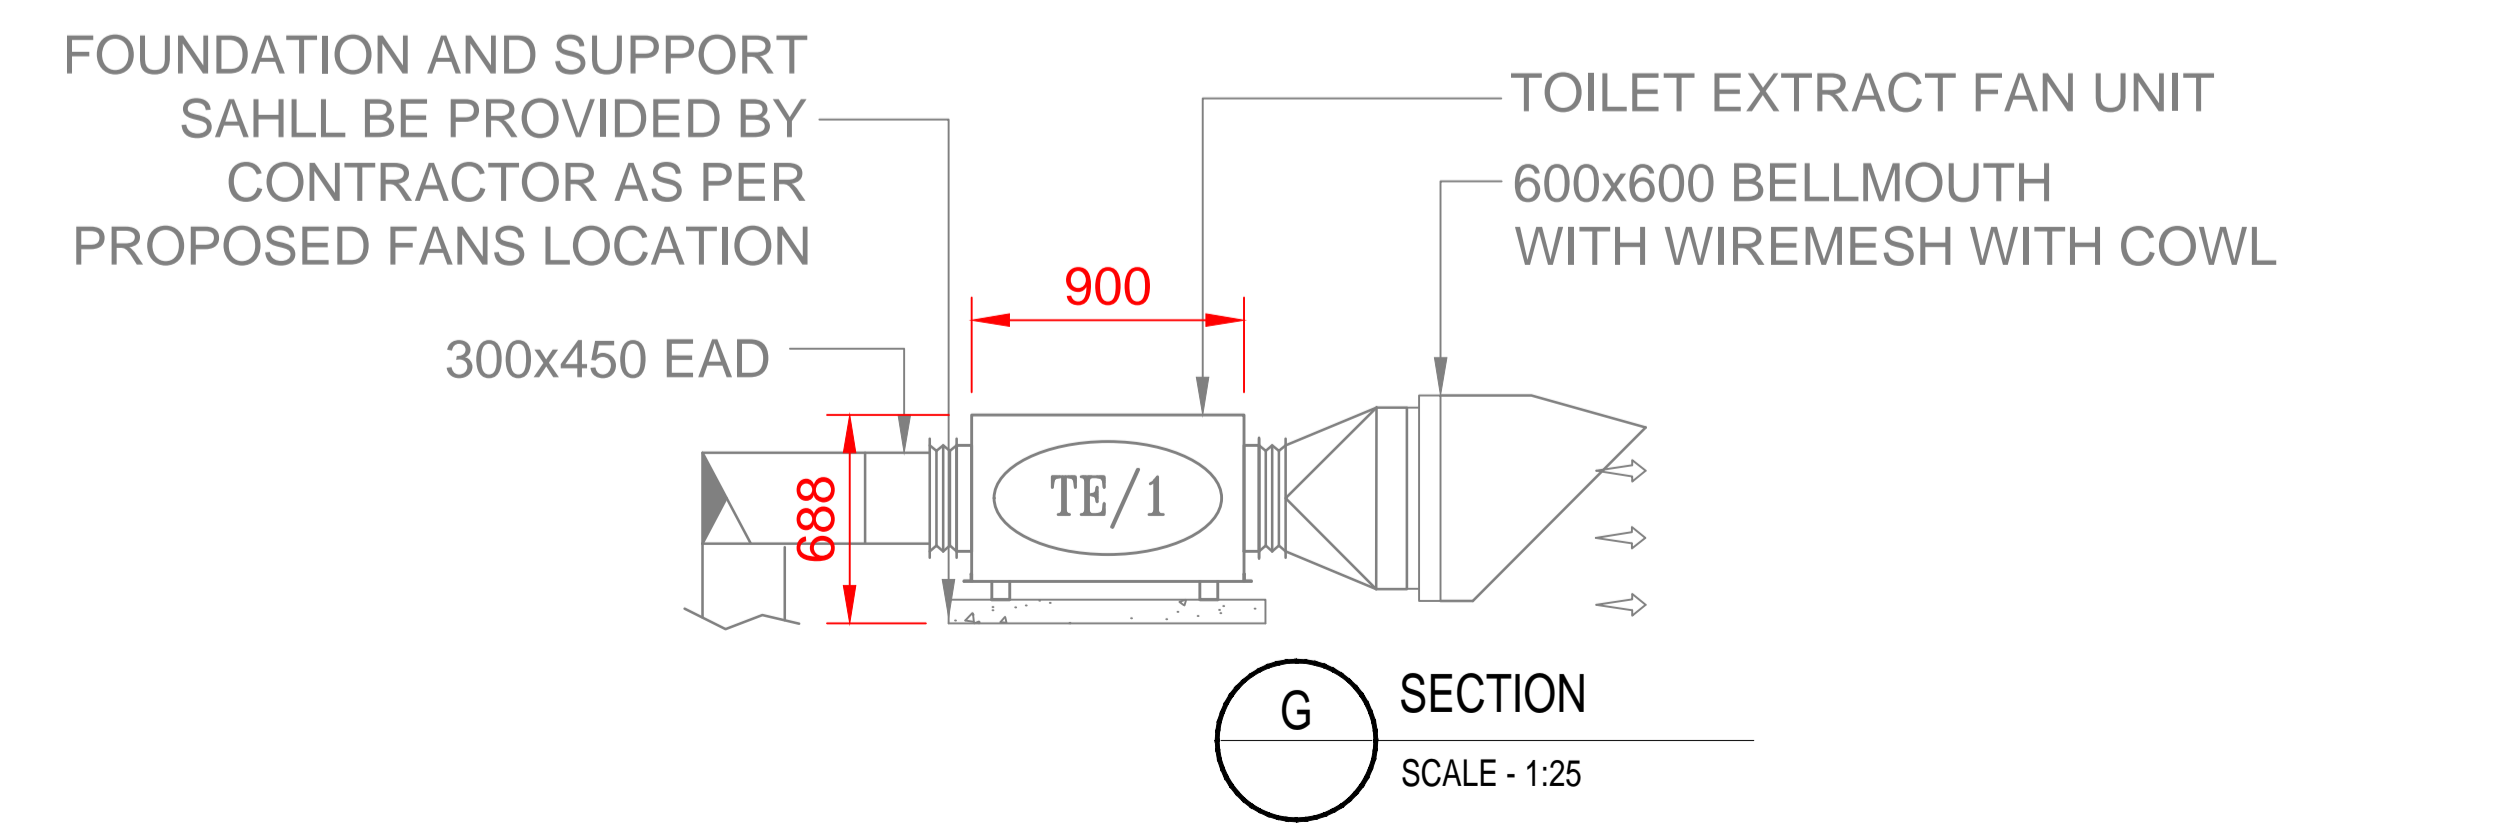
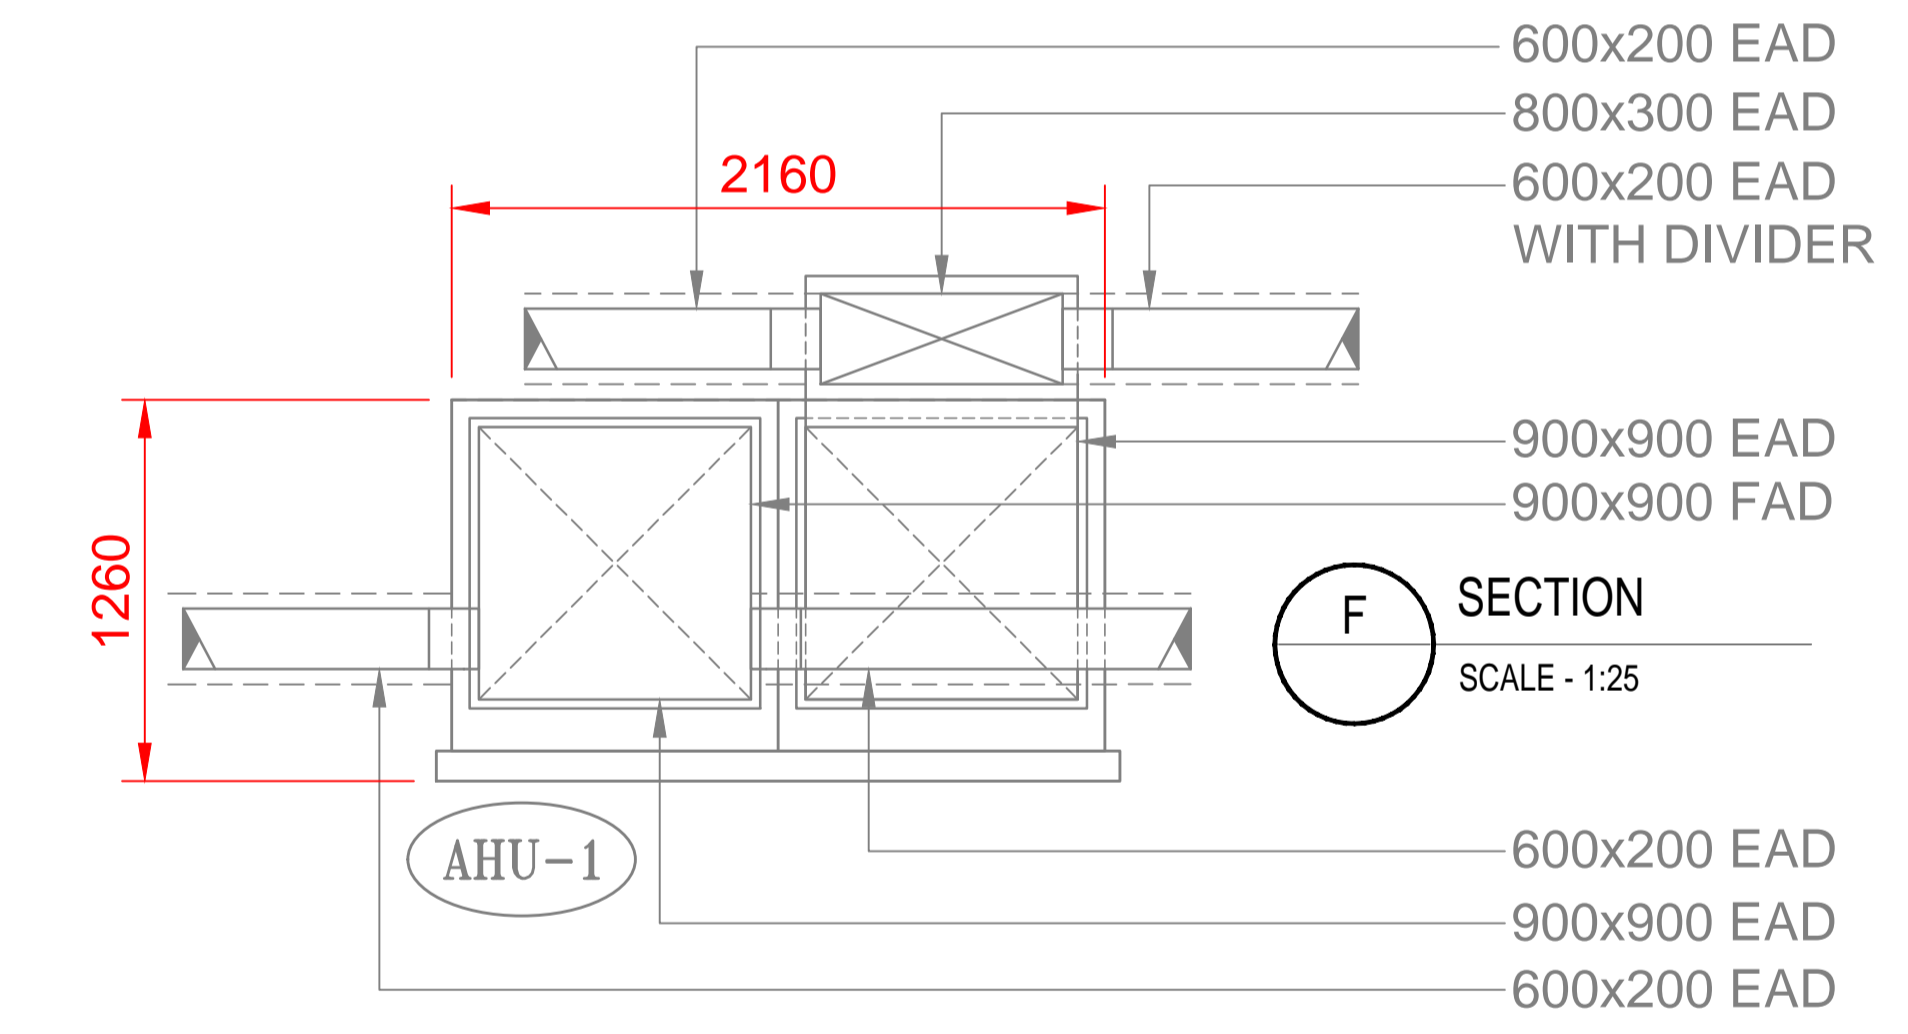
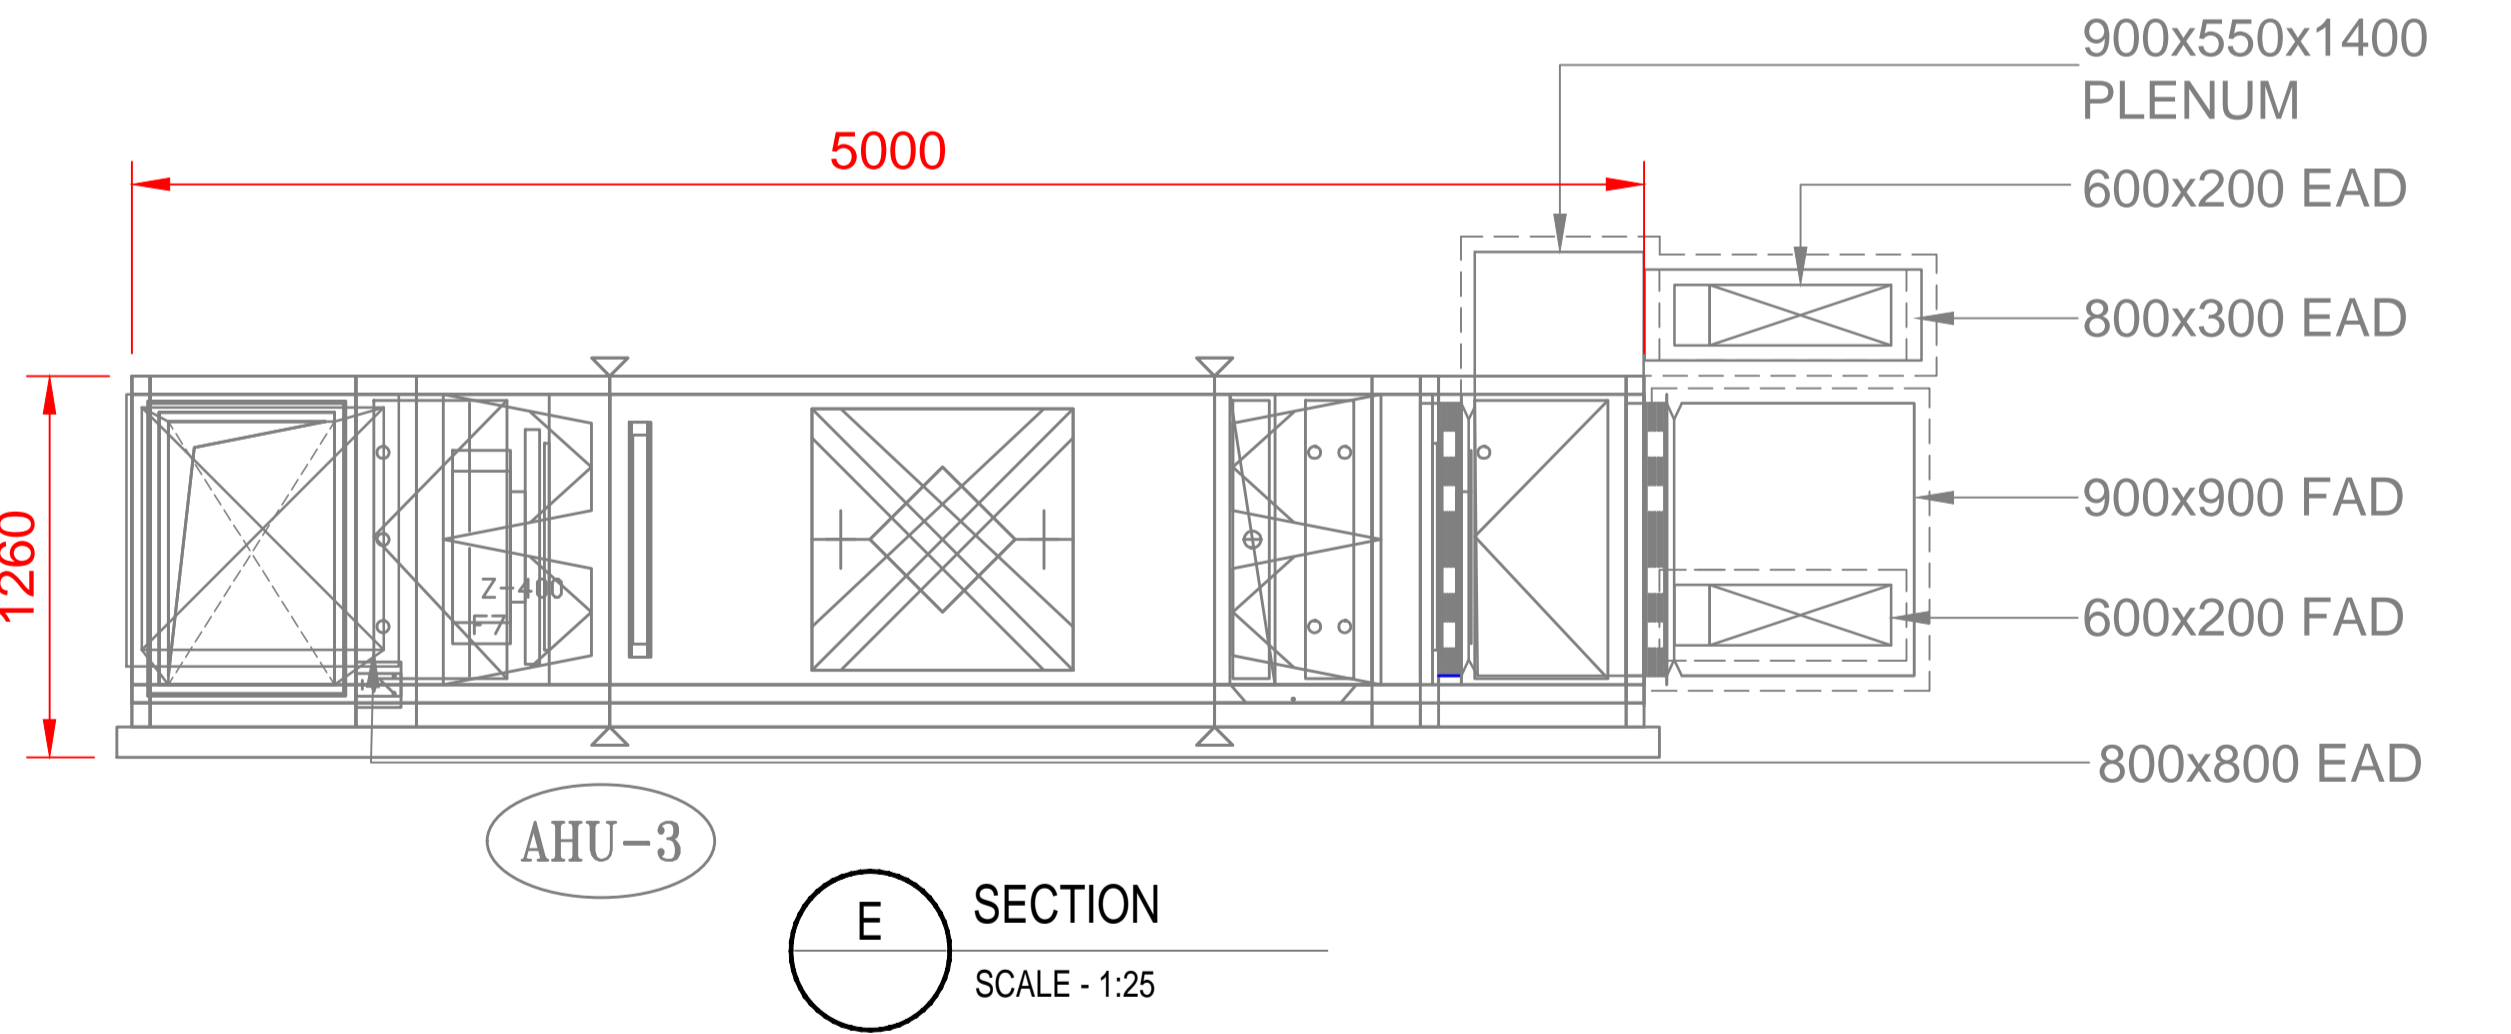
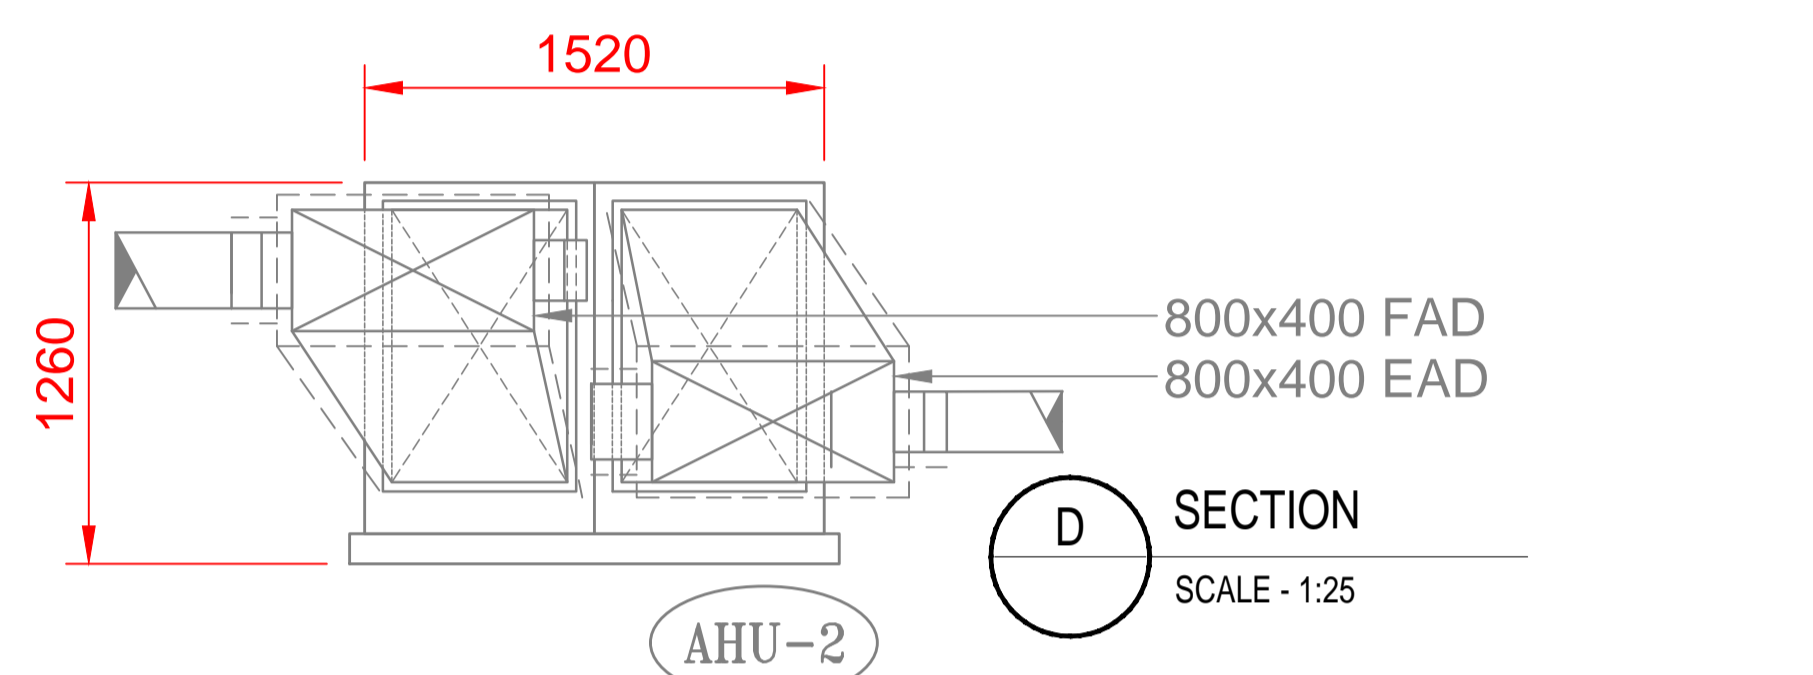
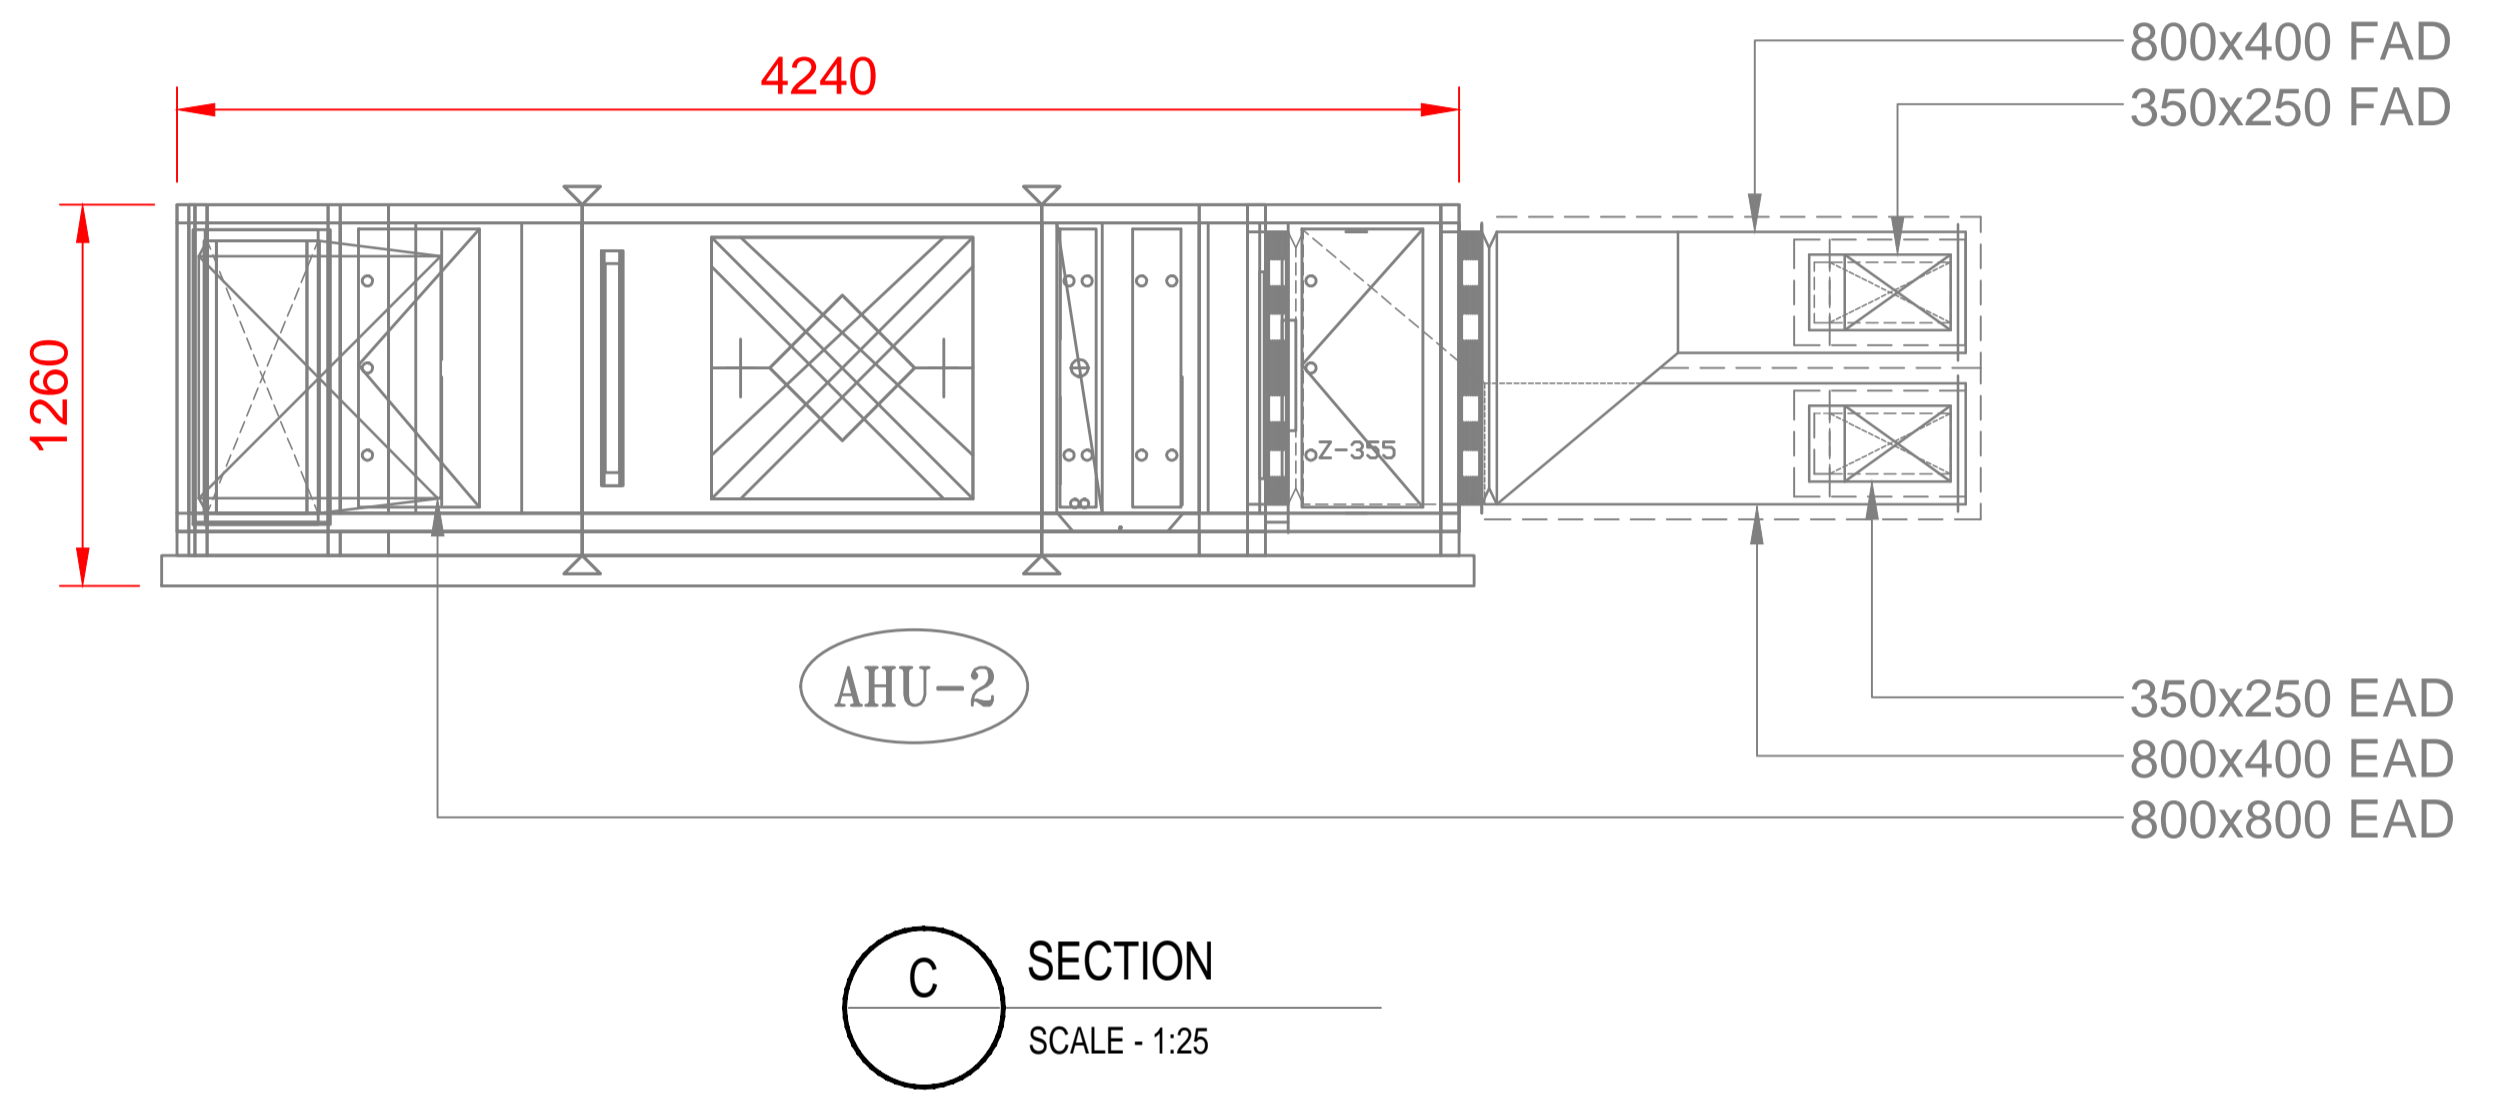
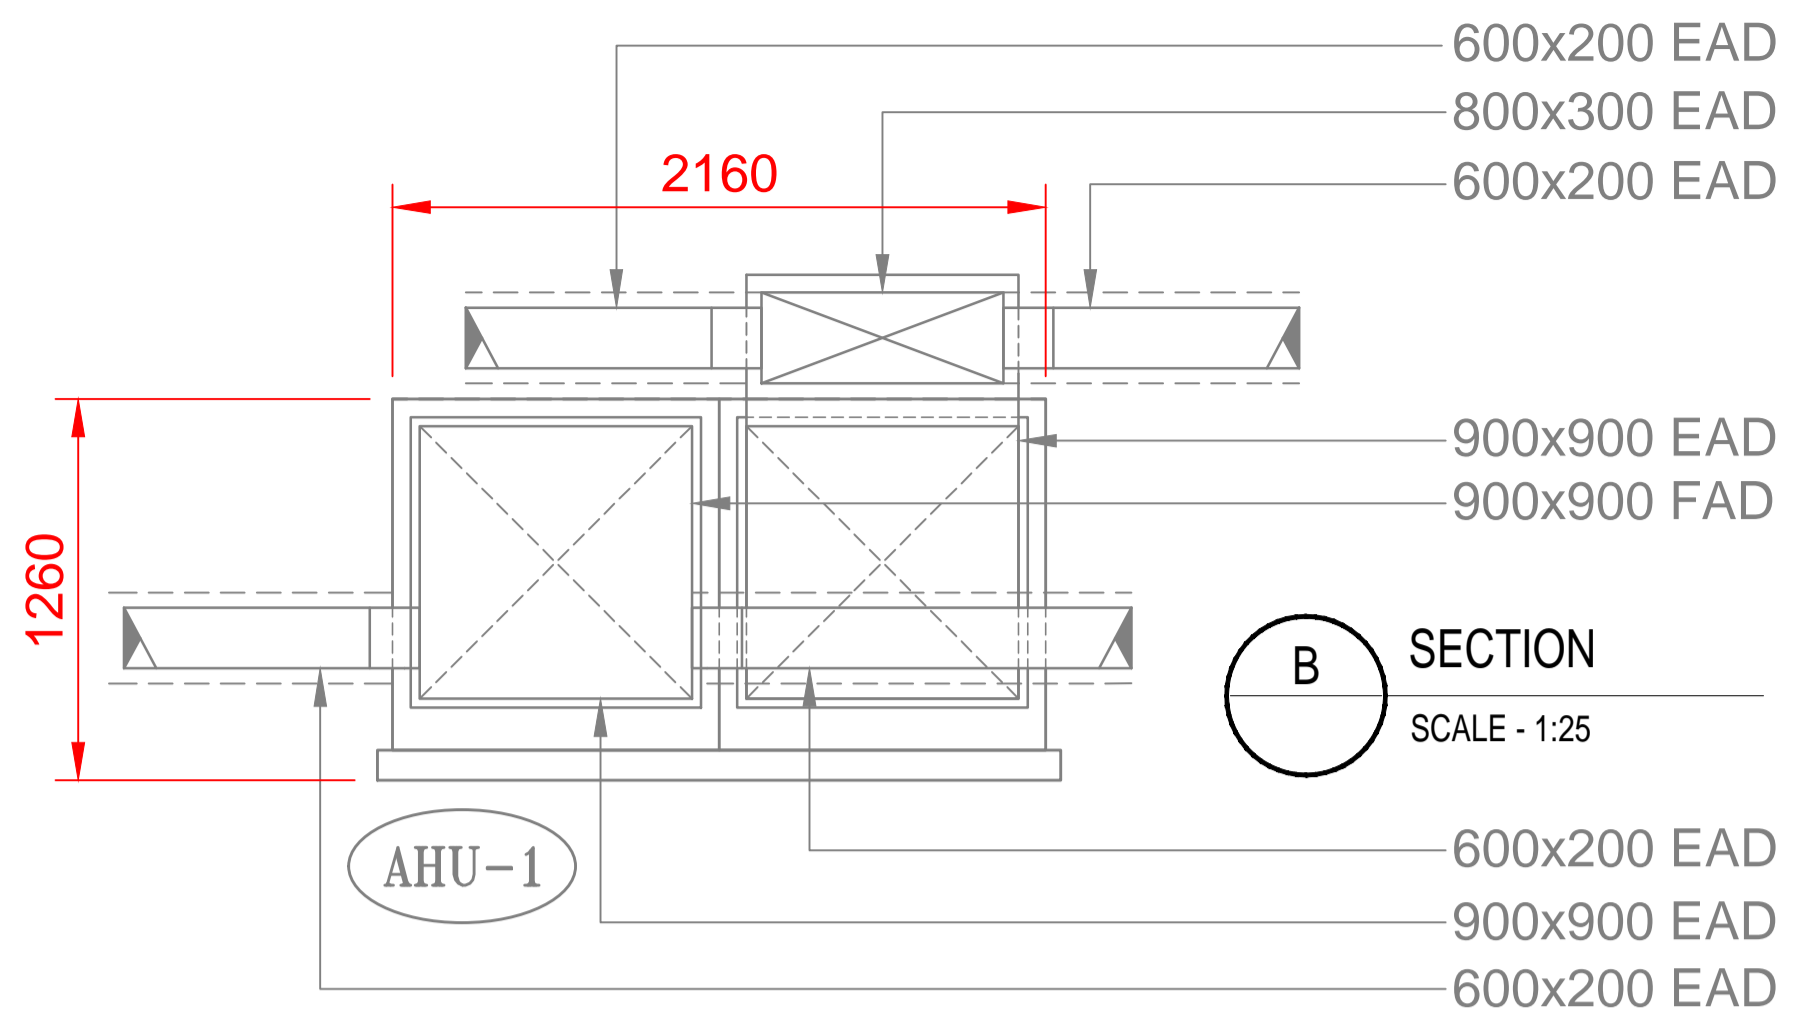


100
0 10
Millimetres

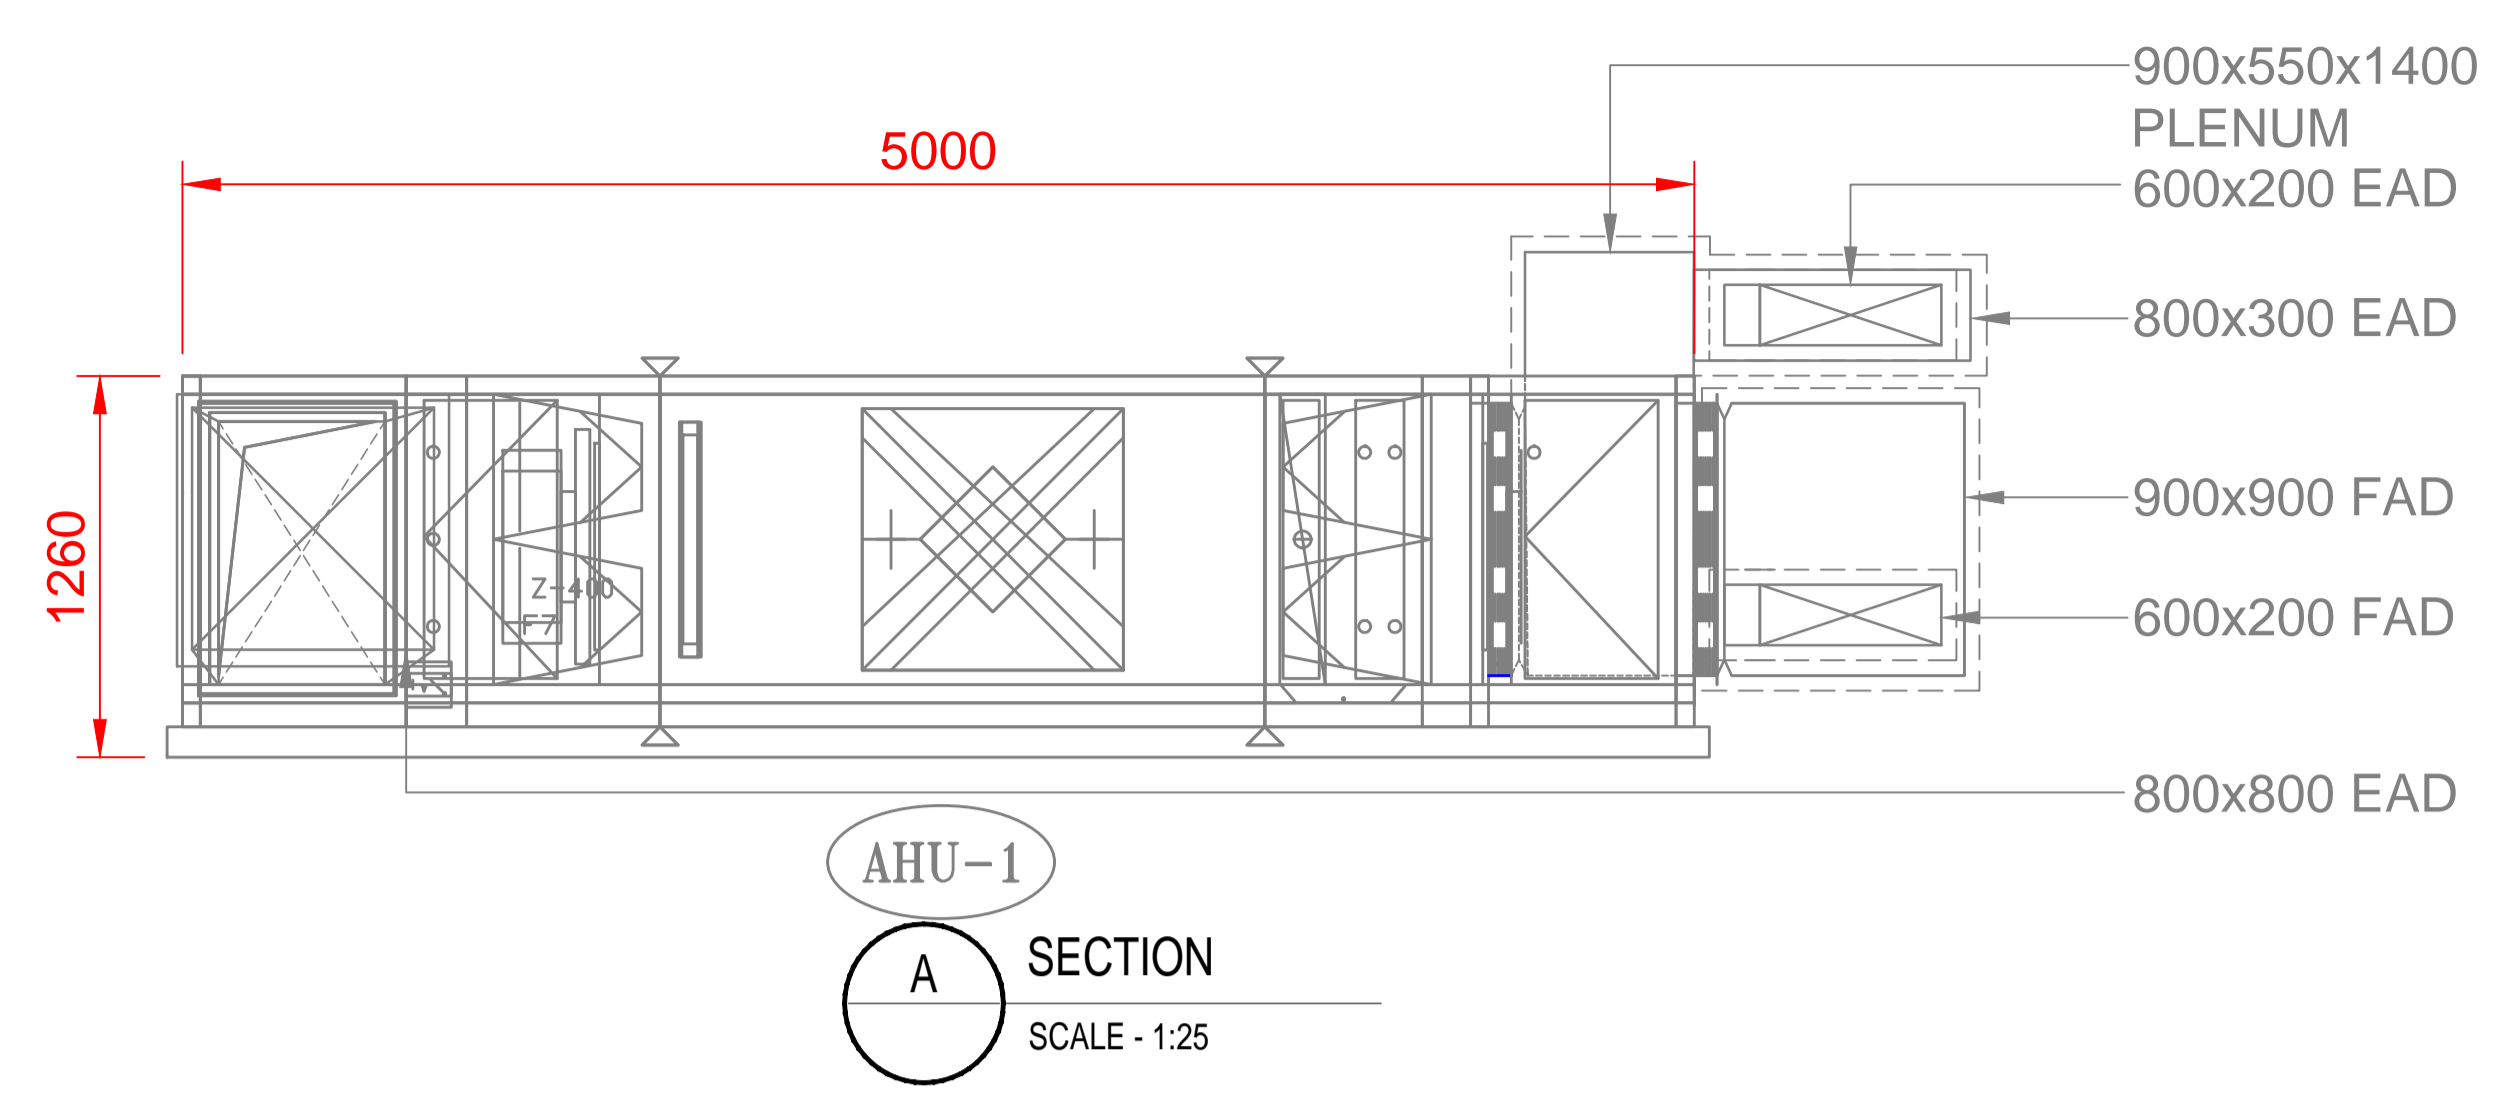

SAFETY, HEALTH AND ENVIRONMENTAL INFORMATION

In addition to the hazards/risks normally associated with the types of work detailed on this drawing, note the following:

CONSTRUCTION

ASBESTOS - REVIEW REFURBISHMENT AND DEMOLITION SURVEY FOR THE EXISTING BUILDING BEFORE WORK CAN COMMENCE IN THESE AREAS.

MAINTENANCE/CLEANING

ASBESTOS - REVIEW REFURBISHMENT AND DEMOLITION SURVEY FOR THE EXISTING BUILDING BEFORE WORK CAN COMMENCE IN THESE AREAS.

DECOMMISSIONING/DEMOLITION

ASBESTOS - REVIEW REFURBISHMENT AND DEMOLITION SURVEY FOR THE EXISTING BUILDING BEFORE WORK CAN COMMENCE IN THESE AREAS.

It is assumed that all works will be carried out by a competent contractor working, where appropriate, to an approved method statement

NOTES

1. ALL DIMENSIONS ARE IN MILLIMETRES UNLESS OTHERWISE SPECIFIED.
2. THIS DRAWING TO BE READ IN CONJUNCTION WITH THE SCHEDULE OF WORK AND ALL RELEVANT ARCHITECTURAL, ELECTRICAL AND MECHANICAL DRAWINGS.
3. MECHANICAL CONTRACTOR TO WEATHERPROOF DUCTWORK TO VERTICAL SCREEN WALL.
4. ALL EQUIPMENTS TO BE FIXED AND APPLIED IN ACCORDANCE WITH MANUFACTURERS CURRENT WRITTEN SPECIFICATION AND INSTRUCTIONS FOR USE.
5. ALL DUCTWORK AND FITTINGS TO BE MANUFACTURED IN ACCORDANCE WITH DW144.
6. ALL MATERIALS TO BE COMPLY WITH THE BUILDINGS STANDARDS REGULATIONS TECHNICAL STANDARDS.
7. SYSTEM SHALL BE SET TO WORK AND COMMISSIONED
8. LOW ASPECT RATION DUCTWORK TO BE FITTED WITH DIVIDER

Rev.	Date	Description	By	Chk'd	App'd
P1	28/09/2021	ISSUED FOR PLANNING	LJH	GN/SL/ML	ML

Drawing Status	Suitability
FOR INFORMATION	S0

SNC-LAVALIN
500 Park Avenue
Aztec West
Almondsbury
BRISTOL
BS32 4RZ
T: +44 (0)1454 662000
F: +44 (0)1454 663333
www.atkinsglobal.com
© SNC-Lavalin (2021)

ATKINS
Member of the SNC-Lavalin Group

Client

Camden

Project Title
SWISS COTTAGE LIBRARY - LZC SALIX WORKS

Drawing Title
ROOF LEVEL MECHANICAL PLANT SECTIONAL DETAILS FOR PLANNING

Scale	Designed	Drawn	Checked	Authorised
AS INDICATED	SL	LJH	GN/SL/ML	ML
Original Size	Date	Date	Date	Date
A1	06/08/21	28/09/21	29/09/21	29/09/21

Drawing Number	Revision
5206133-ATK-Z1-R-DR-M-1117	P1

Internal Project Number: 5206133