

100  
0 10  
Millimetres

DO NOT SCALE

**SAFETY, HEALTH AND ENVIRONMENTAL INFORMATION**

In addition to the hazards/risks normally associated with the types of work detailed on this drawing, note the following:

**CONSTRUCTION**

ASBESTOS - REVIEW REFURBISHMENT AND DEMOLITION SURVEY FOR THE EXISTING BUILDING BEFORE WORK CAN COMMENCE IN THESE AREAS.

**MAINTENANCE/CLEANING**

ASBESTOS - REVIEW REFURBISHMENT AND DEMOLITION SURVEY FOR THE EXISTING BUILDING BEFORE WORK CAN COMMENCE IN THESE AREAS.

**DECOMMISSIONING/DEMOLITION**


ASBESTOS - REVIEW REFURBISHMENT AND DEMOLITION SURVEY FOR THE EXISTING BUILDING BEFORE WORK CAN COMMENCE IN THESE AREAS.

It is assumed that all works will be carried out by a competent contractor working, where appropriate, to an approved method statement


**NOTES**

- REFER TO DRAWING 5206133-ATK-ZA-SB-DR-E-3026 FOR NOTATION.

- THIS DRAWING SHALL BE READ IN CONJUNCTION WITH ALL RELEVANT ARCHITECTS & STRUCTURAL ENGINEERS DRAWINGS.
- REFER TO DRAWING No. H3450/E/001 FOR ELECTRICAL SERVICES LEGEND AND MOUNTING HEIGHTS.
- CIRCUIT TO BE CONTACTOR CONTROLLED SEE DRAWING H3450/E/006
- ELECTRICAL CONTRACTOR SHALL ALLOW FOR RENEWAL OF BESPOKE OPAL DIFFUSERS AND REPLACEMENT OF EXISTING CONTROL GEAR WITH NEW H.F. CONTROL GEAR SUITABLE FOR 2 x 35 WATT LAMP UNITS (4 No.) PER ROW. LAMP COLOUR TEMPERATURE TO BE 'DAYLIGHT' 6500 'K' AS PHILIPS COLOUR 865.
- PIR CONTROLLER TO LUMINAIRE TO HAVE A 20 MINUTE TIME DELAY BEFORE SWITCHING OFF.

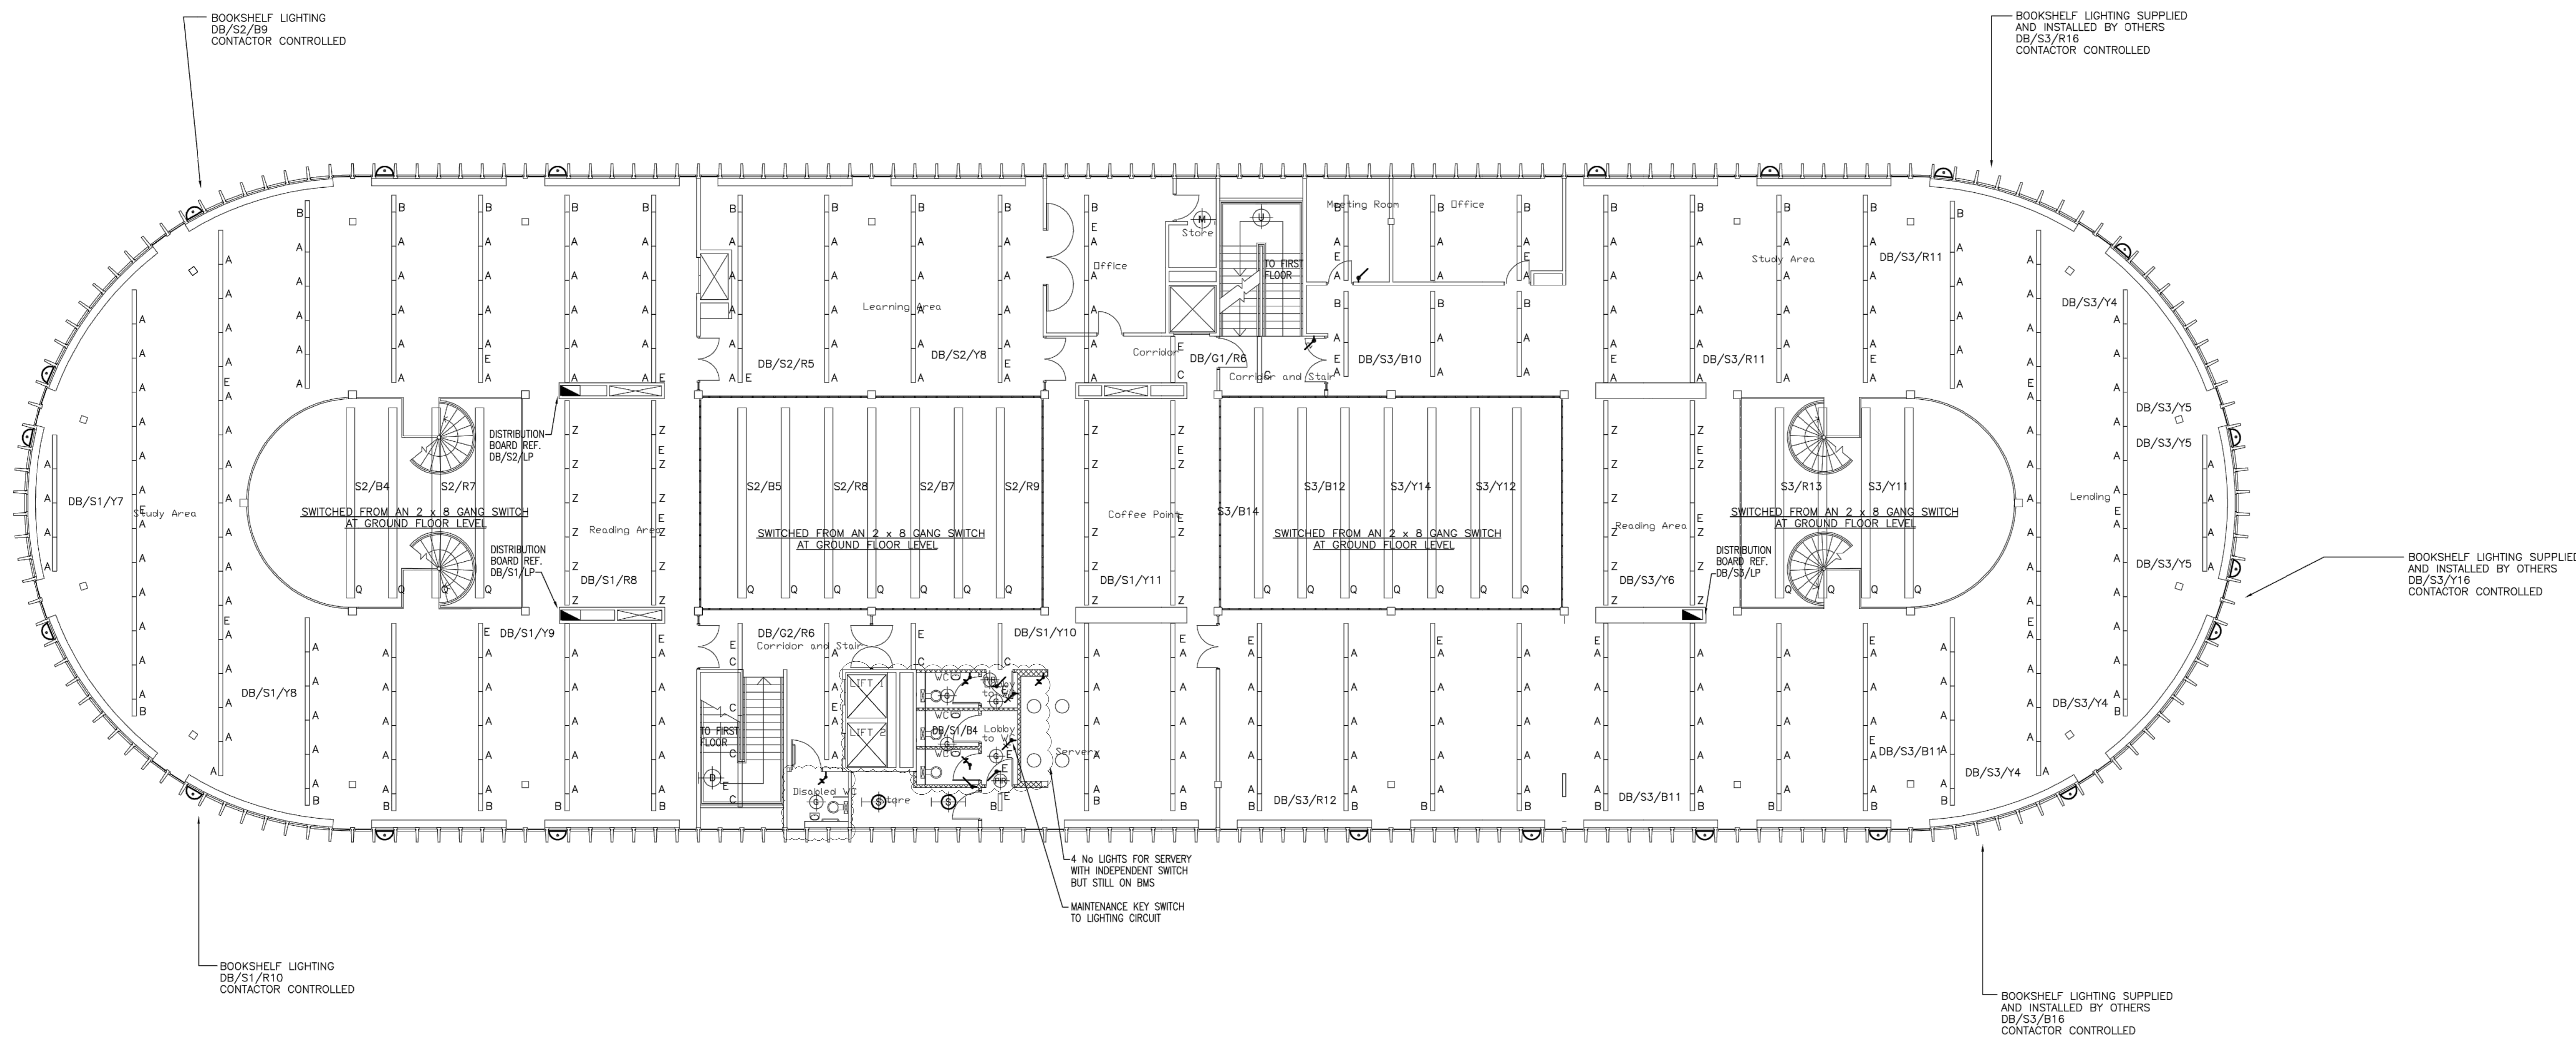

**Key Plan**

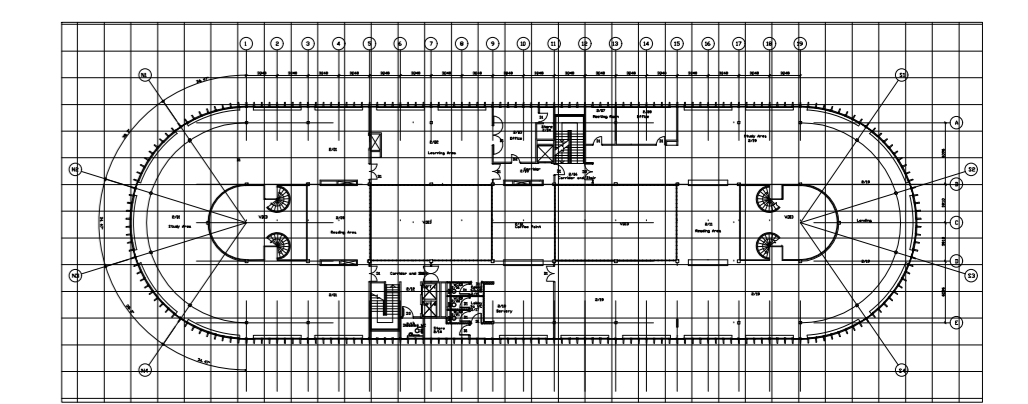


Rev.	Date	Description	By	Chkd	Appd
P1	17/08/2021	ISSUED FOR TENDER	AS	KR	TG

Drawing Status: **FIT FOR TENDER** Suitability: **D2**

**SNC-LAVALIN**  
Member of the SNC-Lavalin Group

**ATKINS**

500 Park Avenue  
Aztec West  
Almondsbury  
BRISTOL  
BS32 4RZ  
T: +44 (0)1454 662000  
F: +44 (0)1454 663333  
www.atkinsglobal.com  
© SNC-Lavalin (2021)

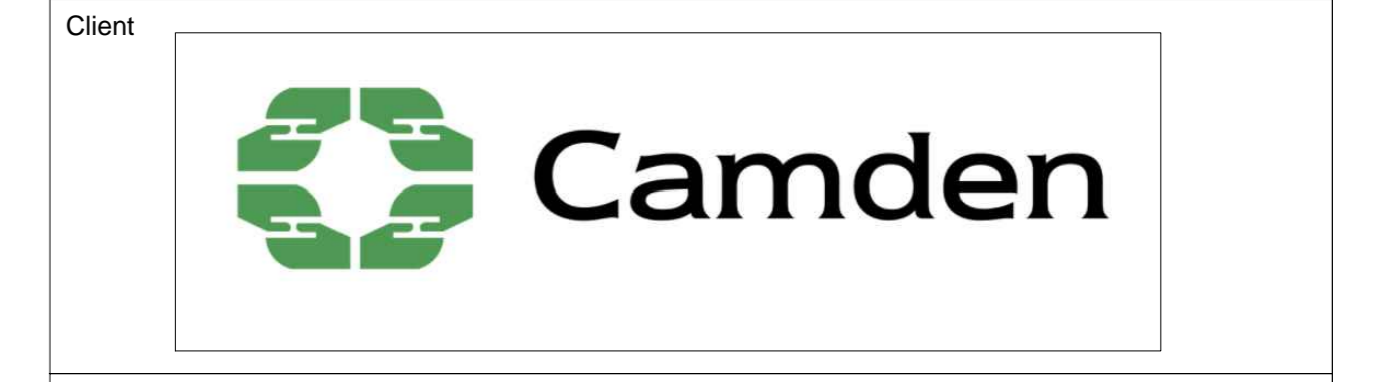

Project Title: **SWISS COTTAGE LIBRARY**

Drawing Title: **SECOND FLOOR LIGHTING LAYOUT OPTION B**

Scale	Designed	Drawn	Checked	Authorised
NTS	AS	GS	KR	TG
Original Size	Date	Date	Date	Date
A0	07/06/2021	07/06/2021	07/06/2021	07/06/2021
Drawing Number	Revision			
5206133-ATK-ZA-SF-DR-E-3030				P1