


ALL DIMENSIONS TO BE  
CONFIRMED ON SITE

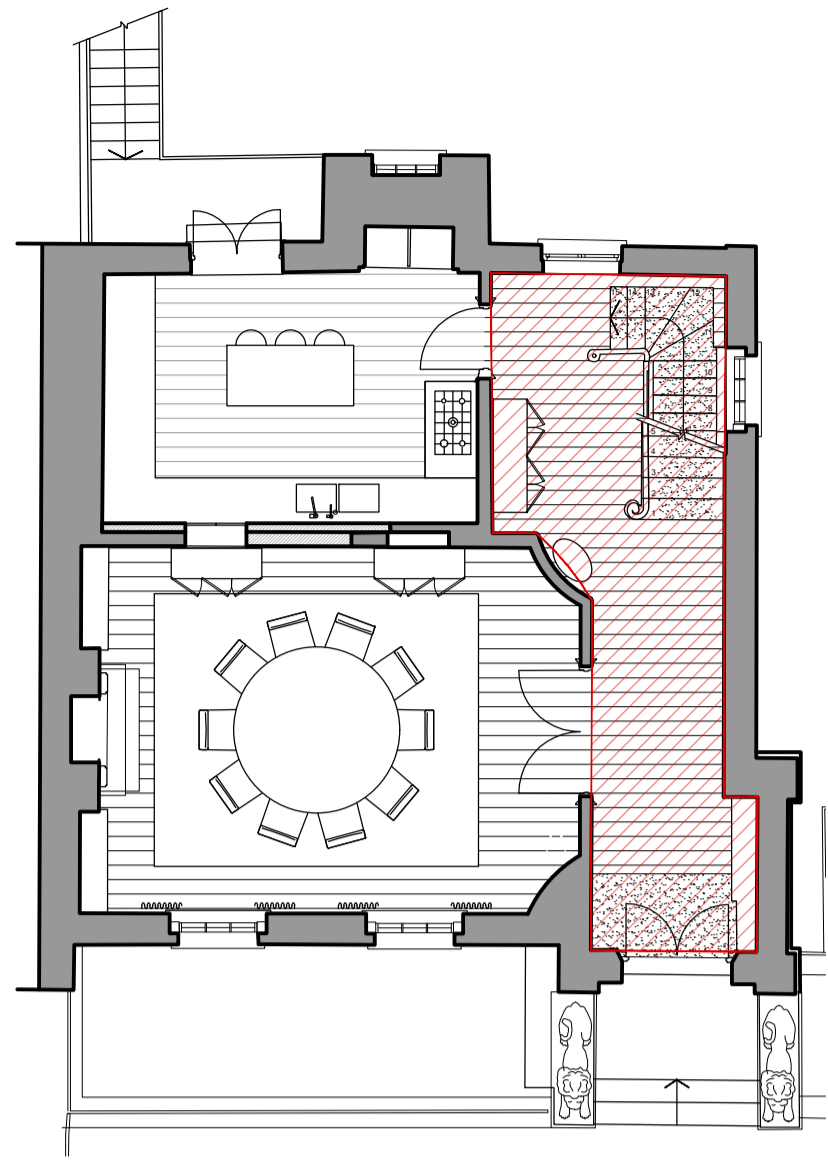

00 KEY PLAN  
1:100 @ A1

**NOTE:**

DRAWINGS TO BE READ IN CONJUNCTION WITH 761\_400s  
ROOM ELEVATIONS AND 761\_900\_100 FINISHES SCHEDULE  
BY ELICYON

'761\_300\_400\_SMALL POWER & LOW LEVEL LIGHTING PLAN'  
& '761\_300\_300\_REFLECTIVE CEILING & AV PLANS' TAKE  
PRECEDENCE OVER '400 SERIES INTERNAL ELEVATIONS'  
DRAWINGS



**NOTES**

EXISTING RELOCATED FITTINGS ARE MARKED IN  
**ORANGE**


NEW FITTINGS ARE MARKED IN **GREEN**

**ELECTRICAL KEY**

☒ SINGLE SWITCHED 5AMP SOCKET OUTLET

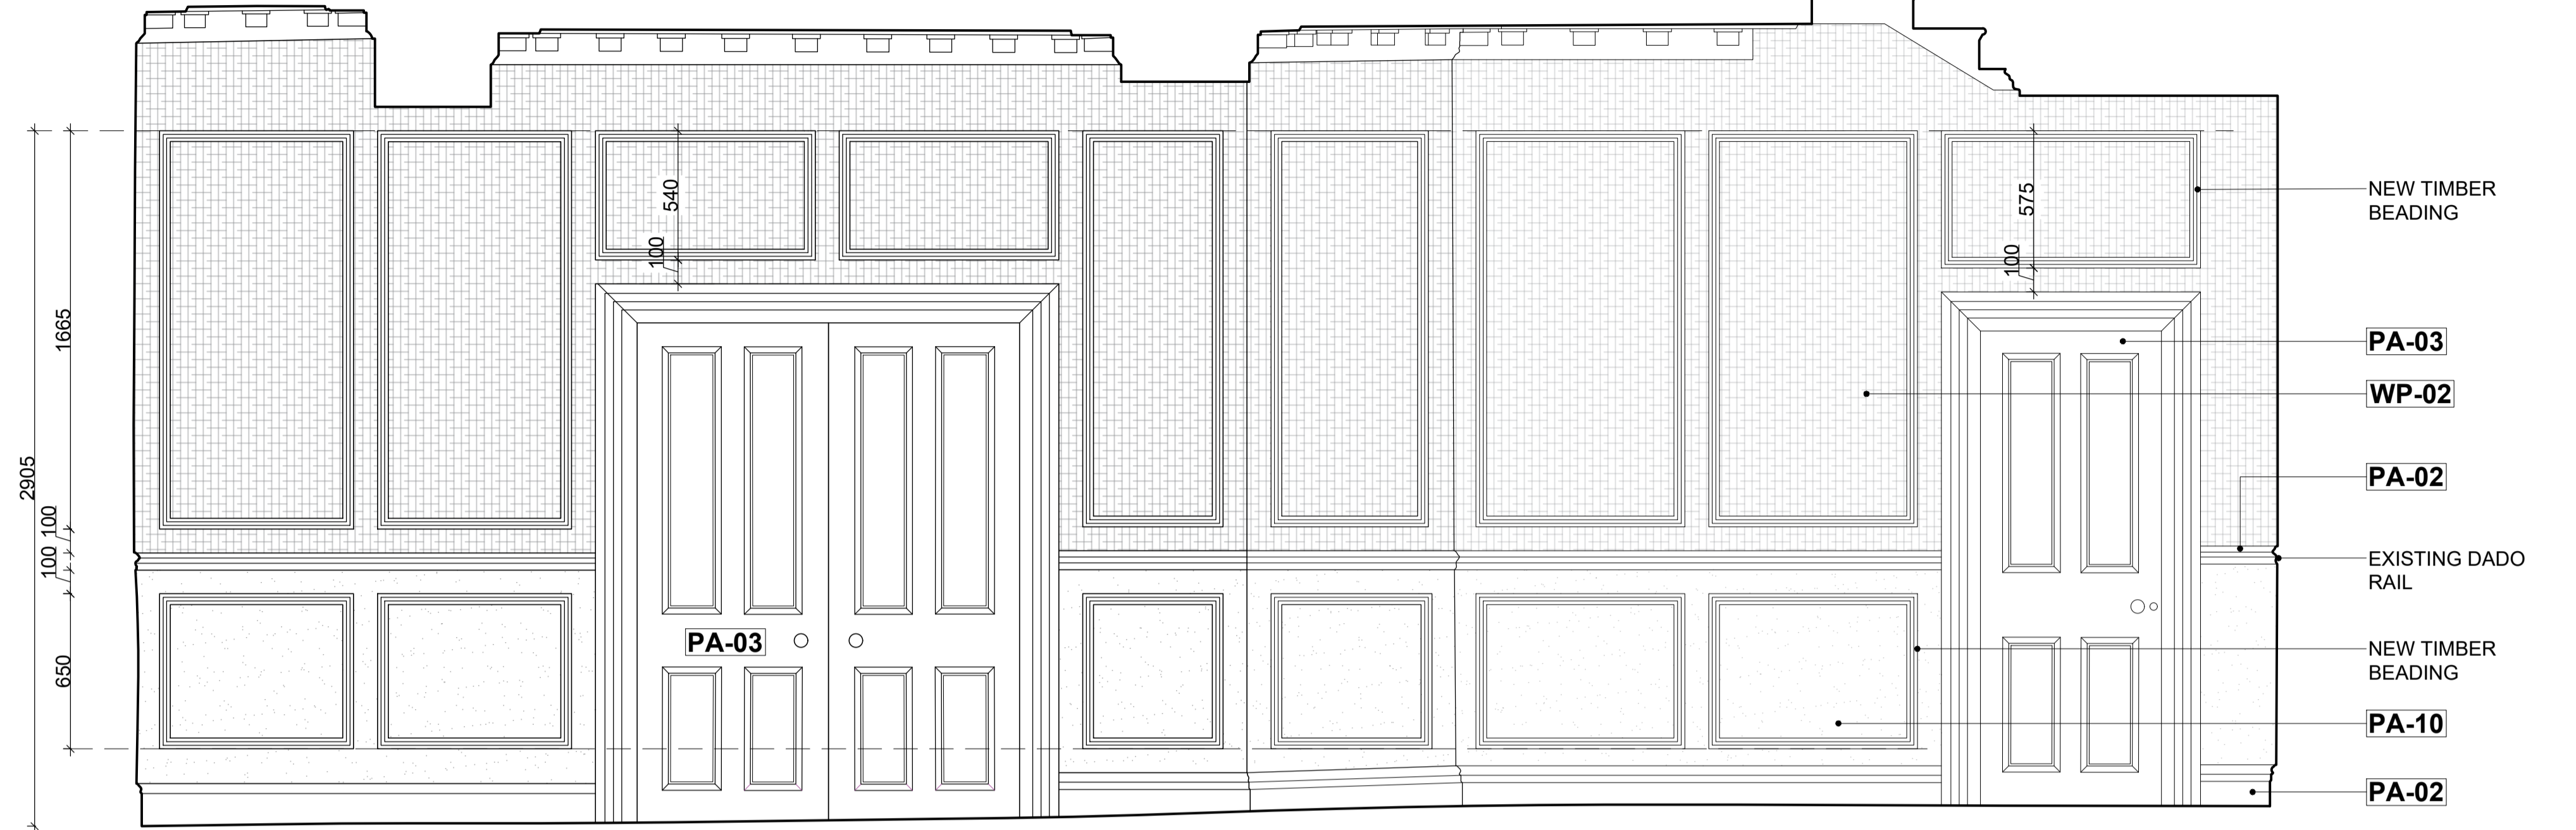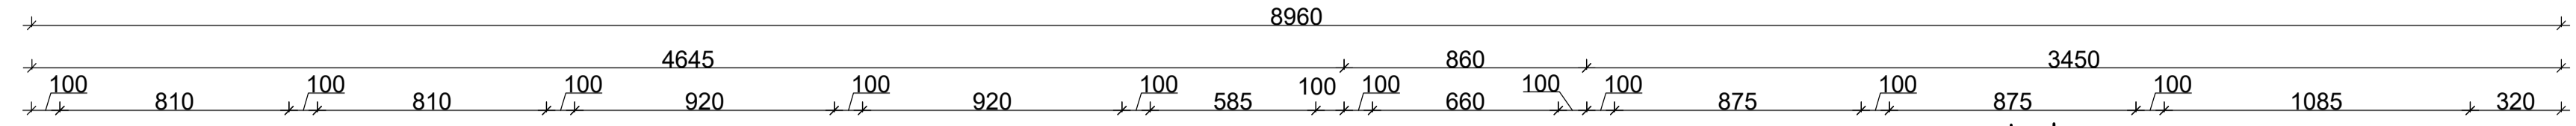


02 ELEVATION A  
1:20 @ A1

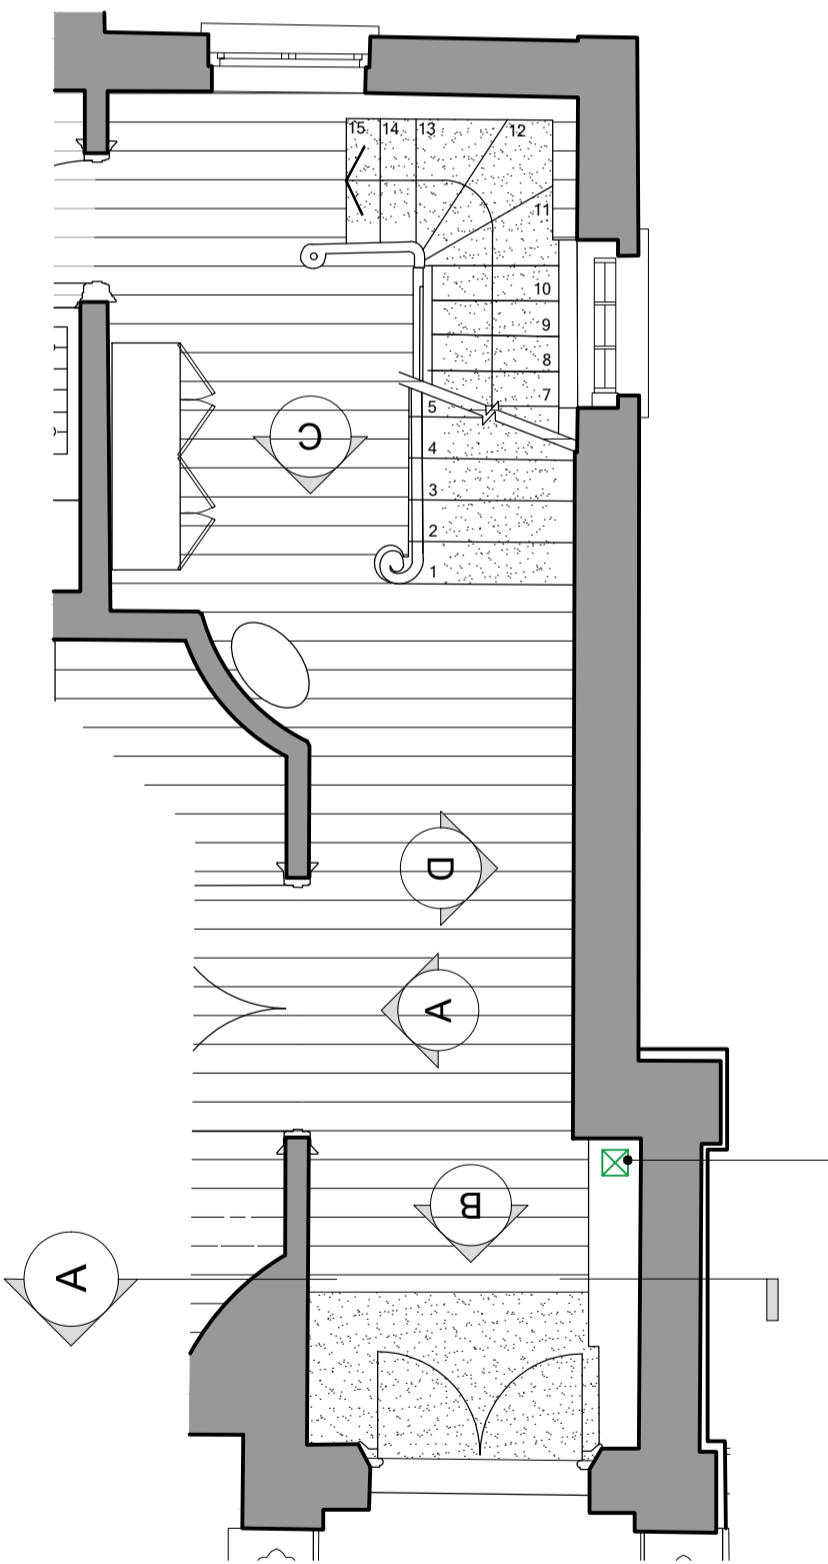

01 PLAN  
1:50 @ A1


SINGLE SOCKET TO  
BE INTEGRATED IN  
NEW RADIATOR TOP

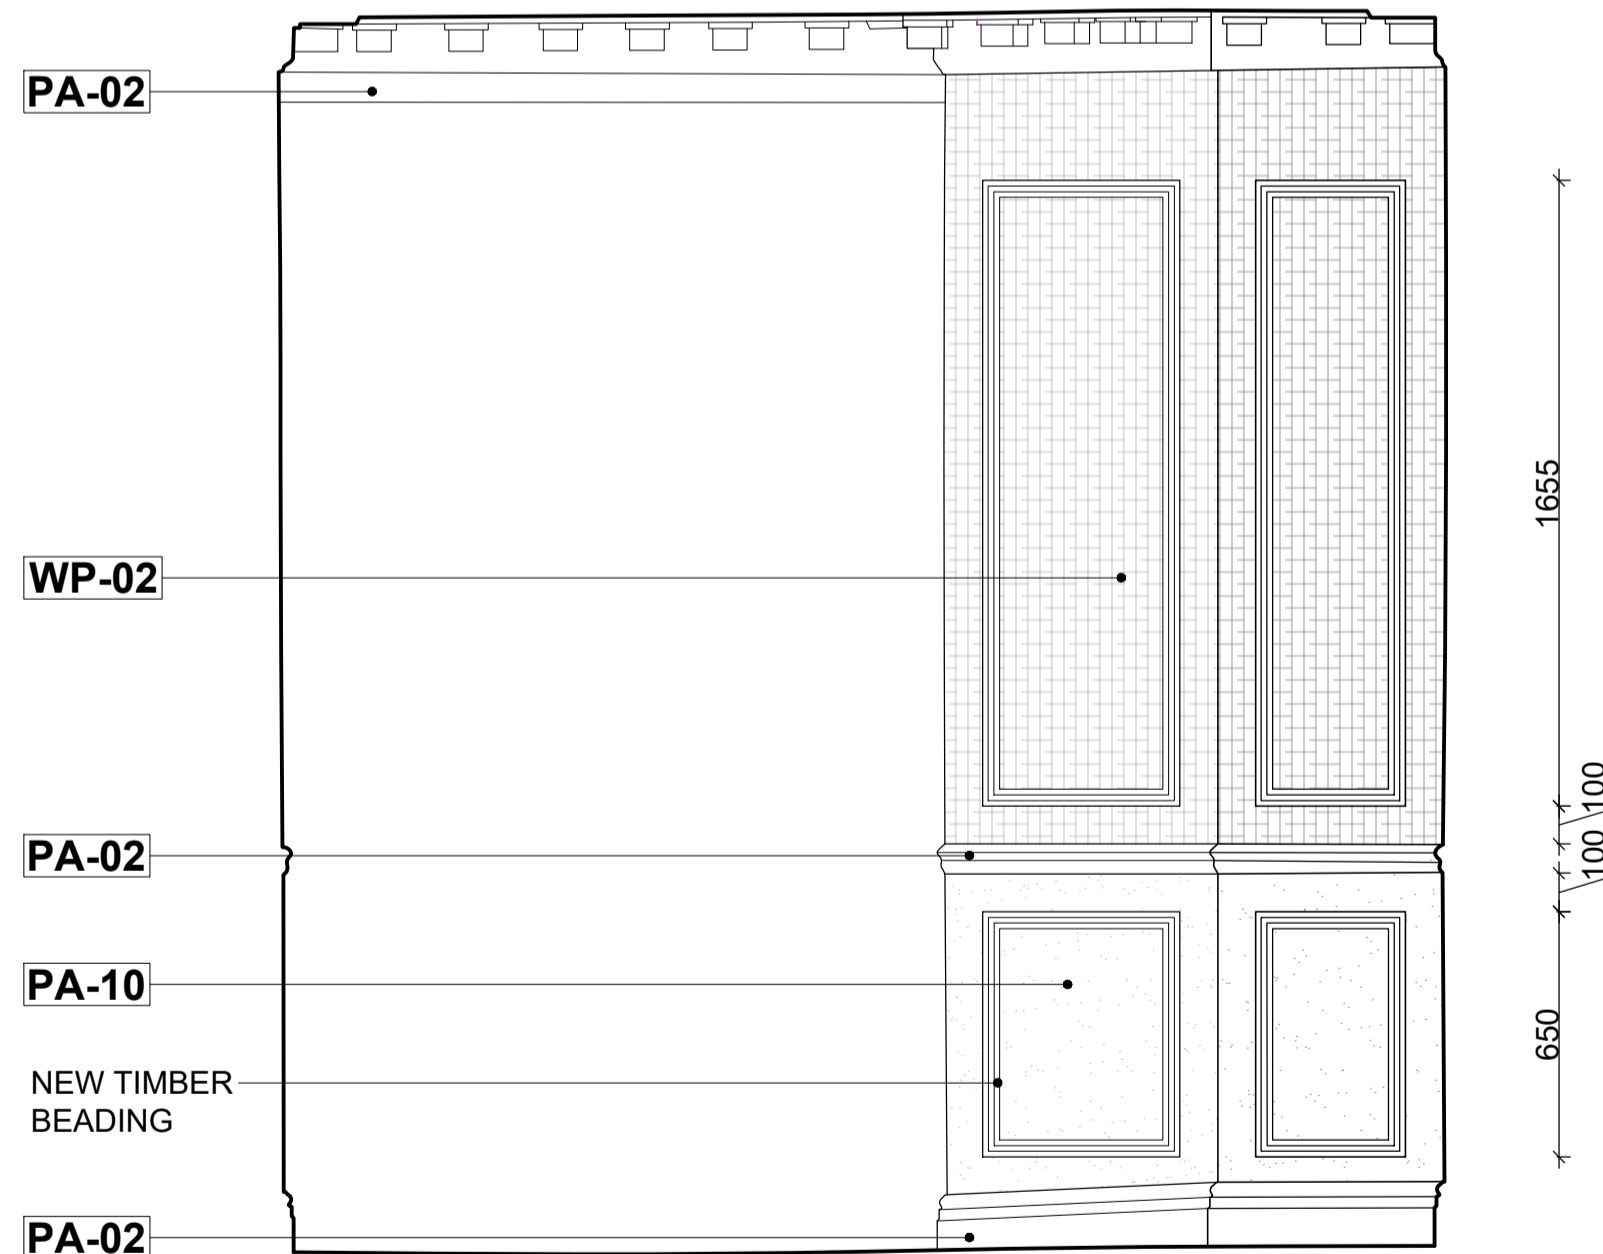


03 ELEVATION C  
1:20 @ A1

EXISTING RADIATOR  
COVER TO BE REPLACED  
WITH NEW TOP. ALLOW  
FOR SINGLE SOCKET TO  
BE INTEGRATED IN  
JOINERY

SF-02

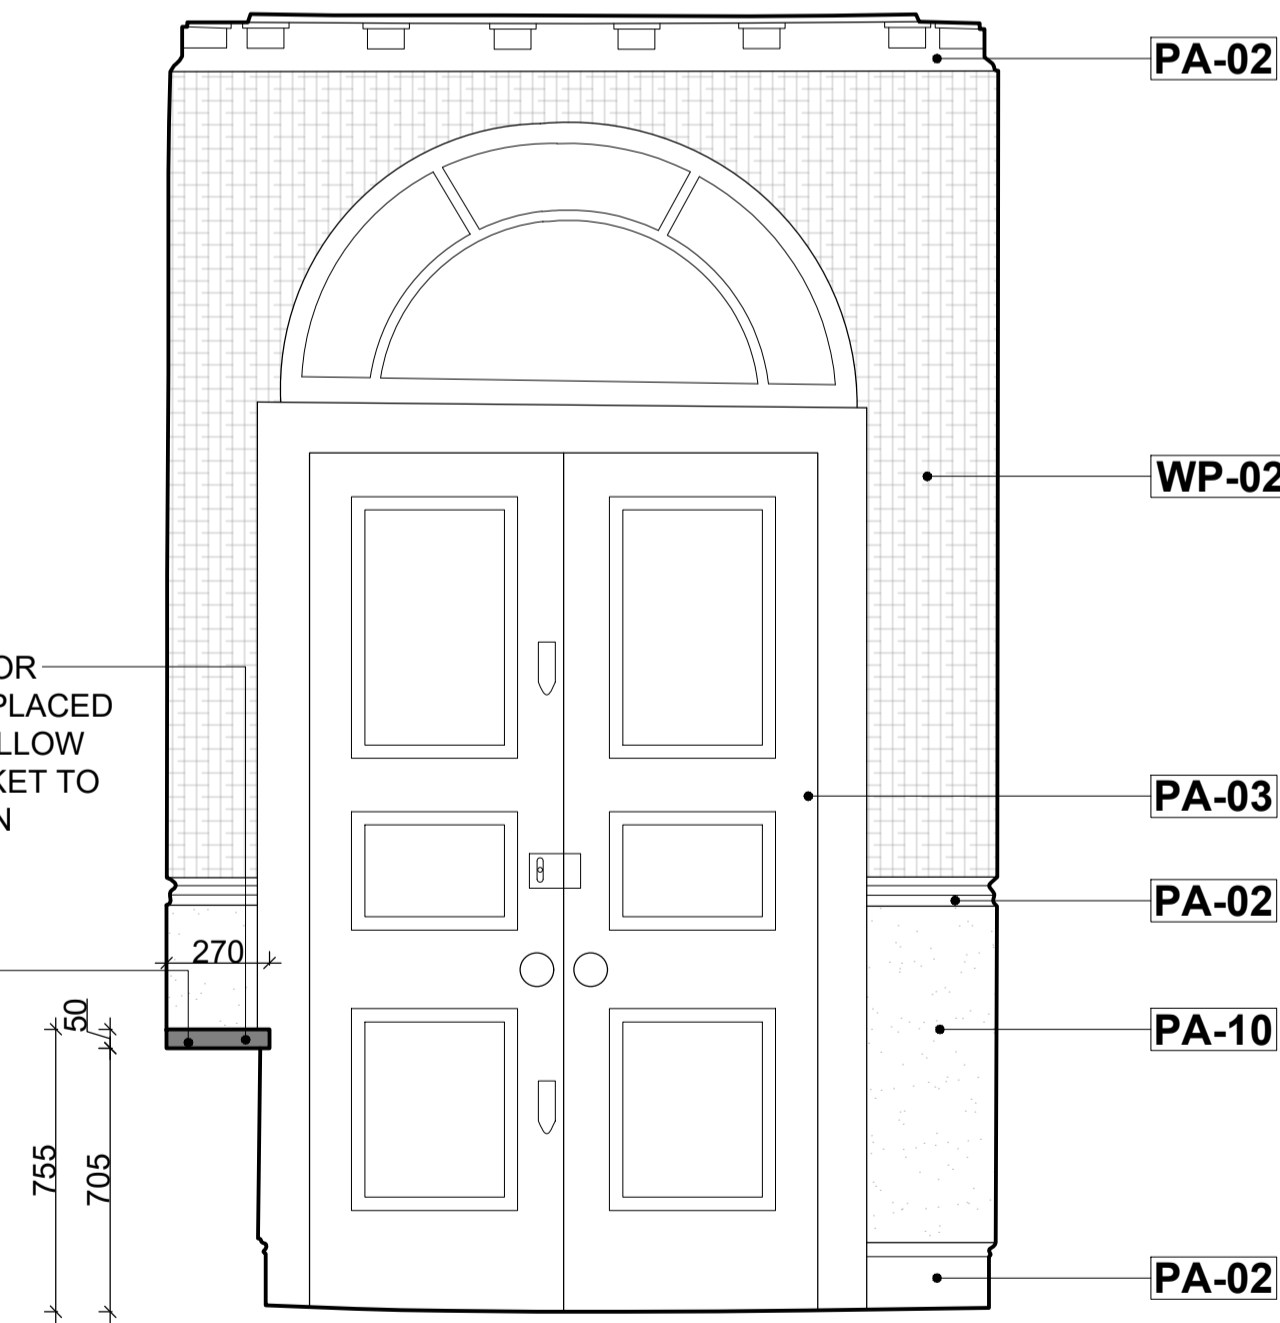

04 SECTION B  
1:20 @ A1

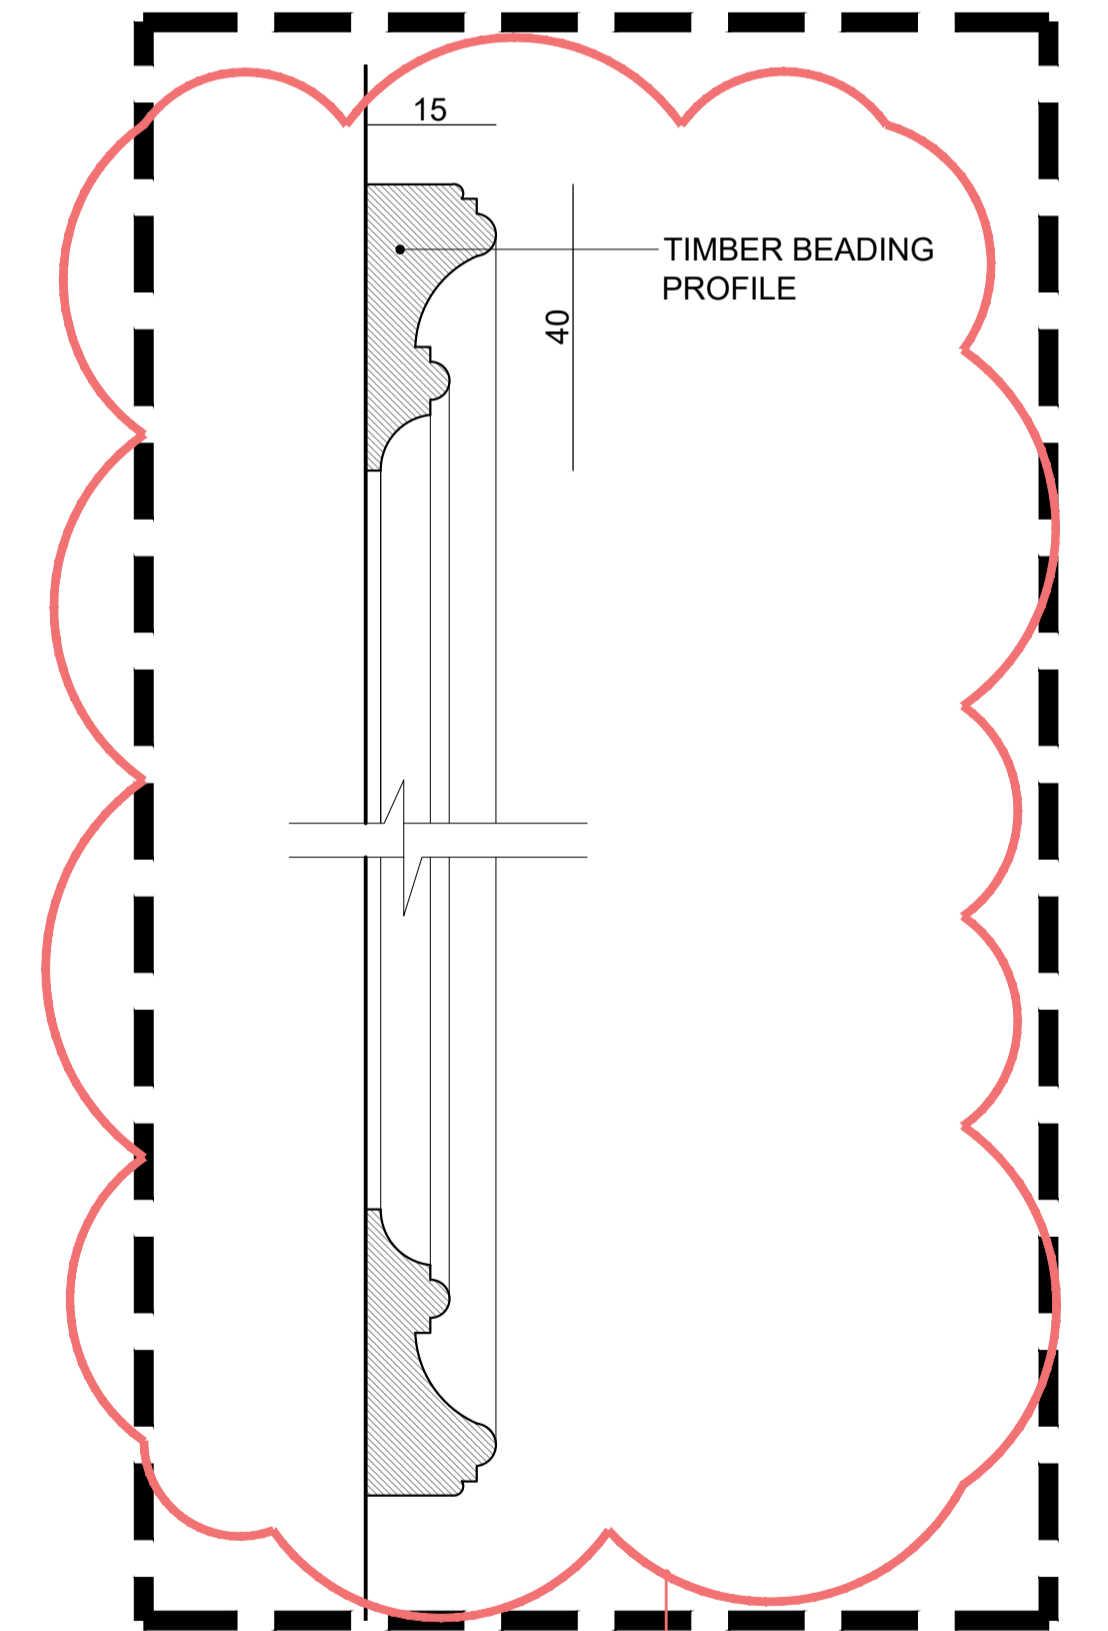

04 BEADING PROFILE  
1:1 @ A1

PROFILE TO BE  
CONFIRMED



PROJECT TITLE:  
6 PRINCE ALBERT ROAD  
REGENTS PARK  
NW1

PROJECT CODE:  
761  
DRAWN BY:  
MA  
CHECKED BY:  
KH  
ISSUED FOR:  
ISSUED FOR TENDER  
SCALE:  
1:20 @ A1  
DATE:  
13.09.2021  
DRAWING NO:  
761\_400\_101\_001  
REVISION:  
A

DRAWING TITLE:  
ENTRANCE HALL  
PLAN & ELEVATION  
AS PROPOSED

REV	BY	DATE	DESCRIPTION
A	MA	29.10.21	ISSUED FOR TENDER

REV	BY	DATE	DESCRIPTION

DISCLAIMER:  
In accordance with our duties under the Misrepresentation Act 1967 and the Mis-description Act 1991, these details have been prepared in good faith but are not intended to constitute part of an offer of contract or create any contractual relationship. No description or information of any kind provided by Elicyon or its Agents, whether written or verbal, contained in these Particulars or elsewhere ("Information") may be relied upon as a statement of representation, warranty or fact. Neither Elicyon nor its Agents have any authority to make any representation or warranty and accordingly any information is given entirely without responsibility on the part of Elicyon, its Agents or the seller. Any plans, photos, and computer generated images shown are indicative and cannot be guaranteed to represent the complete interiors/exterior of a scheme. Any Areas, measurements or distances given are approximate only. Any products and materials shown or indicated are indicative only and may be subject to variations or change. It is not possible to scale from these drawings. Any reference to alterations to or use of any part of the property is not a statement that any necessary planning, building regulations or other consent has been obtained. These matters must be verified by any buyer/lessee. Any buyer/lessee must satisfy himself by inspection or otherwise as to the correctness of any information given. © All rights reserved to Elicyon London.

Elicyon Limited  
First Floor, Avon House,  
Avonmore Road, Kensington Village  
London W14 8TS  
Tel: +44 (0)203 772 0011  
Web: www.elicyon.com  
E-mail: studio@elicyon.com

ELICYON