



ALL DIMENSIONS TO BE
CONFIRMED ON SITE

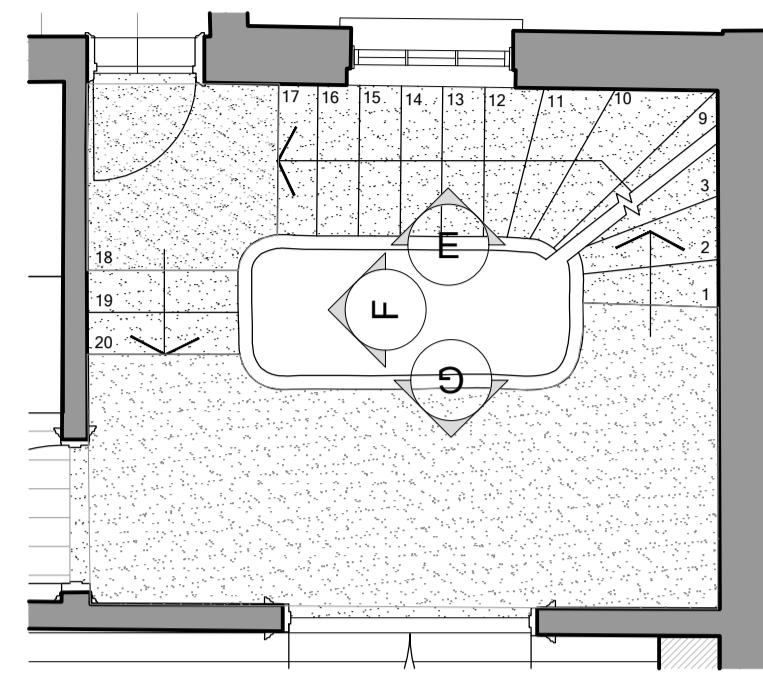



01 KEY PLAN
1:50 @ A1

NOTE:
DRAWINGS TO BE READ IN CONJUNCTION WITH 761_400s
ROOM ELEVATIONS AND 761_900_100 FINISHES SCHEDULE
BY ELICYON


761_300_400_SMALL POWER & LOW LEVEL LIGHTING PLAN
& 761_300_300_REFLECTIVE CEILING & AV PLANS TAKE
PRECEDENCE OVER '400 SERIES INTERNAL ELEVATIONS'
DRAWINGS

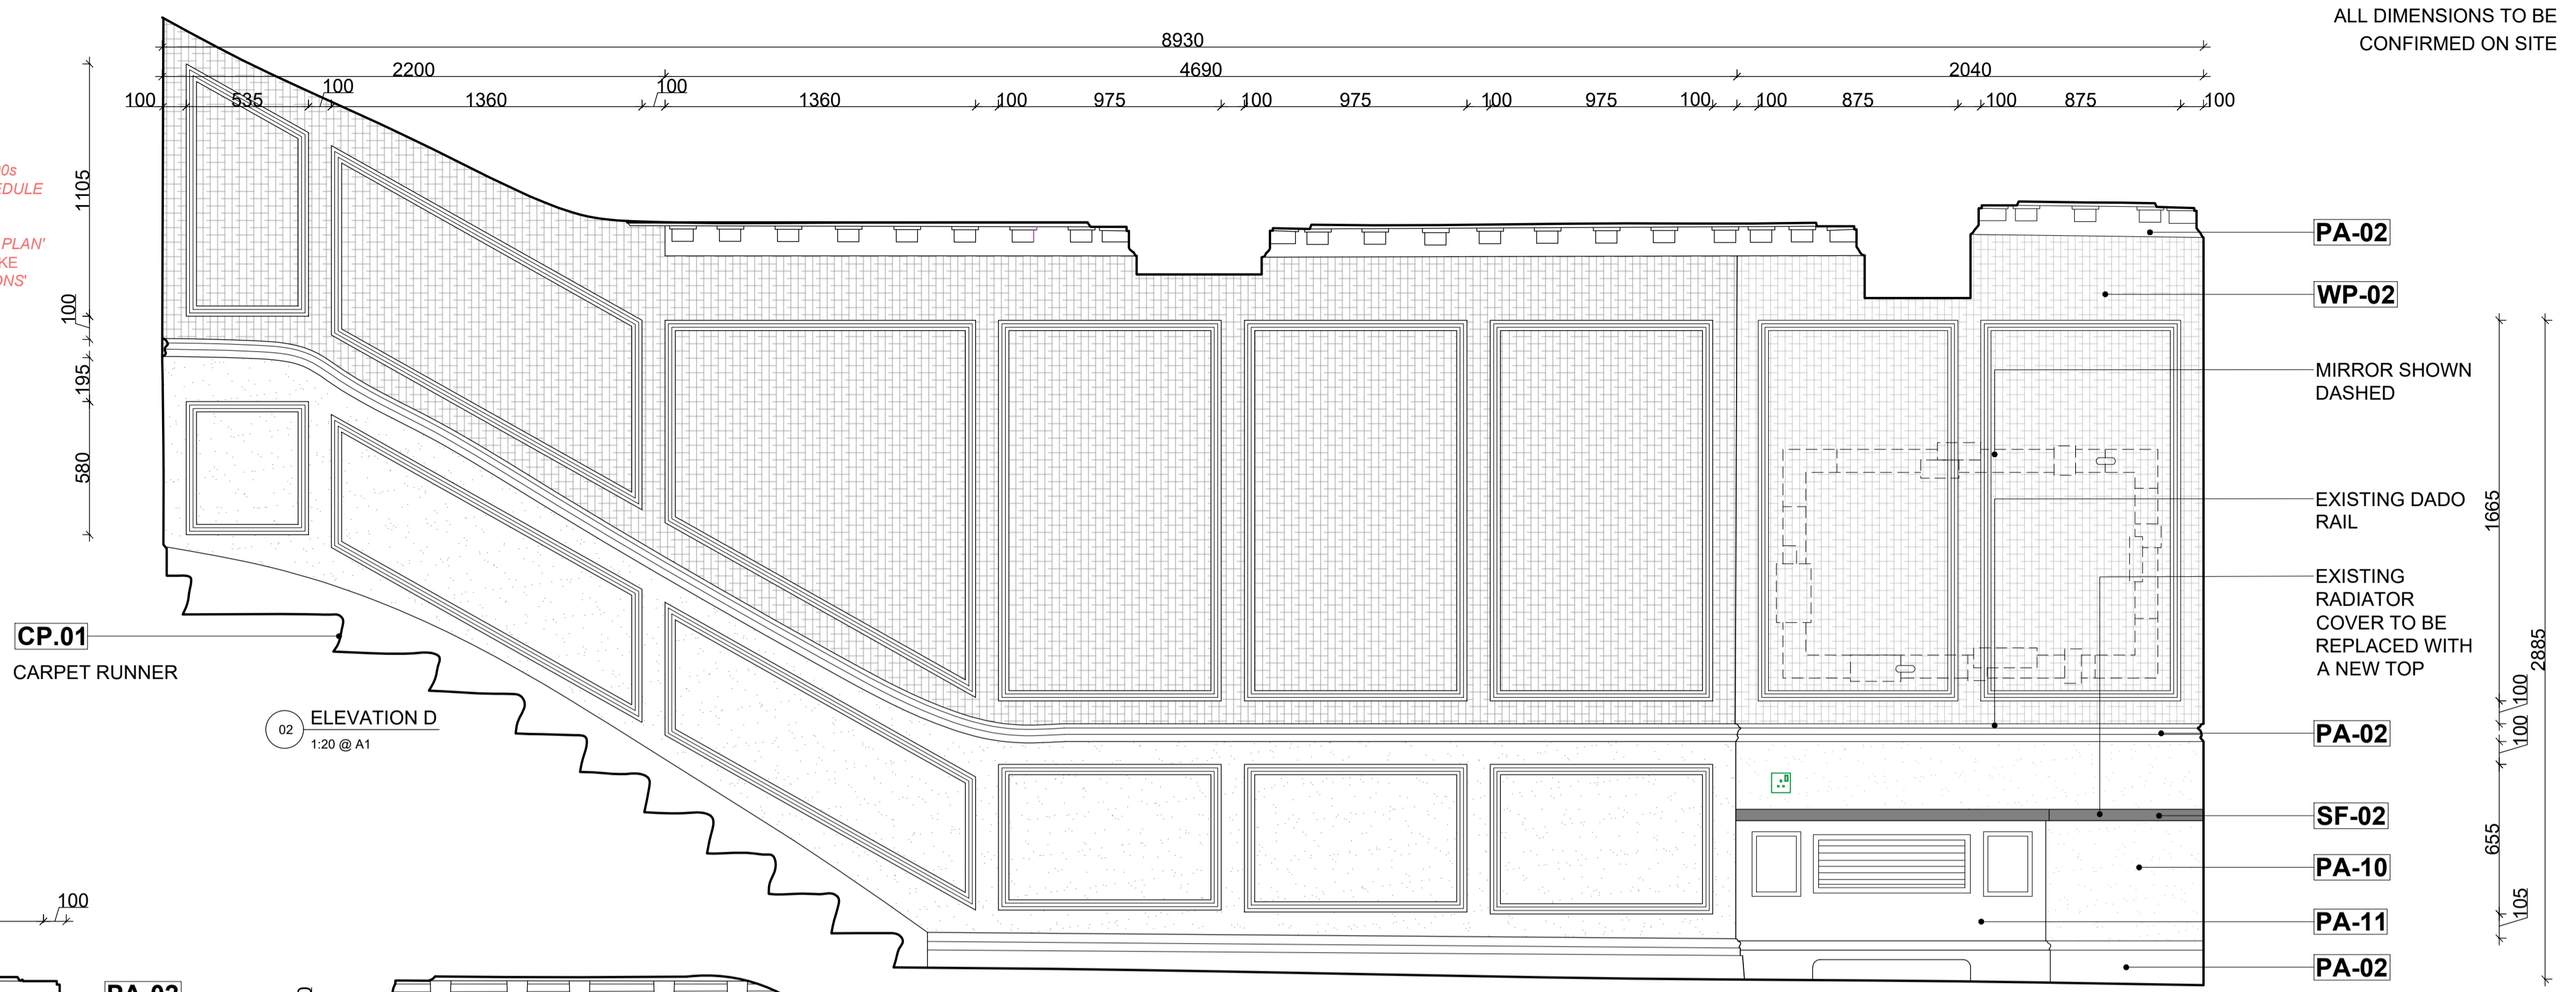


02 ELEVATION D
1:20 @ A1

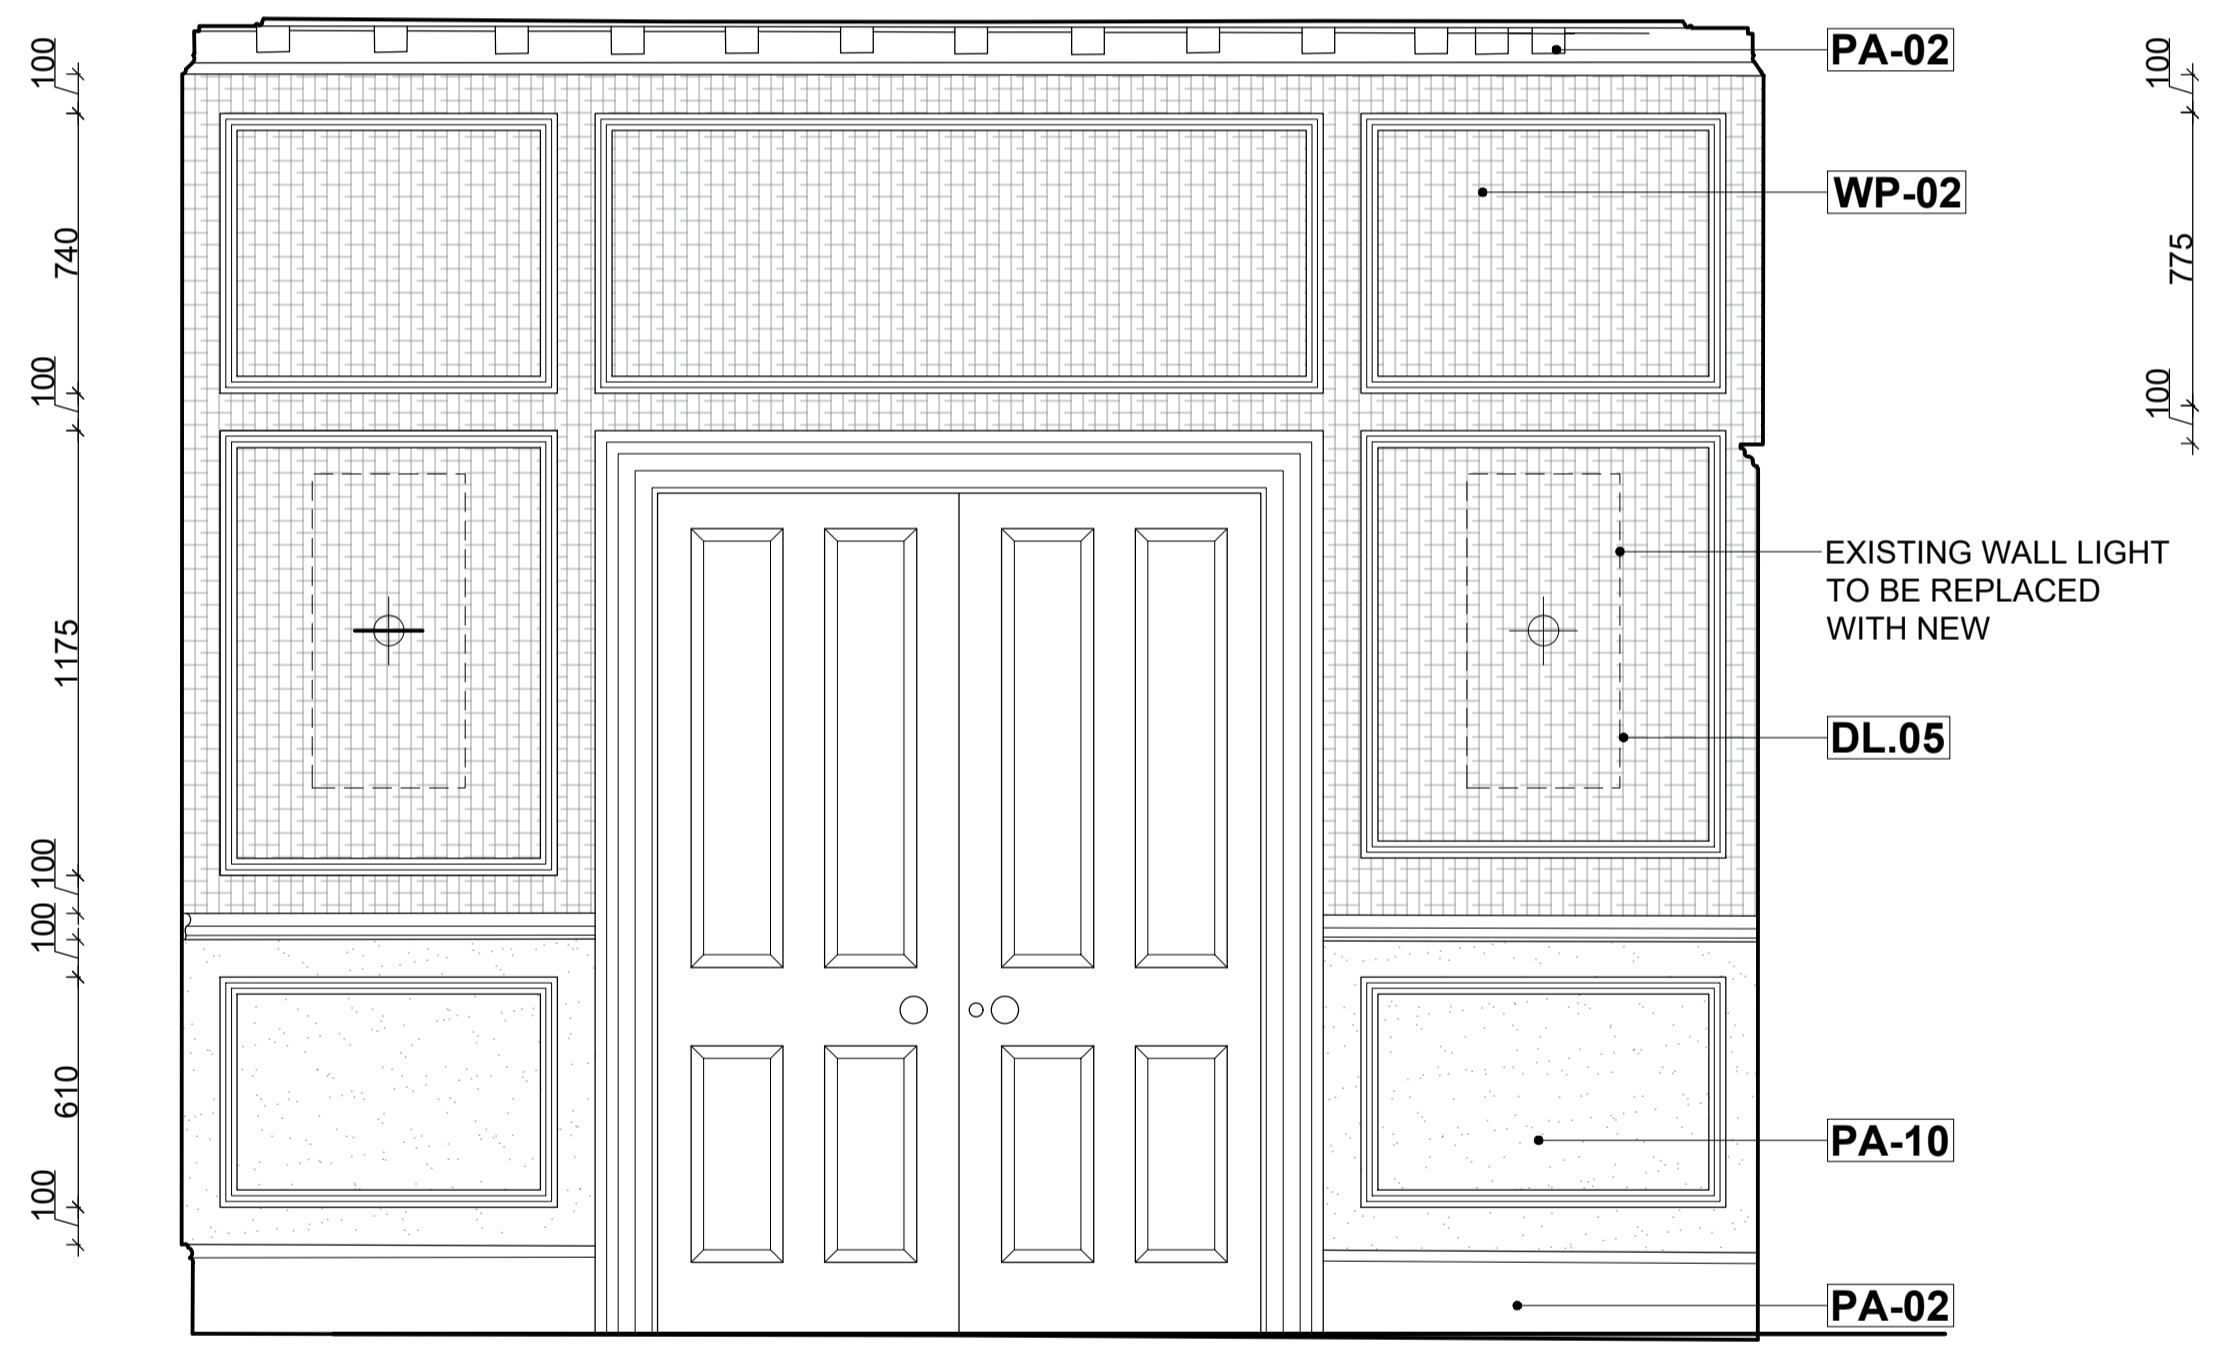 


02 ELEVATION G
1:20 @ A1

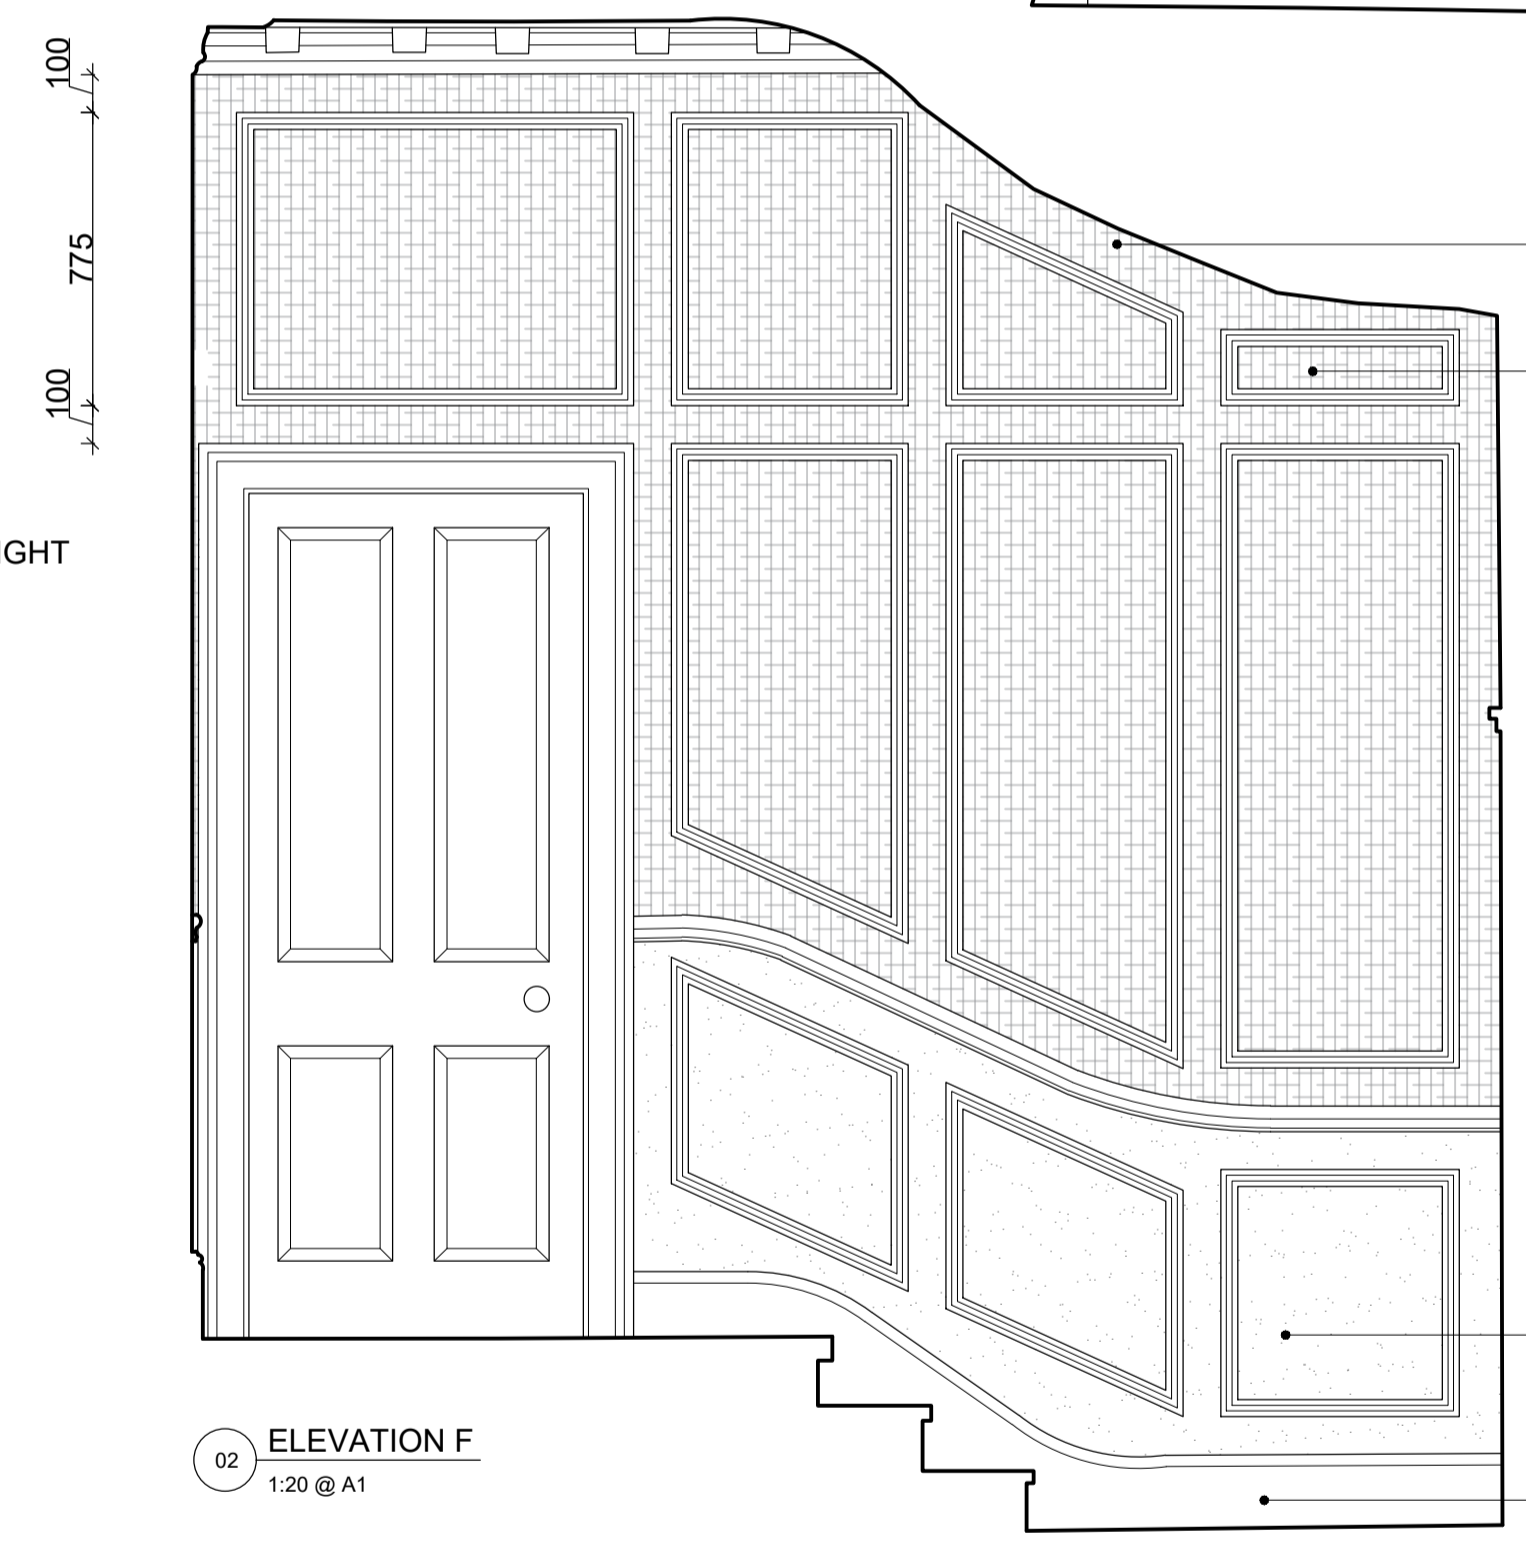

02 ELEVATION F
1:20 @ A1

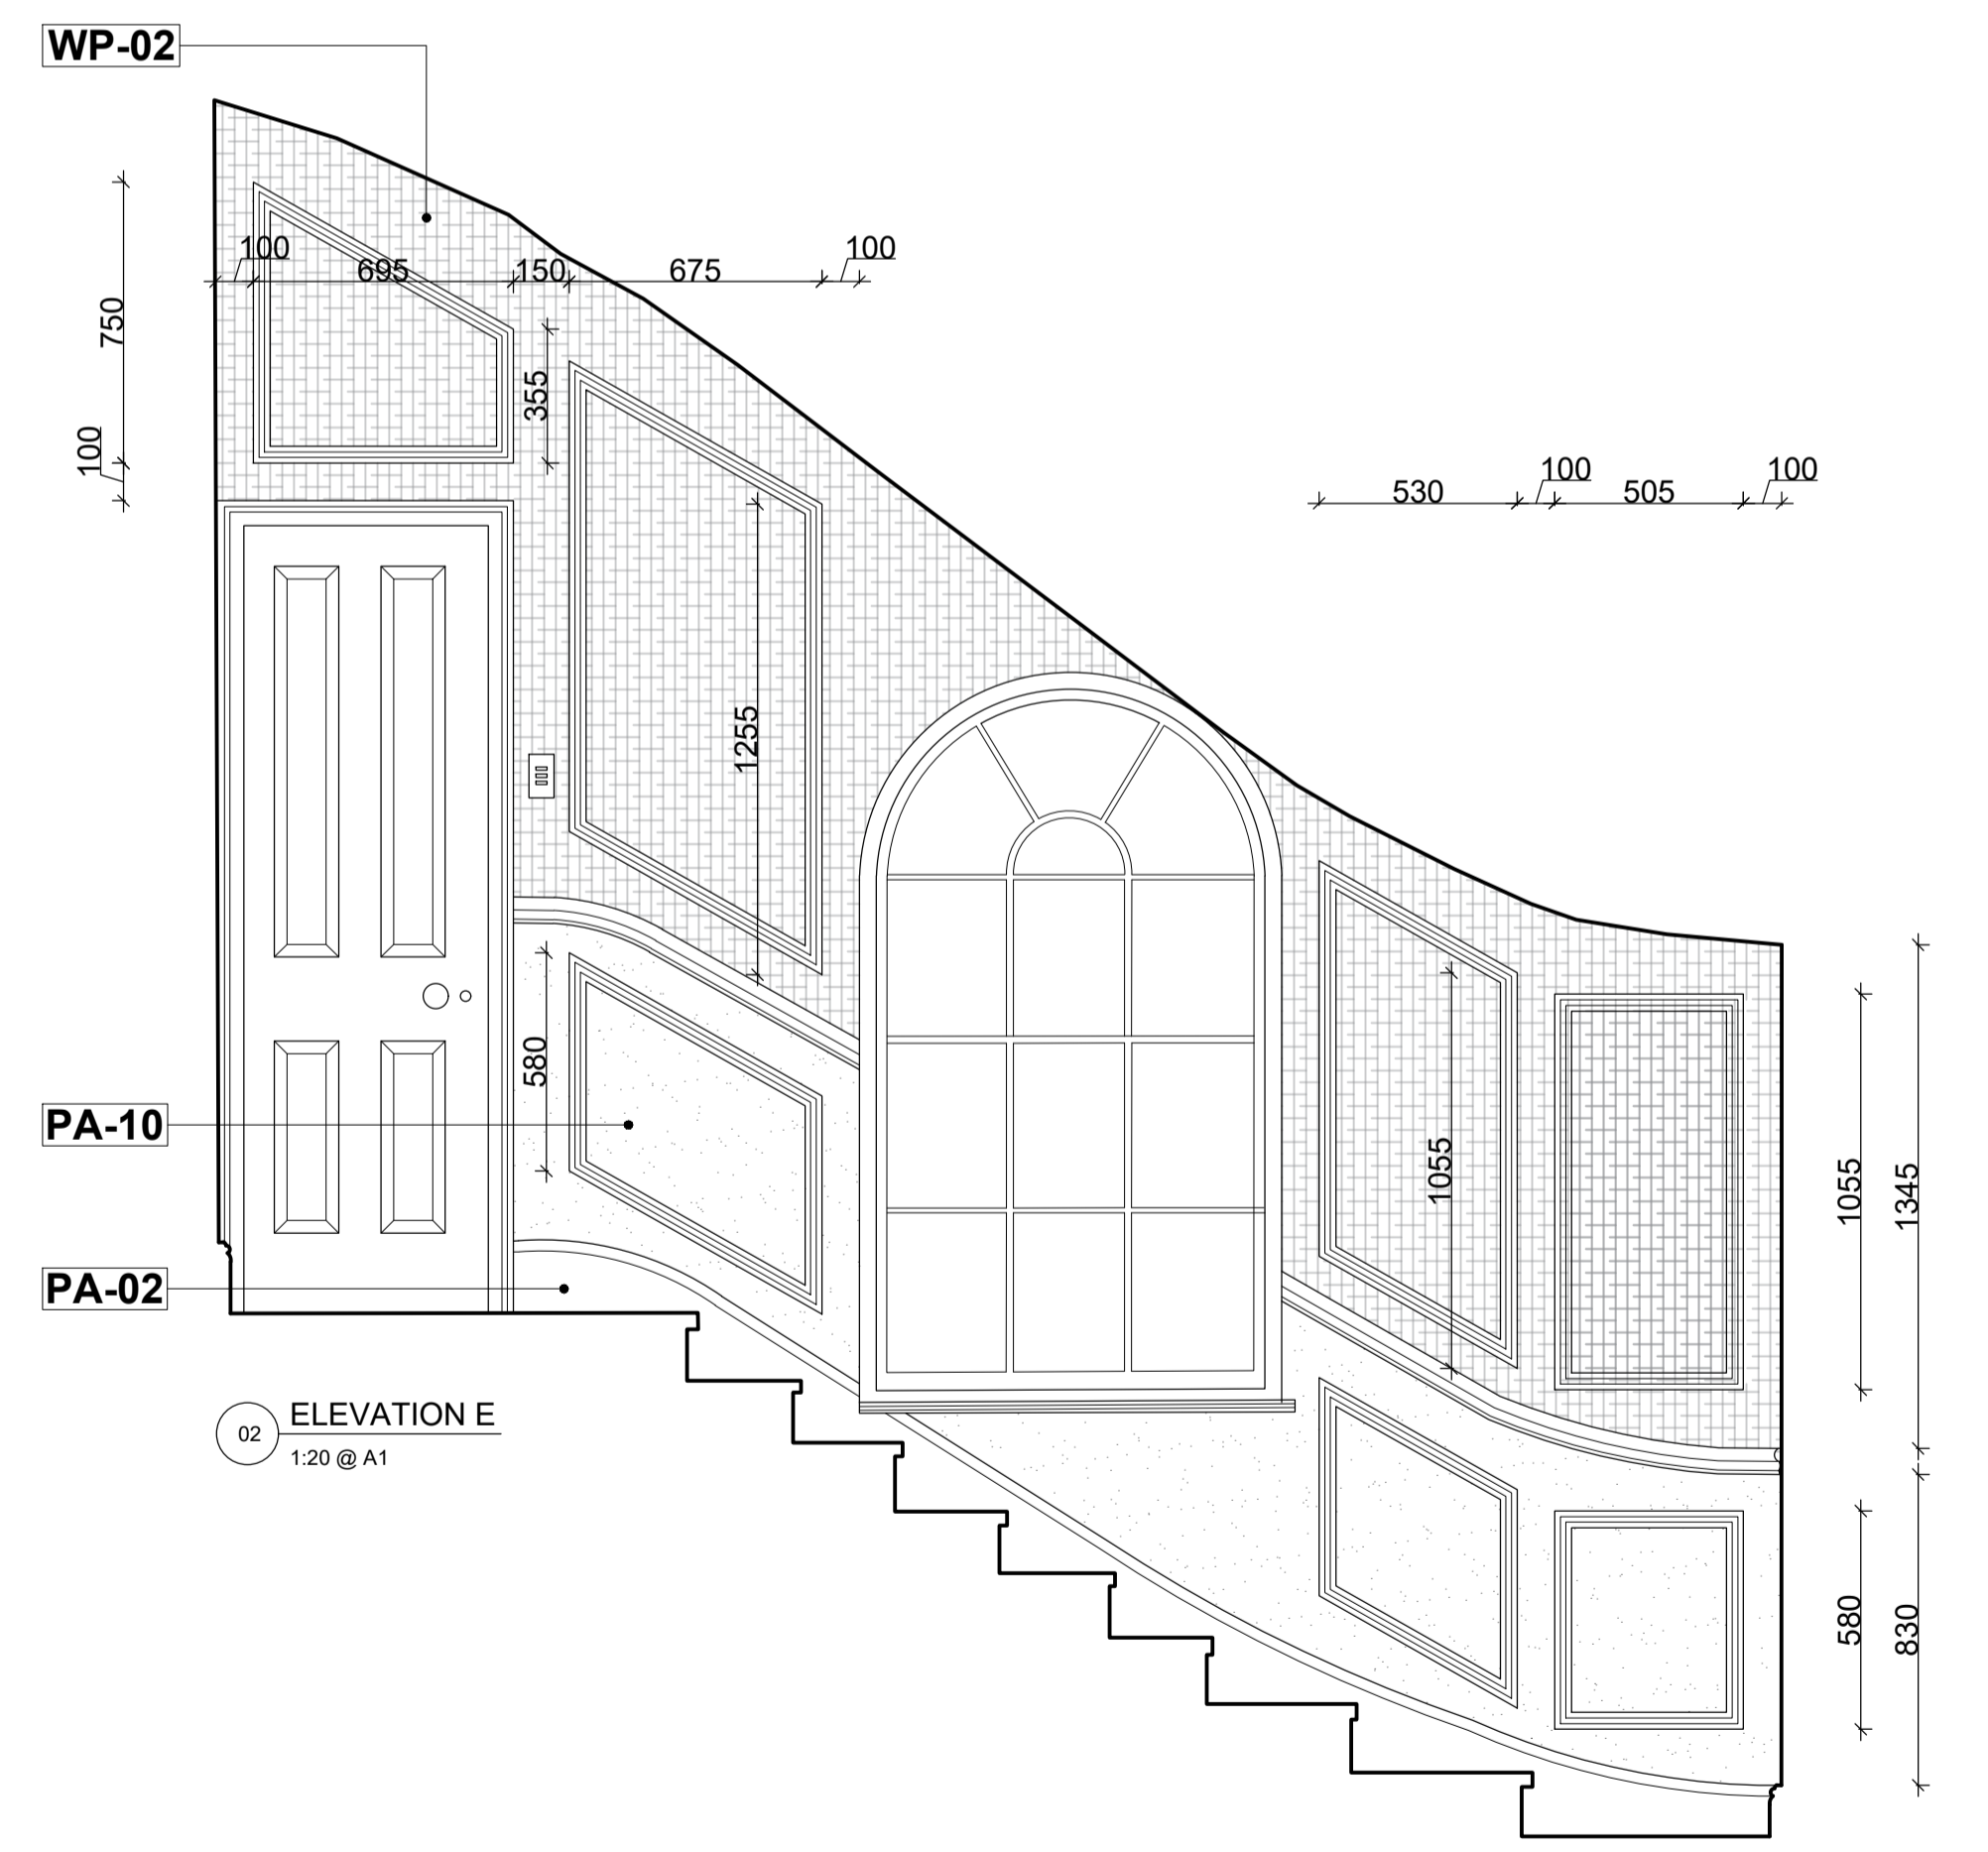

02 ELEVATION E
1:20 @ A1

 

PROJECT TITLE:
6 PRINCE ALBERT ROAD
REGENTS PARK
NW1

PROJECT CODE:
761
DRAWN BY:
MA
CHECKED BY:
KH
ISSUED FOR:
ISSUED FOR TENDER
SCALE:
1:20 @ A1
DATE:
13.09.2021
DRAWING NO:
761_400_101_002
REVISION:
A

REV	BY	DATE	DESCRIPTION
A	MA	29.10.21	ISSUED FOR TENDER

DISCLAIMER:
In accordance with our duties under the Misrepresentation Act 1967 and the Mis-description Act 1991, these details have been prepared in good faith but are not intended to constitute part of an offer of contract or create any contractual relationship. No description or information of any kind provided by Elicyon or its Agents, whether written or verbal, contained in these Particulars or elsewhere ("Information") may be relied upon as a statement of representation, warranty or fact. Neither Elicyon nor its Agents have any authority to make any representation or warranty and accordingly any information is given entirely without responsibility on the part of Elicyon, its Agents or the seller. Any plans, photos, and computer generated images shown are indicative and cannot be guaranteed to represent the complete interiors/exterior of a scheme. Any Areas, measurements or distances given are approximate only. Any products and materials shown or indicated are indicative only and may be subject to variations or change. It is not possible to scale from these drawings. Any reference to alterations to or use of any part of the property is not a statement that any necessary planning, building regulations or other consent has been obtained. These matters must be verified by any buyer/lessee. Any buyer/lessee must satisfy himself by inspection or otherwise as to the correctness of any information given.
© All rights reserved to Elicyon London.

Elicyon Limited
First Floor, Avon House,
Avonmore Road, Kensington Village
London W14 8TS
Tel: +44 (0)203 772 0011
Web: www.elicyon.com
E-mail: studio@elicyon.com

