



Site Plan / Red Line Drawing

1:500 Scale

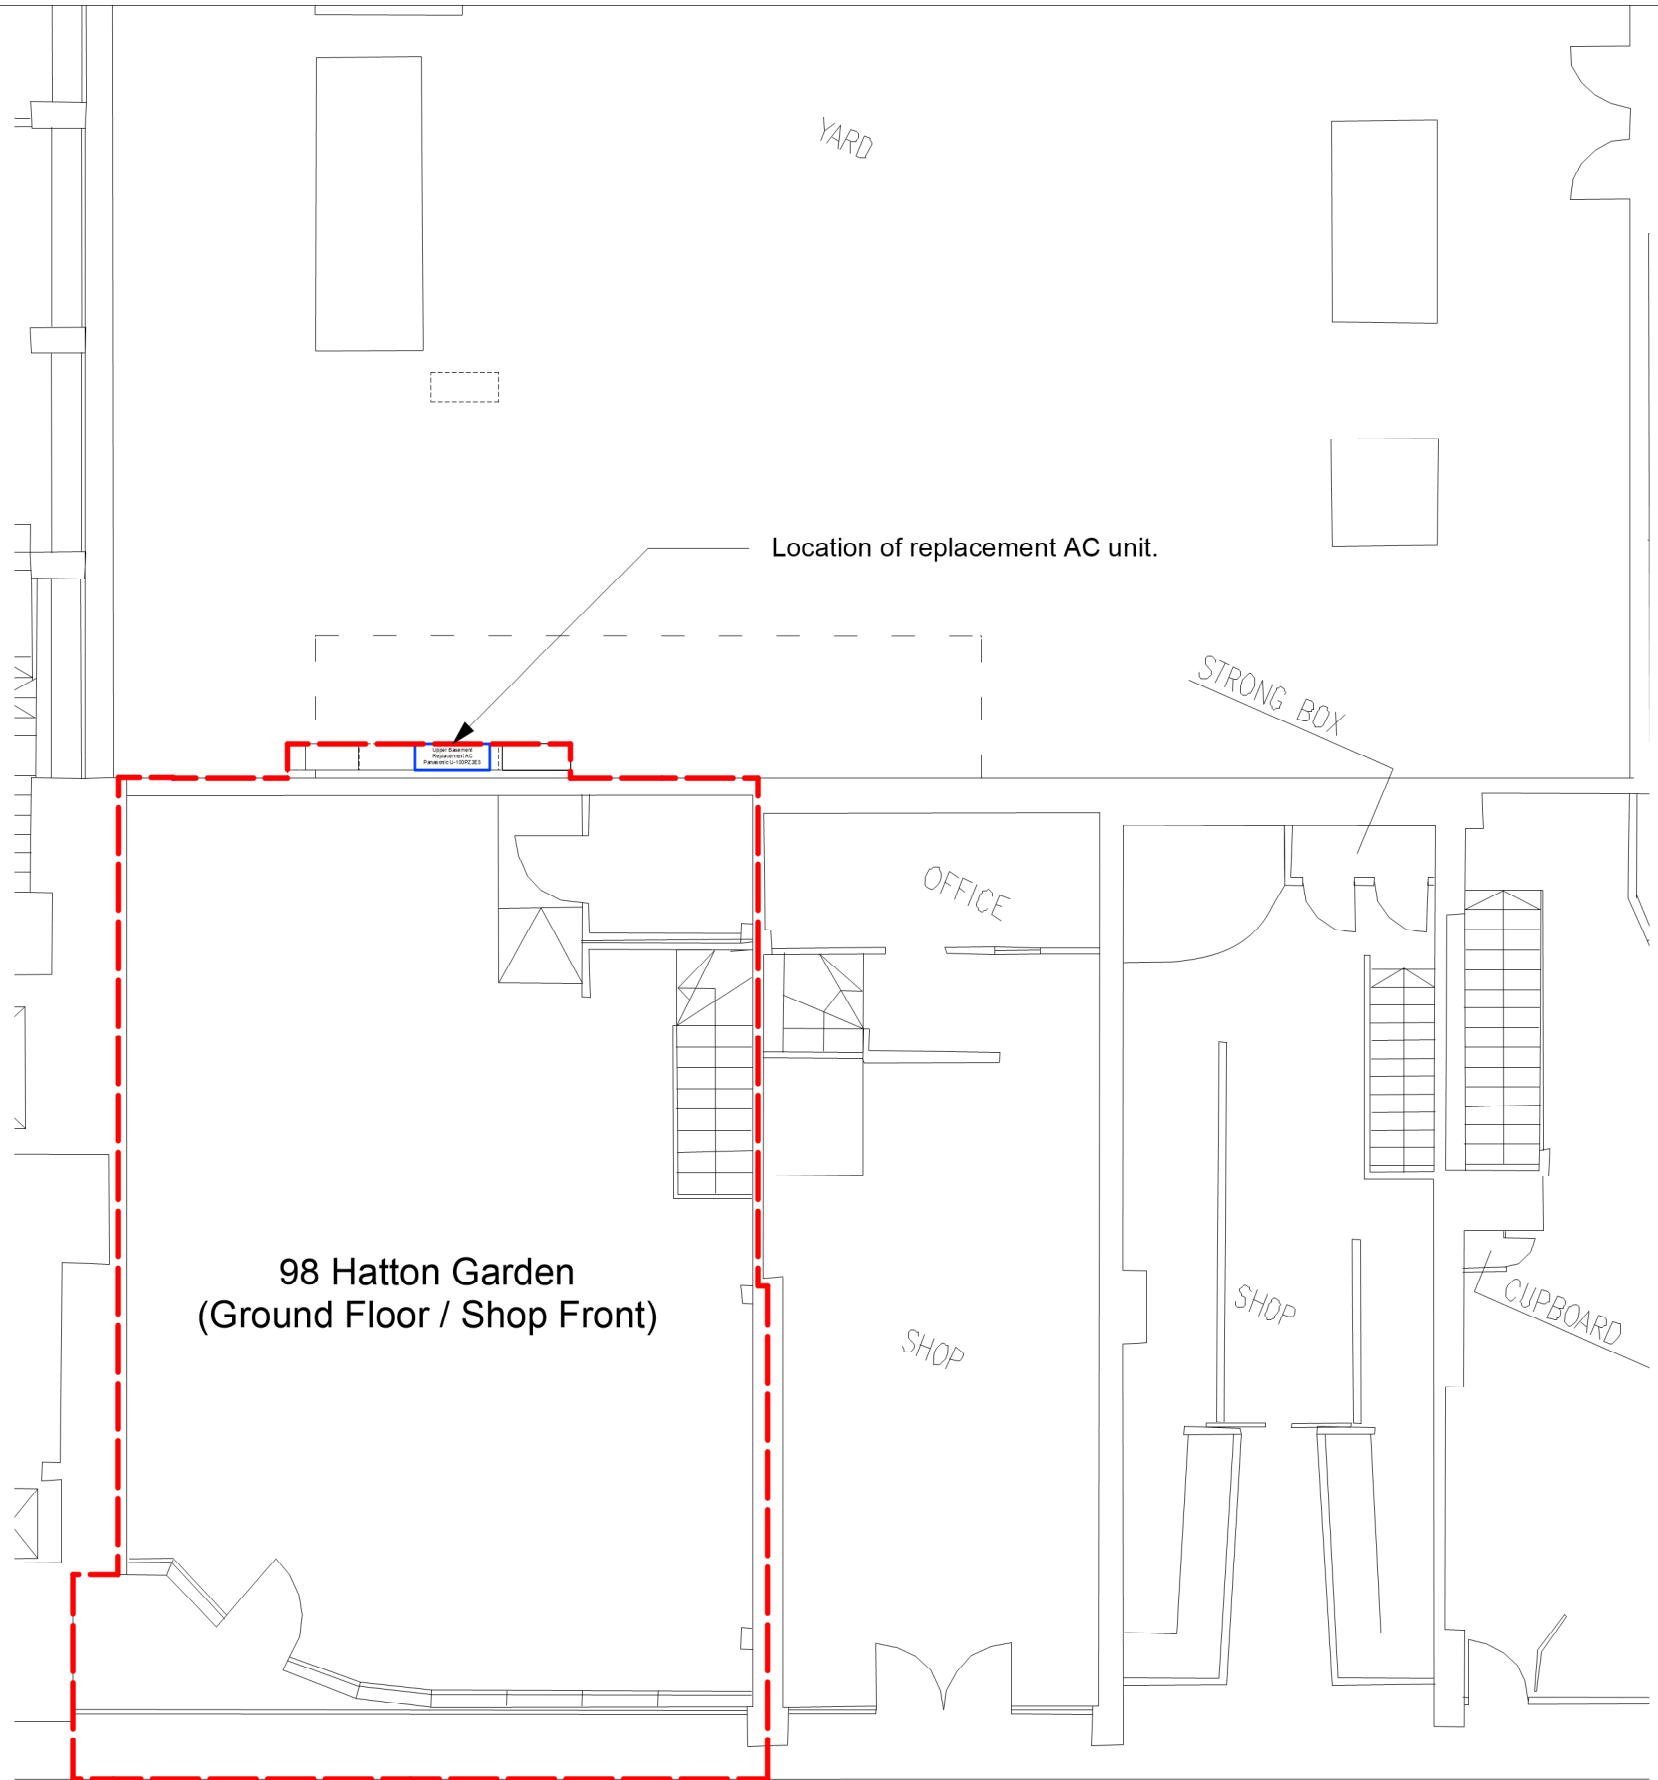

Site Plan - Location of AC unit in internal courtyard to back of 98 Hatton Garden.

 1:00 Scale



DO NOT SCALE THIS DRAWING
 WRITTEN DIMENSIONS ONLY TO BE USED
 ALL DIMENSIONS ARE IN MILLIMETRES
 ALL DIMENSIONS TO BE VERIFIED ON SITE
 ANY INCONSISTENCIES TO BE REPORTED
 TO THE ARCHITECT IMMEDIATELY

GENERAL NOTES:
 1) THIS DRAWING IS TO BE USED IN
 CONJUNCTION WITH ALL RELEVANT
 ARCHITECTS, ENGINEERS AND
 SPECIALISTS DRAWINGS AND DETAILS

date	rev.	by	description of change	checked	status	BERKELEY WORKS BERKLEY GROVE LONDON NW18XY T: 020 7483 7700 F: 020 7483 7733 ISDN: 020 7483 7734 www.chassaylast.co.uk e-mail: @chassaylast.co.uk				CHASSAY LAST ARCHITECTS			
22.11.2021	P1	MB	Issued for Planning Approval.	-	PLANNING	title				Site Plan (Location of replacement AC unit)			
					98 Hatton Garden, Holborn, London EC1N 8NX	drawn by	checked by	date	scale	Stage	Job Code	Dwg. No.	Rev.
						MB	--	22.11.21	1:500 / 1:100 @A3	4	HGC	E301	P1