


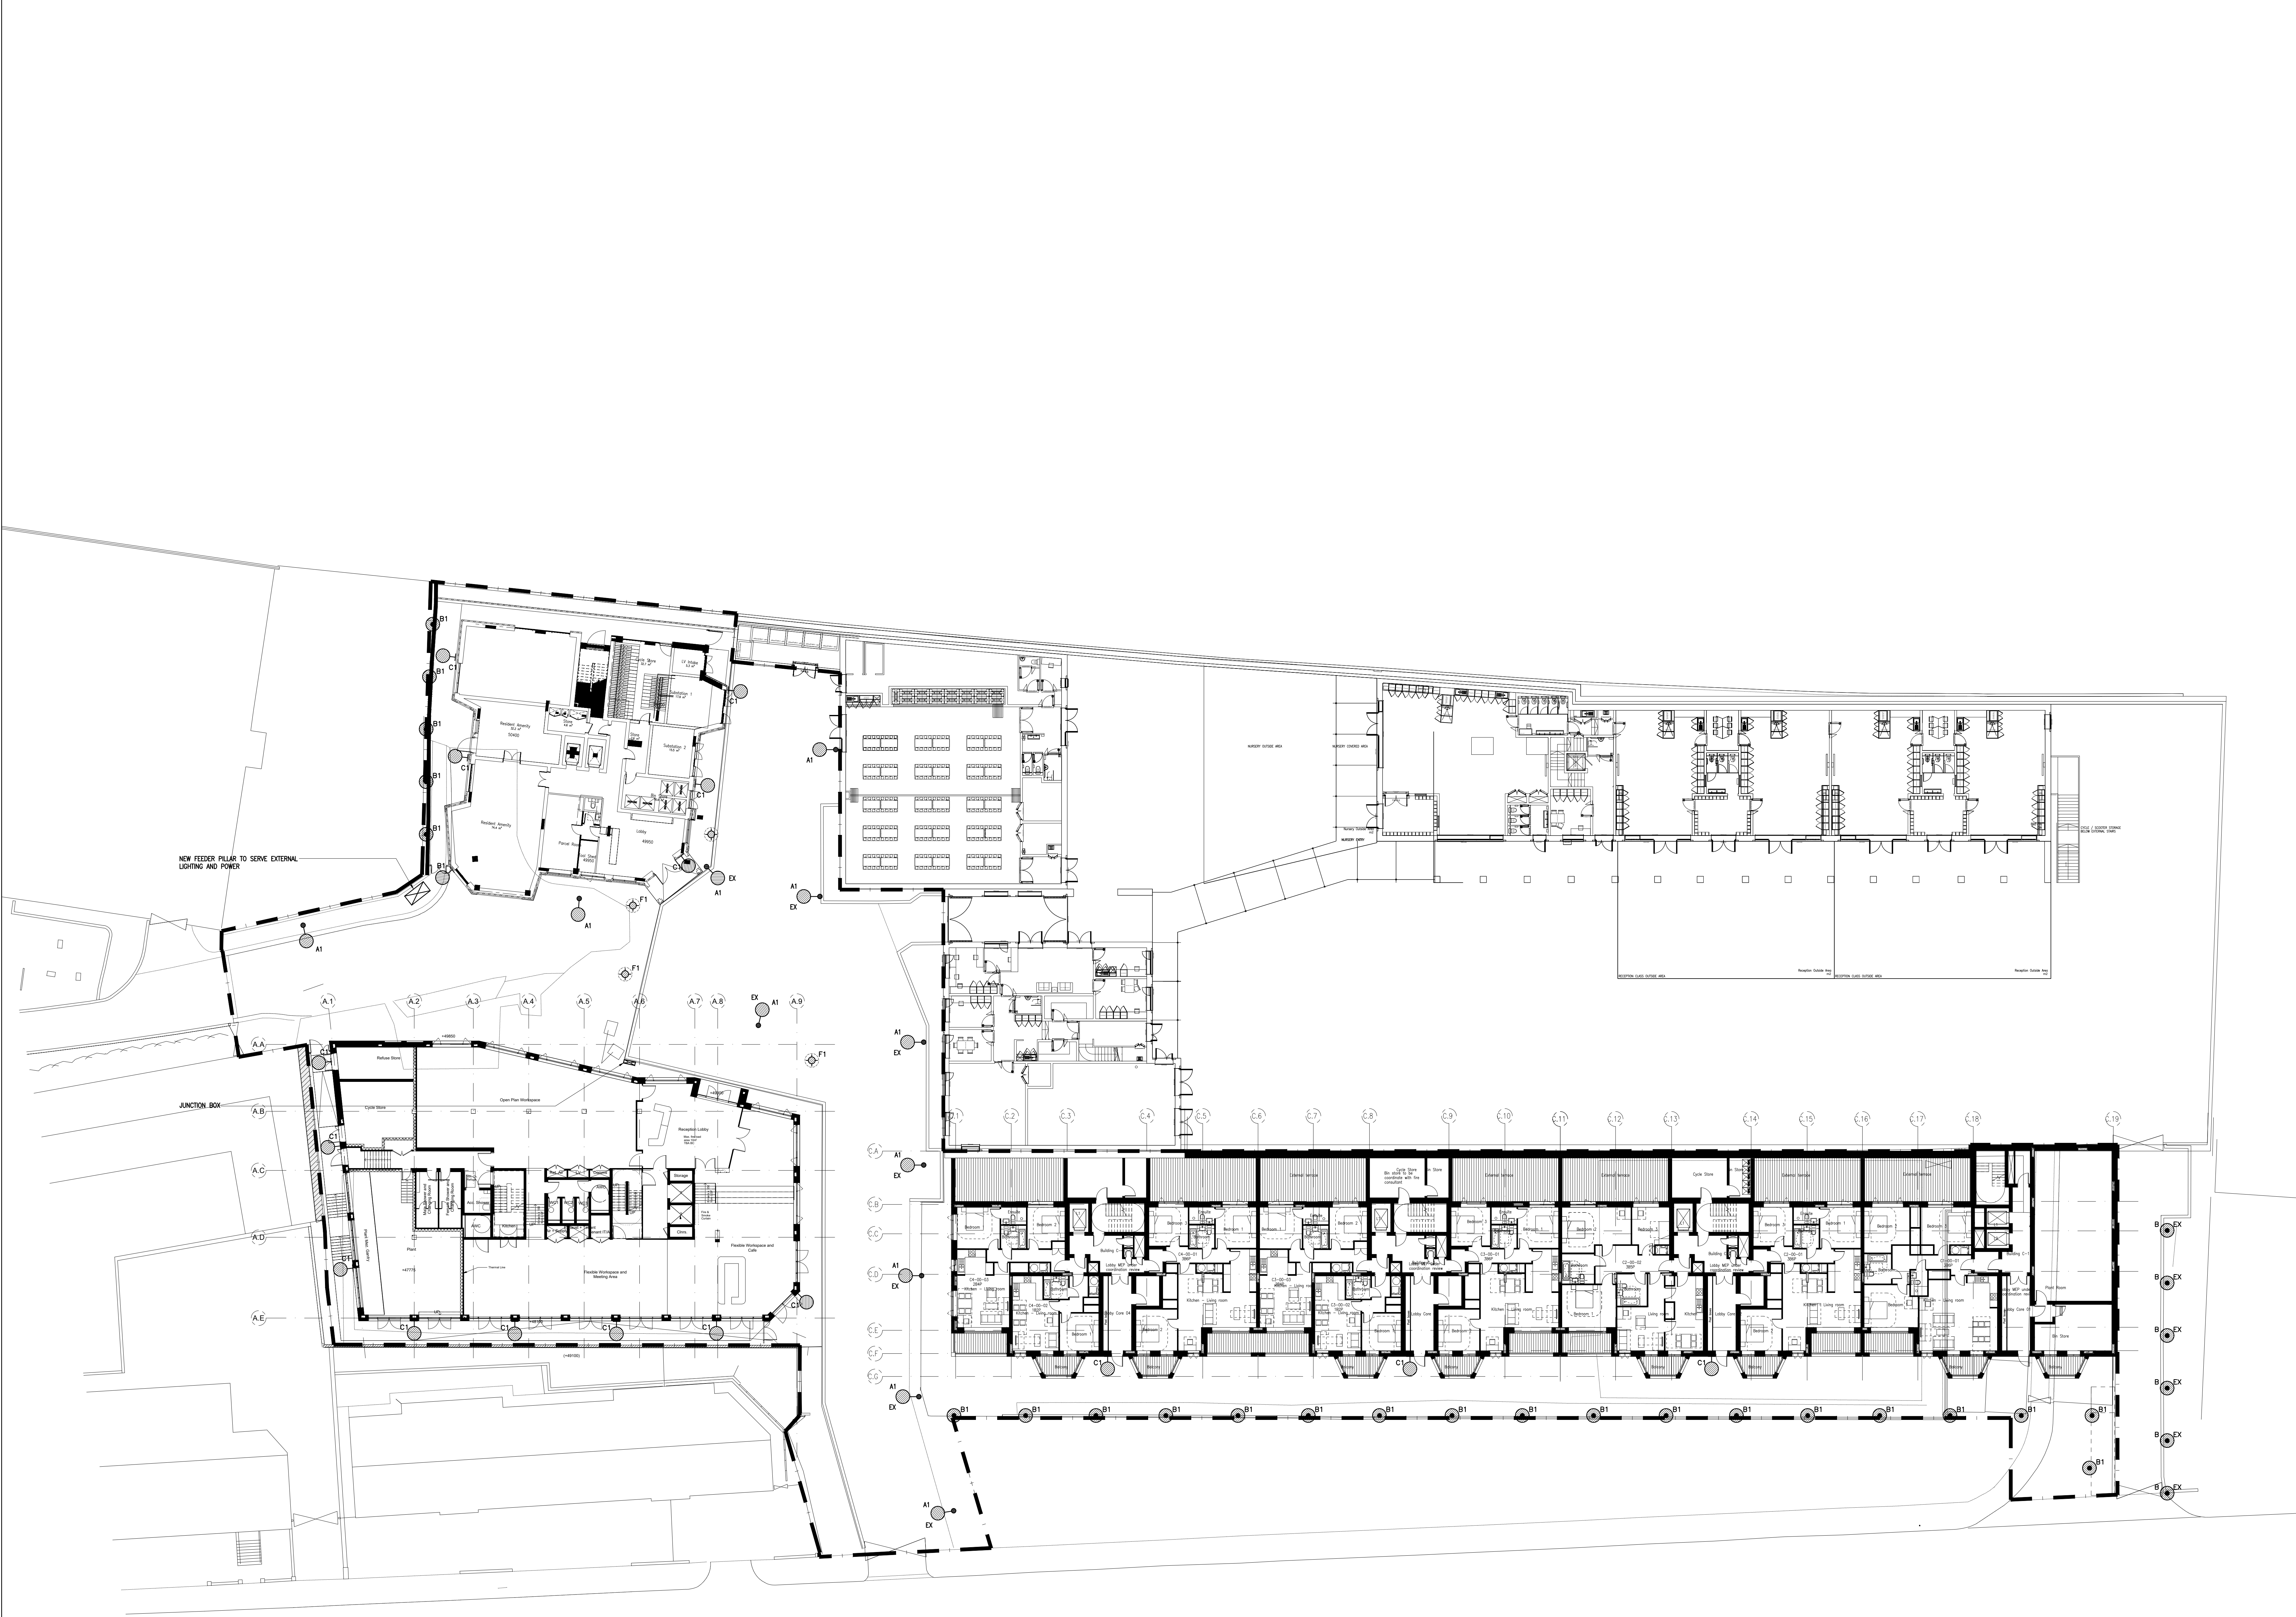

NOTES

- DO NOT SCALE FROM THIS DRAWING USE FIGURED DIMENSIONS ONLY. AND CHECK ALL DIMENSIONS ON SITE.
- ALL DIMENSIONS AND LEVELS TO BE CHECKED ON SITE PRIOR TO COMMENCEMENT ON SITE. ANY DISCREPANCIES SHOULD BE NOTIFIED TO THE RELEVANT PARTIES.
- THIS DRAWING IS TO BE READ IN CONJUNCTION WITH ANY RELEVANT ARCHITECTURAL AND CIVIL DRAWINGS.
- THE CONTRACTOR SHALL ENSURE ALL EXCAVATION WORKS ARE IN LINE WITH THE HEALTH & SAFETY EXECUTIVE GUIDANCE DOCUMENT HS647 AVOIDING DANGER FROM UNDERGROUND SERVICES.
- THE CONTRACTOR SHALL ENSURE THAT THE FINAL LAYOUT OF THE SERVICES IS IN ACCORDANCE WITH THE 'NUG' GUIDELINES ON THE POSITIONING AND COLOUR CODING OF UNDERGROUND UTILITIES APPARATUS.
- EXISTING SERVICES LOCATIONS ARE INDICATIVE. ALL EXISTING SERVICES DRAWINGS TO BE READ IN CONJUNCTION WITH STATUTORY SERVICES ASSET MAPS.
- BURIED DEPTHS ARE TAKEN FROM NUG GUIDELINES.
- ALL DUCTS ARE TO BE 100mm UNLESS SPECIFIED.
- ALL MAINS WATER PIPES WORK IN GROUND TO BE INSTALLED IN (MDPE) BARRIER PIPE.
- ALL WATER PIPE WORK INSTALLED TO BE CARRIED OUT BY (WRAS) APPROVED CONTRACTOR.
- ALL ELECTRICAL SERVICES IN BTLYWHWHYPEROPTIC TO BE DUCTED FULL LENGTH WITH DRAW CABLES.
- WHERE ELECTRICAL CABLE ARE RUNNING UNDER THE BUILDING OR IN THE VOID, STEEL DUCTS SHALL BE LAID.
- WATER MAINS ONLY DUCTED BELOW GROUND FLOOR SLAB.
- ALL SERVICES TO RUN WITHIN THE MAIN COMBINED MAE SERVICES TRENCH WITH REQUIRED MINIMUM SEPARATION DISTANCE BETWEEN THEM.
- CIVIL/STRUCTURAL ENGINEER TO CO-ORDINATE THEIR BELOW GROUND DRAINAGE SERVICES AND Foul INSPECTION CHAMBERS IN LINE WITH THE SERVICES DUCTS AND OTHER BELOW GROUND SERVICES TO AVOID UNNECESSARY CLASHES.

KEY - GENERAL:

- SERVICES AT LOW LEVEL.
- SERVICES BELOW FLOOR.
- SERVICES IN CEILING VOID.
- SERVICES IN VERTICAL (RISER).

H/L - HIGH LEVEL. L/L - LOW LEVEL.
F/A - FROM ABOVE. F/B - FROM BELOW.
T/A - TO ABOVE. T/B - TO BELOW.

KEY - LIGHTING (EXTERNAL):

- BOLLARD LIGHT FITTING.
- EXTERNAL UPLIGHTER - ROUND.
- EXTERNAL UPLIGHTER - SQUARE.
- EXTERNAL CEILING MOUNTED LIGHT FITTING.
- EXTERNAL WALL MOUNTED LIGHT FITTING.
- FLOODLIGHT - EXTERNAL.
- SPOTLIGHT - EXTERNAL.
- EXTERNAL RECESSED WALL LIGHT.
- EXTERNAL SEATING MOUNTED LIGHT FITTING.
- LIGHT SWITCH - EXTERNAL WALL MOUNTED PR.
- LIGHT SWITCH - EXTERNAL CEILING MOUNTED PR.
- JUNCTION BOX / FEEDER PILLAR.
- EX - DENOTES EXISTING.

PRELIMINARY

P1	24.09.21	JM	SK	PRELIMINARY ISSUE
Rev	Date	CAD	Chk	Description

MWL
Mendick Waring Limited
Lymehouse Studios, 30/31 Lyme Street, London NW1 0EE
Tel: 020 8448 9696 Web: www.mwl-group.com
E-Mail: enquiries@mwl-group.com

Client
WEST HAMPSTEAD Ltd.

Architect
BROADWAY MALYAN

Project
**LIDDELL INDUSTRIAL ESTATE
LIDDELL ROAD
LONDON, NW6 2EW**

Drawing
**SITE PLAN
EXTERNAL LIGHTING
SERVICES LAYOUT**

Scale 1:200	Size A0	Engineer SK	Date OCT '20
----------------	------------	----------------	-----------------

Drawing No. 2659-SIT-63	Rev P1
-----------------------------------	------------------