


1 Level B01 - Lecture Theatre Ventilation Plantroom
1 : 50



3 Lecture Theatre Ventilation Plantroom Section
1 : 50

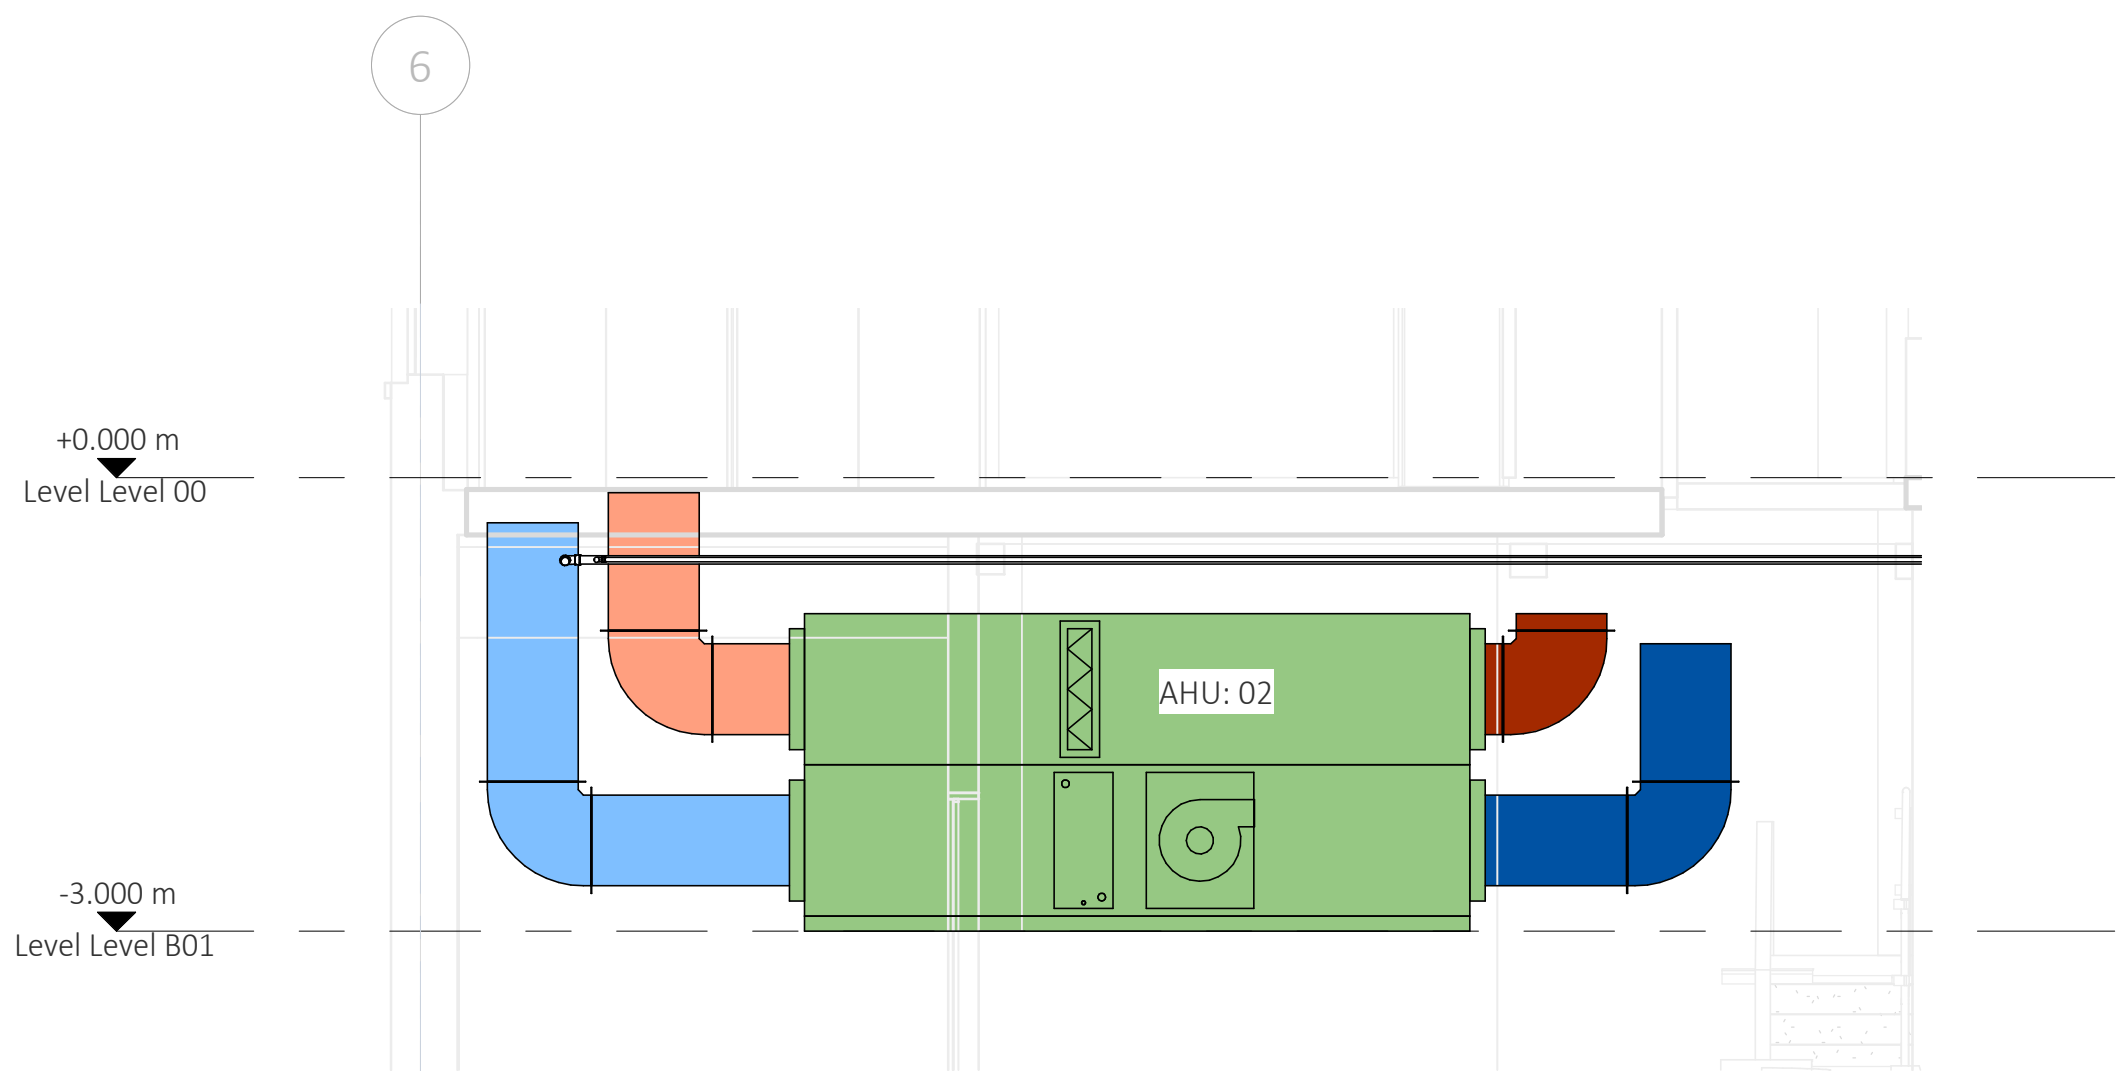

- NOTES
1. All dimensions are to be checked on site before the commencement of works. Any discrepancies are to be reported to the Architect & Engineer for verification. Figured dimensions only are to be taken from this drawing.
 2. This drawing is to be read in conjunction with all relevant engineers' and service engineers' drawings and specifications. This drawing is copyright.
- NOTE: Existing ductwork distribution routes are to be reused where possible

REVISIONS

P02	SUITABLE FOR INFORMATION				
S2	IF	22/05/20	MH	22/05/20	MH
P01	SUITABLE FOR INFORMATION				
S2	JT	07/05/20	AB	07/05/20	MH

REV REVISION NOTES/COMMENTS					
STA.	DRAWN BY	DATE	CHECKED BY	DATE	APPROVED BY



5-7 Tanner Street
London
SE1 3LE
t: +44(0)203 846 8456
e: london@hydrock.com

CLIENT

Birkbeck

PROJECT

Birkbeck, Gordon Square

TITLE

Mechanical Services
Lecture Theatre Ventilation Plantroom
Drawing
Basement
-

HYDROCK PROJECT NO.	SCALE @ A1
C-14299	1:50

STATUS DESCRIPTION	STATUS
SUITABLE FOR INFORMATION	S2

DRAWING NO.	REVISION
14299-HYD-XX-B1-DR-M-8311	P02