
 
 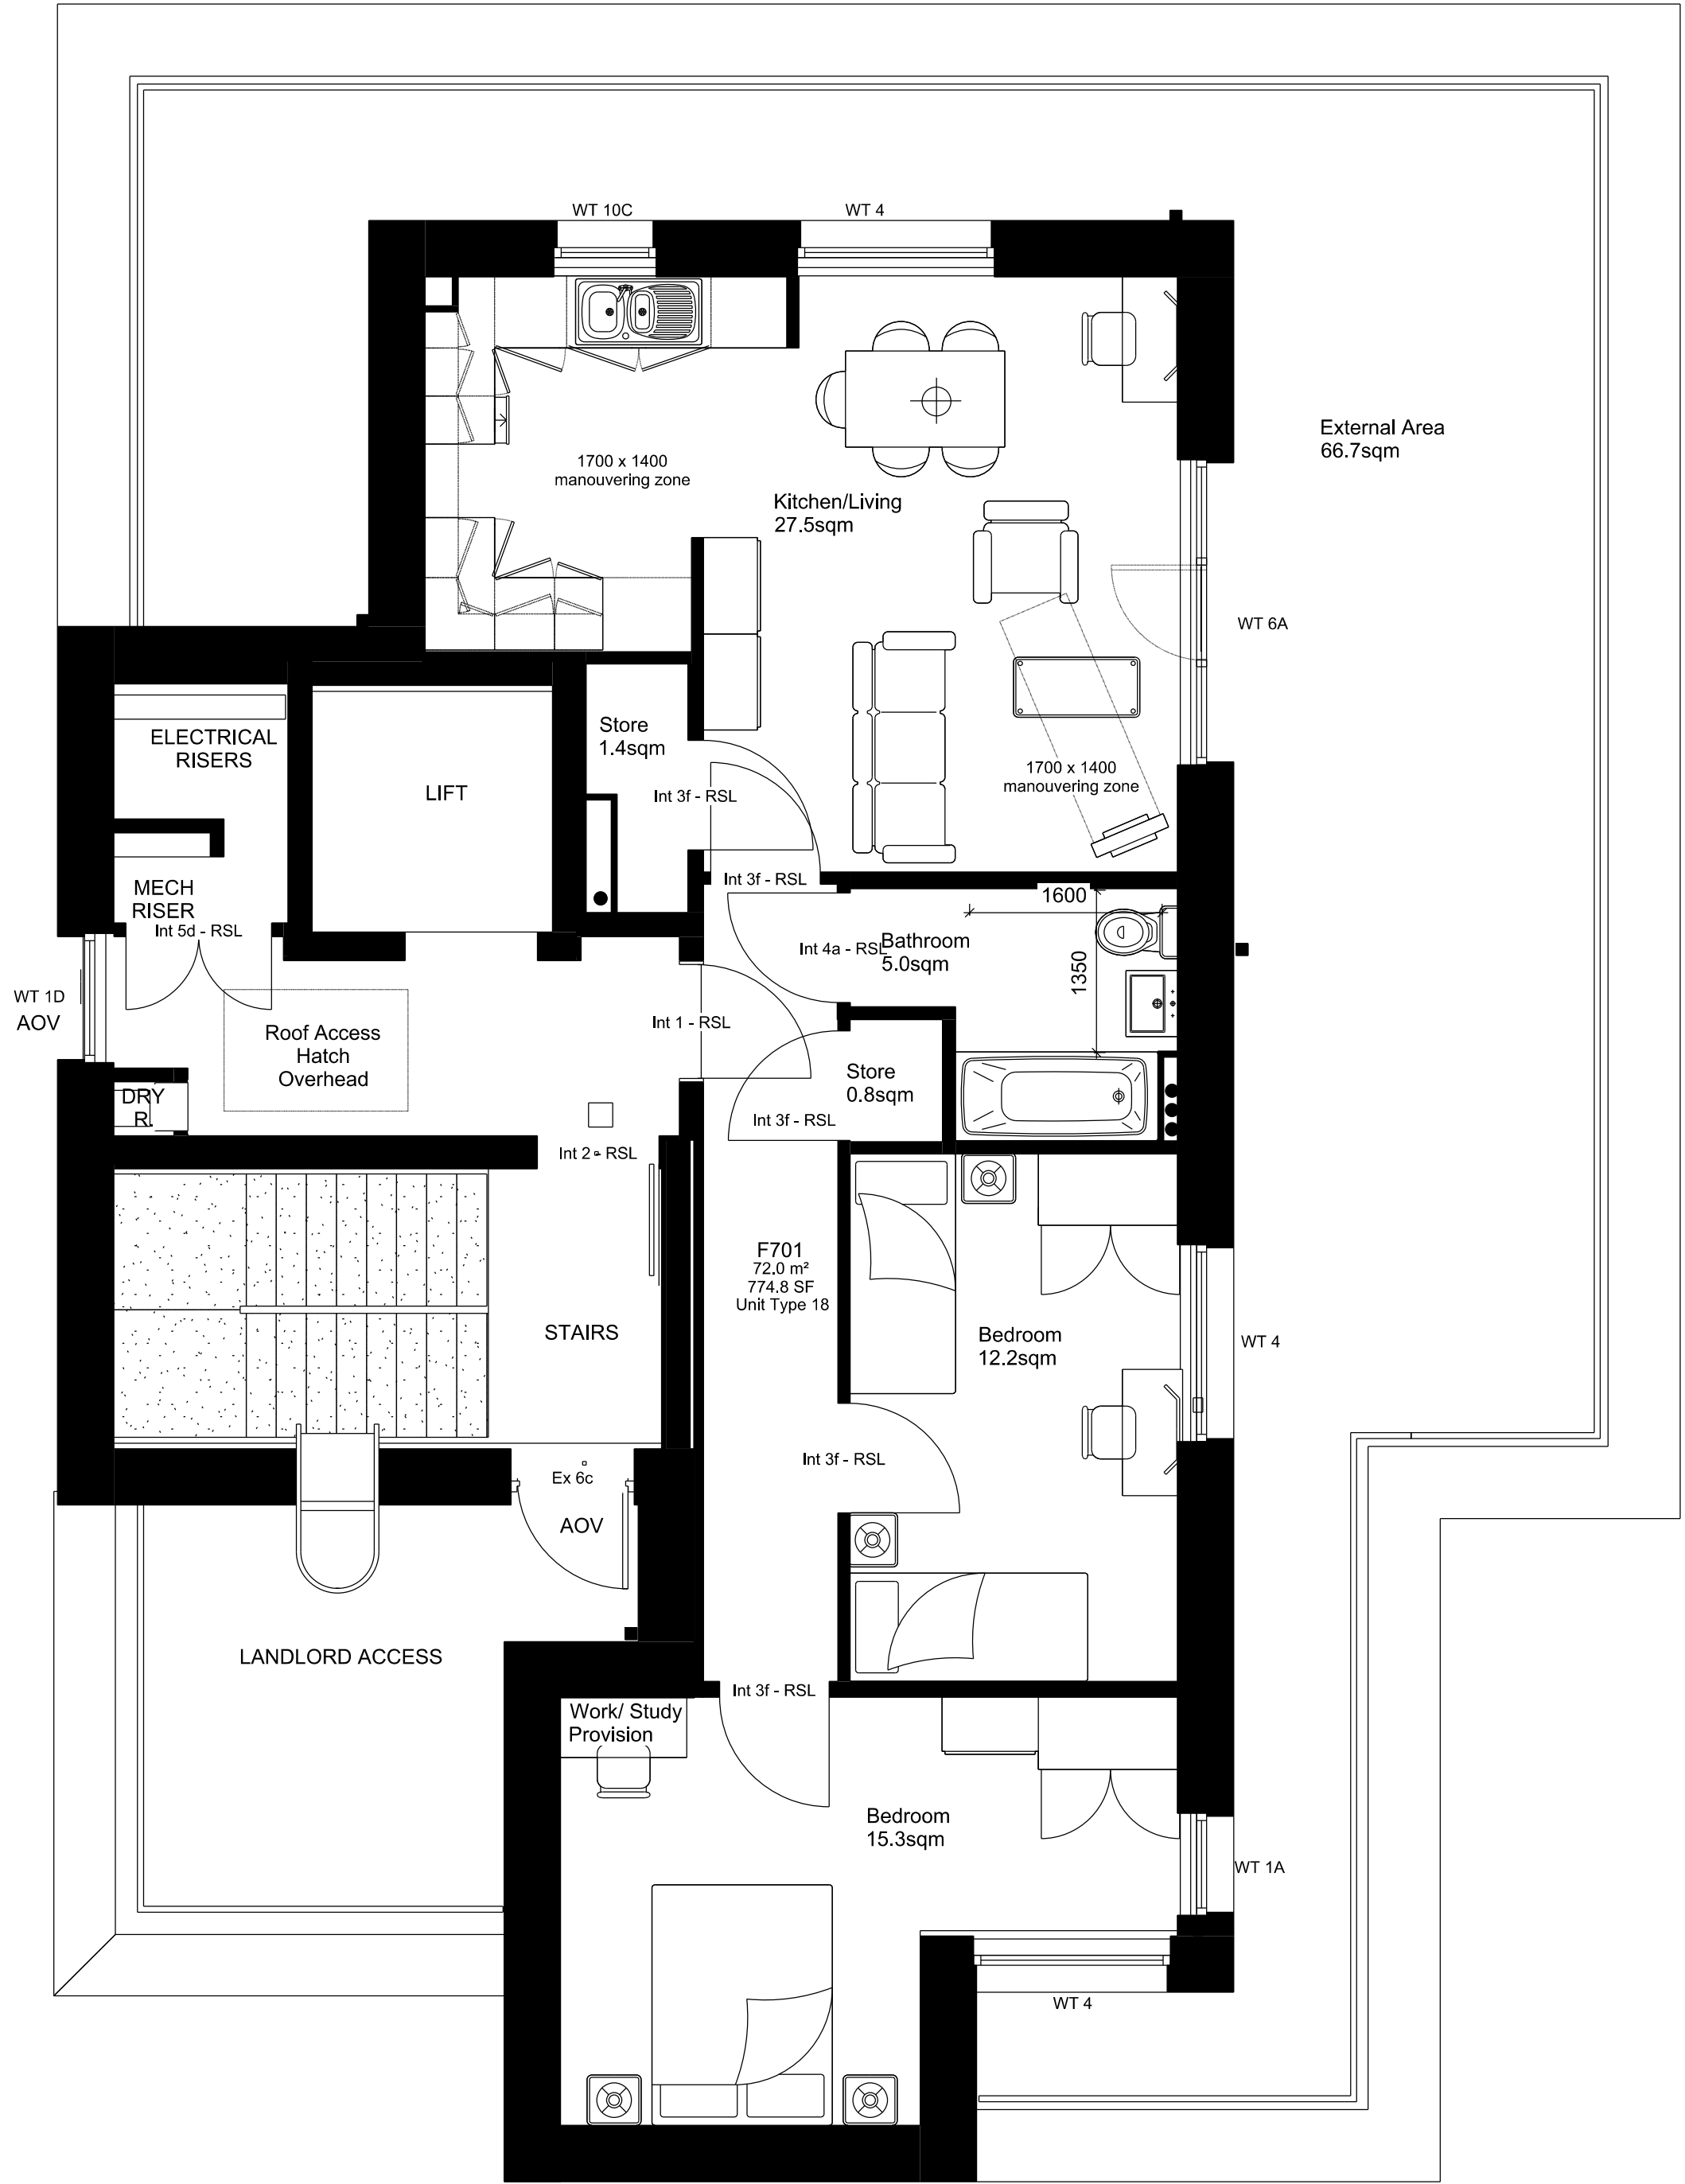


West Hampstead Square - Key Plan
NTS

BUILDING F (LILY BUILDING)



FOR PLANNING APPROVAL



1 Block F - Seventh Floor Plan
Scale 1:100 at A3

<div>COMMON GROUND WORKSHOP</div> <div>COPYRIGHT AND NOTES</div> <div>DO NOT SCALE FROM THIS DRAWING. ALL DIMENSIONS TO BE VERIFIED ON SITE BY CONTRACTOR PRIOR TO COMMENCEMENT OF ANY SHOP DRAWINGS AND ANY WORKS ON SITE. REPORT ALL DISCREPANCIES TO THE ARCHITECT IMMEDIATELY.</div> <div>THIS DRAWING TO BE READ IN CONJUNCTION WITH ALL RELATED ARCHITECT/ENGINEERS DRAWINGS / DETAILS AND ALL OTHER RELEVANT INFORMATION</div>	<div>COMMON GROUND WORKSHOP LTD</div> <div>The Common E2</div> <div>53 Old Bethnal Green Rd, London, E2 6QA</div> <div>T 077 65257123</div> <div>info@commongroundworkshop.co.uk</div> <div>www.commongroundworkshop.co.uk</div>	AMENDMENTS				CONSULTANT(S)	ADDITIONAL NOTES:	<div>This drawing is issued in DWG format; this is an uncontrolled version issued to enable the recipient to prepare their own drawings for which they are solely responsible. It is based on background information current at the time of issue. No liability is accepted for any such alterations or additions to or discrepancies arising out of changes to such background information which occur after it is issued. Contractor to provide Structural Engineering/ design.</div> <div>Do not scale from this drawing.</div> <div>Report any errors, contradictions, & omissions to the architect as soon as possible.</div>	CLIENT(S)	PROJECT	DRAWING TITLE(S)	SCALE	DRAWN	CHECKED		
		REV	DATE	DESCRIPTION	BY	Project Manager -	<div>This drawing is to be read in conjunction with all relevant documents.</div> <div>This drawing is to be read in conjunction with all Engineer's drawings. Contractor to provide Structural Engineering/ design.</div>					WEST HAMPSTEAD SQUARE - DECKING REPLACEMENT	EXISTING BLOCK F (LILY BUILDING) - SEVENTH FLOOR PLAN	1:100 @A3	CC	MS
		A	27.08.2021	FOR PLANNING APPROVAL	CC	Structural Engineer -								PROJECT NUMBER	DATE	
						MEP Services Engineer -								CGW-BDR-WHS-0114	AUG 2021	
						Planning Consultant -								DRAWING NUMBER	REVISION	
				Daylight / Sunlight Consultant -	Cost Consultant -	BDR-WHS-PA-A-BF-1008		A								