
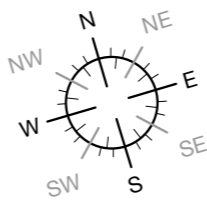


THE GROUND FLOOR DOES NOT FORM PART OF THIS APPLICATION

DOWNSIDE CRESCENT

KEY:

- socket outlet (lighting)
- fuse + switch
- double socket outlet (switched)
- single pole one way switch
- pendant light
- lighting points
- multiple spotlights
- wall lights
- wall lights
- telephone socket
- Temperature Thermostat
- floor to cill, cill to head window height
- ceiling Level
- Floor Level

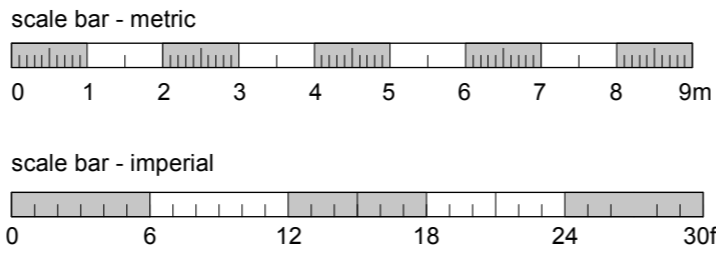

CAD Surveys Ltd.
Suite 2 KPC House
Canterbury Road
Willesborough
Ashford
TN24 0BP

www.cadsurveys.co.uk

01233 635089

Project : 9 Downside Crescent London NW3 2AN	Drawn by : SE
Drawing title : Existing Ground Floor and Site Plan	
Scale: 1:100@A3/1:50@A1	Date : 05/10/2021
Ref : 1122-S01-01	