


- NOTES**
- ALL DRAWINGS SHALL BE READ IN CONJUNCTION WITH LONG & PARTNERS DRAWINGS, SCHEDULES & SPECIFICATION.
 - FOR DETAILS, ELEVATIONS & EXACT SETTING OUT OF WALL MOUNTED ACCESSORIES, REFER TO THE ARCHITECTS LAYOUT.
 - THE ELECTRICAL SERVICES WORKS SHALL BE CARRIED OUT IN ACCORDANCE WITH THE LONG & PARTNER'S SPECIFICATION.
 - ALL EMERGENCY LUMINAIRES TO BE CONNECTED TO KLUX MODULE LOCATED WITHIN THE CEILING VOID. THE CIRCUIT TO BE DERIVED FROM THE LOCAL LIGHTING CIRCUIT.
 - ALL LIGHTING CONTROL LOCATIONS ARE INDICATIVE AND THE MANUFACTURERS INSTALLATION INSTRUCTIONS SHOULD ALWAYS BE CHECKED.


- LEGEND**
- A 1000mm LINEAR RECESSED LED LUMINAIRE
 - A1 1500mm LINEAR RECESSED LED LUMINAIRE
 - A1/S 1500mm SUSPENDED LINEAR LED LUMINAIRE
 - A2 2000mm LINEAR RECESSED LED LUMINAIRE
 - A2/S 3000mm LINEAR SURFACE MOUNTED LED LUMINAIRE
 - A3 1200mm SUSPENDED MOUNTED LED LUMINAIRE
 - A4 2274mm SUSPENDED MOUNTED LED LUMINAIRE TUMBLE BALLAST
 - OB RECESSED CIRCULAR LED DOWNLIGHT
 - OB1 RECESSED CIRCULAR LED DOWNLIGHT
 - OB2 RECESSED CIRCULAR LED DOWNLIGHT
 - OB3 RECESSED CIRCULAR LED DOWNLIGHT
 - OB4 RECESSED CIRCULAR LED DOWNLIGHT
 - OC RECESSED CIRCULAR LED DOWNLIGHT
 - OC1 SUSPENDED CIRCULAR LED DOWNLIGHT
 - OC2 SUSPENDED LED PENDANT
 - OC3 SUSPENDED LED PENDANT
 - IP65 RATED WALL MOUNTED LUMINAIRE
 - L1 & L2 IP65 LINEAR SURFACE MOUNTED LED LUMINAIRE
 - EM1 SURFACE MOUNTED NON MAINTAINED EMERGENCY DOWNLIGHT
 - EM2 RECESSED CIRCULAR NON MAINTAINED EMERGENCY DOWNLIGHT
 - EM3 WALL MOUNTED NON MAINTAINED TWIN SPOTLIGHT EMERGENCY LUMINAIRE
 - EXIT R RECESSED MAINTAINED ILLUMINATED LED EMERGENCY EXIT SIGN C/W RUNNING MAN PICTOGRAM
 - EXIT SS SURFACE MOUNTED MAINTAINED ILLUMINATED LED EMERGENCY EXIT SIGN C/W RUNNING MAN PICTOGRAM
 - EXIT S IP65 RATED SURFACE MOUNTED MAINTAINED ILLUMINATED LED EMERGENCY EXIT SIGN C/W RUNNING MAN PICTOGRAM
 - IP65 RATED SURFACE MOUNTED LINEAR LED LUMINAIRE
 - OH RECESSED CIRCULAR LED DOWNLIGHT
 - EXT IP65 EXTERNAL WALL MOUNTED LUMINAIRE
 - AD RECESSED MOUNTED ABSENCE DETECTOR COMBINED WITH DAYLIGHT LINK
 - PD RECESSED MOUNTED PRESENCE DETECTOR COMBINED WITH DAYLIGHT LINK
 - PD1 SURFACE MOUNTED PRESENCE DETECTOR
 - PD2 SURFACE MOUNTED HIGH BAY PRESENCE DETECTOR COMBINED WITH DAYLIGHT LINK
 - WALL MOUNTED MICROWAVE PRESENCE DETECTOR
 - IP65 EXTERNAL WALL MOUNTED PHOTOCELL SENSOR
 - LCM PLUGGABLE DALI LIGHTING CONTROL MODULE WITH FUSED CONNECTION UNIT MOUNTED ADJACENT
 - PR8000 EXOR LIGHTING CONTROL POWER SUPPLY UNIT
 - EM PANEL ZUMTOBEL EMERGENCY LIGHTING CONTROL PANEL
 - LIGHT SWITCH
 - RETRACTABLE LIGHT SWITCH ('X' DENOTES NO. OF GANGS)
 - INTERMEDIATE LIGHT SWITCH
 - SS WALL MOUNTED LIGHTING CONTROL SCENE SELECT PLATE
 - CV DENOTES ITEM LOCATED WITHIN CEILING VOID
 - WP DENOTES WEATHERPROOF ITEMS

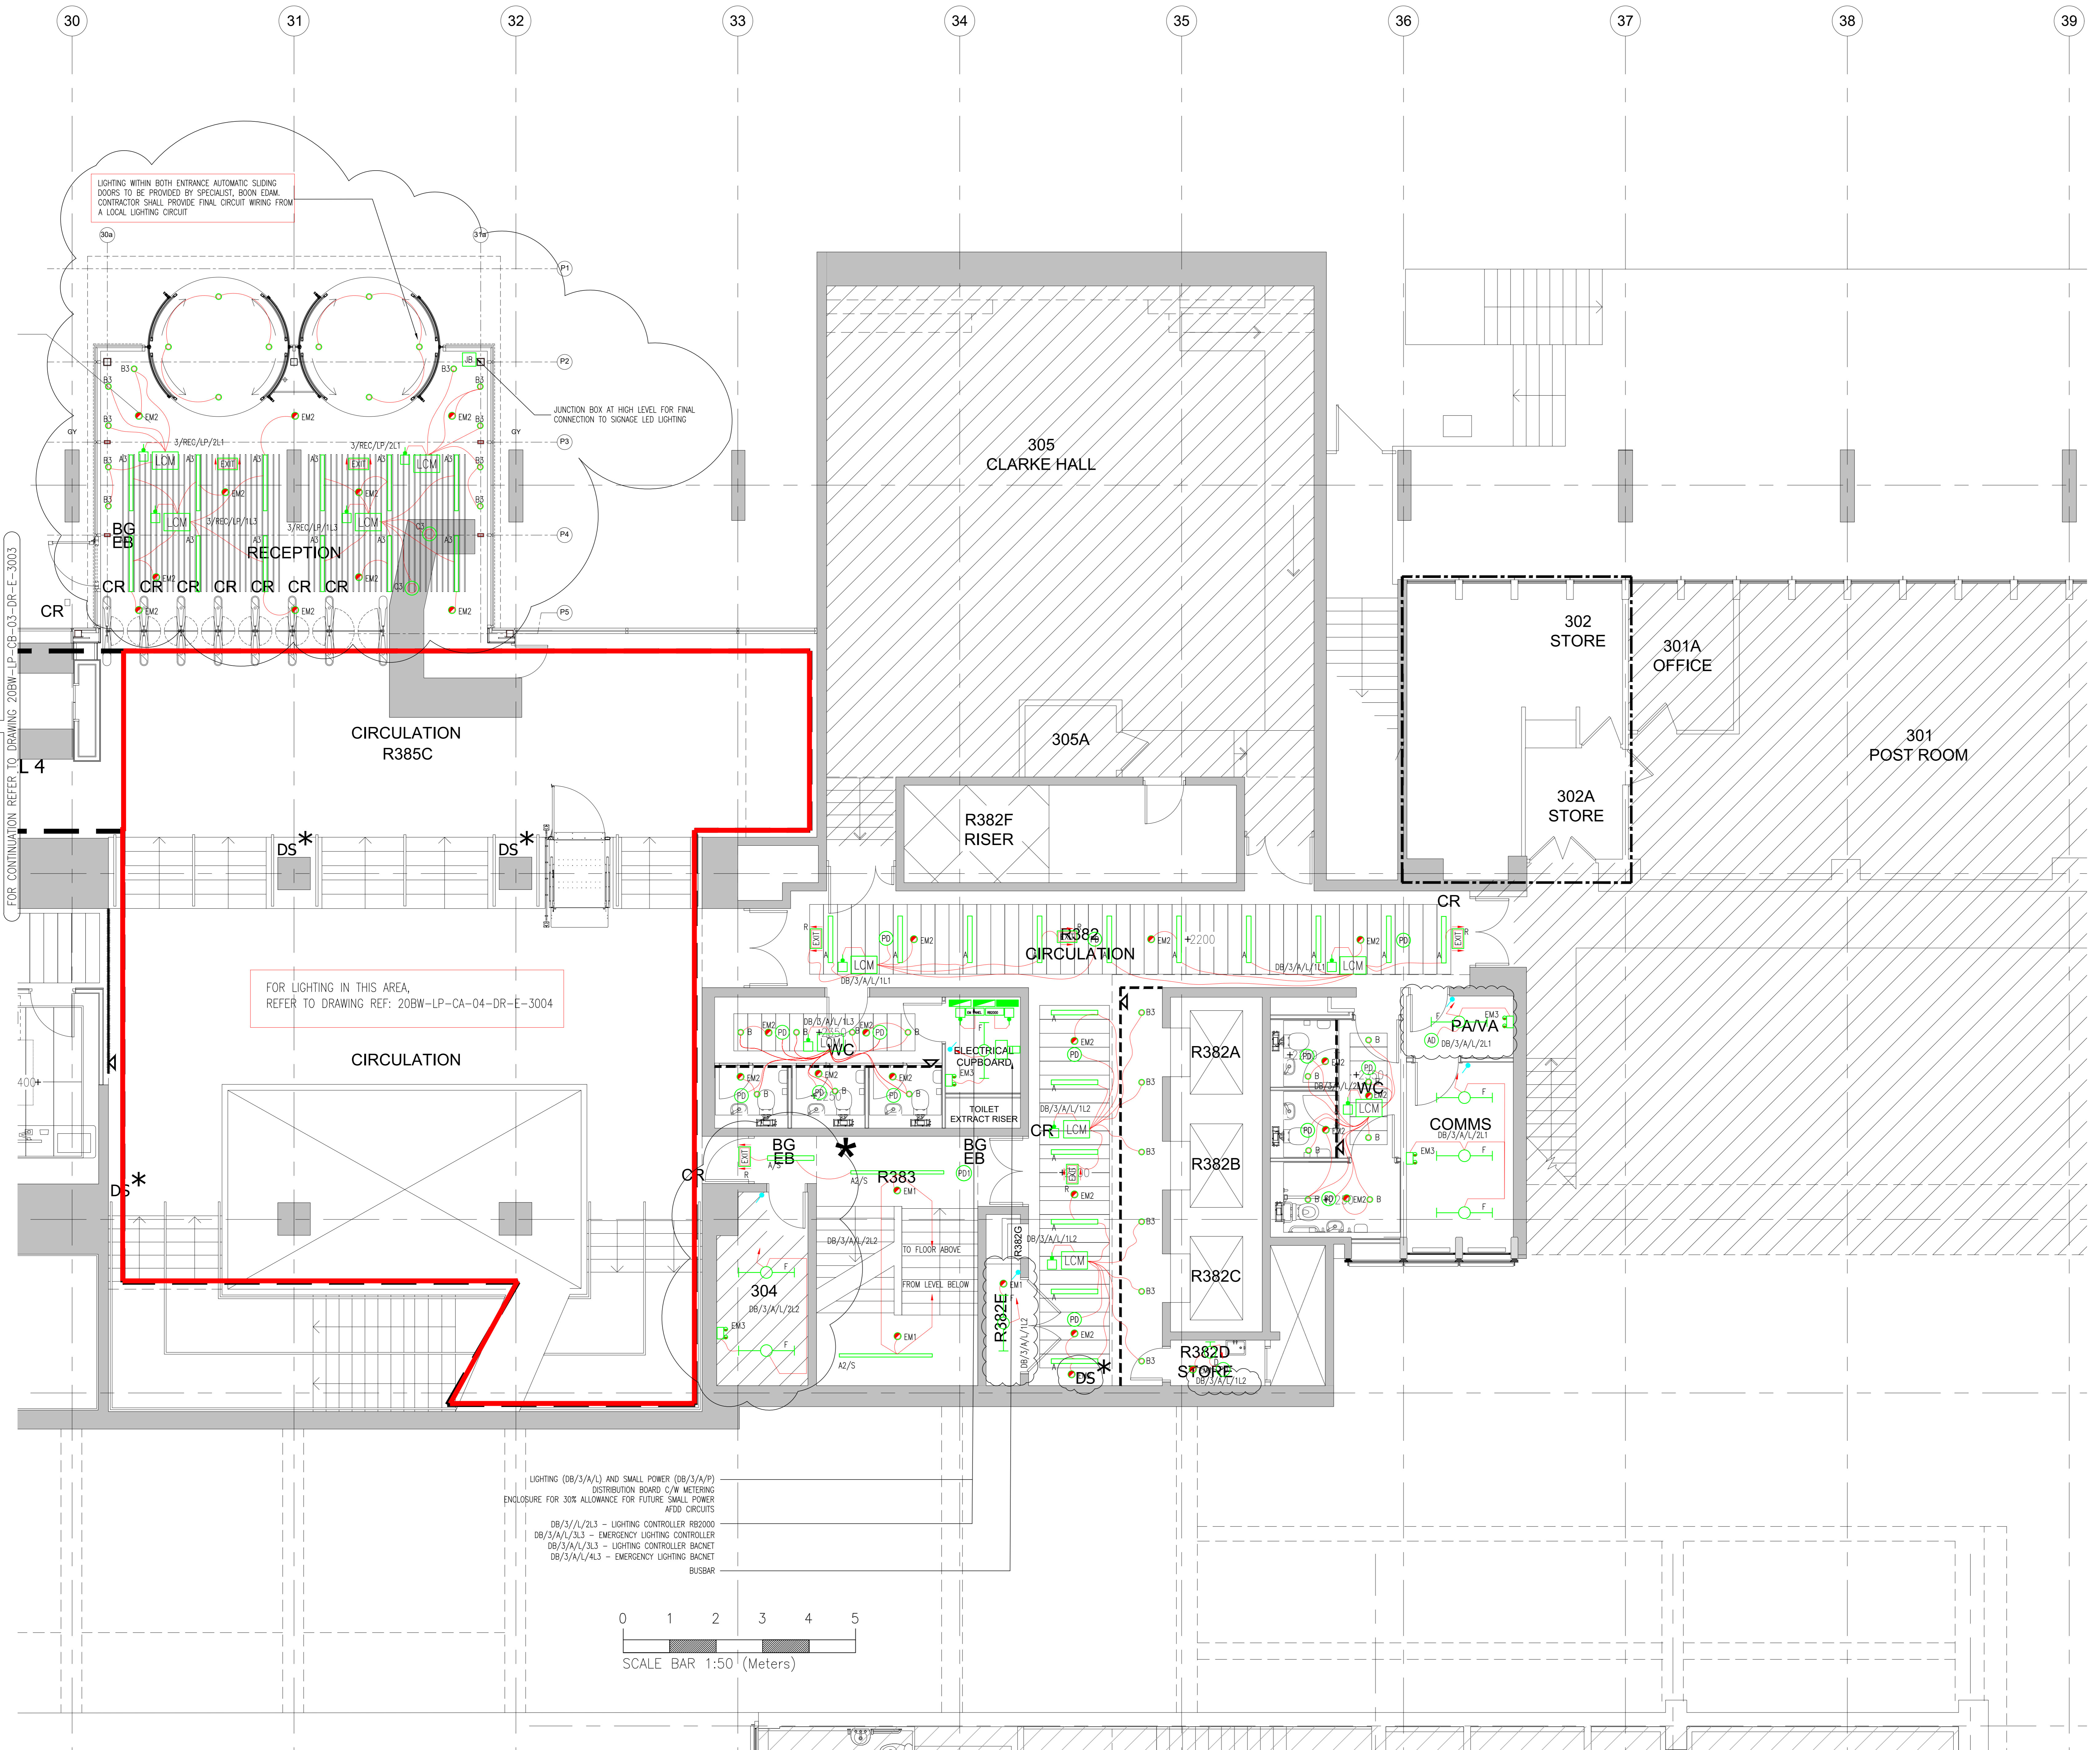

FOR CONTINUATION REFER TO DRAWING 20BW-LP-CB-03-DR-E-3003

FOR LIGHTING IN THIS AREA, REFER TO DRAWING REF: 20BW-LP-CA-04-DR-E-3004

LIGHTING (DB/3/A/L) AND SMALL POWER (DB/3/A/P) (DISTRIBUTION BOARD) C/W METERING ENCLOSURE FOR 30% ALLOWANCE FOR FUTURE SMALL POWER APFD CIRCUITS
 DB/3/A/L/2/L3 - LIGHTING CONTROLLER RIB000
 DB/3/A/L/3/L3 - EMERGENCY LIGHTING CONTROLLER
 DB/3/A/L/3/L3 - LIGHTING CONTROLLER BACNET
 DB/3/A/L/4/L3 - EMERGENCY LIGHTING BACNET
 BUSBAR

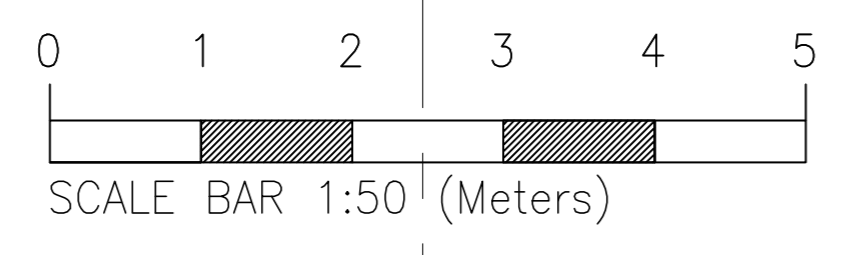

Rev	Date	Description	Drawn
8	01.07.2020	STAGE 4 FINAL ISSUE	CAD
7	19.06.2020	INCORPORATING COMMENTS REVISIT TO SUIT NEW ARCHITECTS GA	CAD
6	15.05.2020	STAGE 4 ISSUE RECEPTION	CAD
5	07.05.2020	STAGE 4 ISSUE RECEPTION	CAD
4	27.04.2020	STAGE 4 DRAFT ISSUE RECEPTION	CAD
3	02.04.2020	STAGE 4 ISSUE	CAD
2	20.03.2020	DRAFT STAGE 4 ISSUE	CAD
1	13.12.19	STAGE 3 ISSUE	CAD
0	22.11.19	STAGE 3 DRAFT ISSUE	CAD

Issue status

STAGE 4

Project: UCL IOE, 20 BEDFORD WAY PHASE 2

Title: LEVEL 3 CORE A LIGHTING LAYOUT

Scale: 1:50@A0

Designed By: SN

Checked by: PEC

Date: NOV 19

