

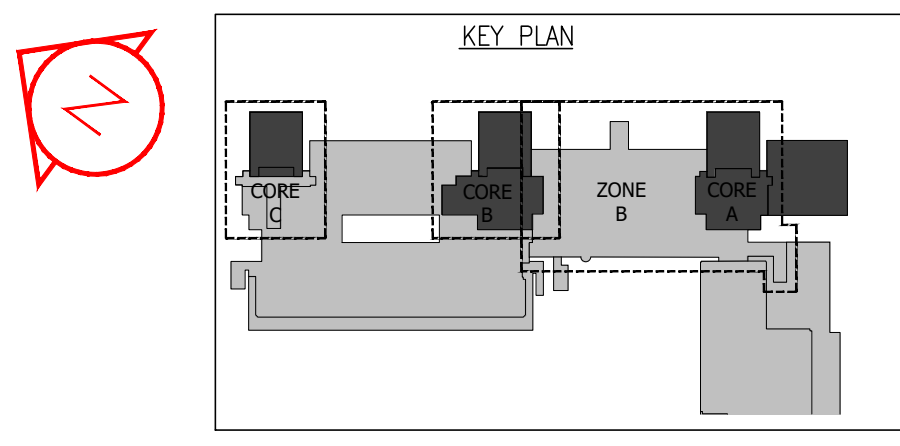


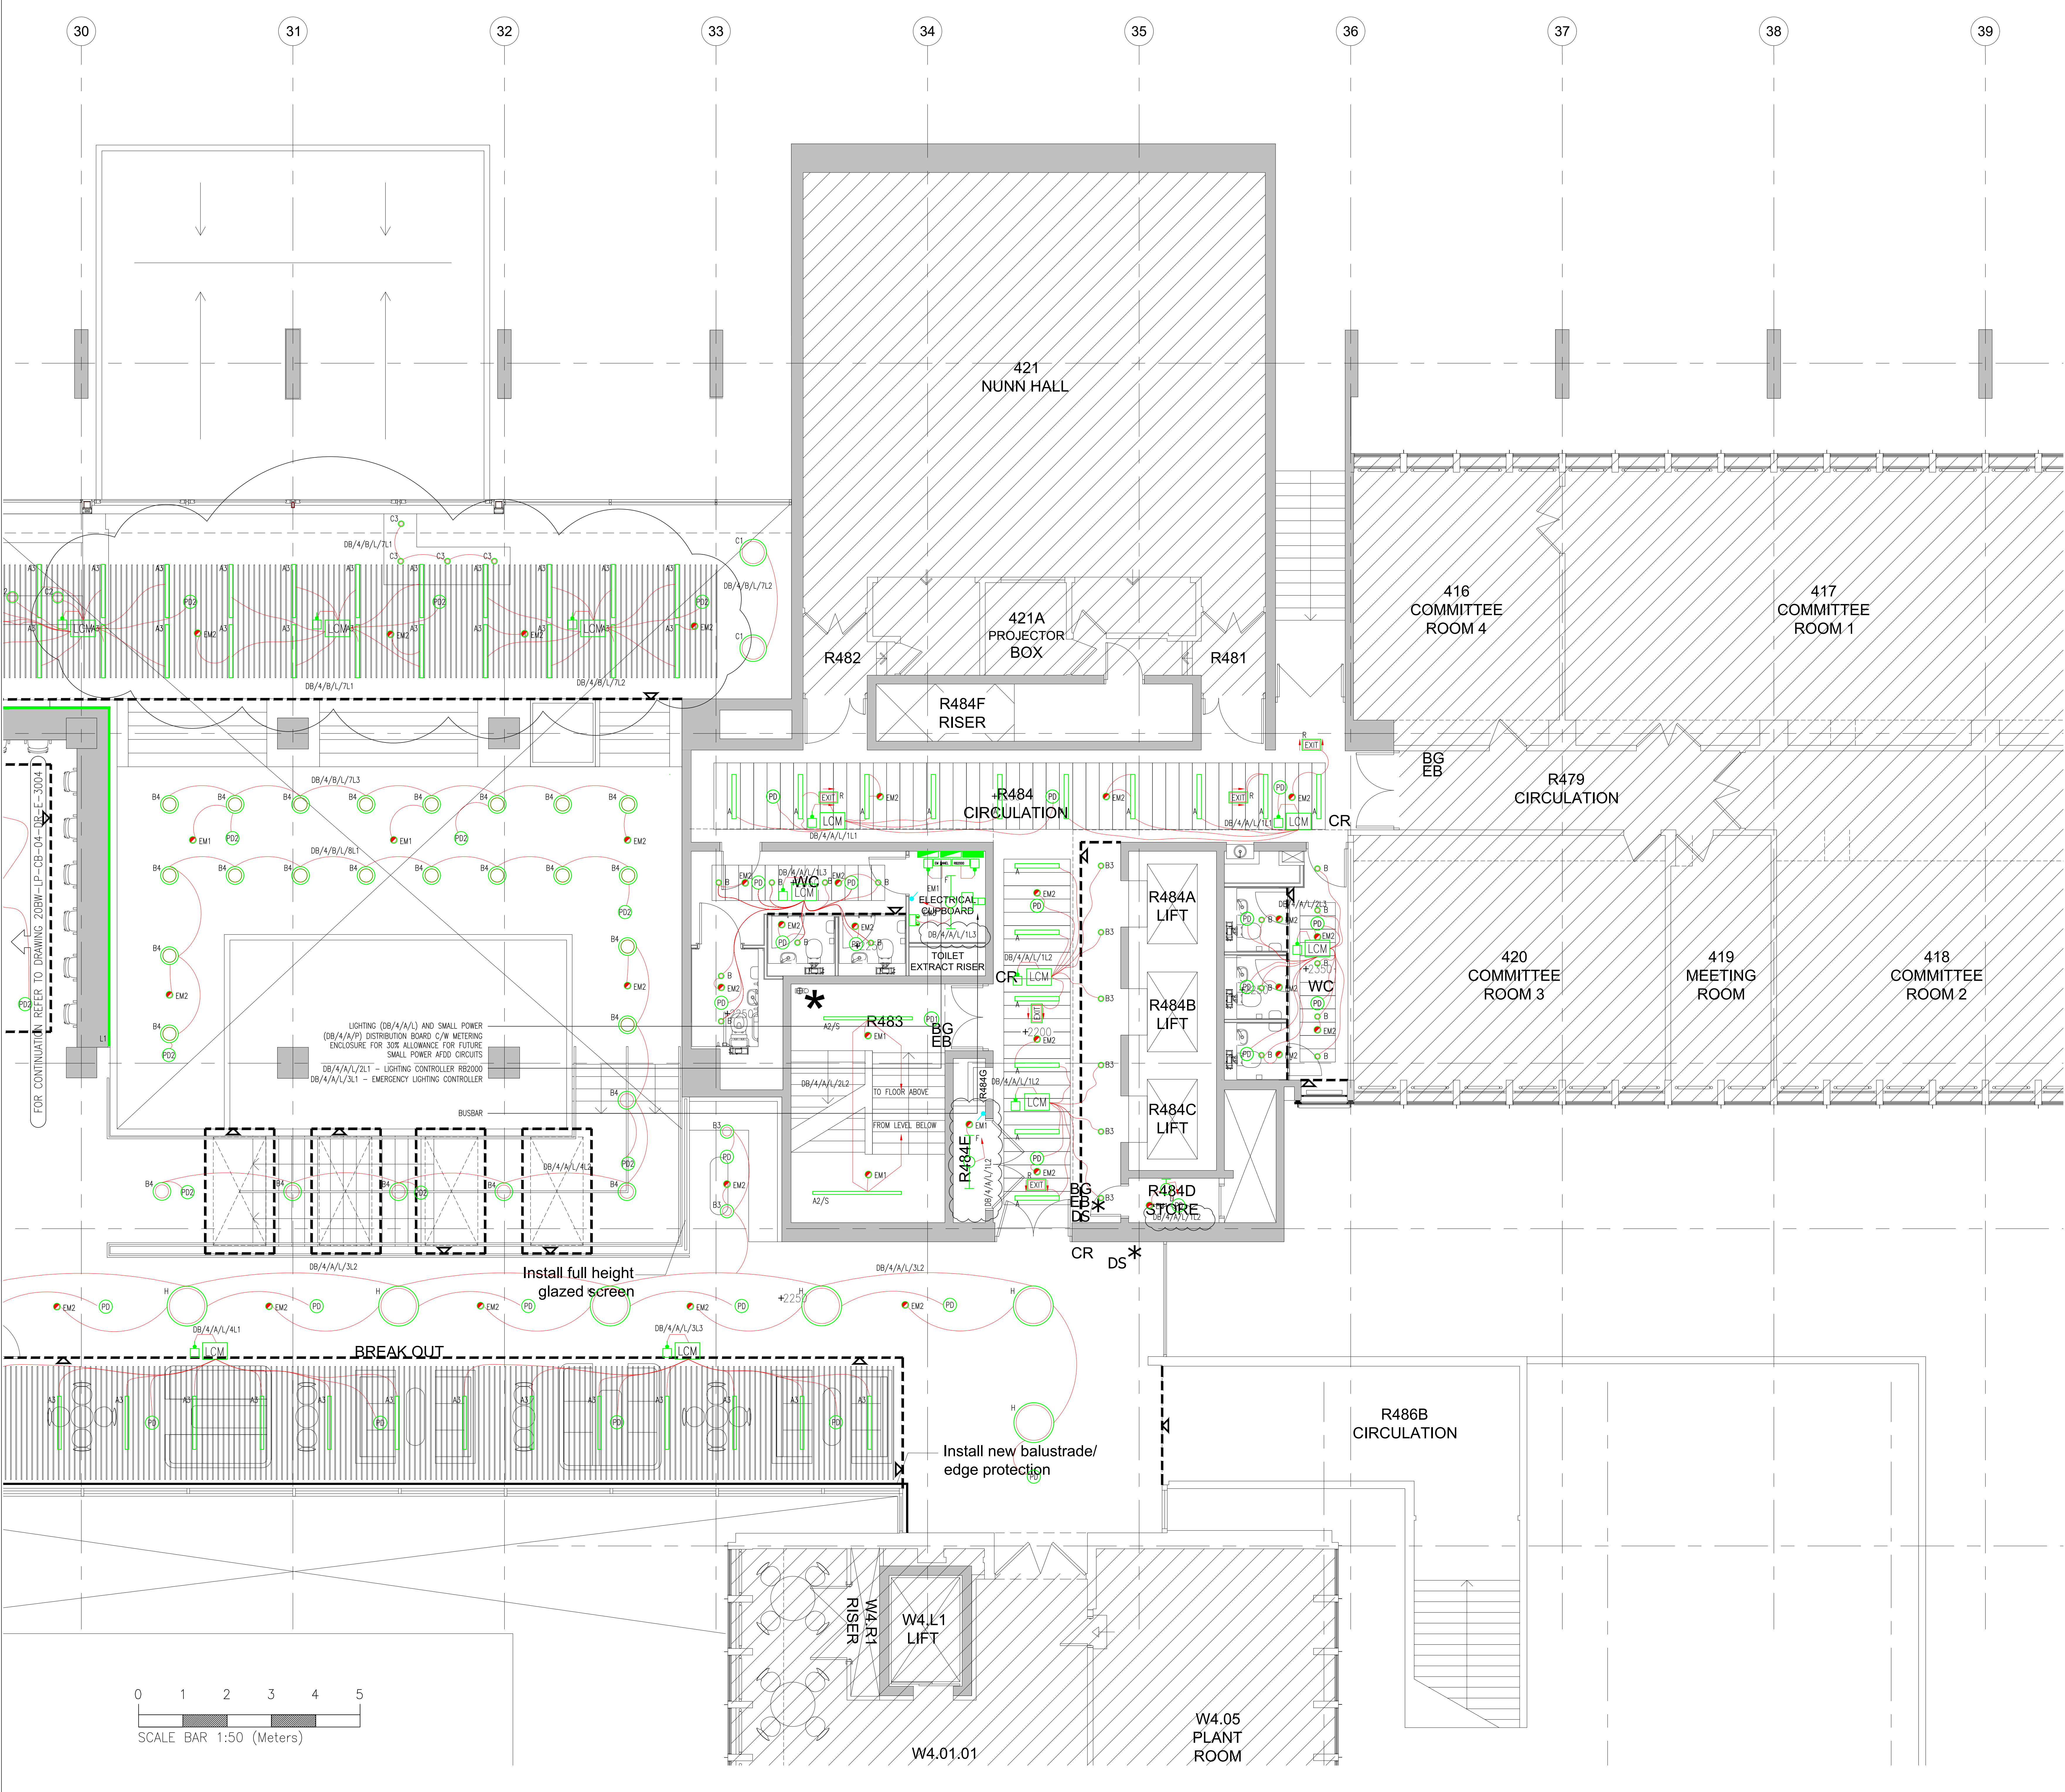

- NOTES
1. ALL DRAWINGS SHALL BE READ IN CONJUNCTION WITH LONG & PARTNERS DRAWINGS, SCHEDULES & SPECIFICATION.
 2. FOR DETAILS, ELEVATIONS & EXACT SETTING OUT OF WALL MOUNTED ACCESSORIES, REFER TO THE ARCHITECTS LAYOUT.
 3. THE ELECTRICAL SERVICES WORKS SHALL BE CARRIED OUT IN ACCORDANCE WITH THE LONG & PARTNER'S SPECIFICATION.
 4. ALL EMERGENCY LUMINAIRES TO BE CONNECTED TO KLUK MODULE LOCATED WITHIN THE CEILING VOID. THE CIRCUIT TO BE DERIVED FROM THE LOCAL LIGHTING CIRCUIT
 5. ALL LIGHTING CONTROL LOCATIONS ARE INDICATIVE AND THE MANUFACTURER'S INSTALLATION INSTRUCTIONS SHOULD ALWAYS BE CHECKED

- LEGEND
- A 1000mm LINEAR RECESSED LED LUMINAIRE
 - A1 1500mm LINEAR RECESSED LED LUMINAIRE
 - A1/S 1500mm SUSPENDED LINEAR LED LUMINAIRE
 - A2 2000mm LINEAR RECESSED LED LUMINAIRE
 - A2/S 3000mm LINEAR SURFACE MOUNTED LED LUMINAIRE
 - A3 1200mm SUSPENDED MOUNTED LED LUMINAIRE
 - A4 2274mm SUSPENDED MOUNTED LED LUMINAIRE TUNABLE BALLAST
 - B RECESSED CIRCULAR LED DOWNLIGHT
 - B1 RECESSED CIRCULAR LED DOWNLIGHT
 - B2 RECESSED CIRCULAR LED DOWNLIGHT
 - B3 RECESSED CIRCULAR LED DOWNLIGHT
 - B4 RECESSED CIRCULAR LED DOWNLIGHT
 - C RECESSED CIRCULAR LED DOWNLIGHT
 - C1 SUSPENDED CIRCULAR LED DOWNLIGHT
 - C2 SUSPENDED LED PENDANT
 - C3 SUSPENDED LED PENDANT
 - D IP65 RATED WALL MOUNTED LUMINAIRE
 - L1 & L2 IP65 LINEAR SURFACE MOUNTED LED LUMINAIRE
 - EM1 SURFACE MOUNTED NON MAINTAINED EMERGENCY DOWNLIGHT
 - EM2 RECESSED CIRCULAR NON MAINTAINED EMERGENCY DOWNLIGHT
 - EM3 WALL MOUNTED NON MAINTAINED TWIN SPOTLIGHT EMERGENCY LUMINAIRE
 - EXIT R RECESSED MAINTAINED ILLUMINATED LED EMERGENCY EXIT SIGN C/W RUNNING MAN PICTOGRAM
 - EXIT SS SURFACE MOUNTED MAINTAINED ILLUMINATED LED EMERGENCY EXIT SIGN C/W RUNNING MAN PICTOGRAM
 - EXIT S IP RATED SURFACE MOUNTED MAINTAINED ILLUMINATED LED EMERGENCY EXIT SIGN C/W RUNNING MAN PICTOGRAM
 - F IP65 RATED SURFACE MOUNTED LINEAR LED LUMINAIRE
 - H RECESSED CIRCULAR LED DOWNLIGHT
 - EX1 IP65 EXTERNAL WALL MOUNTED LUMINAIRE
 - AD RECESSED MOUNTED ABSENCE DETECTOR COMBINED WITH DAYLIGHT LINK
 - PD RECESSED MOUNTED PRESENCE DETECTOR COMBINED WITH DAYLIGHT LINK
 - PD1 SURFACE MOUNTED PRESENCE DETECTOR
 - PD2 SURFACE MOUNTED HIGH BAY PRESENCE DETECTOR COMBINED WITH DAYLIGHT LINK
 - PD3 WALL MOUNTED MICROWAVE PRESENCE DETECTOR
 - PD4 IP65 EXTERNAL WALL MOUNTED PHOTOCELL SENSOR
 - LCM PLUGGABLE DALI LIGHTING CONTROL MODULE WITH FUSED CONNECTION UNIT MOUNTED ADJACENT
 - RB2000 EXOR LIGHTING CONTROL POWER SUPPLY UNIT
 - EM PANEL ZUMTOBEL EMERGENCY LIGHTING CONTROL PANEL
 - SW LIGHT SWITCH
 - R RETRACTABLE LIGHT SWITCH ('X' DENOTES NO. OF GANGS)
 - INT INTERMEDIATE LIGHT SWITCH
 - SS WALL MOUNTED LIGHTING CONTROL SCENE SELECT PLATE
 - 'CV' DENOTES ITEM LOCATED WITHIN CEILING VOID
 - 'WP' DENOTES WEATHERPROOF ITEMS

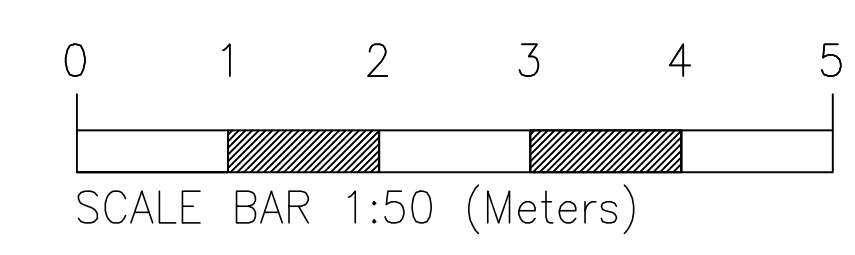

8	01.07.2020	STAGE 4 FINAL ISSUE	CAD
7	19.06.2020	INCORPORATING COMMENTS REVISED TO SUIT NEW ARCHITECTS GA	CAD
6	15.05.2020	STAGE 4 ISSUE RECEPTION	CAD
5	07.05.2020	STAGE 4 ISSUE RECEPTION	CAD
4	27.04.2020	STAGE 4 DRAFT ISSUE RECEPTION	CAD
3	02.04.2020	STAGE 4 ISSUE	CAD
2	20.03.2020	DRAFT STAGE 4 ISSUE	CAD
1	13.12.19	STAGE 3 ISSUE	CAD
0	22.11.19	STAGE 3 DRAFT ISSUE	CAD
Rev	Date	Description	Drawn

Based on architect's drawing

20BW-ALLP-ZZ-04-DR-A-2405-B

Issue Status

STAGE 4

Project UCL IOE, 20 BEDFORD WAY
PHASE 2

Title LEVEL 4 CORE A
LIGHTING LAYOUT

Scale 1:50@A0

Designed By SN

Checked by PEC

Date NOV'19

building services consultants
100 Abchurch Lane, London EC4N 3DF
T +44 (0)20 7626 4600
F +44 (0)20 7626 4601
E info@bscgroup.co.uk
www.bscgroup.co.uk

7110-20BW-
LP-CA-04-DR-E-3004-1

8