



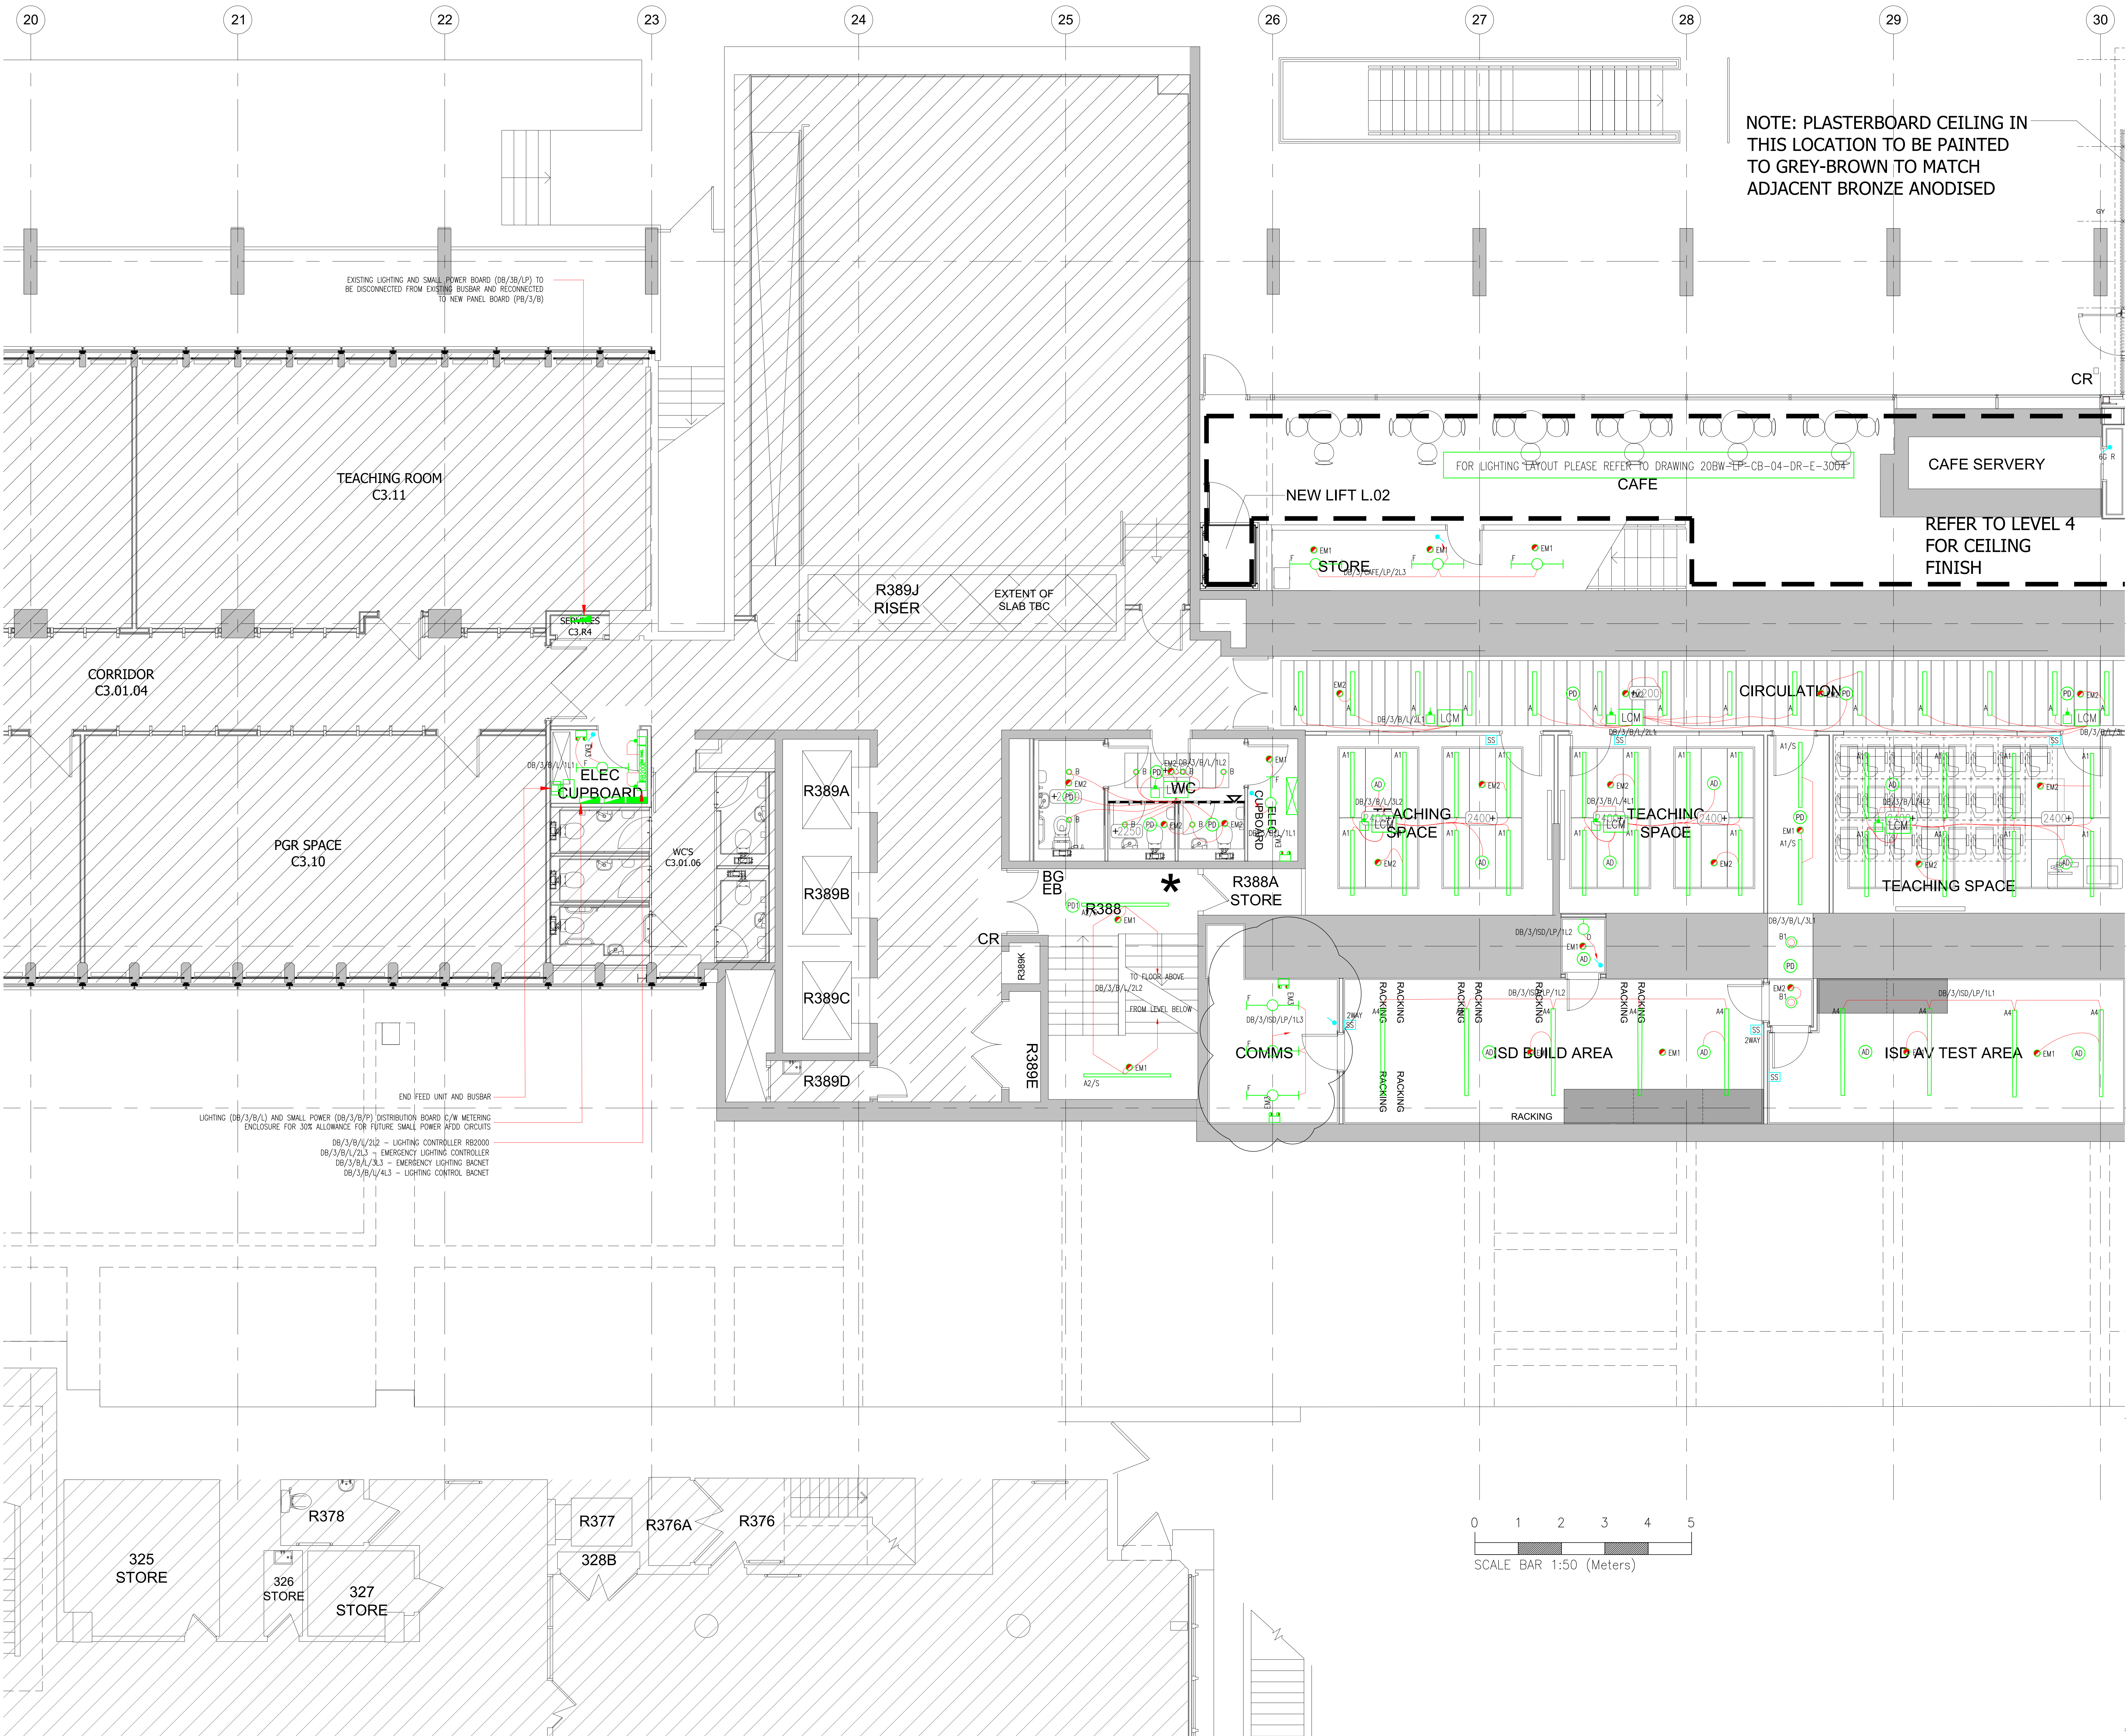


NOTE: PLASTERBOARD CEILING IN THIS LOCATION TO BE PAINTED TO GREY-BROWN TO MATCH ADJACENT BRONZE ANODISED

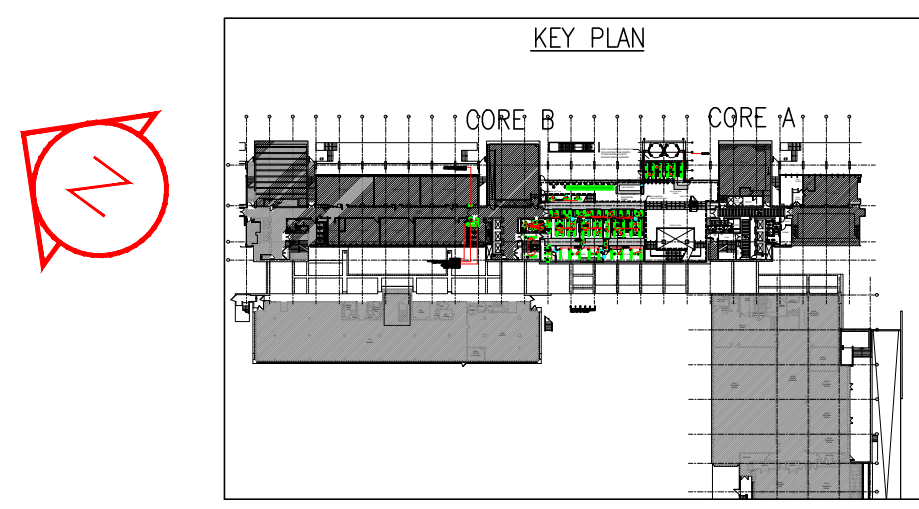

- NOTES
- ALL DRAWINGS SHALL BE READ IN CONJUNCTION WITH LONG & PARTNERS DRAWINGS, SCHEDULES & SPECIFICATION.
 - FOR DETAILS, ELEVATIONS & EXACT SETTING OUT OF WALL MOUNTED ACCESSORIES, REFER TO THE ARCHITECTS LAYOUT.
 - THE ELECTRICAL SERVICES WORKS SHALL BE CARRIED OUT IN ACCORDANCE WITH THE LONG & PARTNERS SPECIFICATION.
 - ALL EMERGENCY LUMINAIRES TO BE CONNECTED TO KVM MODULE LOCATED WITHIN THE CEILING VOID. THE CIRCUIT TO BE DERIVED FROM THE LOCAL LIGHTING CIRCUIT.
 - ALL LIGHTING CONTROL LOCATIONS ARE INDICATIVE AND THE MANUFACTURERS INSTALLATION INSTRUCTIONS SHOULD ALWAYS BE CHECKED.
- LEGEND
- A 1000mm LINEAR RECESSED LED LUMINAIRE
 - A1 1500mm LINEAR RECESSED LED LUMINAIRE
 - A1/S 1500mm SUSPENDED LINEAR LED LUMINAIRE
 - A2 2000mm LINEAR RECESSED LED LUMINAIRE
 - A2/S 3000mm LINEAR SURFACE MOUNTED LED LUMINAIRE
 - A3 1200mm SUSPENDED MOUNTED LED LUMINAIRE
 - A4 2274mm SUSPENDED MOUNTED LED LUMINAIRE TUNABLE BALLAST
 - OB RECESSED CIRCULAR LED DOWNLIGHT
 - OB1 RECESSED CIRCULAR LED DOWNLIGHT
 - OB2 RECESSED CIRCULAR LED DOWNLIGHT
 - OB3 RECESSED CIRCULAR LED DOWNLIGHT
 - OB4 RECESSED CIRCULAR LED DOWNLIGHT
 - OC RECESSED CIRCULAR LED DOWNLIGHT
 - OC1 SUSPENDED CIRCULAR LED DOWNLIGHT
 - OC2 SUSPENDED LED PENDANT
 - OC3 SUSPENDED LED PENDANT
 - D IP65 RATED WALL MOUNTED LUMINAIRE
 - L1 & L2 IP65 LINEAR SURFACE MOUNTED LED LUMINAIRE
 - EM1 SURFACE MOUNTED NON MAINTAINED EMERGENCY DOWNLIGHT
 - EM2 RECESSED CIRCULAR NON MAINTAINED EMERGENCY DOWNLIGHT
 - EM3 WALL MOUNTED NON MAINTAINED TWIN SPOTLIGHT EMERGENCY LUMINAIRE
 - EXIT R RECESSED MAINTAINED ILLUMINATED LED EMERGENCY EXIT SIGN C/W RUNNING MAN PICTOGRAM
 - EXIT SS SURFACE MOUNTED MAINTAINED ILLUMINATED LED EMERGENCY EXIT SIGN C/W RUNNING MAN PICTOGRAM
 - EXIT SS IP RATED SURFACE MOUNTED MAINTAINED ILLUMINATED LED EMERGENCY EXIT SIGN C/W RUNNING MAN PICTOGRAM
 - F IP65 RATED SURFACE MOUNTED LINEAR LED LUMINAIRE
 - OH RECESSED CIRCULAR LED DOWNLIGHT
 - EX1 IP65 EXTERNAL WALL MOUNTED LUMINAIRE
 - AD RECESSED MOUNTED ABSENCE DETECTOR COMBINED WITH DAYLIGHT LINK
 - PD RECESSED MOUNTED PRESENCE DETECTOR COMBINED WITH DAYLIGHT LINK
 - PD1 SURFACE MOUNTED PRESENCE DETECTOR
 - PD2 SURFACE MOUNTED HIGH BAY PRESENCE DETECTOR COMBINED WITH DAYLIGHT LINK
 - PD3 WALL MOUNTED MICROWAVE PRESENCE DETECTOR
 - PCO IP65 EXTERNAL WALL MOUNTED PHOTOCCELL SENSOR
 - LCM PLUGGABLE DALI LIGHTING CONTROL MODULE WITH FIRED CONNECTION UNIT MOUNTED ADJACENT
 - HR2000 EXOR LIGHTING CONTROL POWER SUPPLY UNIT
 - EM PANEL ZUMTOBEL EMERGENCY LIGHTING CONTROL PANEL
 - SW LIGHT SWITCH
 - R RETRACTABLE LIGHT SWITCH ('X' DENOTES NO. OF GANGS)
 - SS INTERMEDIATE LIGHT SWITCH
 - SS WALL MOUNTED LIGHTING CONTROL SCENE SELECT PLATE
 - 'CV' DENOTES ITEM LOCATED WITHIN CEILING VOID
 - 'WP' DENOTES WEATHERPROOF ITEMS

FOR CONTINUATION REFER TO DRAWING 20BW-LLP-CA-03-DR-E-3003-1

END FEED UNIT AND BUSBAR
LIGHTING DB/3/B/L AND SMALL POWER DB/3/B/P DISTRIBUTION BOARD C/W METERING ENCLOSURE FOR 30% ALLOWANCE FOR FUTURE SMALL POWER ADD CIRCUITS
DB/3/B/L/2/2 - LIGHTING CONTROLLER RB2000
DB/3/B/L/2/3 - EMERGENCY LIGHTING CONTROLLER
DB/3/B/L/3/1 - EMERGENCY LIGHTING BACNET
DB/3/B/L/4/3 - LIGHTING CONTROL BACNET

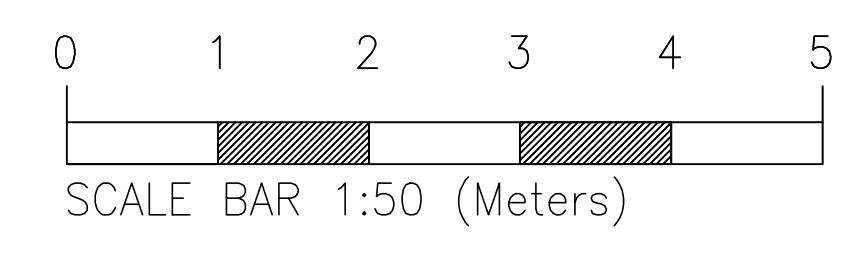

8	01.07.2020	STAGE 4 FINAL ISSUE	CAD
7	19.06.20	INCORPORATING COMMENTS	CAD
6	15.05.2020	REVISED TO SUIT NEW ARCHITECTS	CAD
5	07.05.2020	STAGE 4 ISSUE COMMENTS	CAD
4	27.04.2020	STAGE 4 ISSUE RECEPTION	CAD
3	03.04.2020	STAGE 4 DRAFT ISSUE	CAD
2	28.02.2020	STAGE 4 DRAFT ISSUE	CAD
1	13.12.19	STAGE 3 ISSUE	CAD
0	22.11.19	DRAFT STAGE 3 ISSUE	CAD

Based on architect's drawing
20BW-ALLP-ZZ-03-DR-A-2305-B

Issue Status

STAGE 4

Project: UCL IOE, 20 BEDFORD WAY PHASE 2

Title: LEVEL 3 CORE B LIGHTING LAYOUT

Scale: 1:500A0

Designed By: SN

Checked By: PEC

Date: NOV'19

building services consultants
100 Abchurch Lane, London, EC4N 3DF
T +44 (0)20 7625 4600
F +44 (0)20 7625 4601
E info@bscgroup.co.uk

7110-20BW-LLP-CB-03-DR-E-3003

8