
 


SCALE 1:50

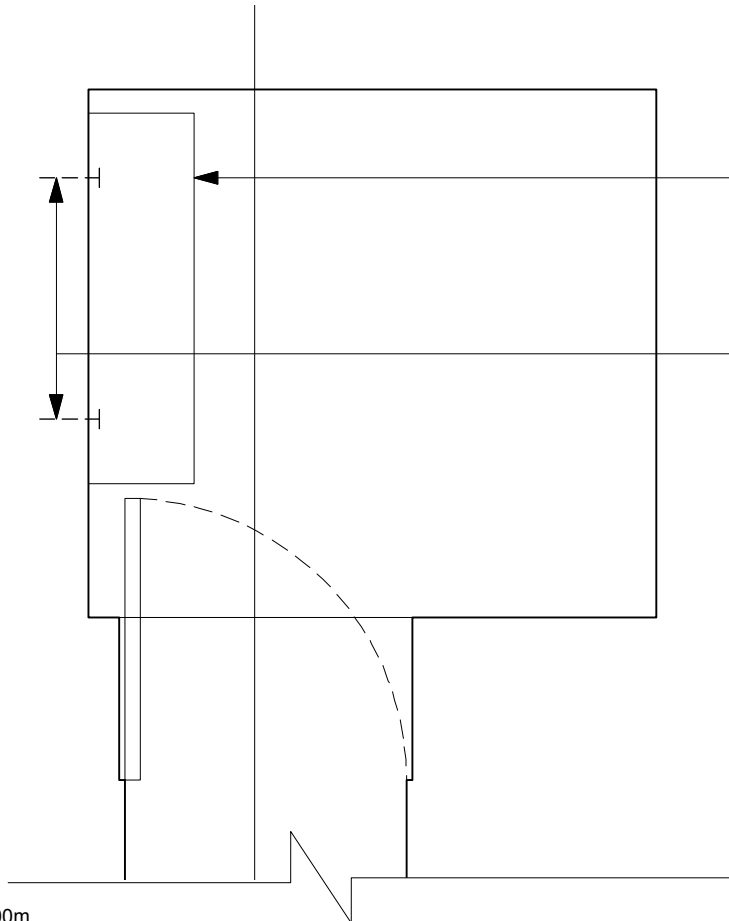

AC unit located at high level on existing wall

Location of frilled holes for AC unit fixings as required



SCALE 1:20

Notes
- All dimensions are to be confirmed on site.
- Any discrepancies are to be brought to the attention of the Architect before the work is carried-out.

Issue / Amendment	Date	Rev



Project 57-59 Neal Street London		Drawing Title Proposed Floor Plan		
Scale	Original Size	A3	Drawn	Checked
<input checked="" type="checkbox"/> Information		<input type="checkbox"/> Tender/Contract		<input type="checkbox"/> Construction
Project No. NS		Drawing No. NS.110		Revision No. -