


- NOTES:
- This drawing is to be read in conjunction with all relevant Architect's, Engineer's and specialists' drawings and specifications.
  - Do not scale from this drawing in either paper or digital form. Use written dimensions only. To check that this drawing has been printed to the intended scale this bar should be 50mm long @ A1 or 25mm long @ A3.
  - Health & Safety: All specific drawing notes are to be read in conjunction with the project "Information Pack" and "Site Rules".
  - For general notes refer to Drawing No. 29100 / 0002.
  - All existing drainage within access road TBC on site. References taken from Phase 1 drainage layout. Levels taken from as-built topographical survey (917508, Jan 2018)

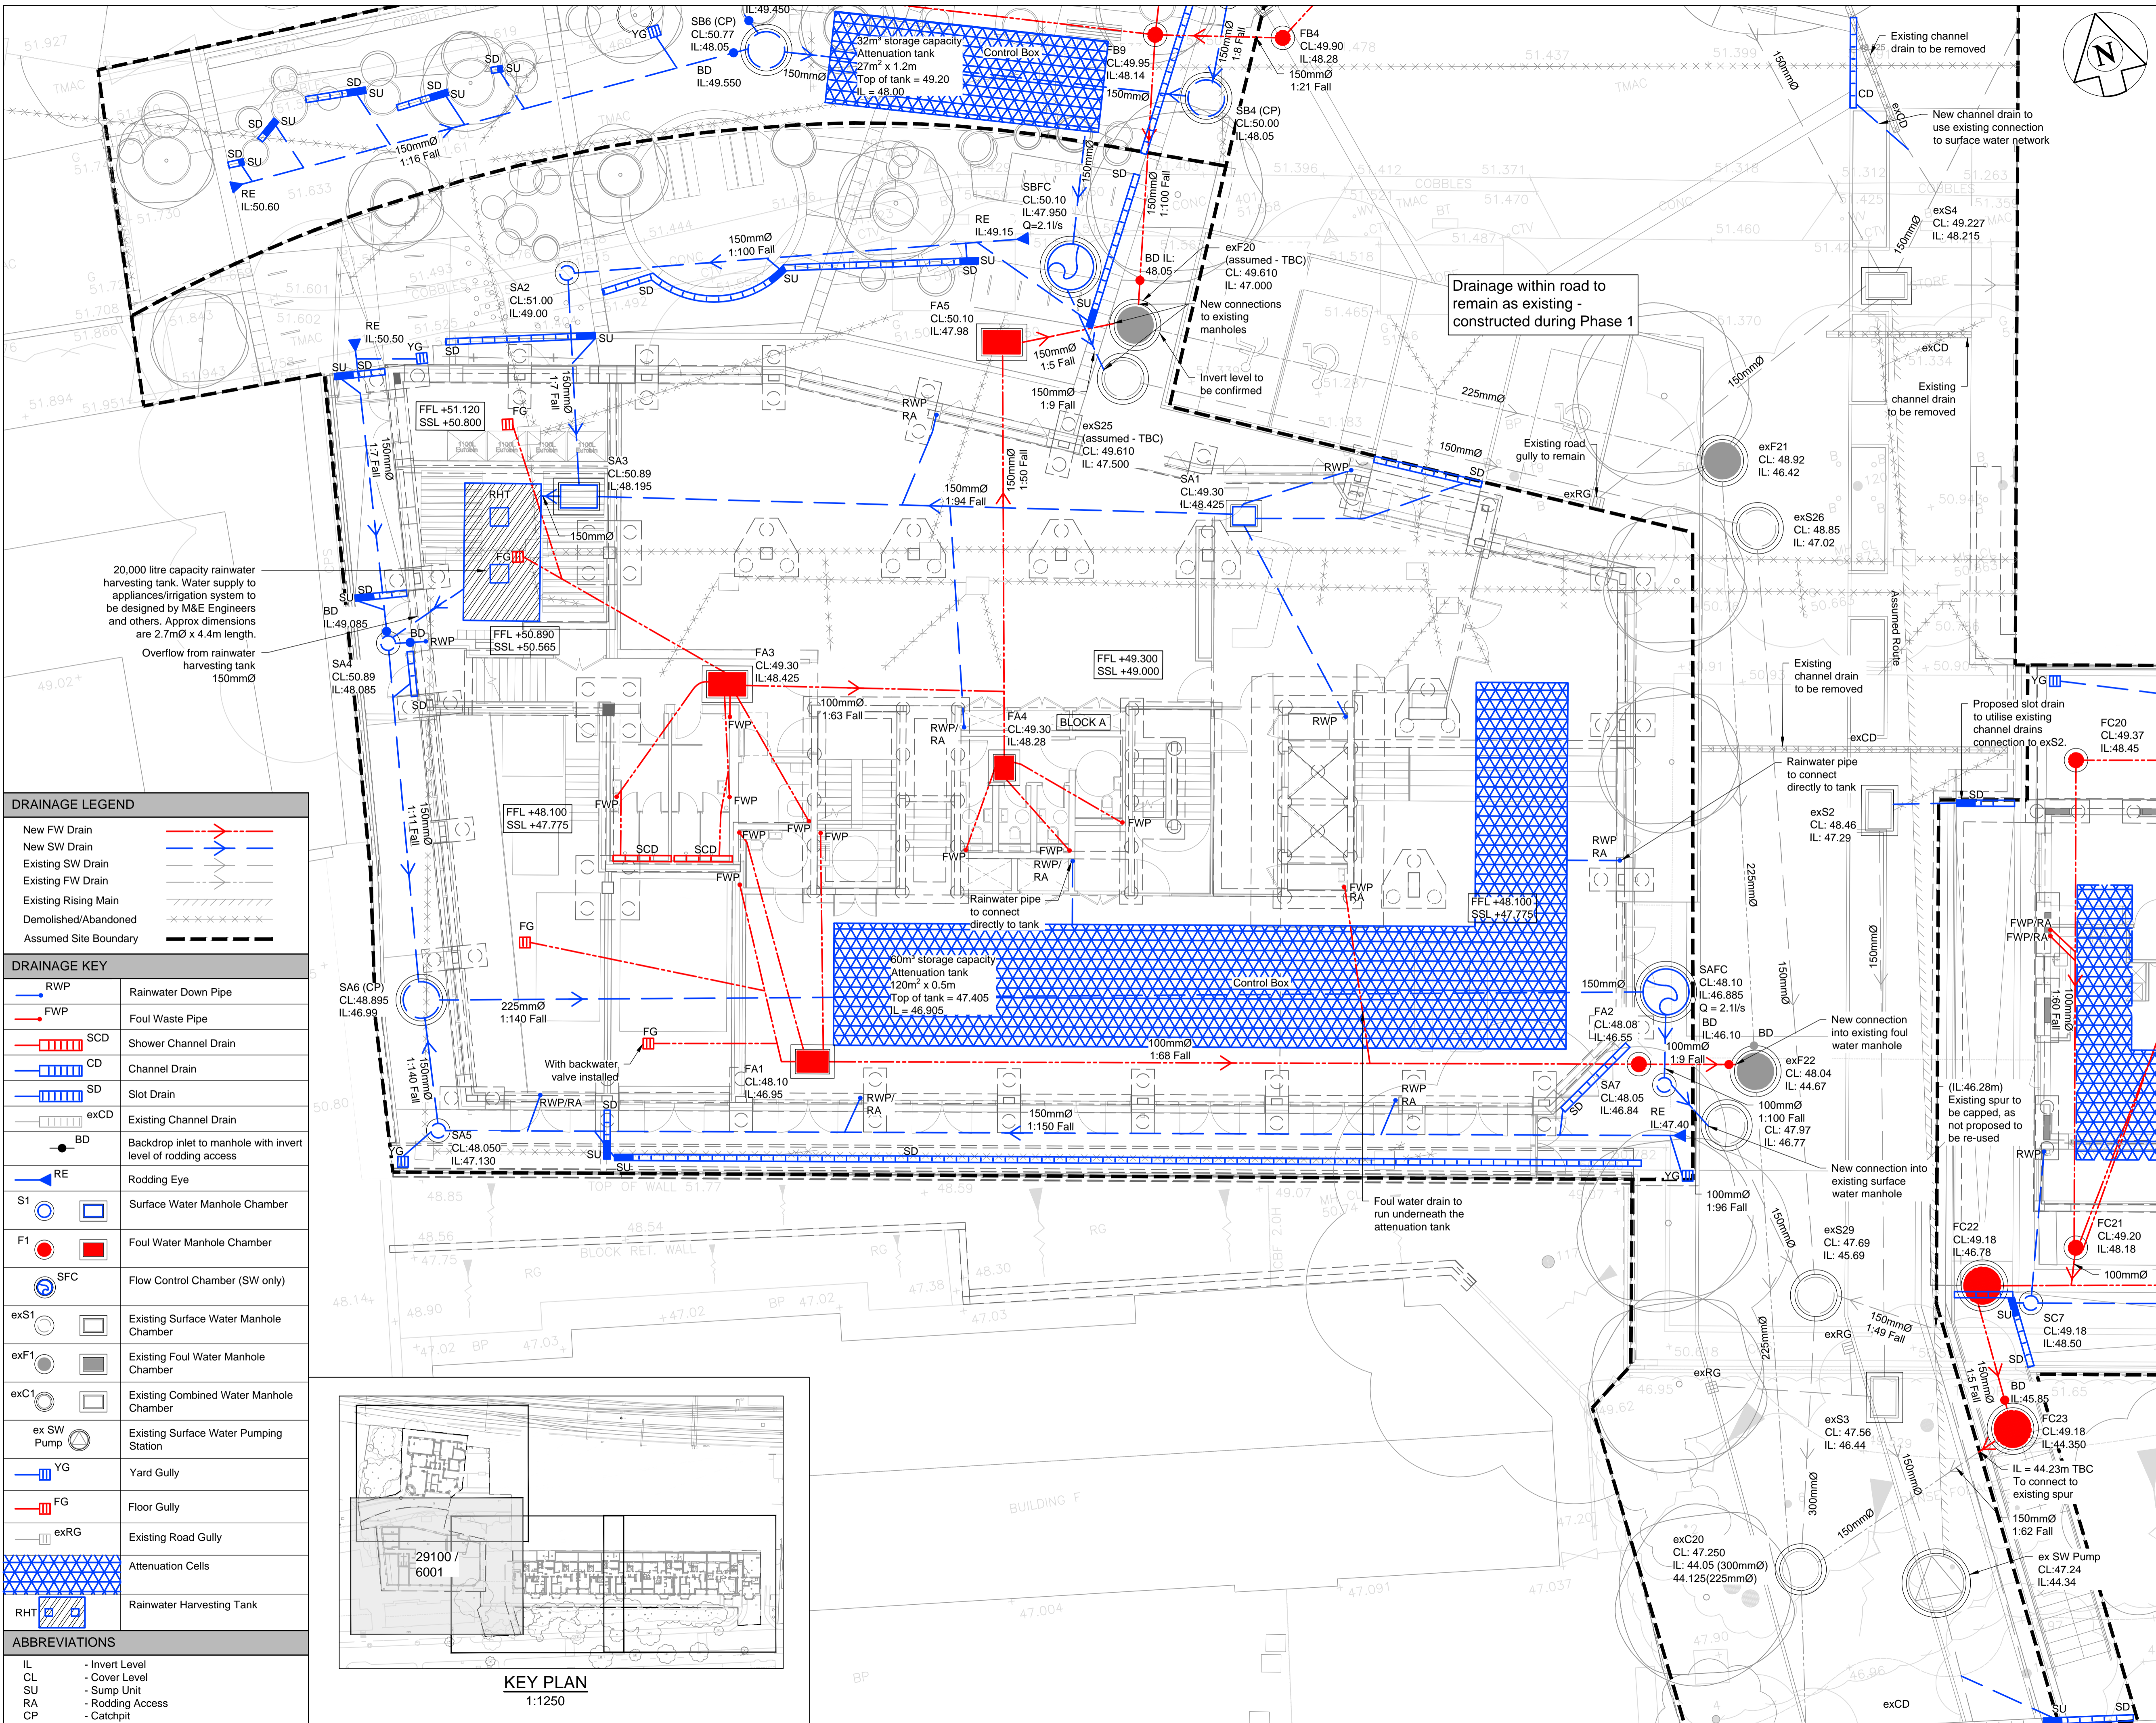

**DRAINAGE LEGEND**


- New FW Drain
- New SW Drain
- Existing SW Drain
- Existing FW Drain
- Existing Rising Main
- Demolished/Abandoned
- Assumed Site Boundary

**DRAINAGE KEY**

- RWP Rainwater Down Pipe
- FWP Foul Waste Pipe
- SCD Shower Channel Drain
- CD Channel Drain
- SD Slot Drain
- exCD Existing Channel Drain
- BD Backdrop inlet to manhole with invert level of rodding access
- RE Rodding Eye
- S1 Surface Water Manhole Chamber
- F1 Foul Water Manhole Chamber
- SFC Flow Control Chamber (SW only)
- exS1 Existing Surface Water Manhole Chamber
- exF1 Existing Foul Water Manhole Chamber
- exC1 Existing Combined Water Manhole Chamber
- ex SW Pump Existing Surface Water Pumping Station
- YG Yard Gully
- FG Floor Gully
- exRG Existing Road Gully
- Attenuation Cells
- RHT Rainwater Harvesting Tank

**ABBREVIATIONS**

- IL - Invert Level
- CL - Cover Level
- SU - Sump Unit
- RA - Rodding Access
- CP - Catchpit

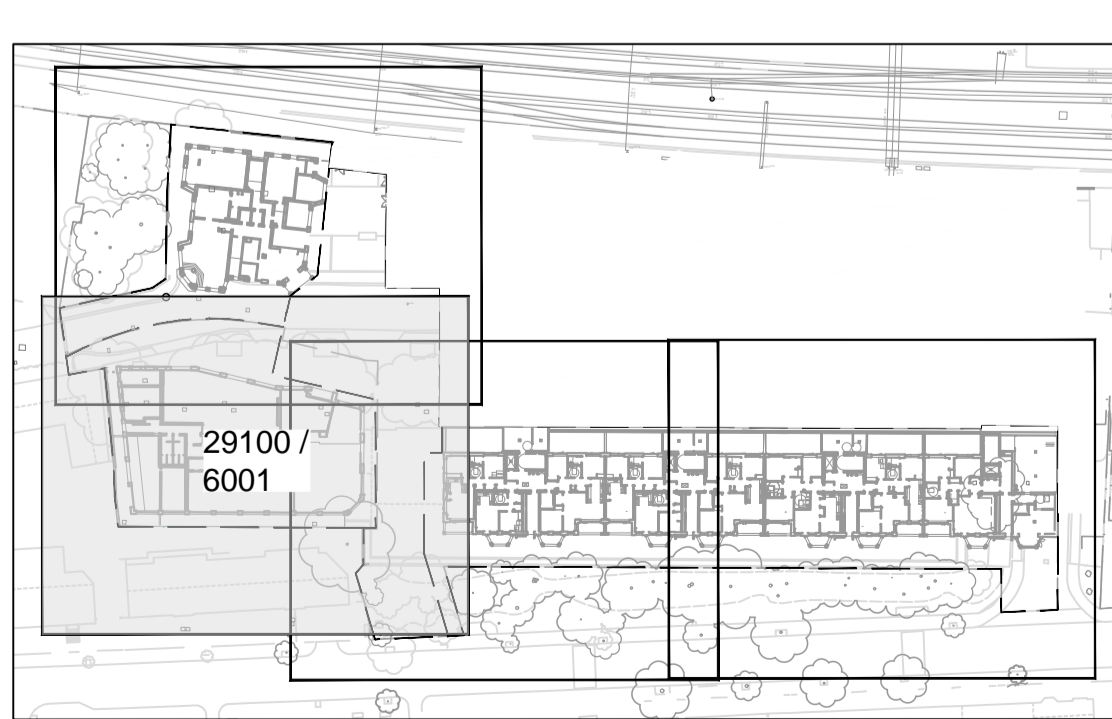

Rev	Date	Drawn	Eng	Amendment
P03	28.10.21	AC	KB	Issued for Stage 3
P02	22.10.21	AC	KB	Contract Issue
P01	16.08.21	AC	KB	Issued for Information

**LIDDELL ROAD - PHASE 2**  
**BELOW GROUND DRAINAGE**  
**BLOCK A**  
**SHEET 1**

Status  
**STAGE 3 ISSUE**  
NOT FOR CONSTRUCTION

Drawn	AH	Eng	KB
Scales	1:100 at A1	1:200 at A3	
Drawing No	29100 / 6001	Rev	P03
Doc Ref.	29100-PAM-ZZ-XX-DR-C-6001		

**PRICE & MYERS**  
Consulting Engineers  
37 Alfred Place  
London  
WC1E 7DP  
020 7631 5128  
mail@pricemyers.com  
www.pricemyers.com