


KEY PLAN
1:1250

- NOTES :
- This drawing is to be read in conjunction with all relevant Architect's, Engineer's and specialists' drawings and specifications.
 - Do not scale from this drawing in either paper or digital form. Use written dimensions only. To check that this drawing has been printed to the intended scale this bar should be 50mm long @ A1 or 25mm long @ A3.
 - Health & Safety : All specific drawing notes are to be read in conjunction with the project "Information Pack" and "Site Rules".
 - For general notes refer to Drawing No. 29100 / 0002.
 - All existing drainage within access road TBC on site. References taken from Phase 1 drainage layout. Levels taken from as-built topographical survey (917508, Jan 2018)

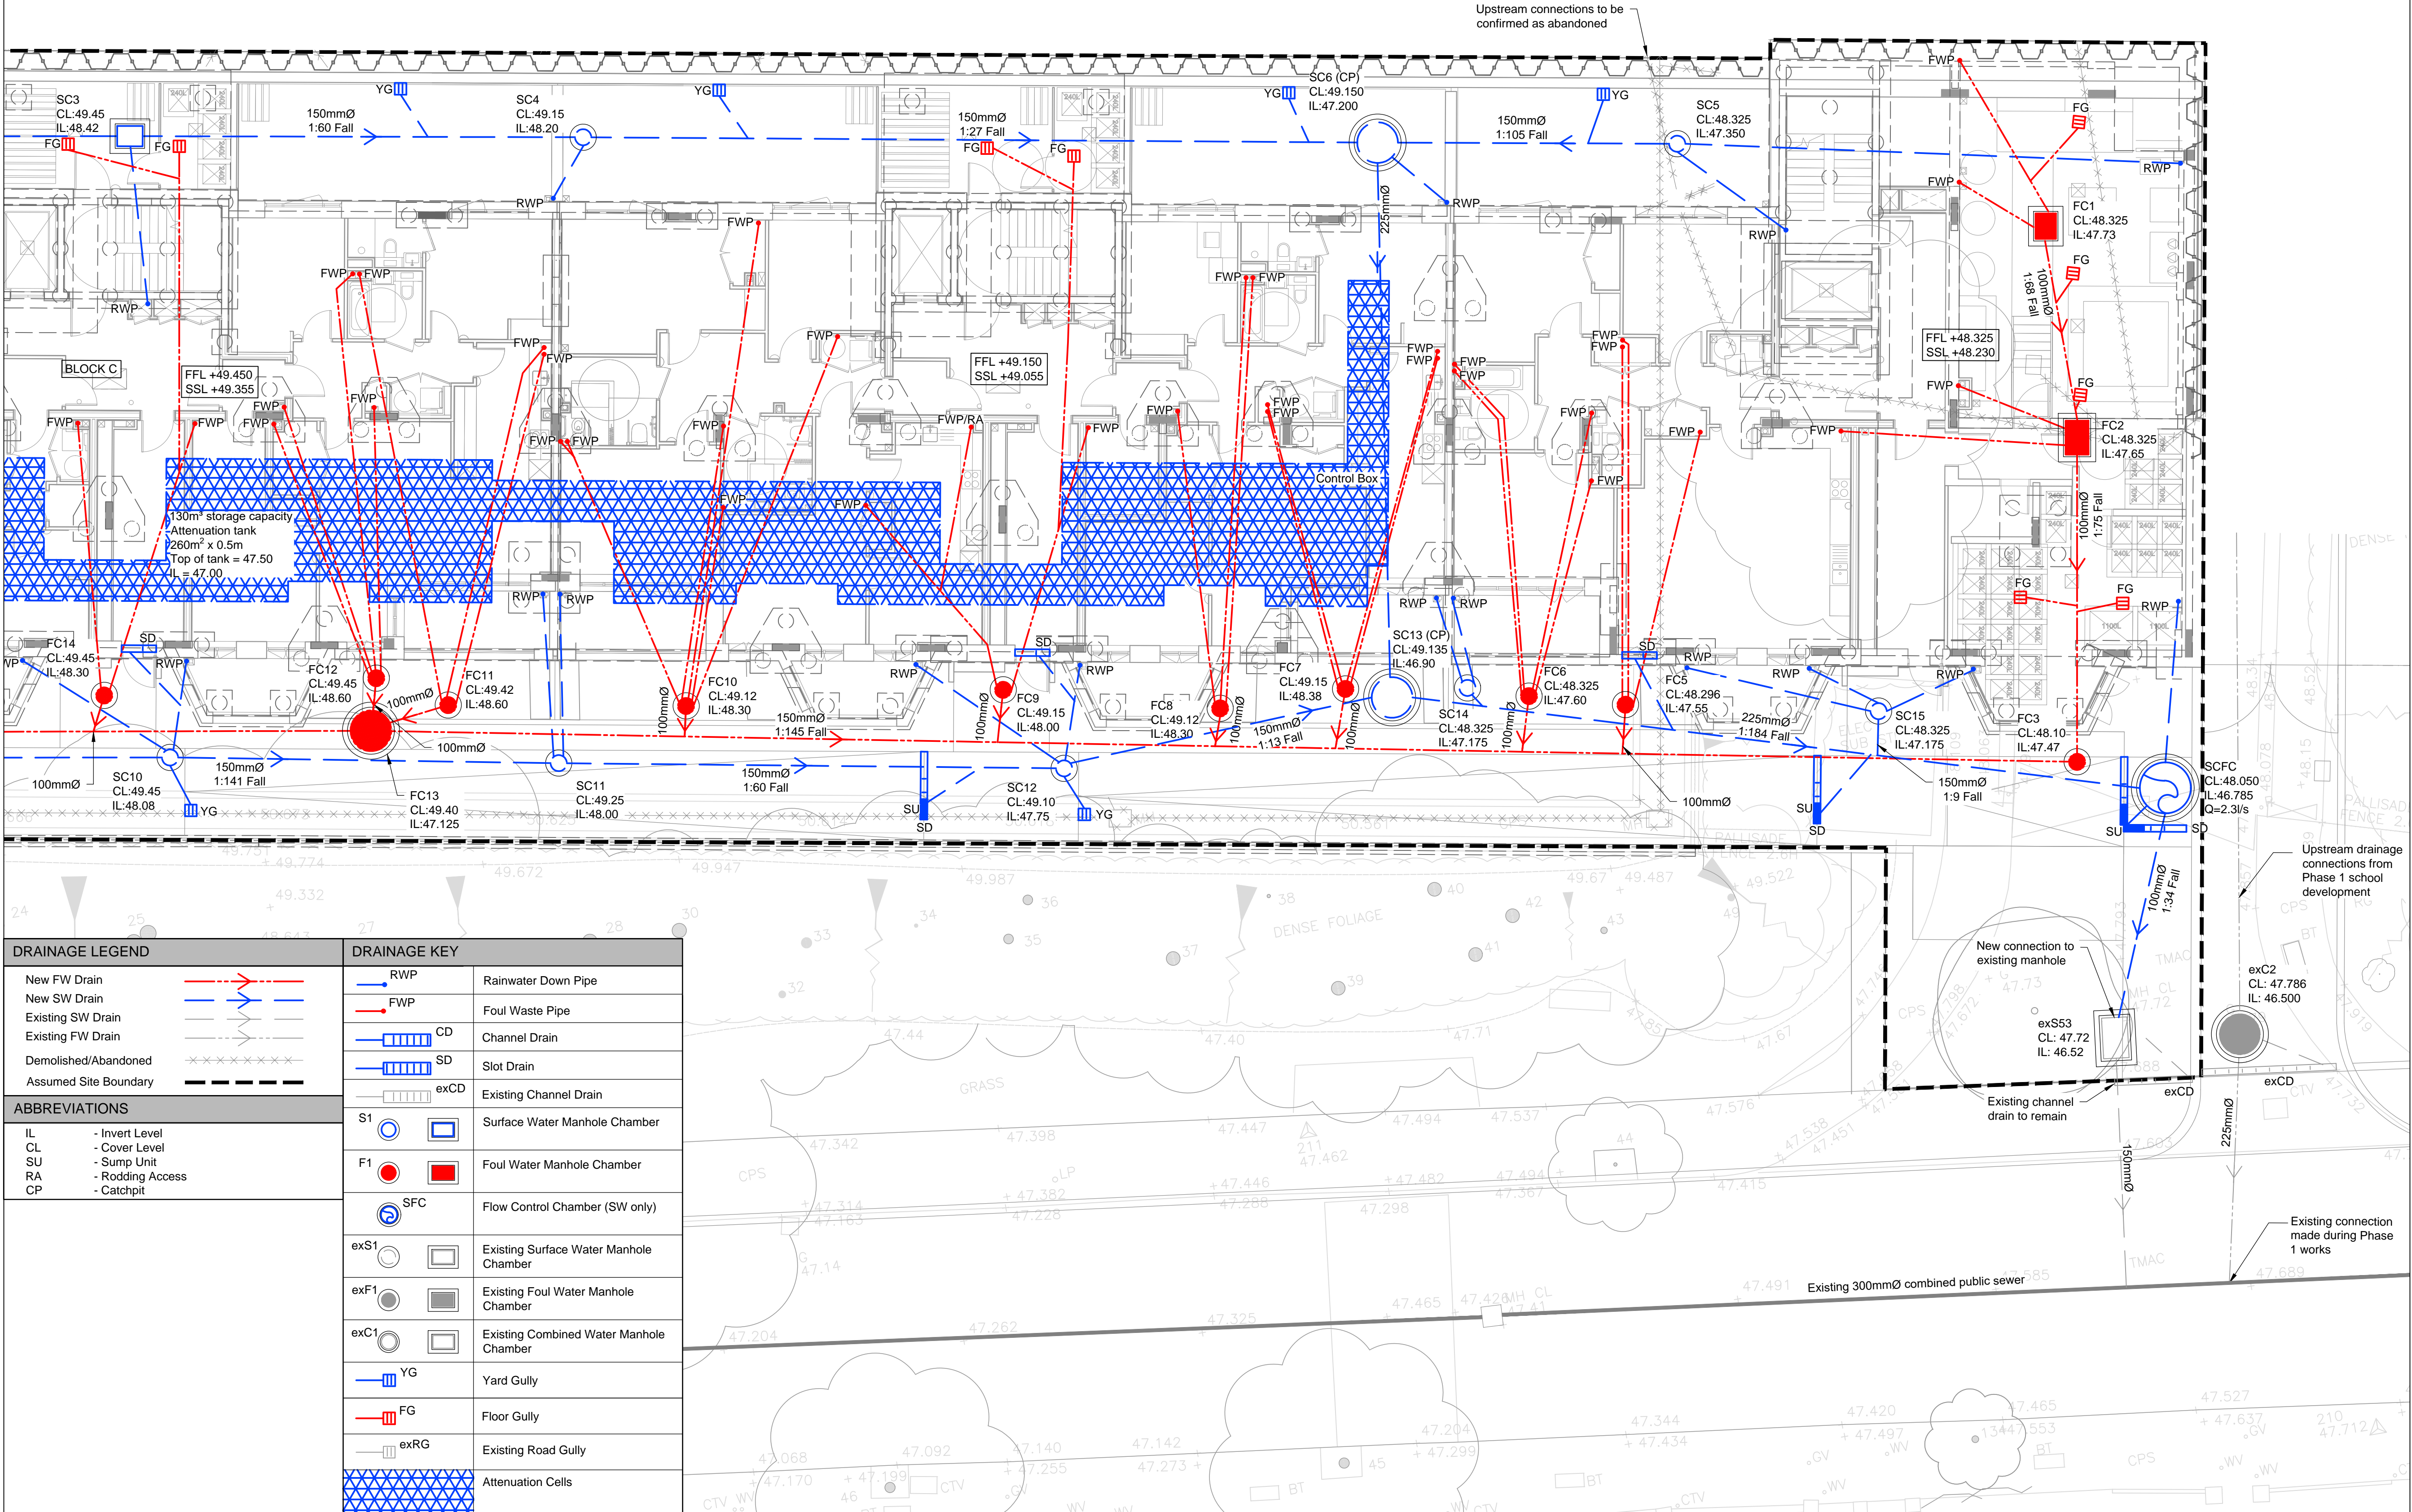

| DRAINAGE LEGEND | | DRAINAGE KEY | |
|-----------------------|------------------|--------------|---|
| New FW Drain | | RWP | Rainwater Down Pipe |
| New SW Drain | | FWP | Foul Waste Pipe |
| Existing SW Drain | | CD | Channel Drain |
| Existing FW Drain | | SD | Slot Drain |
| Demolished/Abandoned | | exCD | Existing Channel Drain |
| Assumed Site Boundary | | S1 | Surface Water Manhole Chamber |
| ABBREVIATIONS | | F1 | Foul Water Manhole Chamber |
| IL | - Invert Level | SFC | Flow Control Chamber (SW only) |
| CL | - Cover Level | exS1 | Existing Surface Water Manhole Chamber |
| SU | - Sump Unit | exF1 | Existing Foul Water Manhole Chamber |
| RA | - Rodding Access | exC1 | Existing Combined Water Manhole Chamber |
| CP | - Catchpit | YG | Yard Gully |
| | | FG | Floor Gully |
| | | exRG | Existing Road Gully |
| | | | Attenuation Cells |

| Rev | Date | Drawn | Eng | Amendment |
|-----|----------|-------|-----|-------------------------------------|
| P05 | 28.10.21 | AC | KB | Issued for Stage 3 |
| P04 | 22.10.21 | AC | KB | Contract Issue |
| P03 | 13.10.21 | AC | KB | Block C drainage updated as clouded |
| P02 | 22.09.21 | AC | KB | Block C Attenuation Tank updated |
| P01 | 16.09.21 | AC | KB | Issued for Information |

LIDDELL ROAD - PHASE 2

**BELOW GROUND DRAINAGE
BLOCK C
SHEET 4**

Status
STAGE 3 ISSUE
NOT FOR CONSTRUCTION

| | | | |
|------------|---------------------------|-------------|-----|
| Drawn | AH | Eng | KB |
| Scales | 1:100 at A1 | 1:200 at A3 | |
| Drawing No | 29100 / 6004 | Rev | P05 |
| Doc Ref. | 29100-PAM-ZZ-XX-DR-C-6004 | | |

PRICE & MYERS
Consulting Engineers
37 Alfred Place
London
WC1E 7DP
020 7631 5128
mail@pricemyers.com
www.pricemyers.com