


Rain Garden Connections

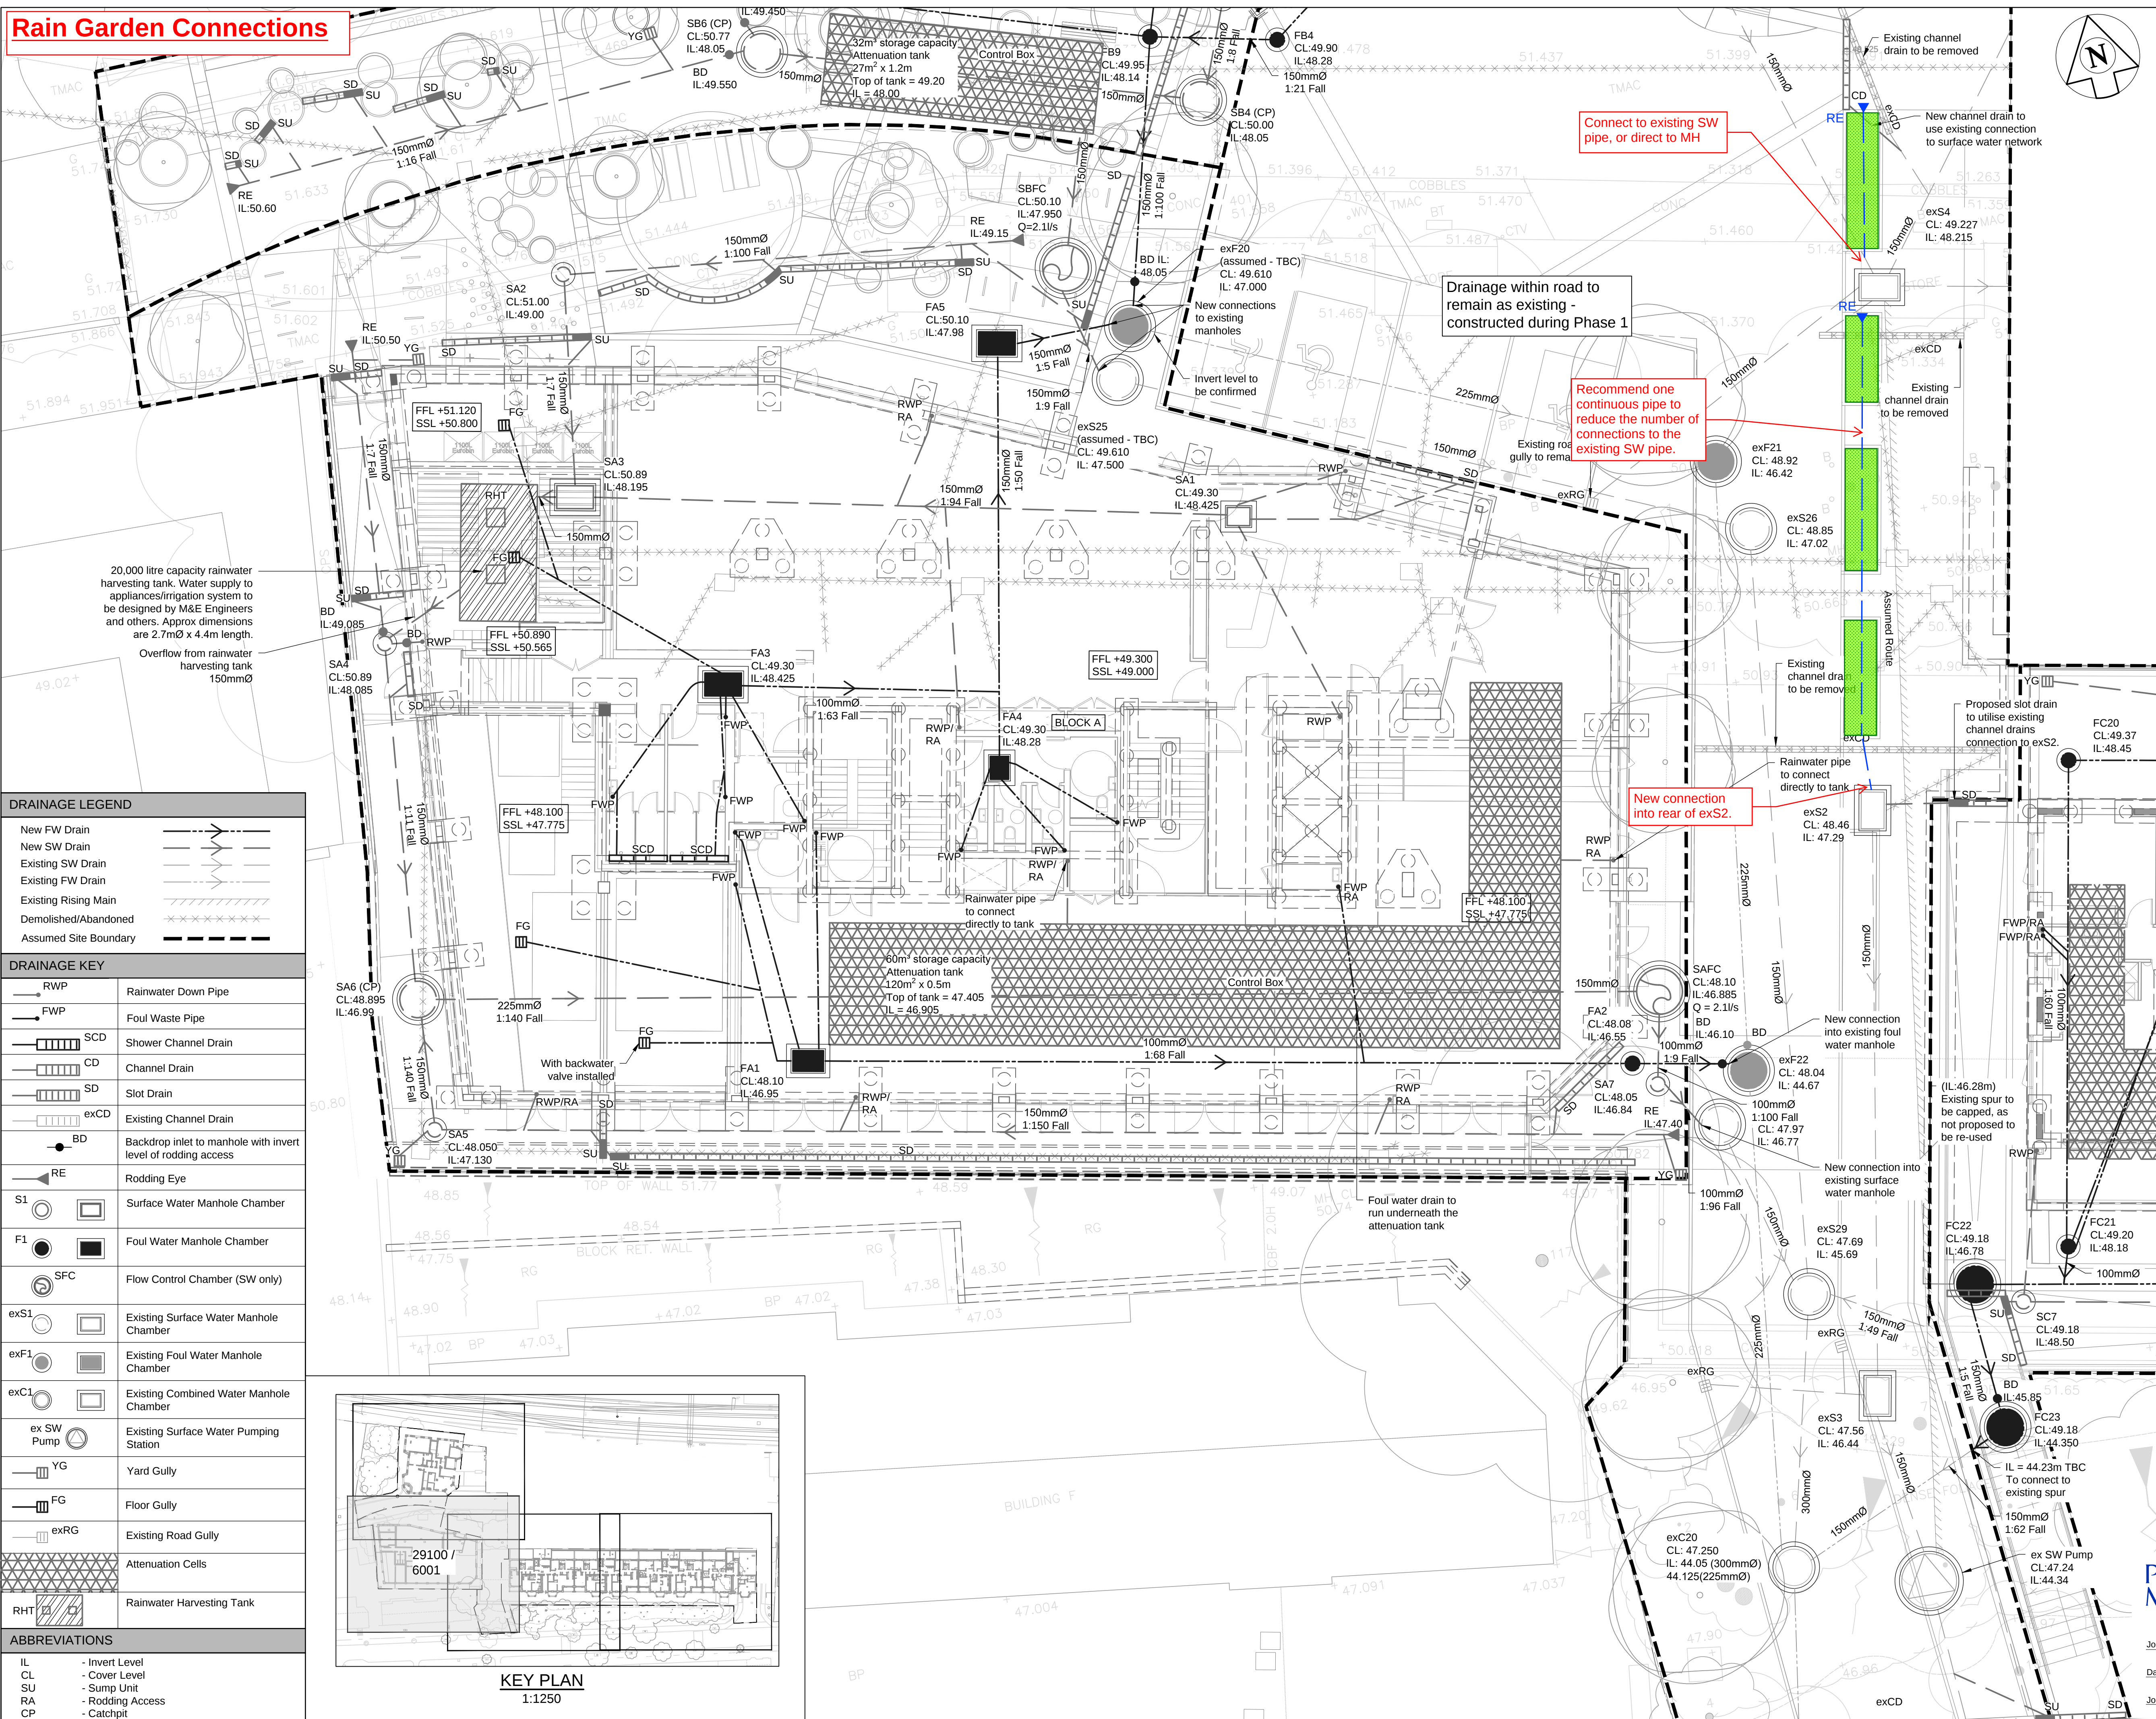

- NOTES :**
1. This drawing is to be read in conjunction with all relevant Architect's, Engineer's and specialists' drawings and specifications.
 2. Do not scale from this drawing in either paper or digital form. Use written dimensions only. To check that this drawing has been printed to the intended scale this bar should be 50mm long @ A1 or 25mm long @ A3.

 3. Health & Safety :
All specific drawing notes are to be read in conjunction with the project "Information Pack" and "Site Rules".
 4. For general notes refer to Drawing No. 29100 / 0002.
 5. All existing drainage within access road TBC on site. References taken from Phase 1 drainage layout. Levels taken from as-built topographical survey (917508, Jan 2018)