



KEY
 EXISTING PLANT

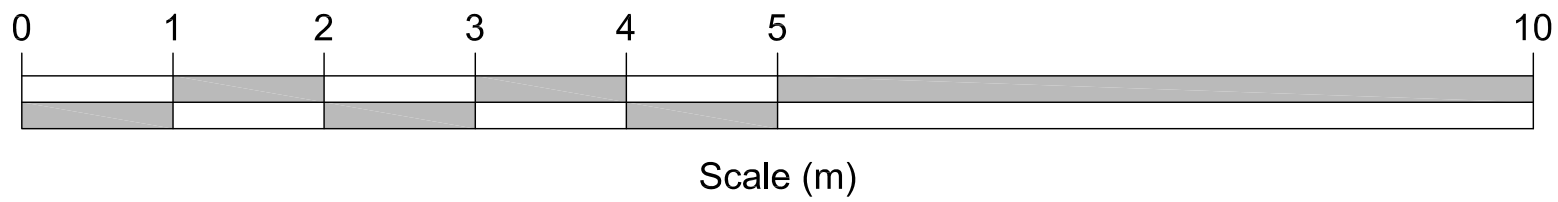

HIGH HOLBORN

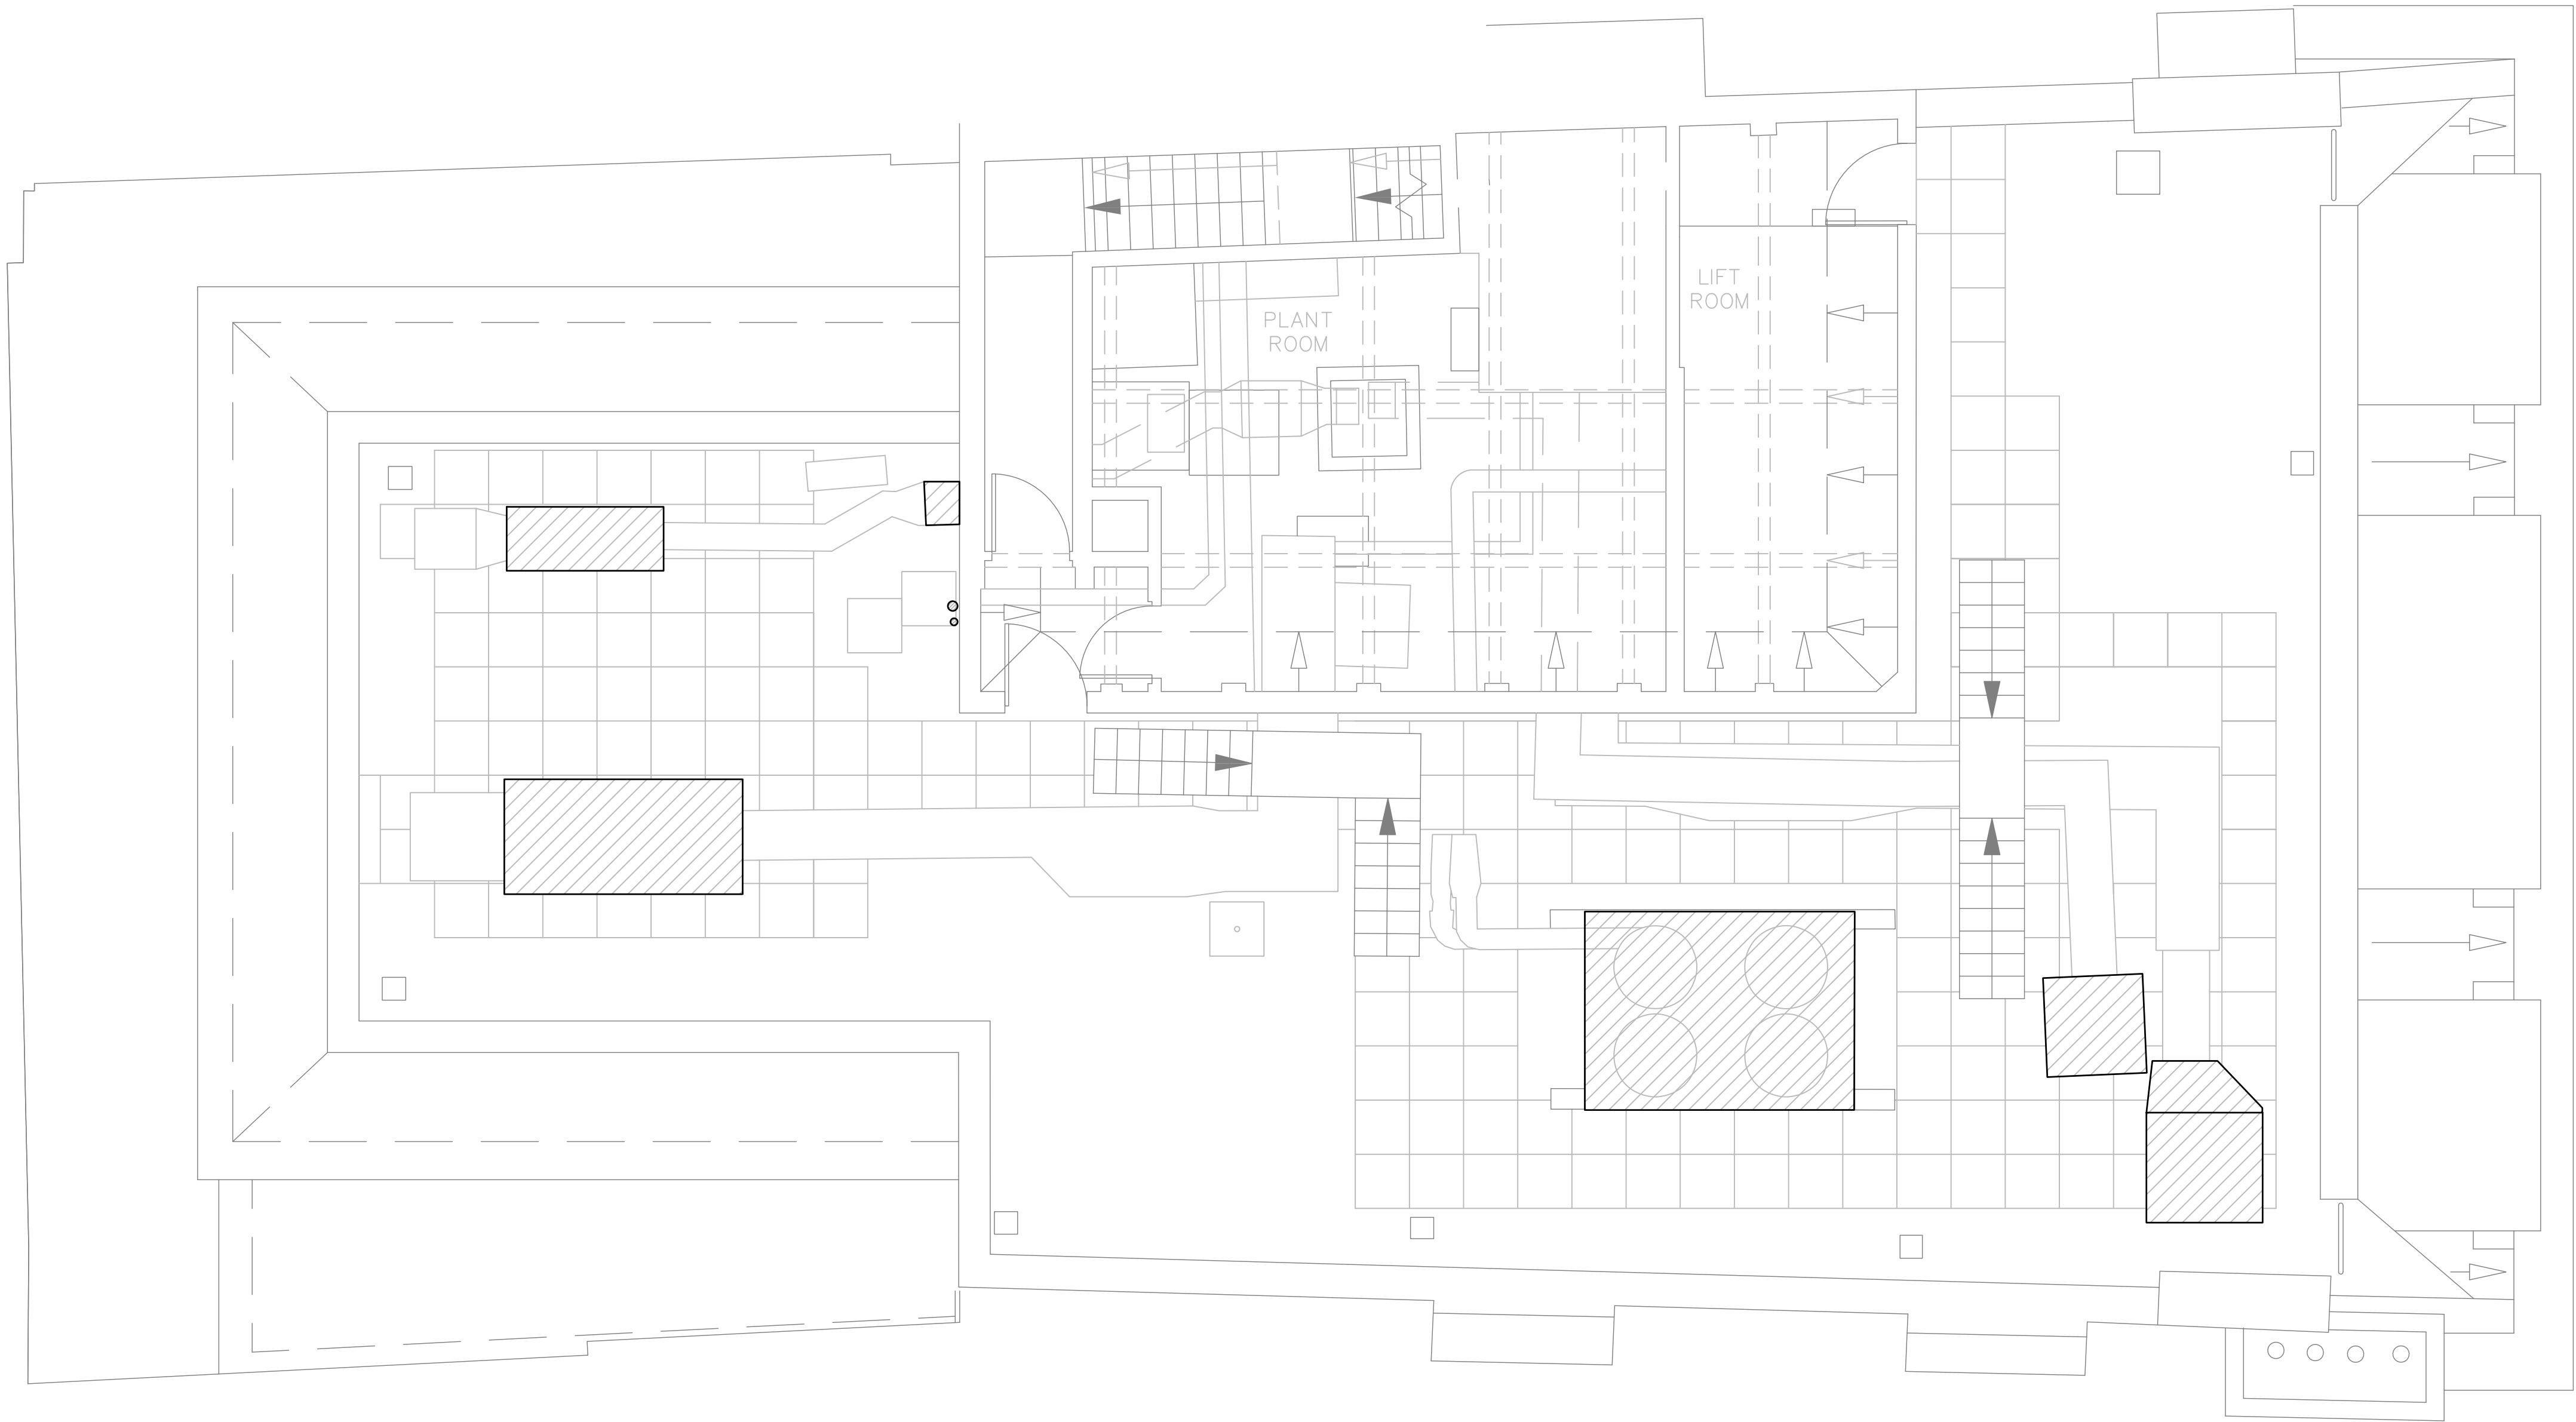

CONSTRUCTION (DESIGN AND
MANAGEMENT) REGULATIONS 2015

DESIGNERS HAZARD INFORMATION
FOR CONSTRUCTION

THE ABOVE NOTES REFER SPECIFICALLY TO THE INFORMATION SHOWN ON
THIS DRAWING.
REFER TO THE HEALTH AND SAFETY PLAN FOR FURTHER INFORMATION.

REV	REVISIONS	DATE	CHK BY	BY
-----	-----------	------	-----------	----

CSA

CHARLES SMITH & ASSOCIATES LTD.
CONSULTING ENGINEERS
333 High Street Rochester Kent ME1 1DA
Tel 01634 880544 Fax 01634 880599
Email: cso@csacatham.co.uk

PROJECT TITLE

**210 HIGH HOLBORN
LONDON WC1V 7HD**

DRAWN	M.W.	CHECKED
CAD FILE	M4052116	APPROVED
SCALE	1:50 @ A1	DATE FEB 2022

DRAWING TITLE

**ROOF LEVEL
MECHANICAL PLANT
EXISTING**

DRG No M405/21/16 P1

**ISSUED FOR
PLANNING CONSENT**