

NOTE: ALL FOH SOCKETS TO BE MATT BLACK METAL FINISH


NOTES:
ALL DIMENSIONS TO BE CHECKED WITH SITE DIMENSIONS.
CONTRACTOR TO RAISE ANY ISSUES OR CONFLICTS WITH STUDIO FOUND PRIOR TO MANUFACTURE

Notes:
The drawings show design intent only, all dimensions to be checked on site prior to construction or production. Construction details to be confirmed by contractor / manufacturer by submitting fabrication drawings for Designer's/ Client's approval.
Design / drawings to not to be scaled for production and construction purposes.
All discrepancies and omissions on site must be reported to Designer for comment and/or approval prior to commencement of works.
The designs are subject to approval by Statutory Authorities and any necessary alterations should be made if required to comply with statutory requirements and communicated to the Designer.
All design concepts and drawings are the property of Studio Found Ltd. and are covered by copyright. No reproductions, adaptations and/or copies may be made without written permission by Studio Found.


© 2019/2021 STUDIO FOUND 2021

ELECTRICAL

SINGLE POWER SOCKET	⏏
DOUBLE POWER SOCKET	⏏ ²
WATER PROOF SOCKET	⏏ _{WP}
5 AMP LIGHTING SOCKET	⏏ _{5A}
FUSED SPUR	⏏ _{FS}
HAND DRYER SPUR	⏏ _{HD}
TELEPHONE POINT	⏏ _{TP} ²
DATA POINT	⏏ _{DP} ²
HIGH LEVEL ELEC POINT	HL
CONTROL PANEL (Dimmers / Speakers / Etc)	SP D
SPEAKERS	⊗

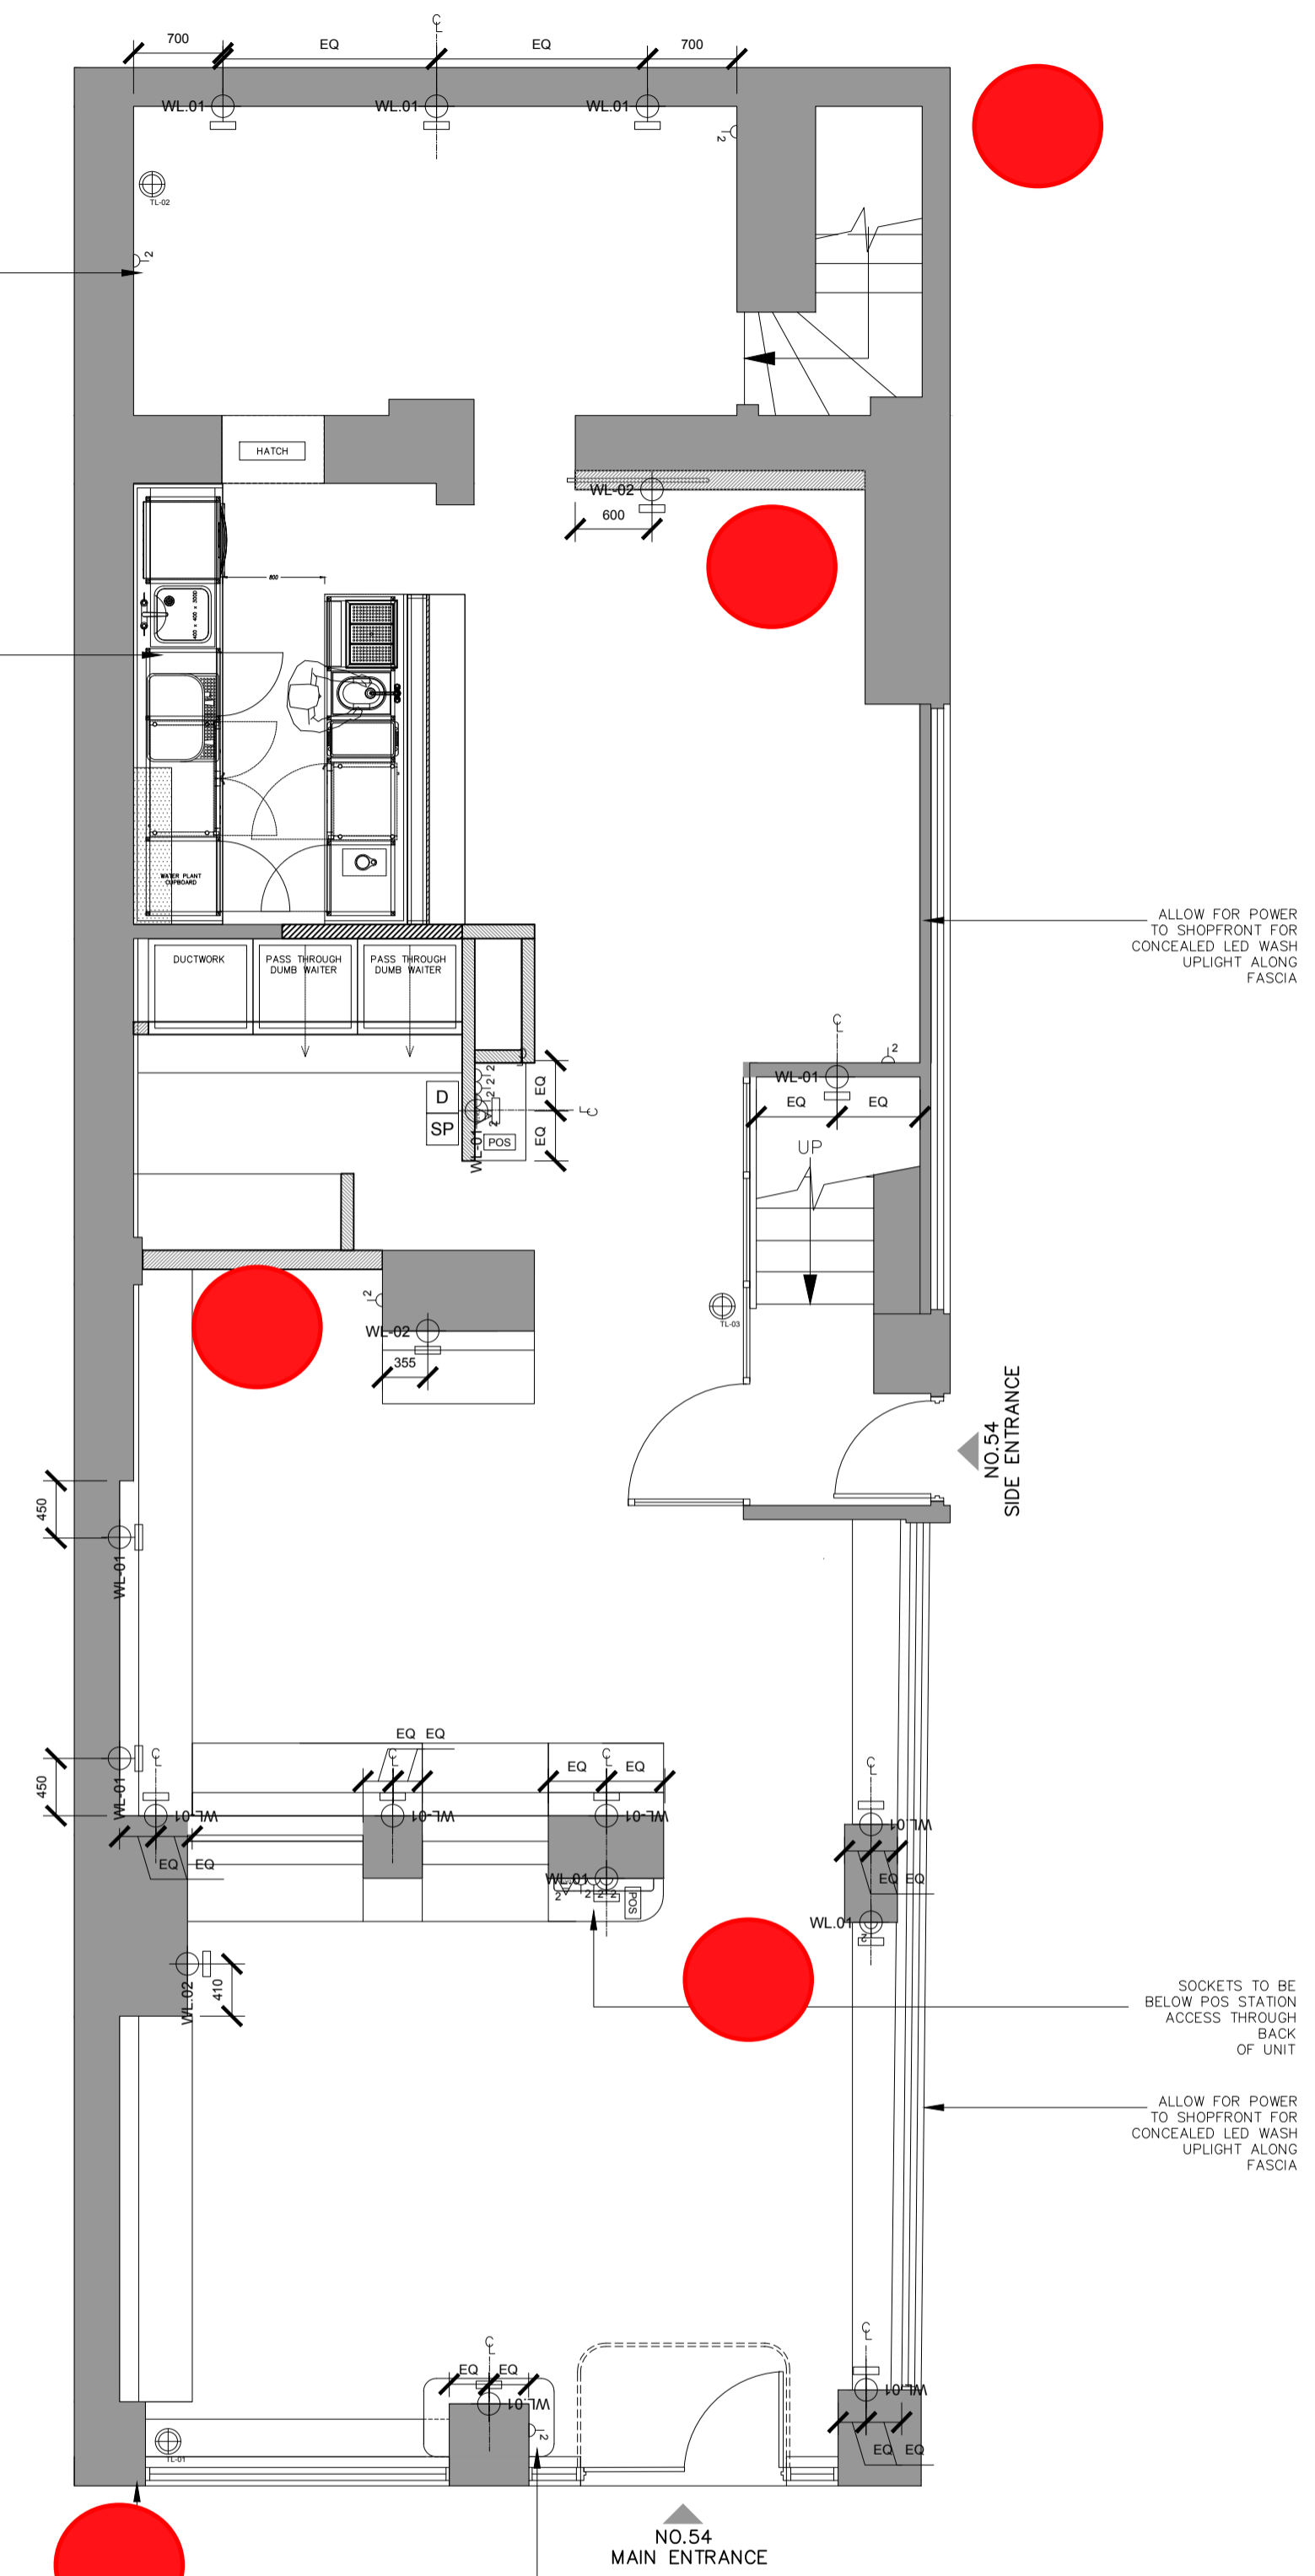

01 SMALL POWER AND LL LIGHTING PLAN
1:50 @ A1

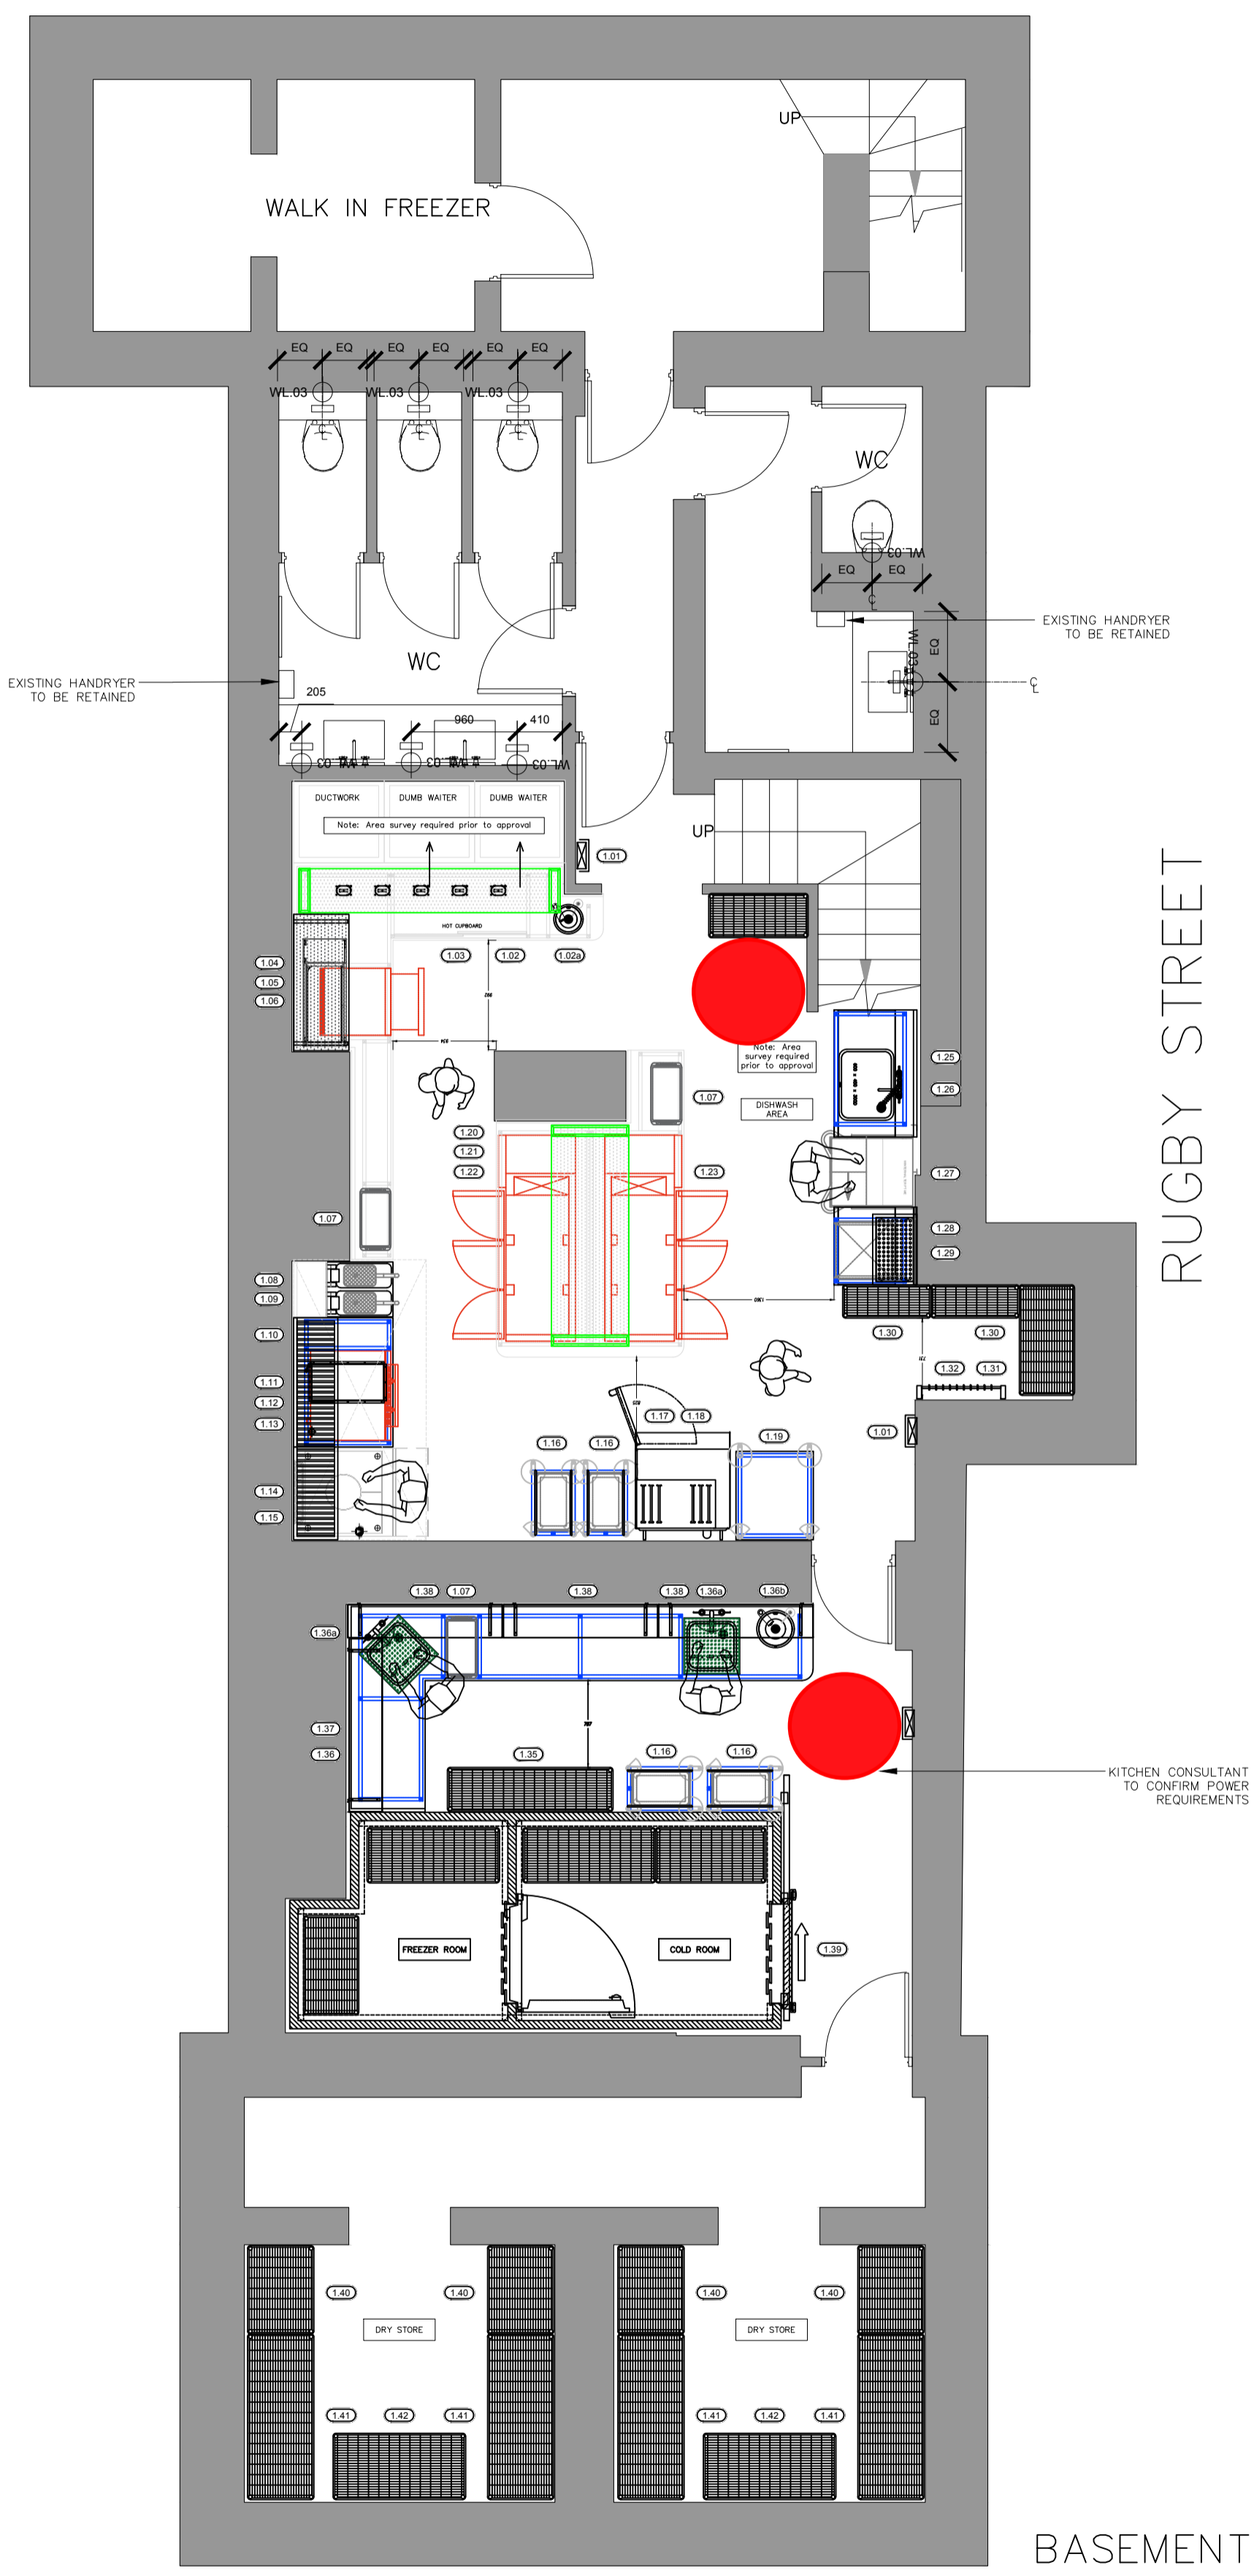

02 SMALL POWER AND LL LIGHTING PLAN
1:50 @ A1

Rev | Date | Comments

FOR INFO

Studio Found

Project: HONEY & CO	Client: HONEY & CO	Drawn: MR	Checked: EP
Drawing Title: SMALL POWER AND LL LIGHTING		Scale: @ A1	
Project Reference: 2070	Drawing Number: 2070.106	Revision: /	