 


SITE LOCATION




Reproduced by permission of Ordnance Survey on behalf of the Controller of Her Majesty's Stationery Office
All rights reserved. © Crown Copyright licence no. 100022432

SITE AREA PLAN




SITE PHOTOGRAPH

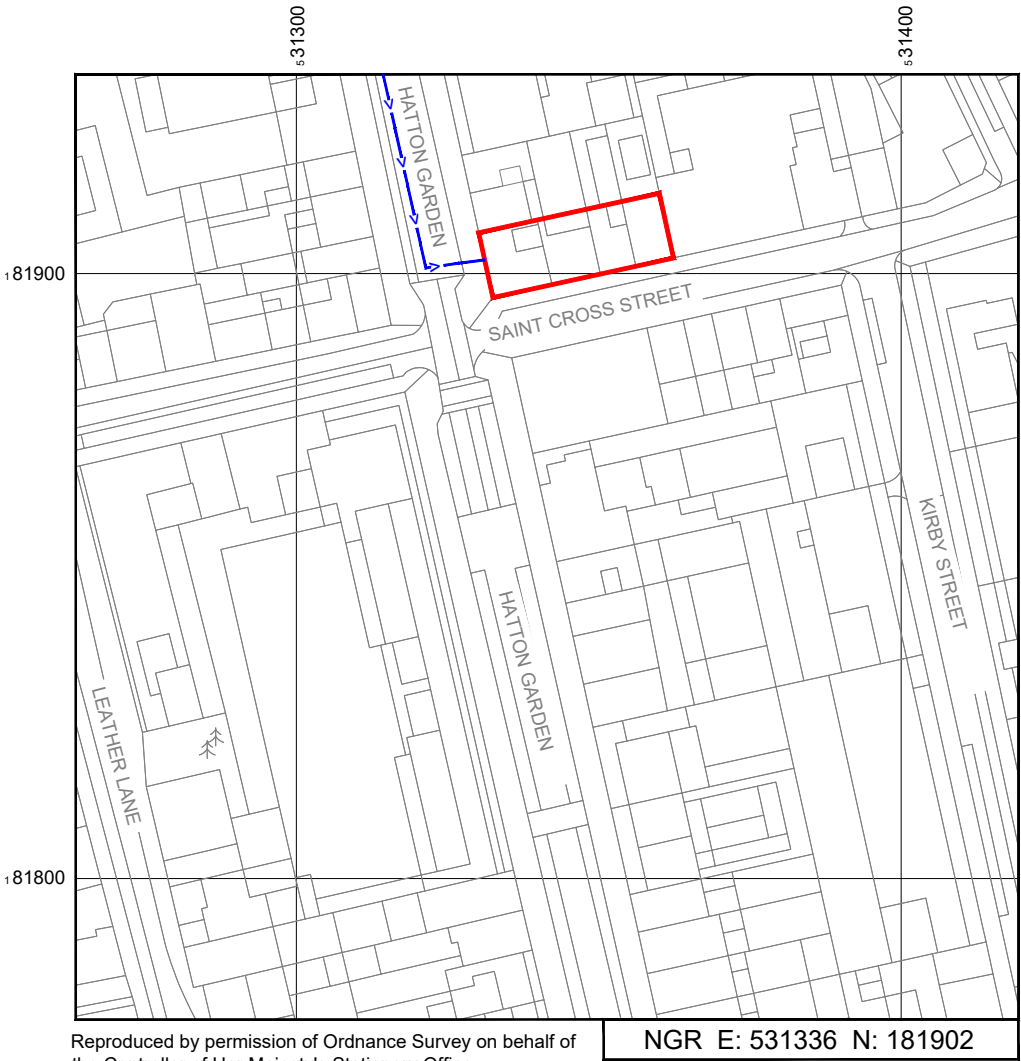

Reproduced by permission of Ordnance Survey on behalf of
the Controller of Her Majesty's Stationery Office
All rights reserved. © Crown Copyright licence no. 100022432

 SITE LOCATION PLAN



GOOGLE MAPS QR CODE

GOOGLE MAPS - <https://goo.gl/maps/S37wwiFpxmgVp47a8>

GOOGLE STREETVIEW - <https://goo.gl/maps/f74tpjo85KcB9vq88>

NOTES:

1. ALL DIMENSIONS IN MM UNLESS OTHERWISE NOTED.

DIRECTIONS TO SITE:
HEAD SOUTH ON GRAHAME PARK WAY TOWARD AVION CRES, AT THE
ROUNDBABOUT, TAKE THE 1ST EXIT ONTO AERODROME RD AND TURN
RIGHT ONTO CHURCH RD/A504 AND TURN LEFT ONTO WATFORD WAY/A41
AND TURN LEFT ONTO CRICKLEWOOD LN/A407 THEN CONTINUE ONTO
HERMITAGE LN. AT THE ROUNDBABOUT, TAKE THE 3RD EXIT ONTO PLATT'S
LN AND TURN LEFT ONTO FERNCROFT AVE AND TURN LEFT ONTO HEATH
DR AND TURN RIGHT AT THE 1ST CROSS STREET ONTO REDINGTON RD
AND TURN RIGHT ONTO FROGNAL AND TURN LEFT ONTO ARKWRIGHT RD
AND TAKE A502, A400 AND A4200 TO HATTON GARDEN/B521 DESTINATION
WILL BE ON THE RIGHT

Site Provider's
Property Boundary:



Access Route To Site:



Access Route:



Master:	MBNL / EE / H3G:	Project:	Purpose of Issue:	Issue:
M001	H3G	3UK UNILATERAL	Planning	A
Date:	10/01/22	Revision / Upgrade Description:		
Drawn:	C Group	First Issue		
Checked:	B. Ormshaw			
Approved:	D. Cross			



Hutchison 3G UK Limited
Star House, 20 Grenfell Road
Maidenhead, SL6 1EH
Tel: 01628 765 000
Fax: 01628 765 001

H3G Base Station Information line:
0845 6043000
Available 8am-8pm Monday to Friday

Design Consultant & Principal Contractor:



WHP Telecoms
Unit 1 Maple Park,
Low Fields Avenue, Leeds
LS12 6HH

Tel: 01133023550
e-mail: info@whptelecoms.com

Site Name: KINETIC HOUSE

Site ID: 1434902

Address:
44 HATTON GARDENS
CLERKENWELL
CAMDEN
LONDON
EC1N 8ER

Title: 002 SITE LOCATION PLAN

Project: 3UK UNILATERAL

Purpose of Issue: GENERAL ARRANGEMENT

EE Cell ID:	MBNL Cell ID:	3UK Cell ID:
50014	ISL148	EC0149

Master Drawing No: 1434902_ISL148_50014_EC0149_M001

Issue: A




Asset Reference	Asset Description:	Asset Status:	Antenna / Dish / MHA / RRU / Equipment Access Description:	Asset Reference	Asset Description:	Asset Status:	Antenna / Dish / MHA / RRU / Equipment Access Description:	Asset Reference	Asset Description:	Asset Status:	Antenna / Dish / MHA / RRU / Equipment Access Description:
EA1-EC1	Antennas	Remove	Rooftop worker	CAB1-3	Cabinets	Installed	Unrestricted Access	ERS1-12	ERS	Proposed	Rooftop worker
A1-C1	Antennas	Proposed	Rooftop worker	CAB4-5	Cabinet	Remove	Unrestricted Access	PR1-6	Passive Router	Proposed	Rooftop worker
GPS1	GPS Node	Proposed	Rooftop worker	CAB6	Cabinets	Proposed	Unrestricted Access	BT1-6	BOB Top	Proposed	Rooftop worker
				TD1	Dish	Installed	Rooftop worker	BB1-2	BOB Bottom	Proposed	Unrestricted Access
								RRU1-5	RRU	Remove	Unrestricted Access


NOTES:

1. ALL DIMENSIONS IN MM UNLESS OTHERWISE NOTED.

DEFINED ACCESS ROUTE DESCRIPTION FROM SITE ENTRANCE TO THE EQUIPMENT:

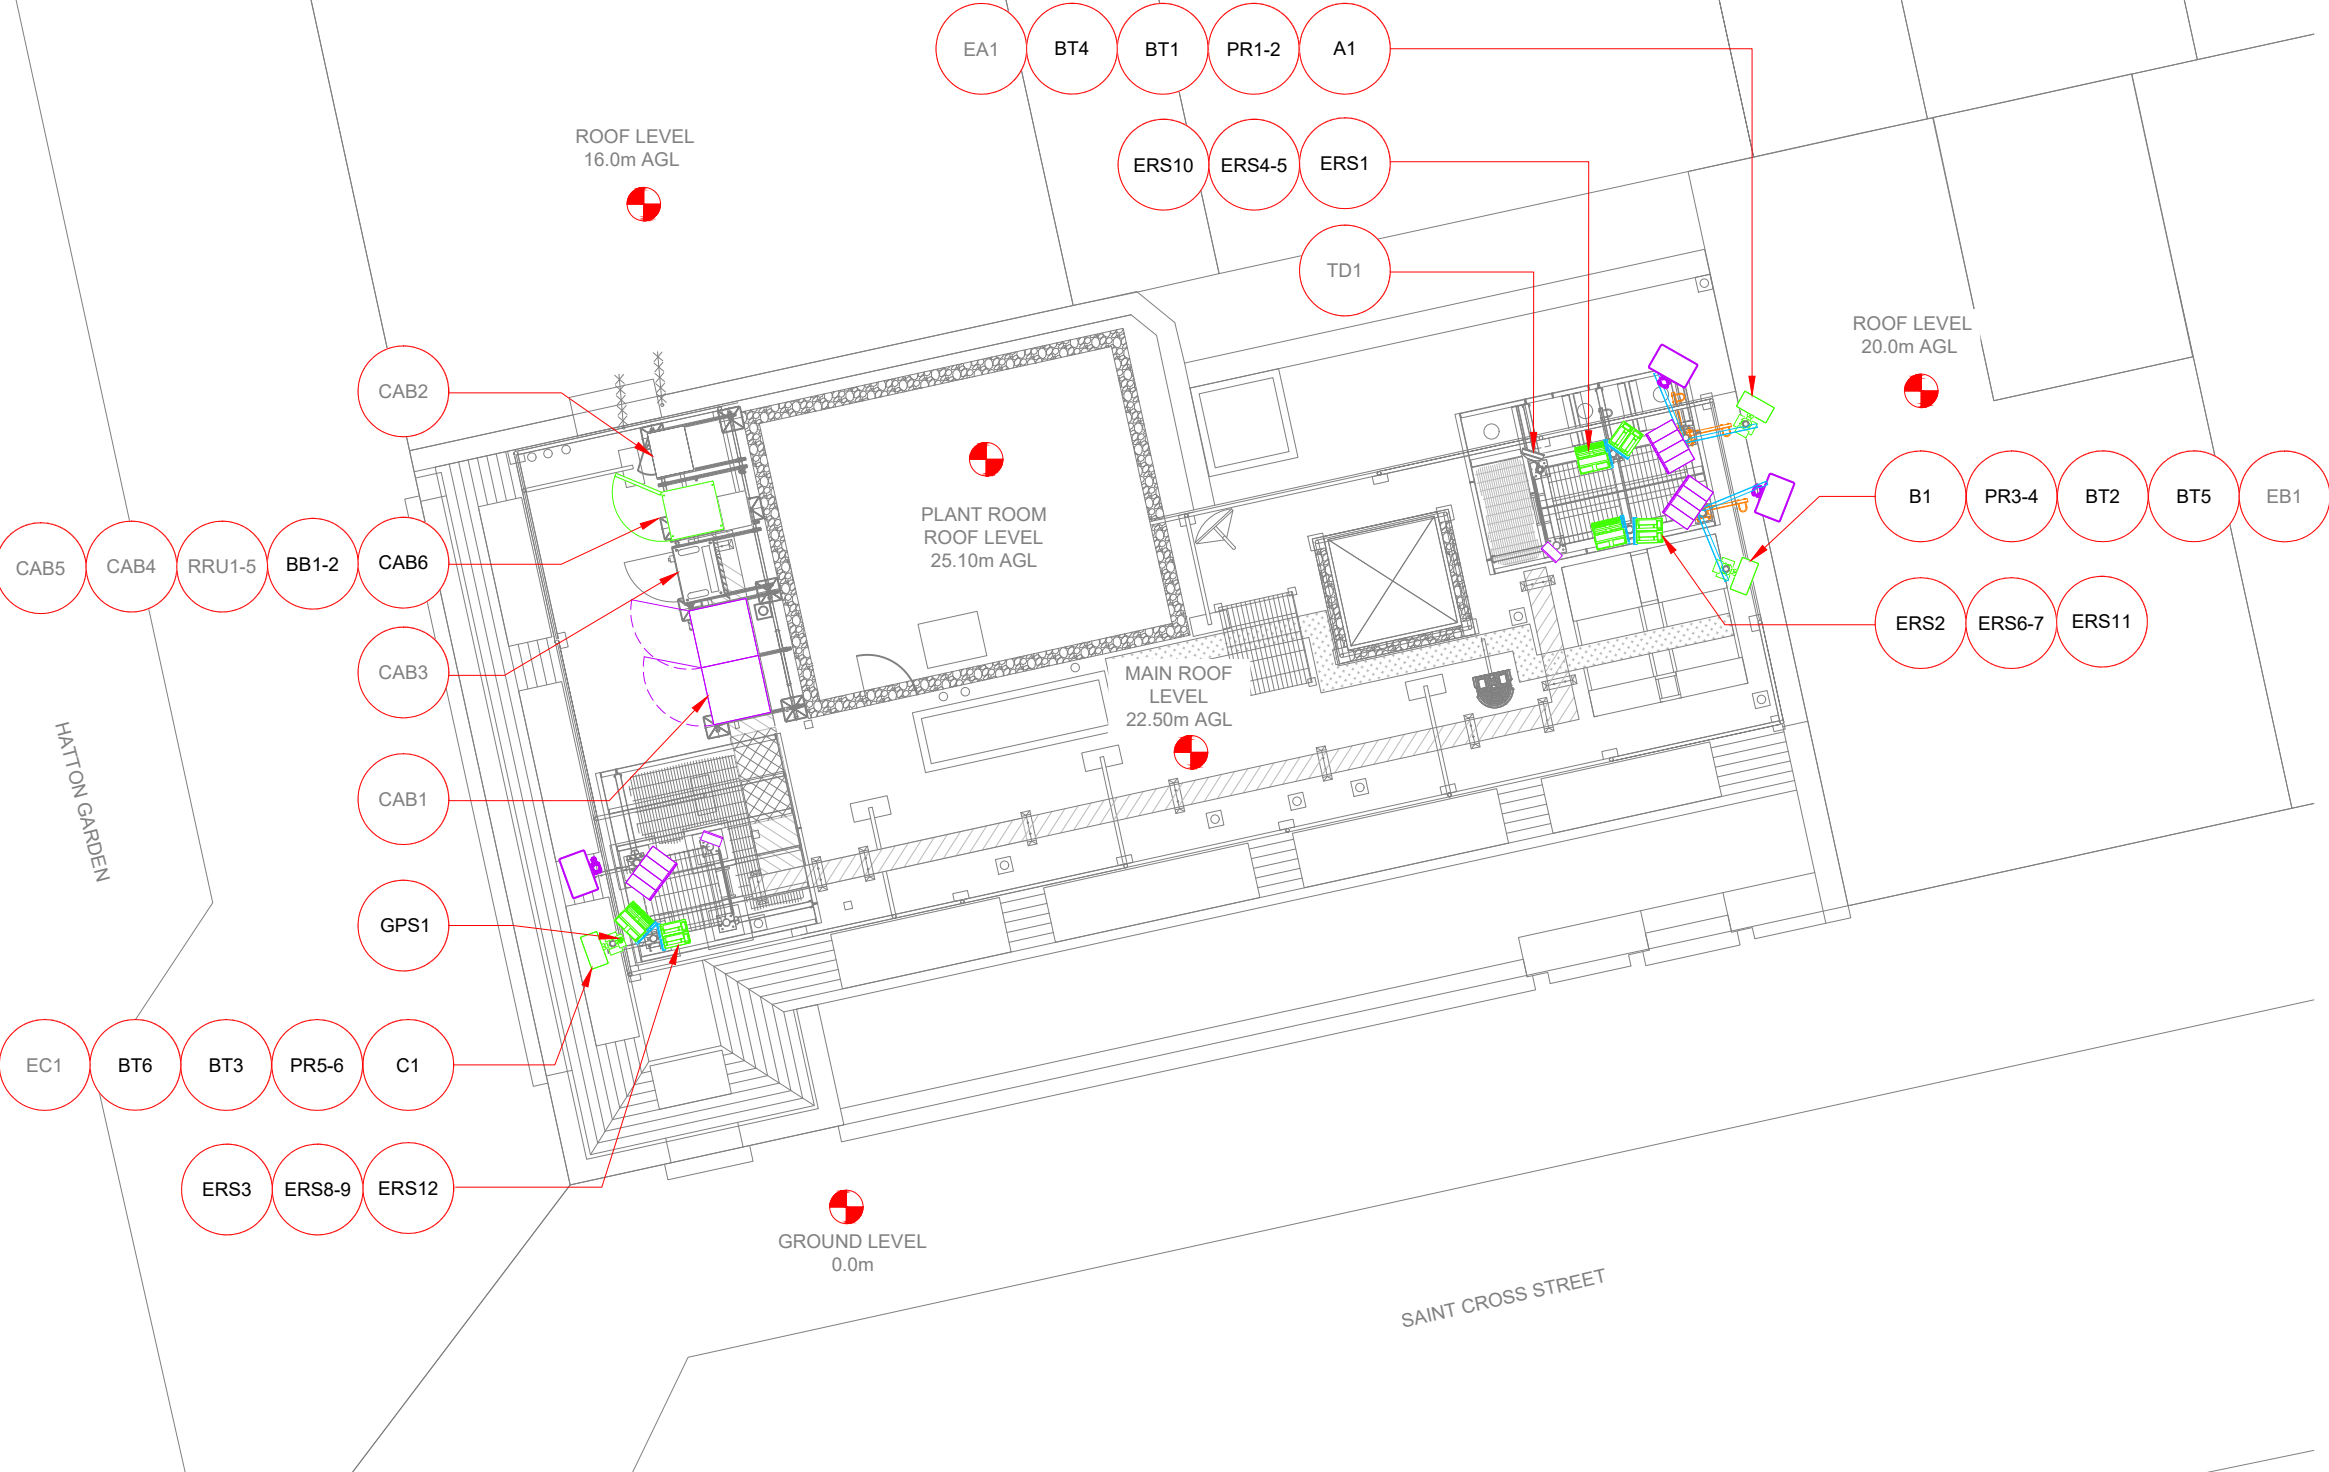

Master:	MBNL / EE / H3G:	Project:	Purpose of Issue:	Issue:
M001	H3G	3UK UNILATERAL	Planning	A
Date:	10/01/22	Revision / Upgrade Description:		
Drawn:	C Group	First Issue		
Checked:	B. Ormshaw			
Approved:	D. Cross			
		Hutchison 3G UK Limited Star House, 20 Grenfell Road Maidenhead, SL6 1EH Tel: 01628 765 000 Fax: 01628 765 001 H3G Base Station Information line: 0845 6043000 Available 8am-8pm Monday to Friday		
Design Consultant & Principal Contractor:				
		WHP Telecoms Unit 1 Maple Park, Low Fields Avenue, Leeds LS12 6HH Tel: 01133023550 e-mail: info@whptelecoms.com		
Site Name:				
KINETIC HOUSE				
Site ID:				
1434902				
Address:				
44 HATTON GARDENS CLERKENWELL CAMDEN LONDON EC1N 8ER				
Title:				
003 ACCESS PLAN				
Project:				
3UK UNILATERAL				
Purpose of Issue:				
GENERAL ARRANGEMENT				
EE Cell ID:		MBNL Cell ID:		3UK Cell ID:
50014		ISL148		EC0149
Master Drawing No:				Issue:
1434902_ISL148_50014_EC0149_M001				A

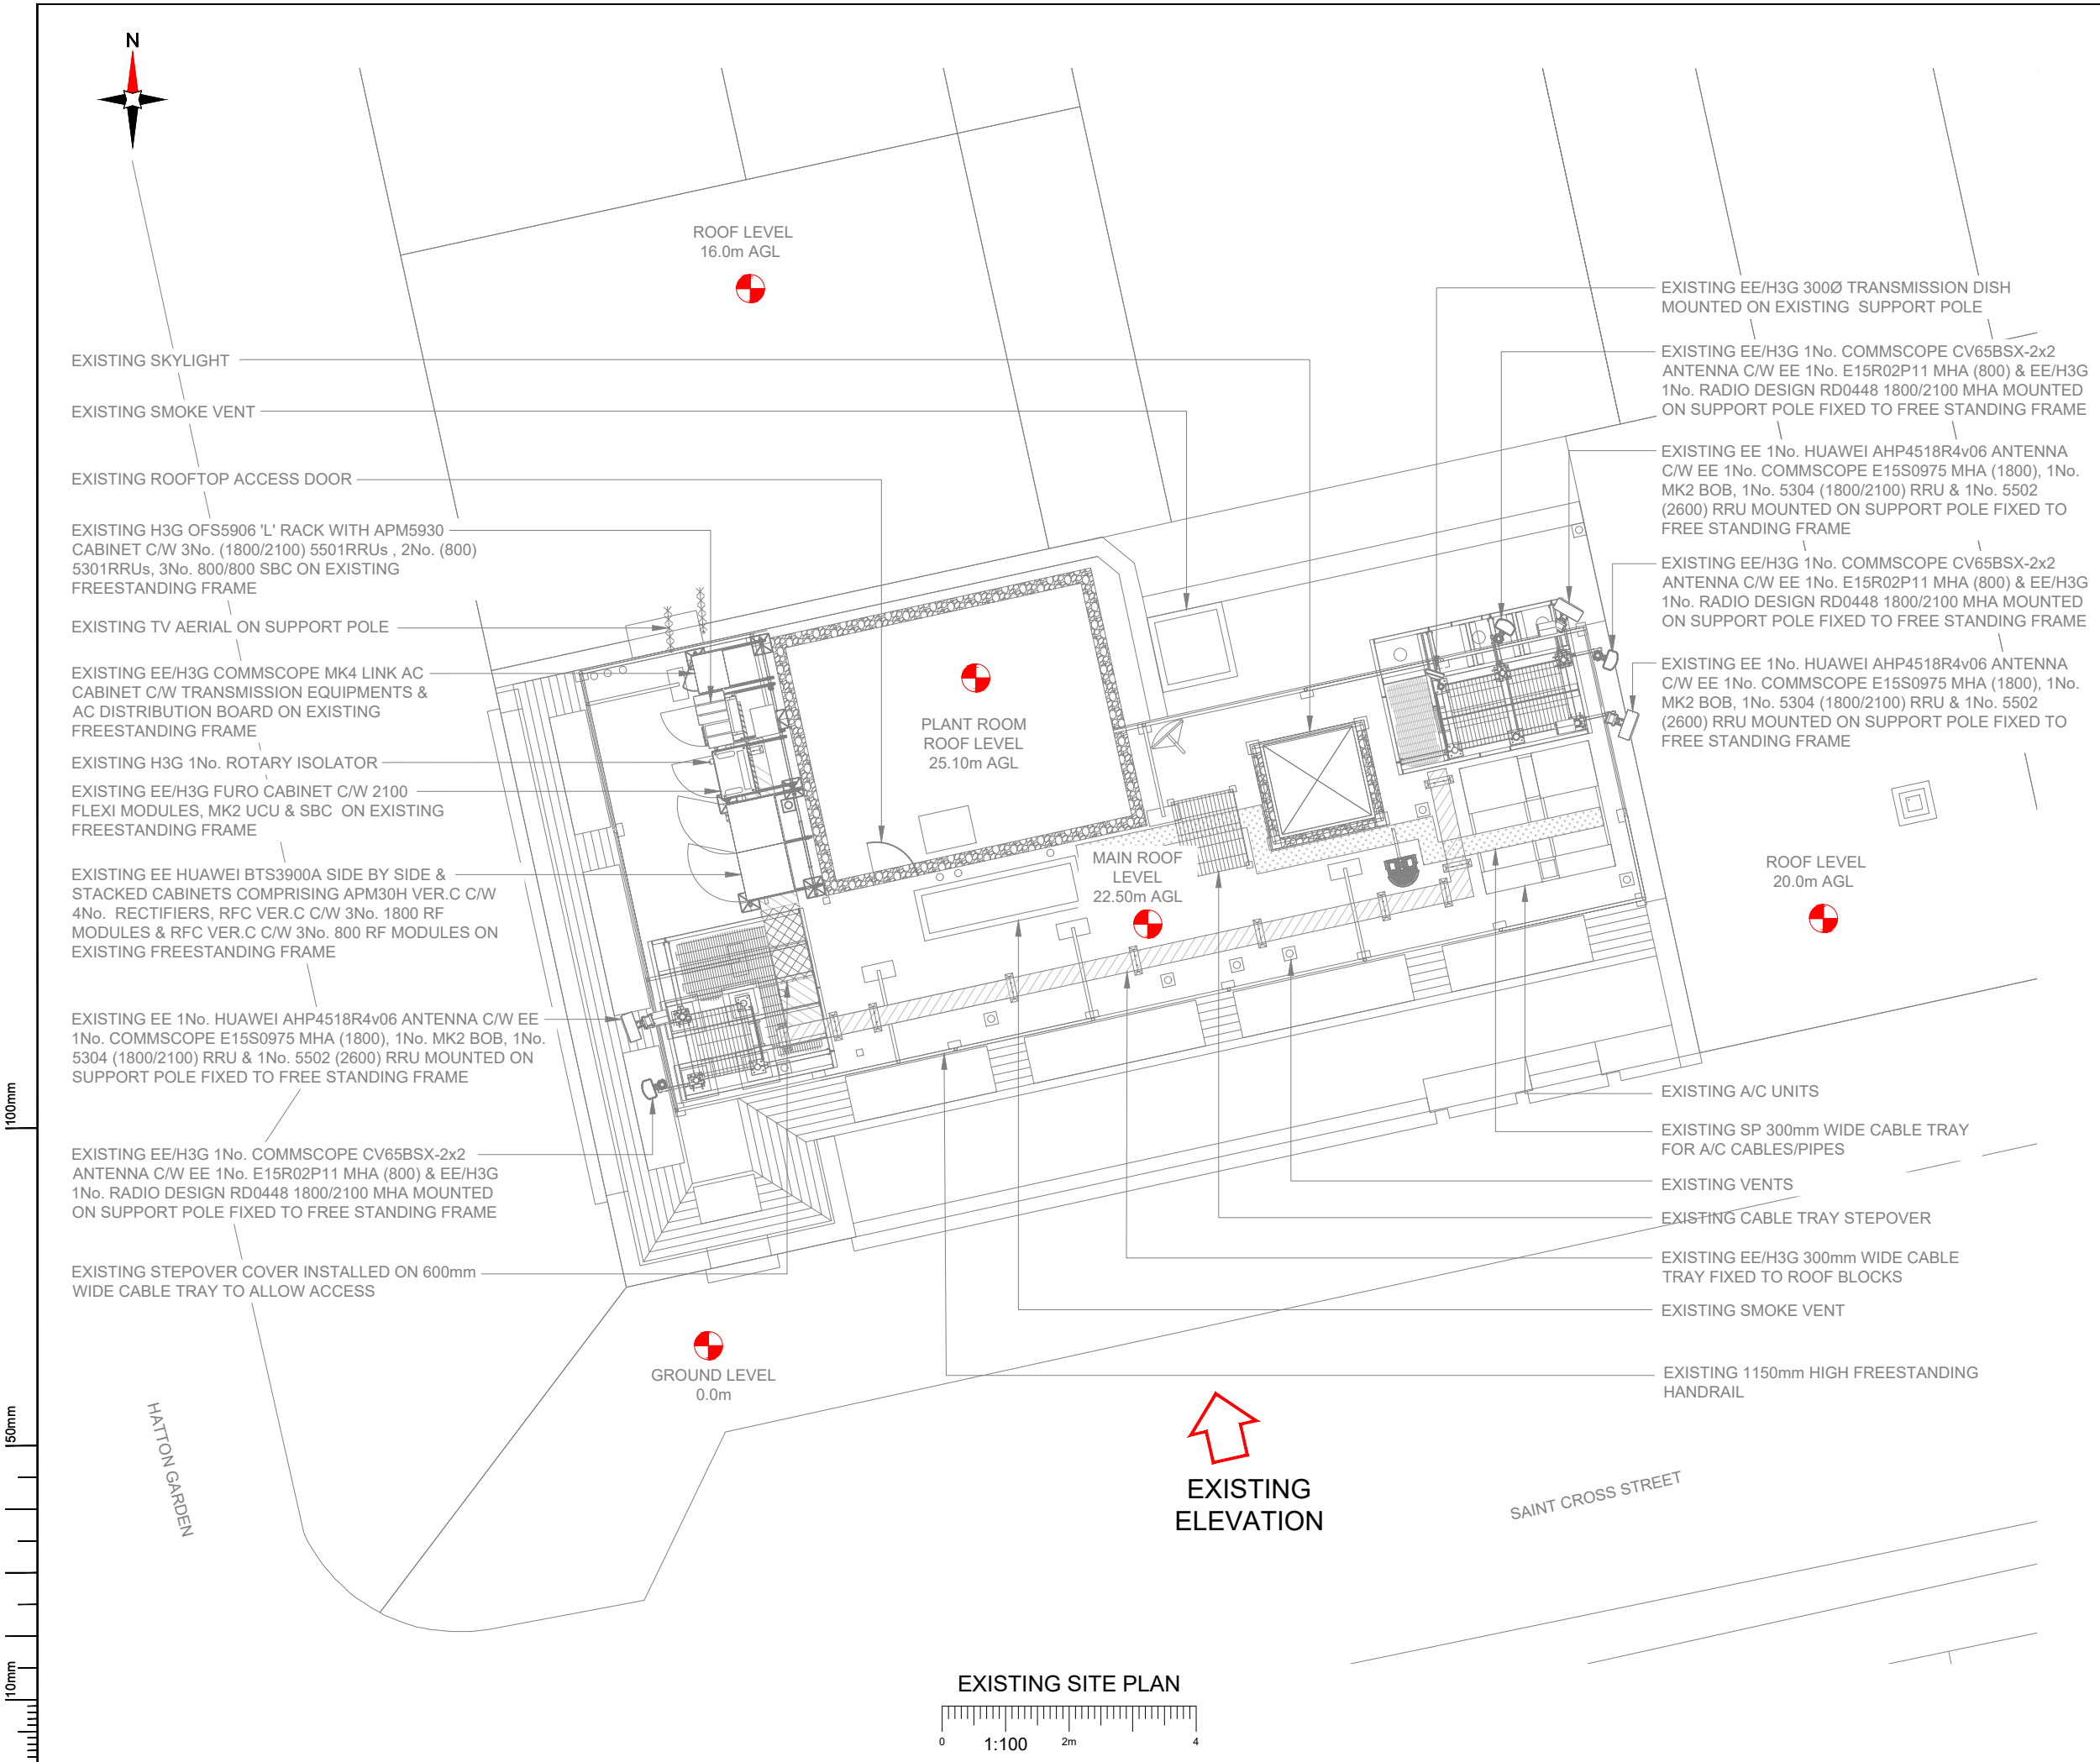

NOTES:

1. ALL DIMENSIONS IN MM UNLESS OTHERWISE NOTED.

Master:	MBNL / EE / H3G:	Project:	Purpose of Issue:	Issue:
M001	H3G	3UK UNILATERAL	Planning	A
Date:	10/01/22	Revision / Upgrade Description:		
Drawn:	C Group	First Issue		
Checked:	B. Ormshaw			
Approved:	D. Cross			



Hutchison 3G UK Limited
Star House, 20 Grenfell Road
Maidenhead, SL6 1EH
Tel: 01628 765 000
Fax: 01628 765 001

H3G Base Station Information line:
0845 6043000
Available 8am-8pm Monday to Friday

Design Consultant & Principal Contractor:



WHP Telecoms
Unit 1 Maple Park,
Low Fields Avenue, Leeds
LS12 6HH

Tel: 01133023550
e-mail: info@whptelecoms.com

Site Name:

KINETIC HOUSE

Site ID:

1434902

Address:

44 HATTON GARDENS
CLERKENWELL
CAMDEN
LONDON
EC1N 8ER

Title:

100 EXISTING SITE PLAN

Project:

3UK UNILATERAL

Purpose of Issue:

GENERAL ARRANGEMENT

EE Cell ID:	MBNL Cell ID:	3UK Cell ID:
50014	ISL148	EC0149

Master Drawing No:

1434902_ISL148_50014_EC0149_M001


Issue:

A

100mm

50mm

10mm

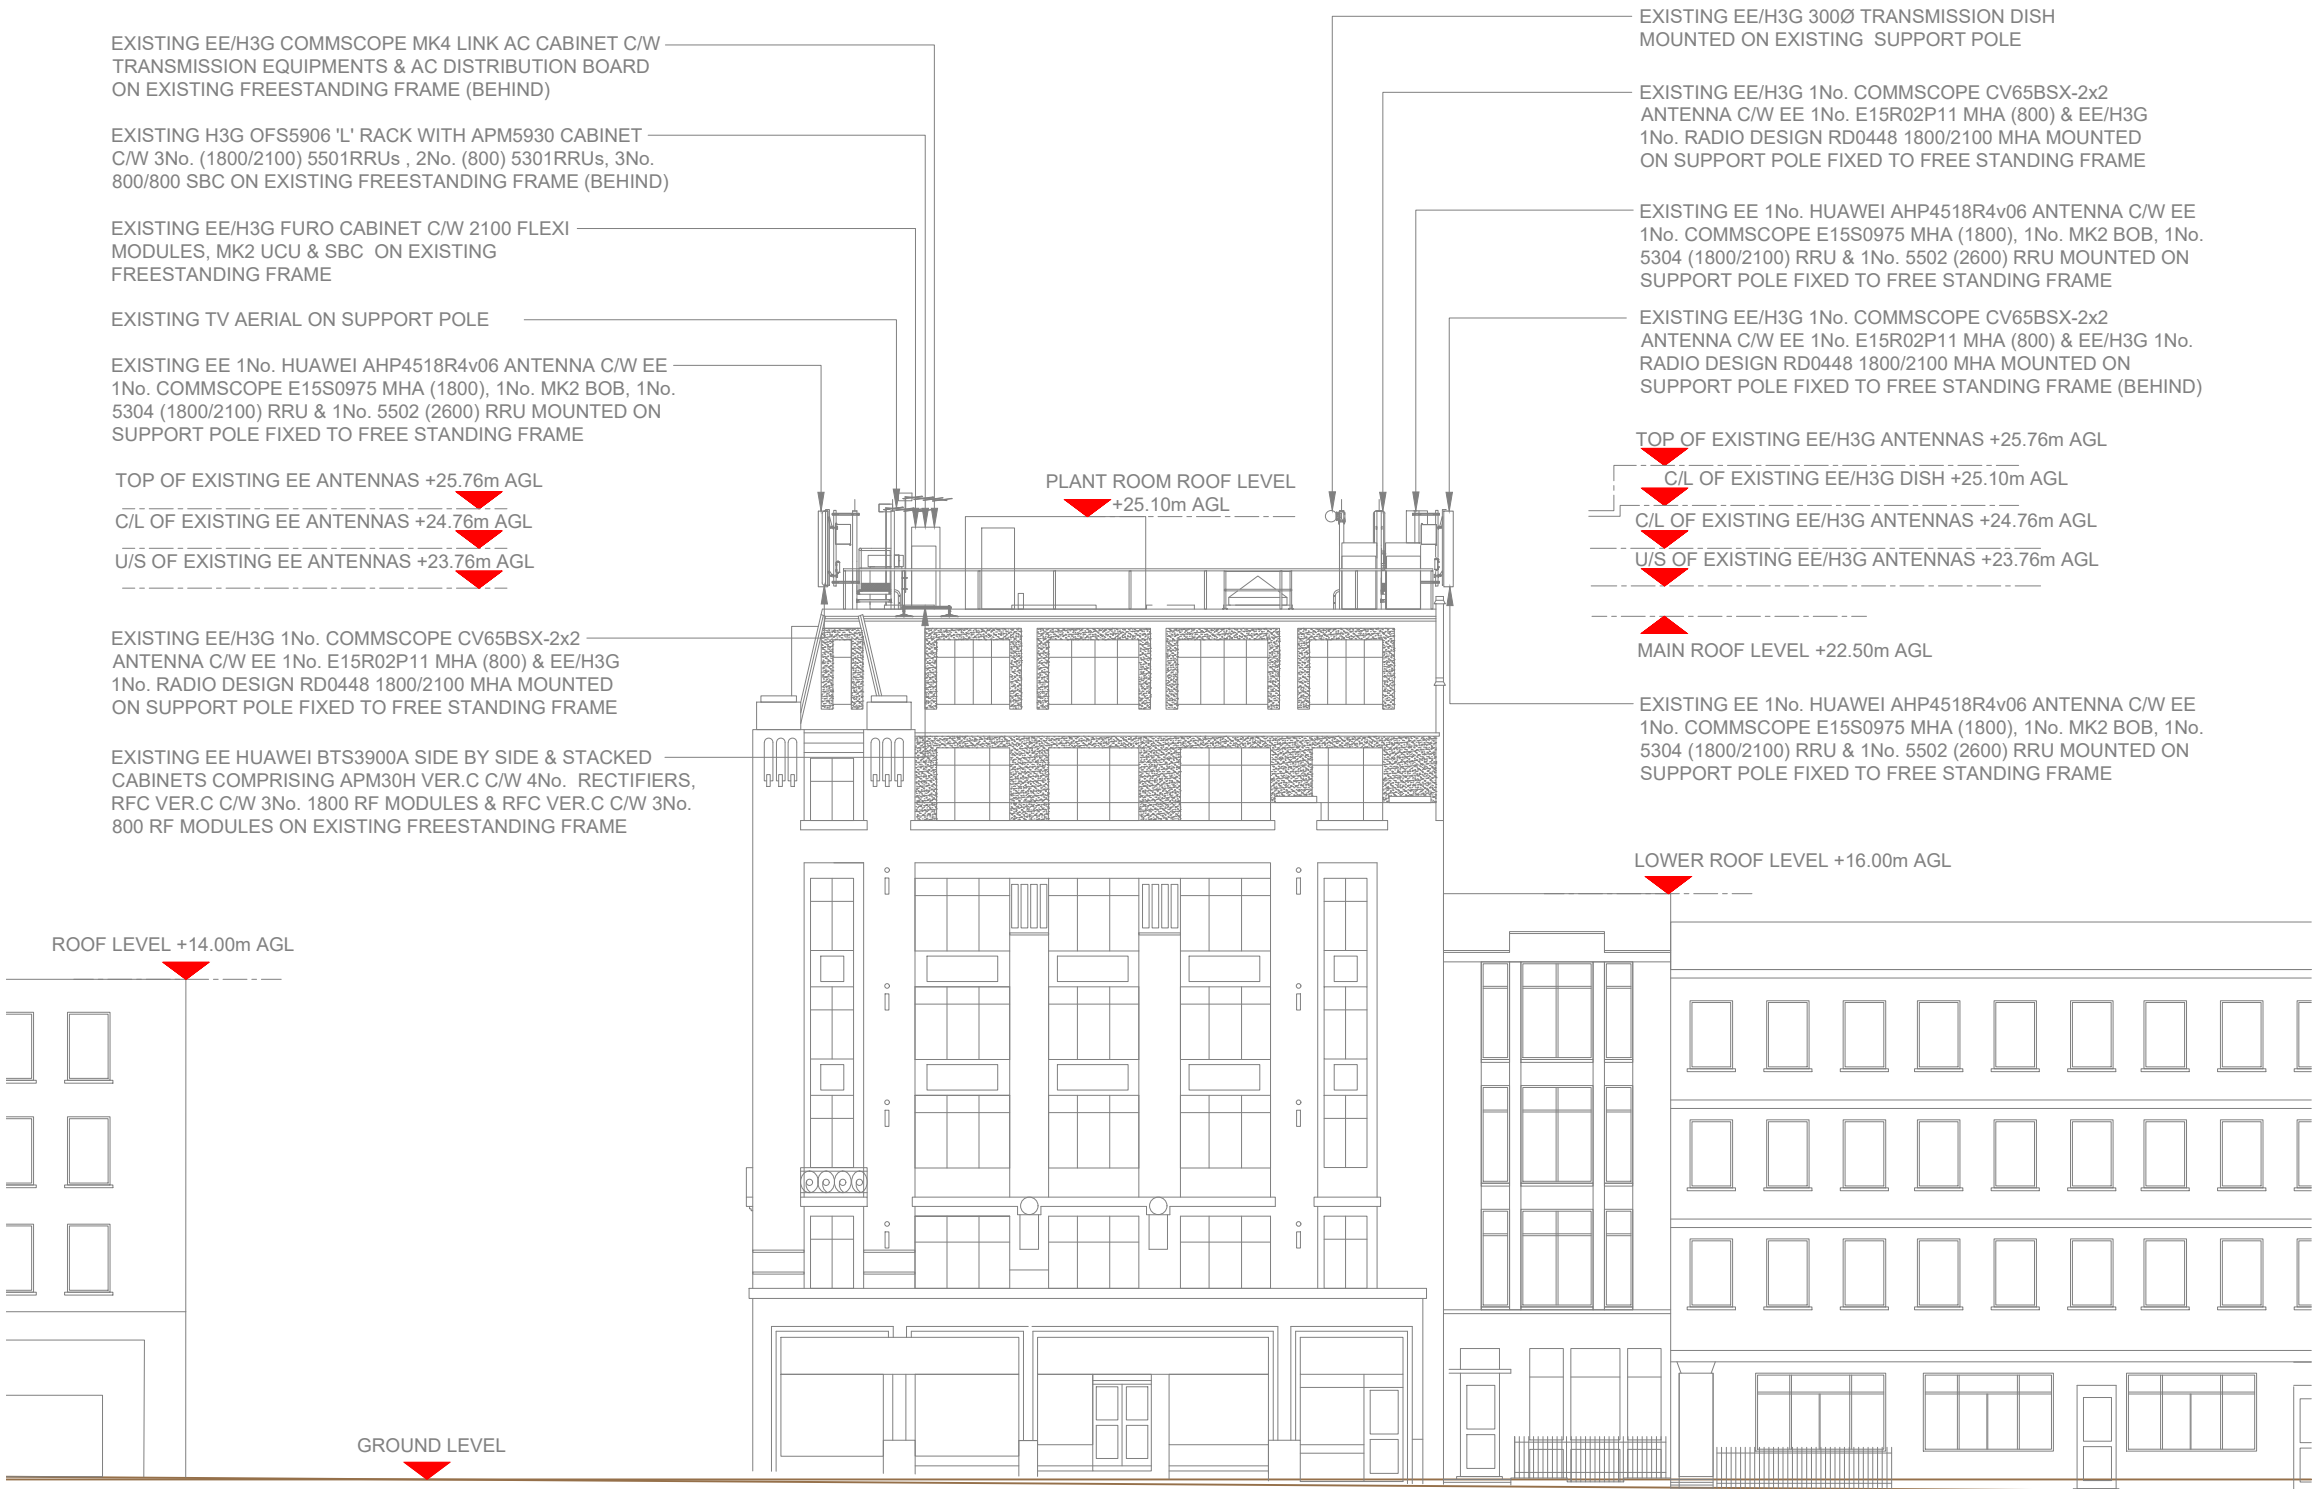

EXISTING SITE ELEVATION



- NOTES:
- ALL DIMENSIONS IN MM UNLESS OTHERWISE NOTED.

Master:	MBNL / EE / H3G:	Project:	Purpose of Issue:	Issue:
M001	H3G	3UK UNILATERAL	Planning	A
Date:	10/01/22	Revision / Upgrade Description:		
Drawn:	C Group	First Issue		
Checked:	B. Ormshaw			
Approved:	D. Cross			



Hutchison 3G UK Limited
Star House, 20 Grenfell Road
Maidenhead, SL6 1EH
Tel: 01628 765 000
Fax: 01628 765 001

H3G Base Station Information line:
0845 6043000
Available 8am-8pm Monday to Friday


Design Consultant & Principal Contractor:



WHP Telecoms
Unit 1 Maple Park,
Low Fields Avenue, Leeds
LS12 6HH

Tel: 01133023550
e-mail: info@whptelecoms.com

Site Name:	KINETIC HOUSE		
Site ID:	1434902		
Address:	44 HATTON GARDENS CLERKENWELL CAMDEN LONDON EC1N 8ER		
Title:	150 EXISTING SITE ELEVATION		
Project:	3UK UNILATERAL		
Purpose of Issue:	GENERAL ARRANGEMENT		
EE Cell ID:	MBNL Cell ID:	3UK Cell ID:	
50014	ISL148	EC0149	
Master Drawing No:			Issue:
1434902_ISL148_50014_EC0149_M001			A

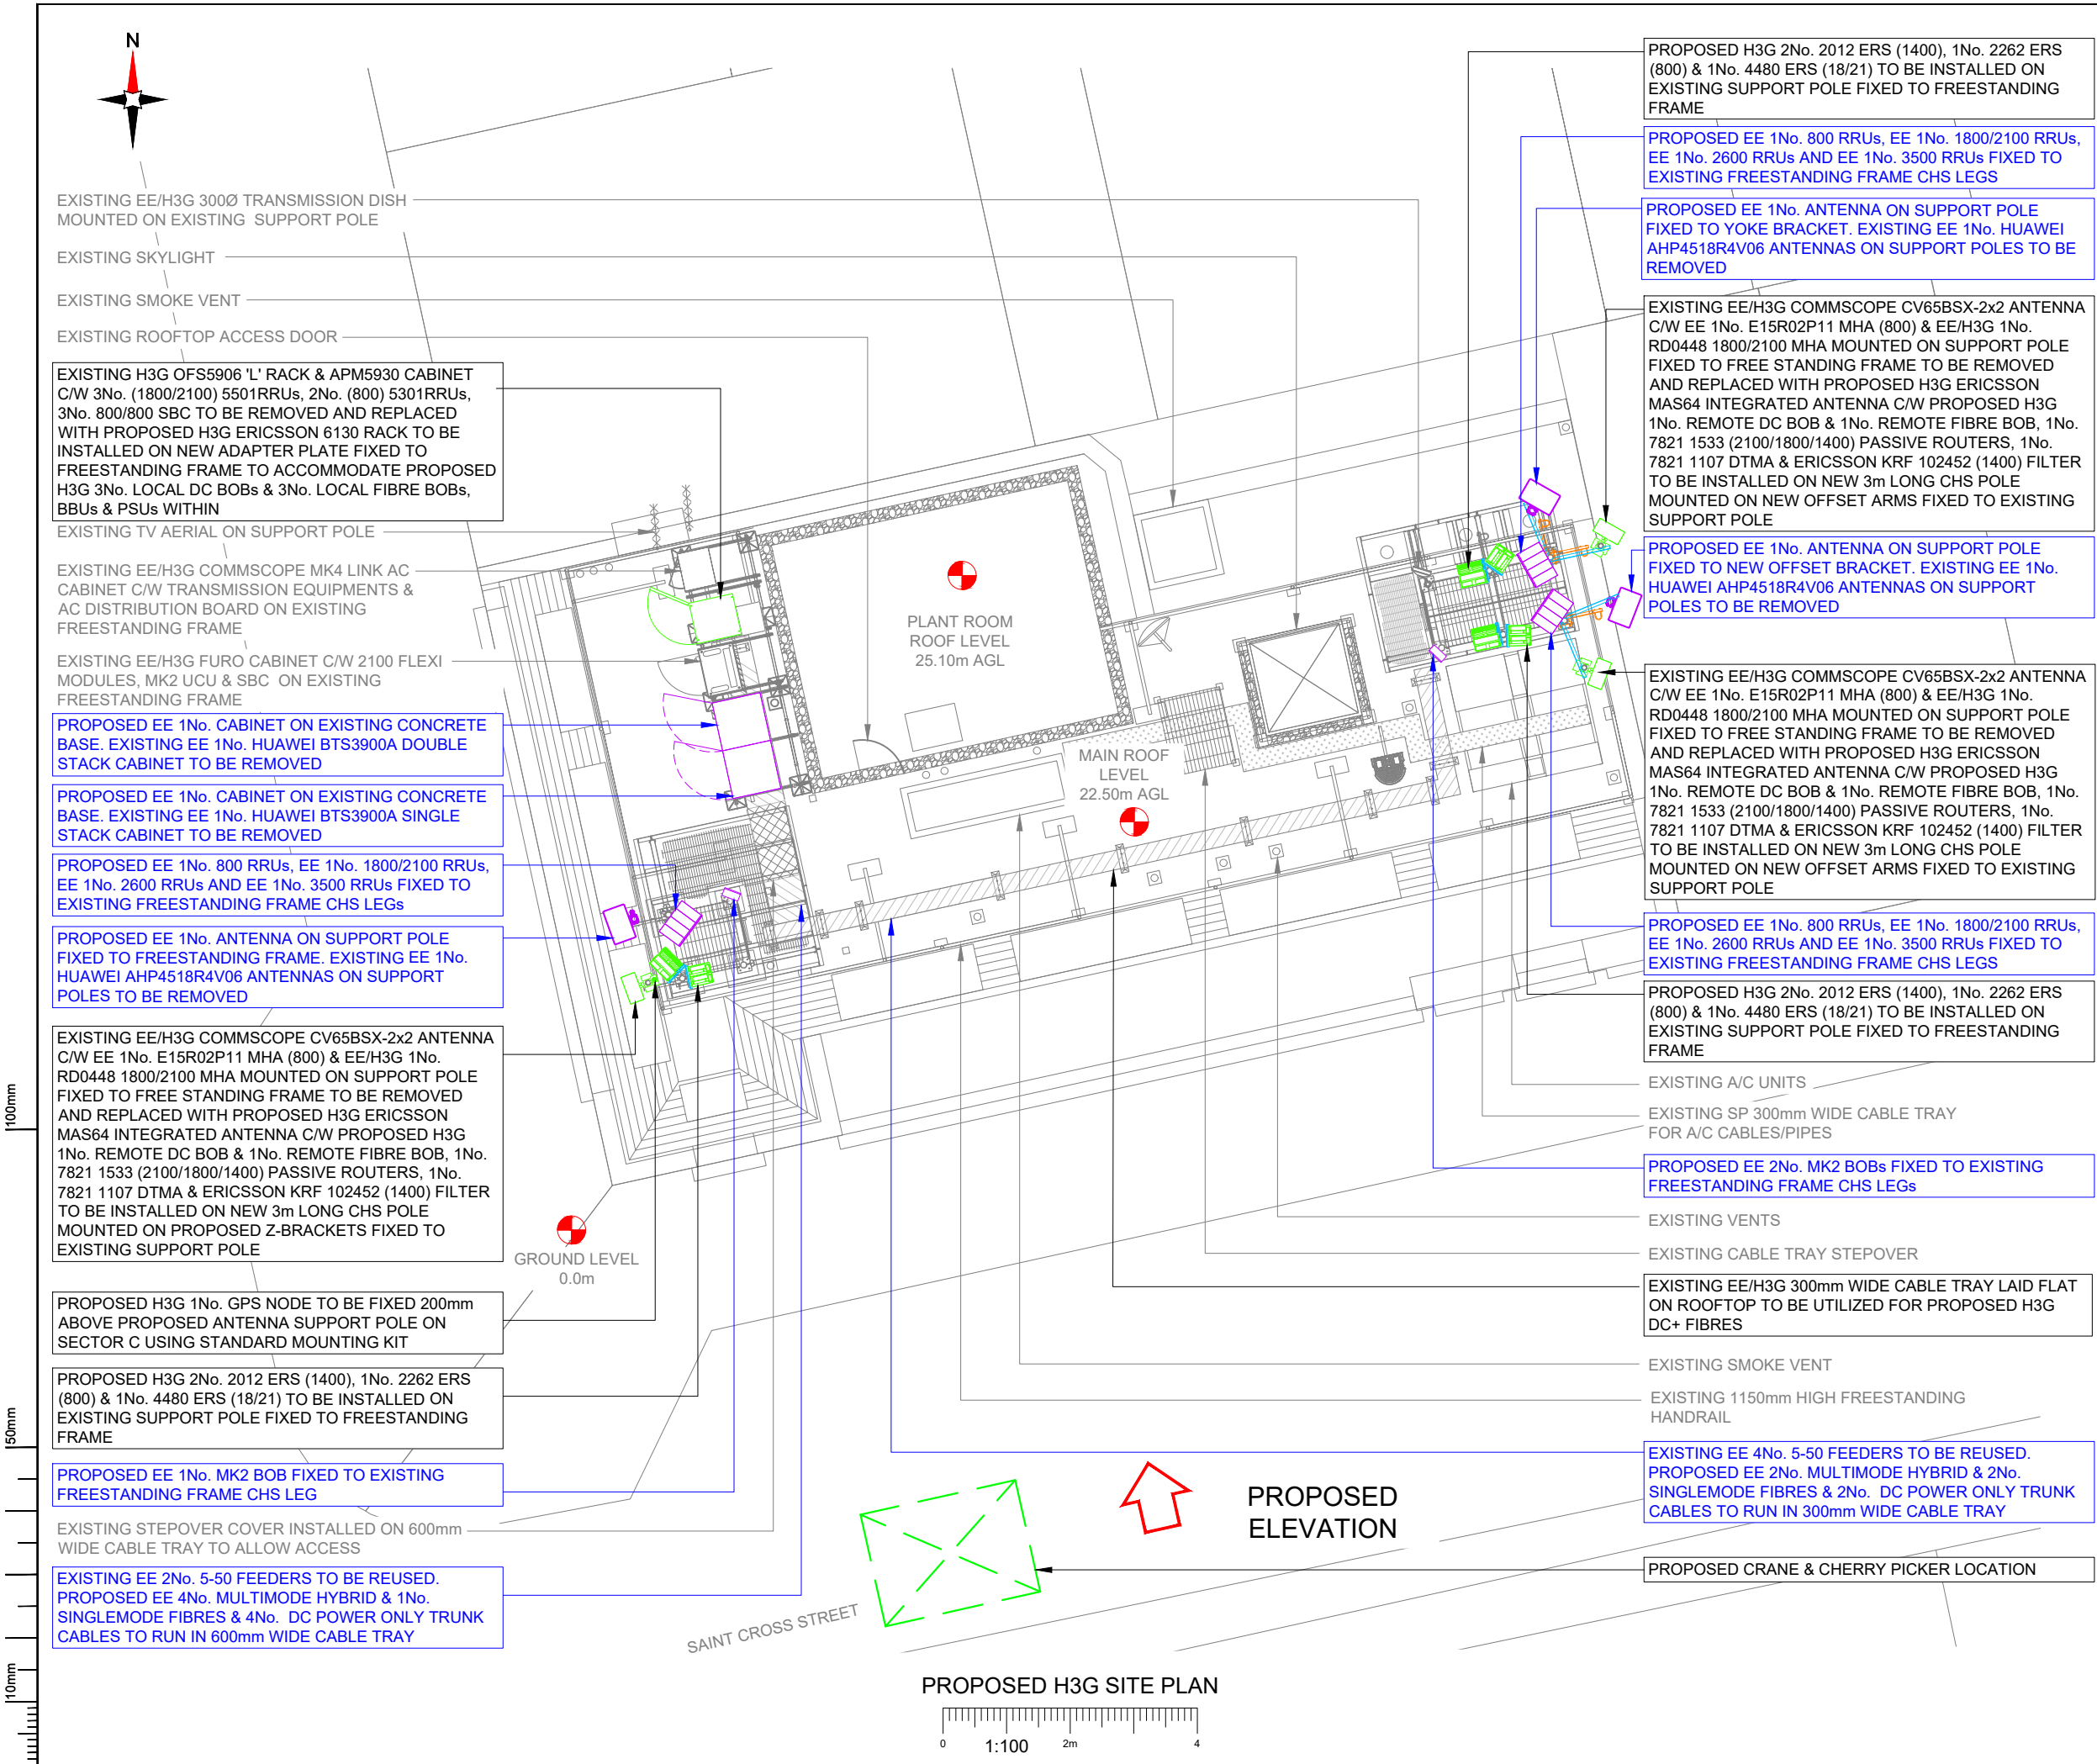

- NOTES:
- ALL DIMENSIONS IN MM UNLESS OTHERWISE NOTED.
 - PROPOSED CRANE OR CHERRY PICKER LOCATION:

REFER TO DRAWING
"15072_23-04-2021_1434902_ISL148_50014_EC0149_KINETIC HOUSE_29.09.20_EA_RevA" FOR FURTHER INFORMATION

Master:	MBNL / EE / H3G:	Project:	Purpose of Issue:	Issue:
M001	H3G	3UK UNILATERAL	Planning	A
Date:	10/01/22	Revision / Upgrade Description:		
Drawn:	C Group	First Issue		
Checked:	B. Ormshaw			
Approved:	D. Cross			



Hutchison 3G UK Limited
Star House, 20 Grenfell Road
Maidenhead, SL6 1EH
Tel: 01628 765 000
Fax: 01628 765 001

H3G Base Station Information line:
0845 6043000
Available 8am-8pm Monday to Friday

Design Consultant & Principal Contractor:



WHP Telecoms
Unit 1 Maple Park,
Low Fields Avenue, Leeds
LS12 6HH

Tel: 01133023550
e-mail: info@whptelecoms.com

Site Name: KINETIC HOUSE

Site ID: 1434902

Address: 44 HATTON GARDENS
CLERKENWELL
CAMDEN
LONDON
EC1N 8ER

Title: 210 PROPOSED H3G SITE PLAN

Project: 3UK UNILATERAL

Purpose of Issue: GENERAL ARRANGEMENT

EE Cell ID: 50014	MBNL Cell ID: ISL148	3UK Cell ID: EC0149
----------------------	-------------------------	------------------------

Master Drawing No: 1434902_ISL148_50014_EC0149_M001	Issue: A
--	-------------

EXISTING EE/H3G COMMSCOPE MK4 LINK AC CABINET C/W TRANSMISSION EQUIPMENTS & AC DISTRIBUTION BOARD ON EXISTING FREESTANDING FRAME (BEHIND)

EXISTING H3G OFS5906 'L' RACK & APM5930 CABINET C/W 3No. (1800/2100) 5501RRUs, 2No. (800) 5301RRUs, 3No. 800/800 SBC TO BE REMOVED AND REPLACED WITH PROPOSED H3G ERICSSON 6130 RACK TO BE INSTALLED ON NEW ADAPTER PLATE FIXED TO FREESTANDING FRAME TO ACCOMMODATE PROPOSED H3G 3No. LOCAL DC BOBs & 3No. LOCAL FIBRE BOBs, BBUs & PSUs WITHIN (BEHIND)

EXISTING EE/H3G FURO CABINET C/W 2100 FLEXI MODULES, MK2 UCU & SBC ON EXISTING FREESTANDING FRAME

PROPOSED EE 1No. MK2 BOB FIXED TO EXISTING FREESTANDING FRAME CHS LEG

EXISTING TV AERIAL ON SUPPORT POLE

PROPOSED EE 1No. 800 RRUs, EE 1No. 1800/2100 RRUs, EE 1No. 2600 RRUs AND EE 1No. 3500 RRUs FIXED TO EXISTING FREESTANDING FRAME CHS LEGs

PROPOSED H3G 1No. GPS NODE TO BE FIXED 200mm ABOVE PROPOSED ANTENNA SUPPORT POLE ON SECTOR C USING STANDARD MOUNTING KIT

PROPOSED EE 1No. ANTENNA ON SUPPORT POLE FIXED TO FREESTANDING FRAME. EXISTING EE 1No. HUAWEI AHP4518R4V06 ANTENNAS ON SUPPORT POLES TO BE REMOVED (BEHIND)

TOP OF EXISTING EE ANTENNAS +25.76m AGL

C/L OF EXISTING EE ANTENNAS +24.76m AGL

U/S OF EXISTING EE ANTENNAS +23.76m AGL

EXISTING EE/H3G COMMSCOPE CV65BSX-2x2 ANTENNA C/W EE 1No. E15R02P11 MHA (800) & EE/H3G 1No. RD0448 1800/2100 MHA MOUNTED ON SUPPORT POLE FIXED TO FREE STANDING FRAME TO BE REMOVED AND REPLACED WITH PROPOSED H3G ERICSSON MAS64 INTEGRATED ANTENNA C/W PROPOSED H3G 1No. REMOTE DC BOB & 1No. REMOTE FIBRE BOB, 1No. 7821 1533 (2100/1800/1400) PASSIVE ROUTERS, 1No. 7821 1107 DTMA & ERICSSON KRF 102452 (1400) FILTER TO BE INSTALLED ON NEW 3m LONG CHS POLE MOUNTED ON PROPOSED Z-BRACKETS FIXED TO EXISTING SUPPORT POLE

PROPOSED H3G 2No. 2012 ERS (1400), 1No. 2262 ERS (800) & 1No. 4480 ERS (18/21) TO BE INSTALLED ON EXISTING SUPPORT POLE FIXED TO FREESTANDING FRAME

PROPOSED EE 1No. CABINET ON EXISTING CONCRETE BASE. EXISTING EE 1No. HUAWEI BTS3900A DOUBLE STACK CABINET TO BE REMOVED

PROPOSED EE 1No. CABINET ON EXISTING CONCRETE BASE. EXISTING EE 1No. HUAWEI BTS3900A SINGLE STACK CABINET TO BE REMOVED

EXISTING EE/H3G 300Ø TRANSMISSION DISH MOUNTED ON EXISTING SUPPORT POLE

PROPOSED H3G 2No. 2012 ERS (1400), 1No. 2262 ERS (800) & 1No. 4480 ERS (18/21) TO BE INSTALLED ON EXISTING SUPPORT POLE FIXED TO FREESTANDING FRAME (BEHIND)

EXISTING EE/H3G COMMSCOPE CV65BSX-2x2 ANTENNA C/W EE 1No. E15R02P11 MHA (800) & EE/H3G 1No. RD0448 1800/2100 MHA MOUNTED ON SUPPORT POLE FIXED TO FREE STANDING FRAME TO BE REMOVED AND REPLACED WITH PROPOSED H3G ERICSSON MAS64 INTEGRATED ANTENNA C/W PROPOSED H3G 1No. REMOTE DC BOB & 1No. REMOTE FIBRE BOB, 1No. 7821 1533 (2100/1800/1400) PASSIVE ROUTERS, 1No. 7821 1107 DTMA & ERICSSON KRF 102452 (1400) FILTER TO BE INSTALLED ON NEW 3m LONG CHS POLE MOUNTED ON NEW OFFSET ARMS FIXED TO EXISTING SUPPORT POLE

PROPOSED EE 1No. 800 RRUs, EE 1No. 1800/2100 RRUs, EE 1No. 2600 RRUs AND EE 1No. 3500 RRUs FIXED TO EXISTING FREESTANDING FRAME CHS LEGS

PROPOSED EE 1No. ANTENNA ON NEW OFFSET ARM FIXED TO FREESTANDING FRAME. EXISTING EE 1No. HUAWEI AHP4518R4V06 ANTENNAS ON SUPPORT POLES TO BE REMOVED

TOP OF PROPOSED H3G ANTENNAS +26.01m AGL

C/L OF EXISTING EE/H3G DISH +25.10m AGL

C/L OF PROPOSED H3G ANTENNAS +24.76m AGL

U/S OF PROPOSED H3G ANTENNAS +23.51m AGL

MAIN ROOF LEVEL +22.50m AGL

EXISTING EE/H3G COMMSCOPE CV65BSX-2x2 ANTENNA C/W EE 1No. E15R02P11 MHA (800) & EE/H3G 1No. RD0448 1800/2100 MHA MOUNTED ON SUPPORT POLE FIXED TO FREE STANDING FRAME TO BE REMOVED AND REPLACED WITH PROPOSED H3G ERICSSON MAS64 INTEGRATED ANTENNA C/W PROPOSED H3G 1No. REMOTE DC BOB & 1No. REMOTE FIBRE BOB, 1No. 7821 1533 (2100/1800/1400) PASSIVE ROUTERS, 1No. 7821 1107 DTMA & ERICSSON KRF 102452 (1400) FILTER TO BE INSTALLED ON NEW 3m LONG CHS POLE MOUNTED ON NEW OFFSET ARMS FIXED TO EXISTING SUPPORT POLE

PROPOSED EE 1No. ANTENNA ON NEW OFFSET ARM FIXED TO FREESTANDING FRAME. EXISTING EE 1No. HUAWEI AHP4518R4V06 ANTENNAS ON SUPPORT POLES TO BE REMOVED

PROPOSED EE 1No. 800 RRUs, EE 1No. 1800/2100 RRUs, EE 1No. 2600 RRUs AND EE 1No. 3500 RRUs FIXED TO EXISTING FREESTANDING FRAME CHS LEGS

PROPOSED H3G 2No. 2012 ERS (1400), 1No. 2262 ERS (800) & 1No. 4480 ERS (18/21) TO BE INSTALLED ON EXISTING SUPPORT POLE FIXED TO FREESTANDING FRAME

 
PROPOSED EE 2No. MK2 BOBs FIXED TO EXISTING FREESTANDING FRAME CHS LEGs

PLANT ROOM ROOF LEVEL +25.10m AGL

LOWER ROOF LEVEL +16.00m AGL

GROUND LEVEL

PROPOSED H3G ELEVATION



NOTES:

1. ALL DIMENSIONS IN MM UNLESS OTHERWISE NOTED.

REFER TO DRAWING "15072_23-04-2021_1434902_ISL148_50014_EC0149_KINETIC HOUSE_29.09.20_EA_RevA" FOR FURTHER INFORMATION

Master:	MBNL / EE / H3G:	Project:	Purpose of Issue:	Issue:
M001	H3G	3UK UNILATERAL	Planning	A
Date:	10/01/22	Revision / Upgrade Description:		
Drawn:	C Group	First Issue		
Checked:	B. Ormshaw			
Approved:	D. Cross			



Hutchison 3G UK Limited
Star House, 20 Grenfell Road
Maidenhead, SL6 1EH
Tel: 01628 765 000
Fax: 01628 765 001

H3G Base Station Information line:
0845 6043000
Available 8am-8pm Monday to Friday

Design Consultant & Principal Contractor:



WHP Telecoms
Unit 1 Maple Park,
Low Fields Avenue, Leeds
LS12 6HH

Tel: 01133023550
e-mail: info@whptelecoms.com

Site Name: KINETIC HOUSE

Site ID: 1434902

Address: 44 HATTON GARDENS
CLERKENWELL
CAMDEN
LONDON
EC1N 8ER

Title: 260 PROPOSED H3G ELEVATION

Project: 3UK UNILATERAL

Purpose of Issue: GENERAL ARRANGEMENT

EE Cell ID:	MBNL Cell ID:	3UK Cell ID:
50014	ISL148	EC0149

Master Drawing No:	Issue:
1434902_ISL148_50014_EC0149_M001	A