




GROUND FLOOR HIGH LEVEL
SCALE 1:50

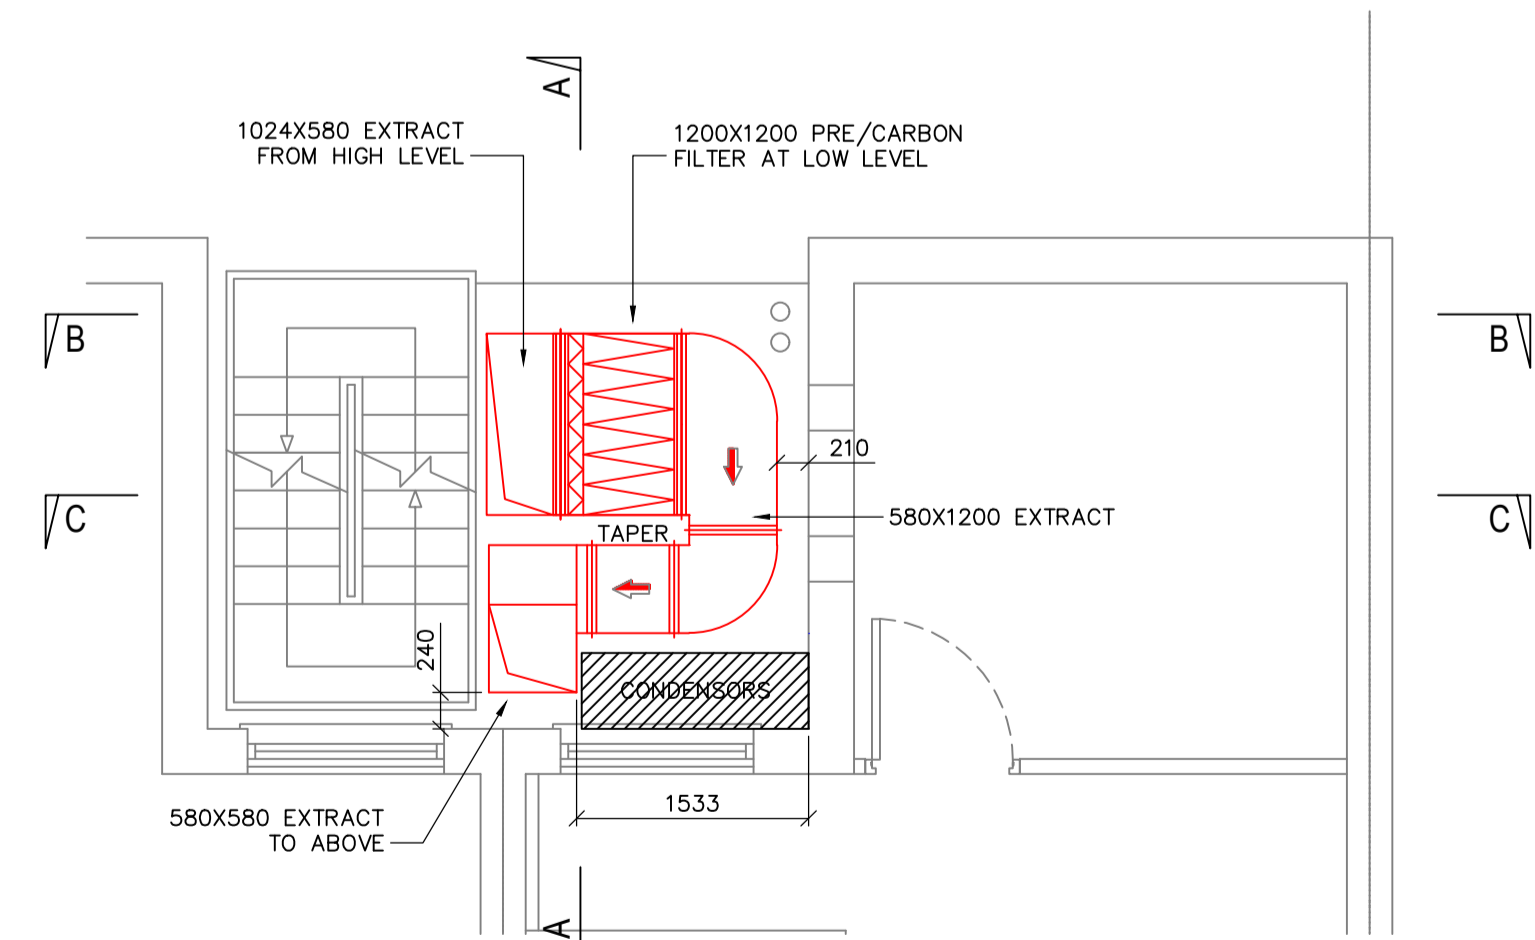


GROUND FLOOR LOW LEVEL
SCALE 1:50

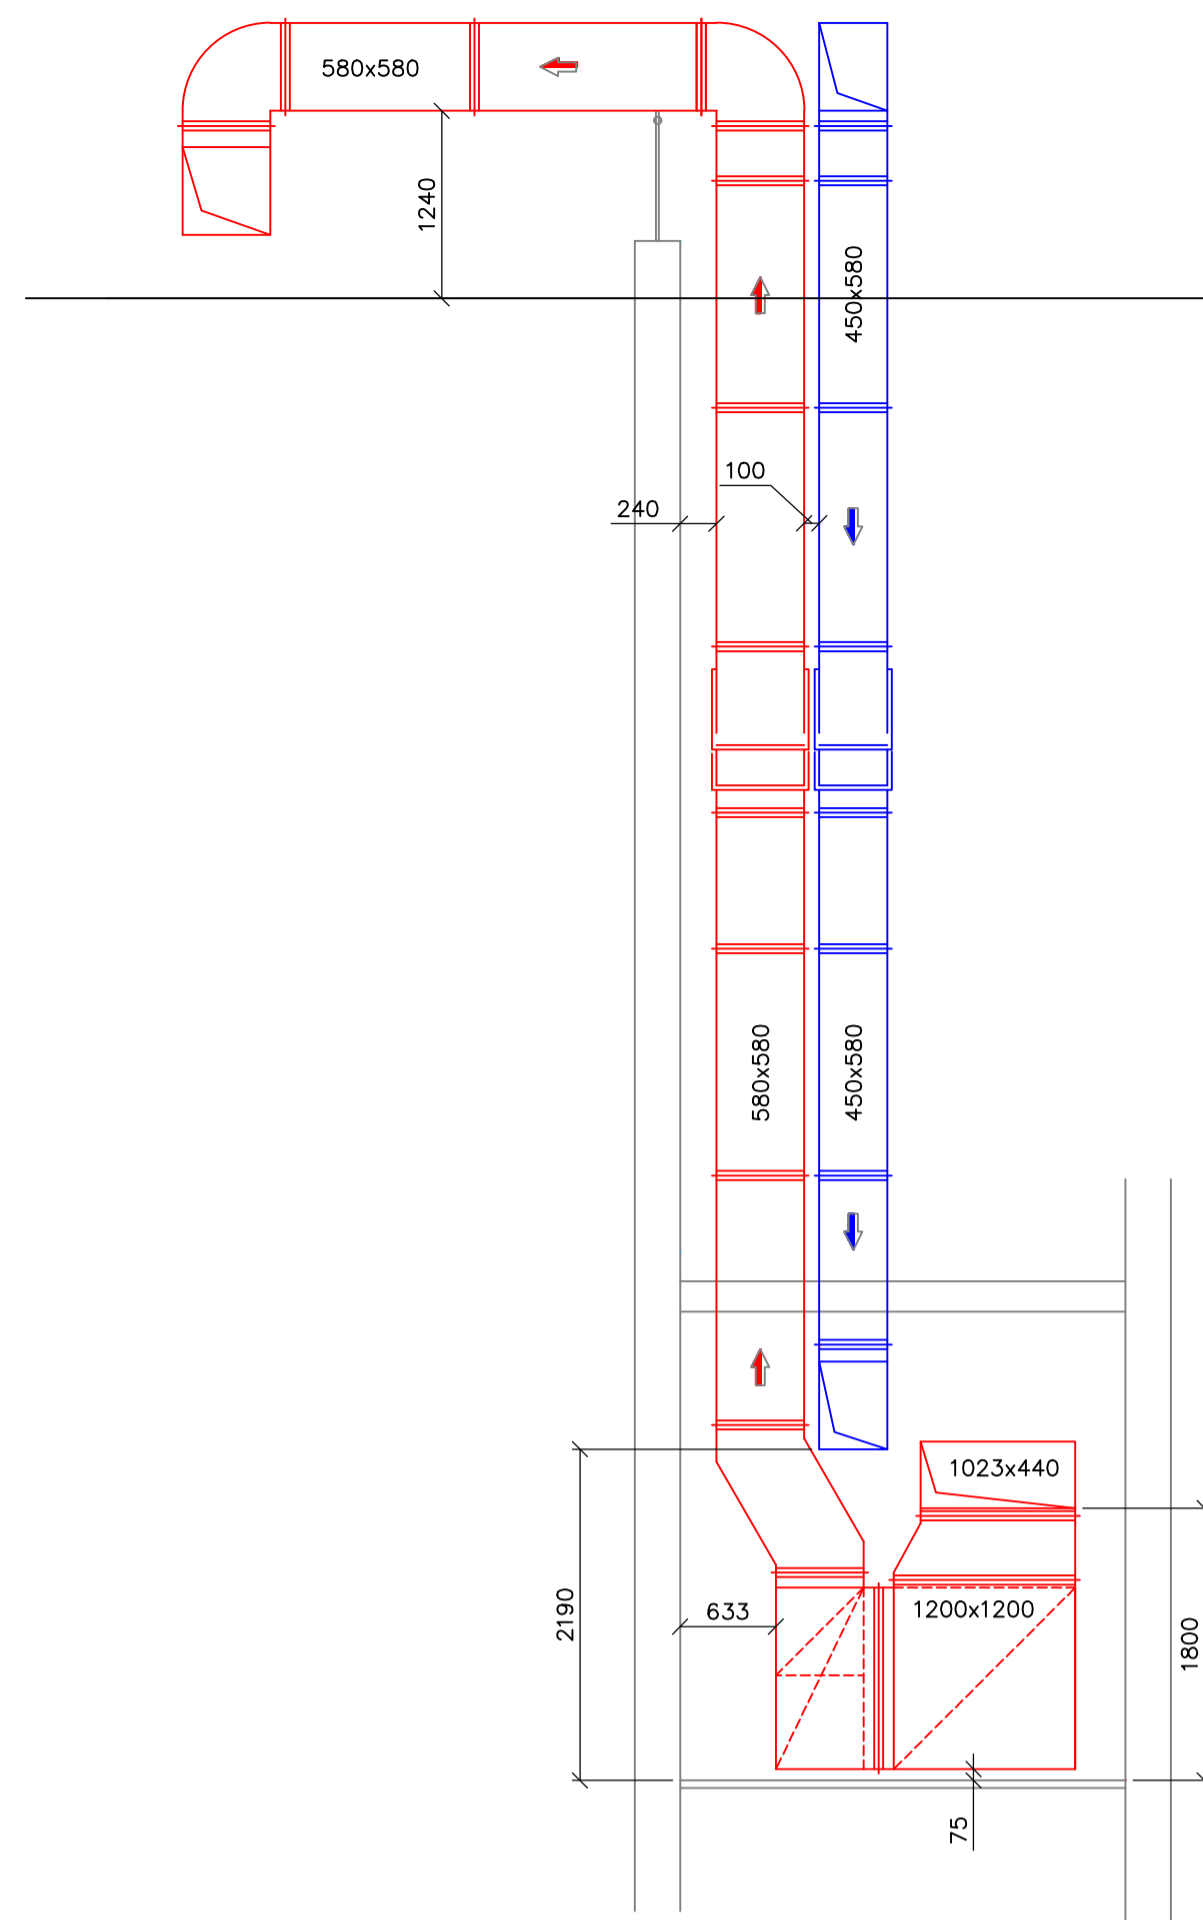


SECTION AA
SCALE 1:50

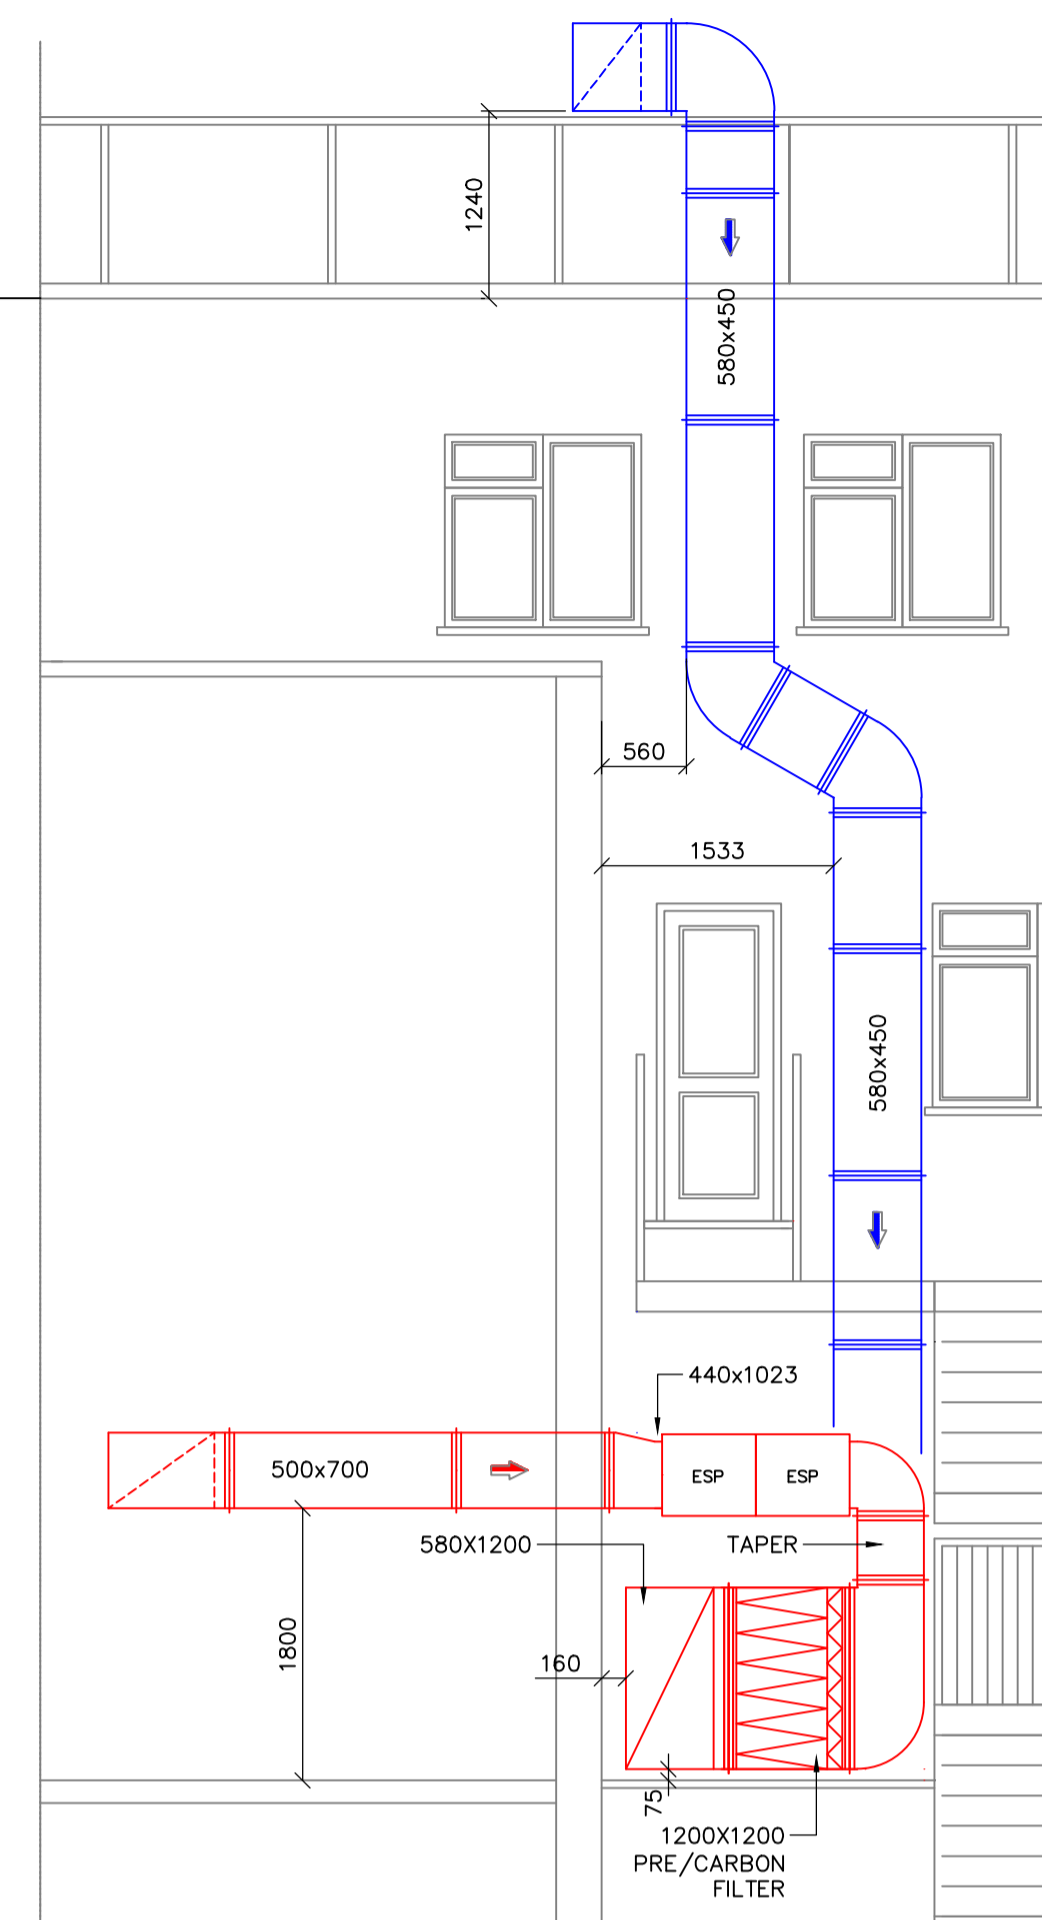

SECTION BB
SCALE 1:50

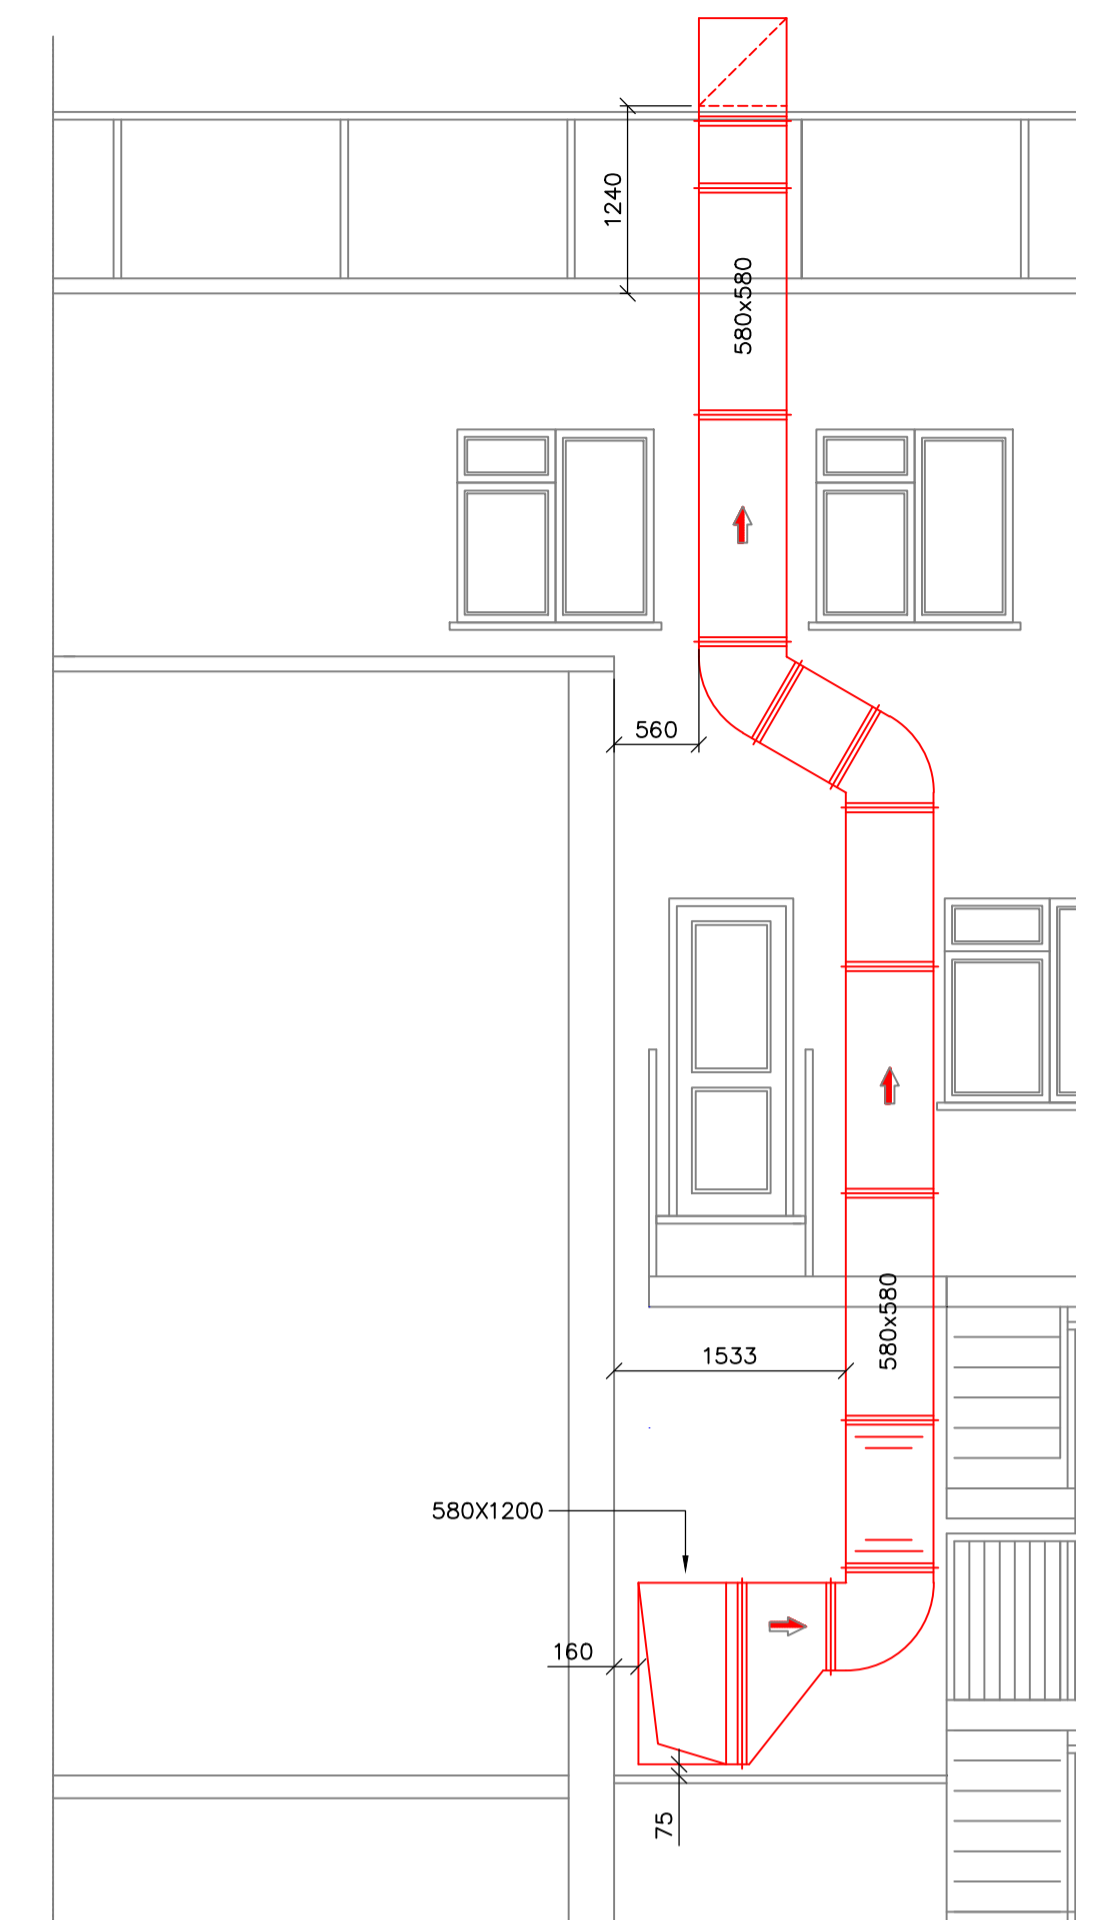

SECTION CC
SCALE 1:50

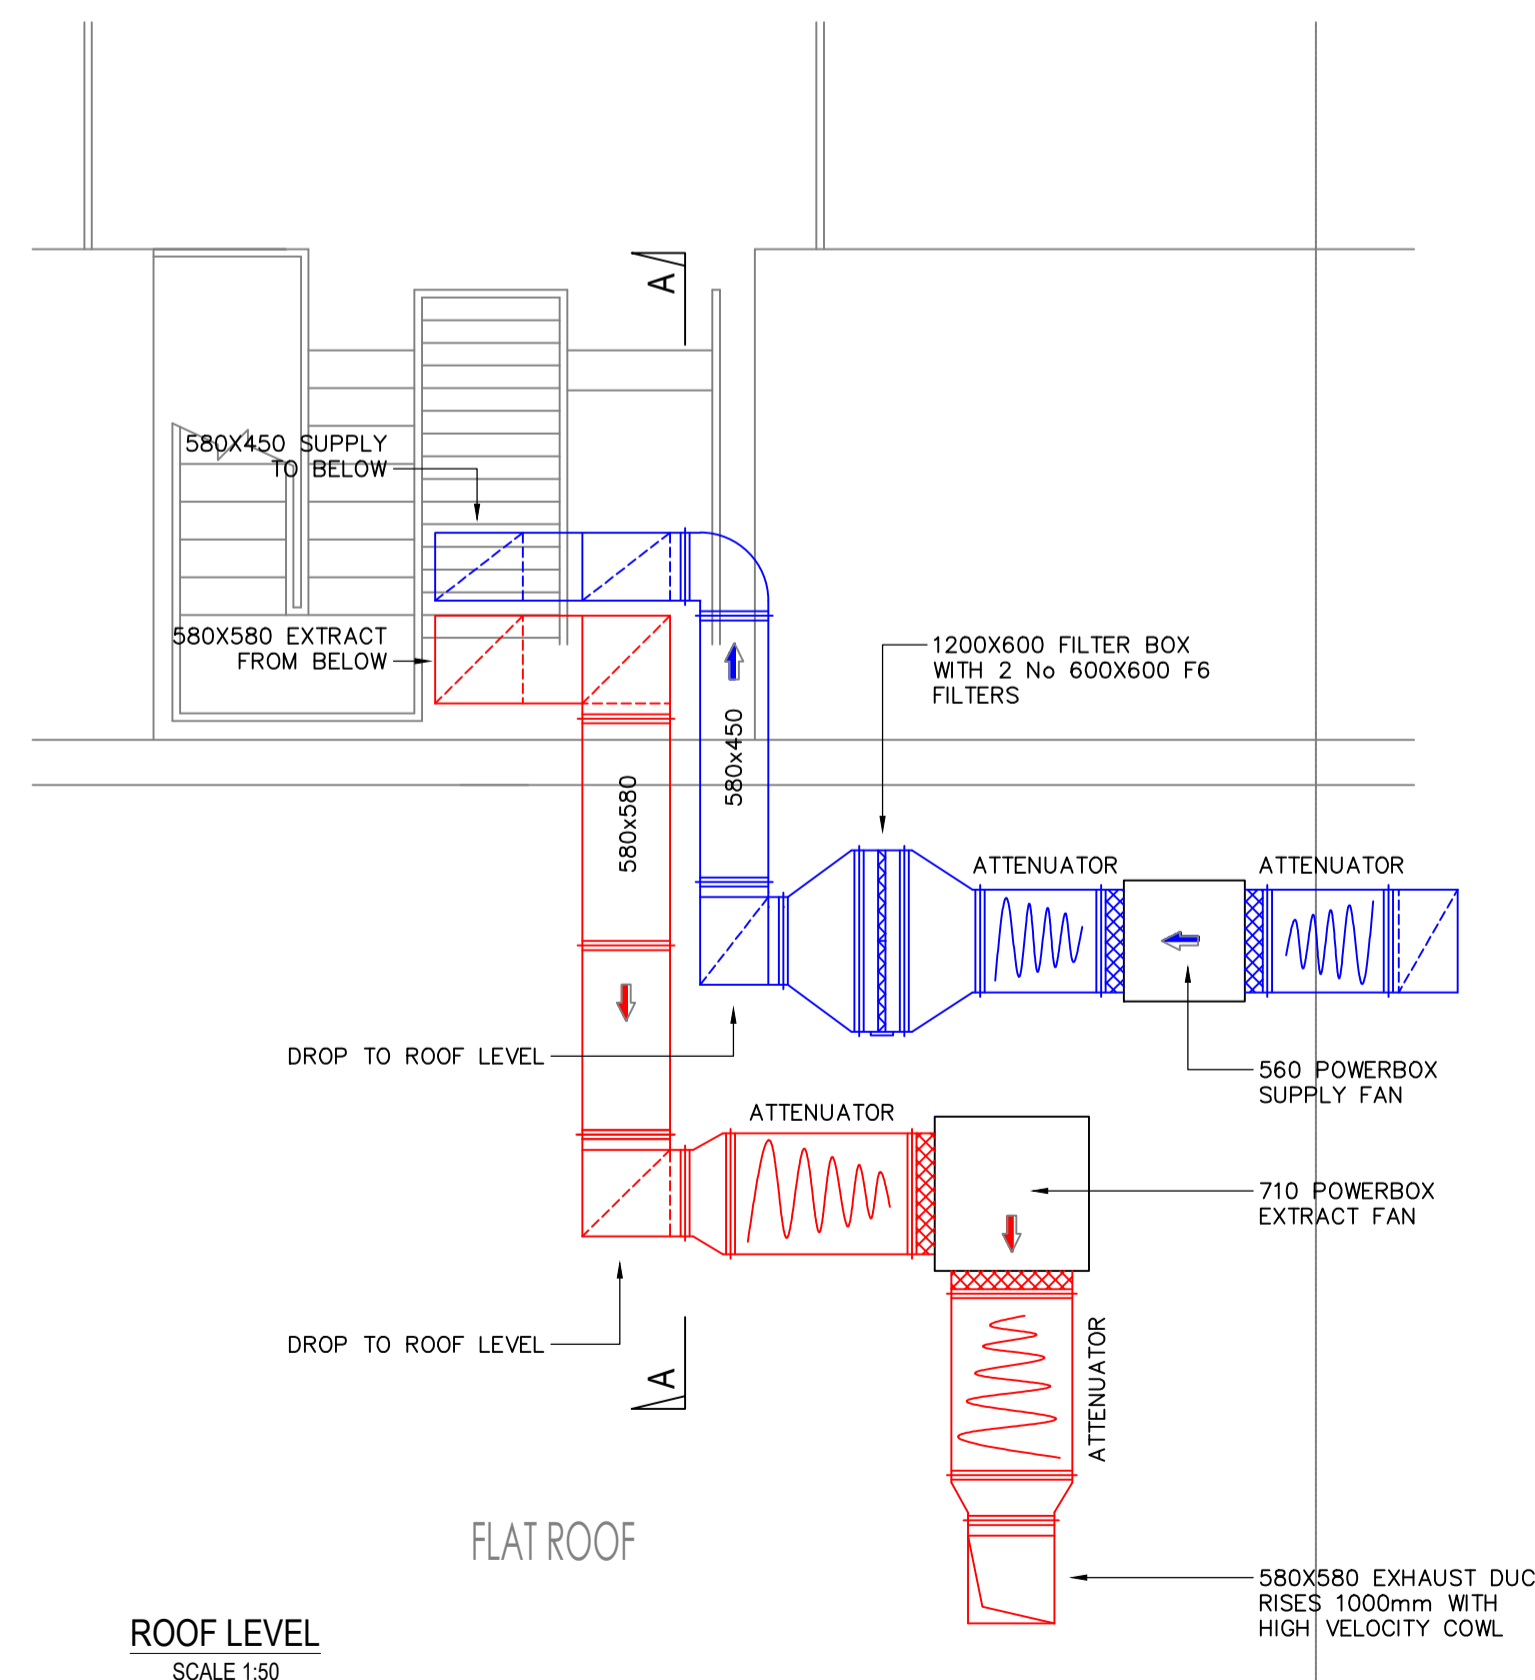

ROOF LEVEL
SCALE 1:50

REV	DESCRIPTION	DATE
-	-	-
PROJECT: Tony's Pita		
CLIENT: Client		
DRAWING TITLE: Kitchen Ventilation Layout		
DRAWING NUMBER: No. NL-SOS-TP-01		SCALE: 1:25 @ A1
DRAWN: NL	CHECKED: JI	APPROVED: DATE: 14/02/22



206-208 Billet Road, Walthamstow,
London, E17 5DX
T: 020 8531 8543
www.soscateringequipment.co.uk