


Existing downlighters to be removed shown in red

KITCHEN
101


DINING
ROOM
104

LIVING
ROOM
102

RECEPTION
103

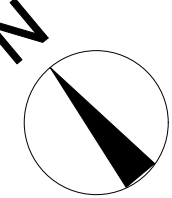


BRANDON SCHUBERT LTD	
PROJECT: 11 ROSSLYN HILL	
TITLE: Ground Floor - Lighting Plan	
SCALE: 1:50 @ A3	REV. NO: —
DATE: 23 FEBRUARY 2022	SHEET NO: EP-101
ISSUE: —	
All dimensions to be checked on site.	


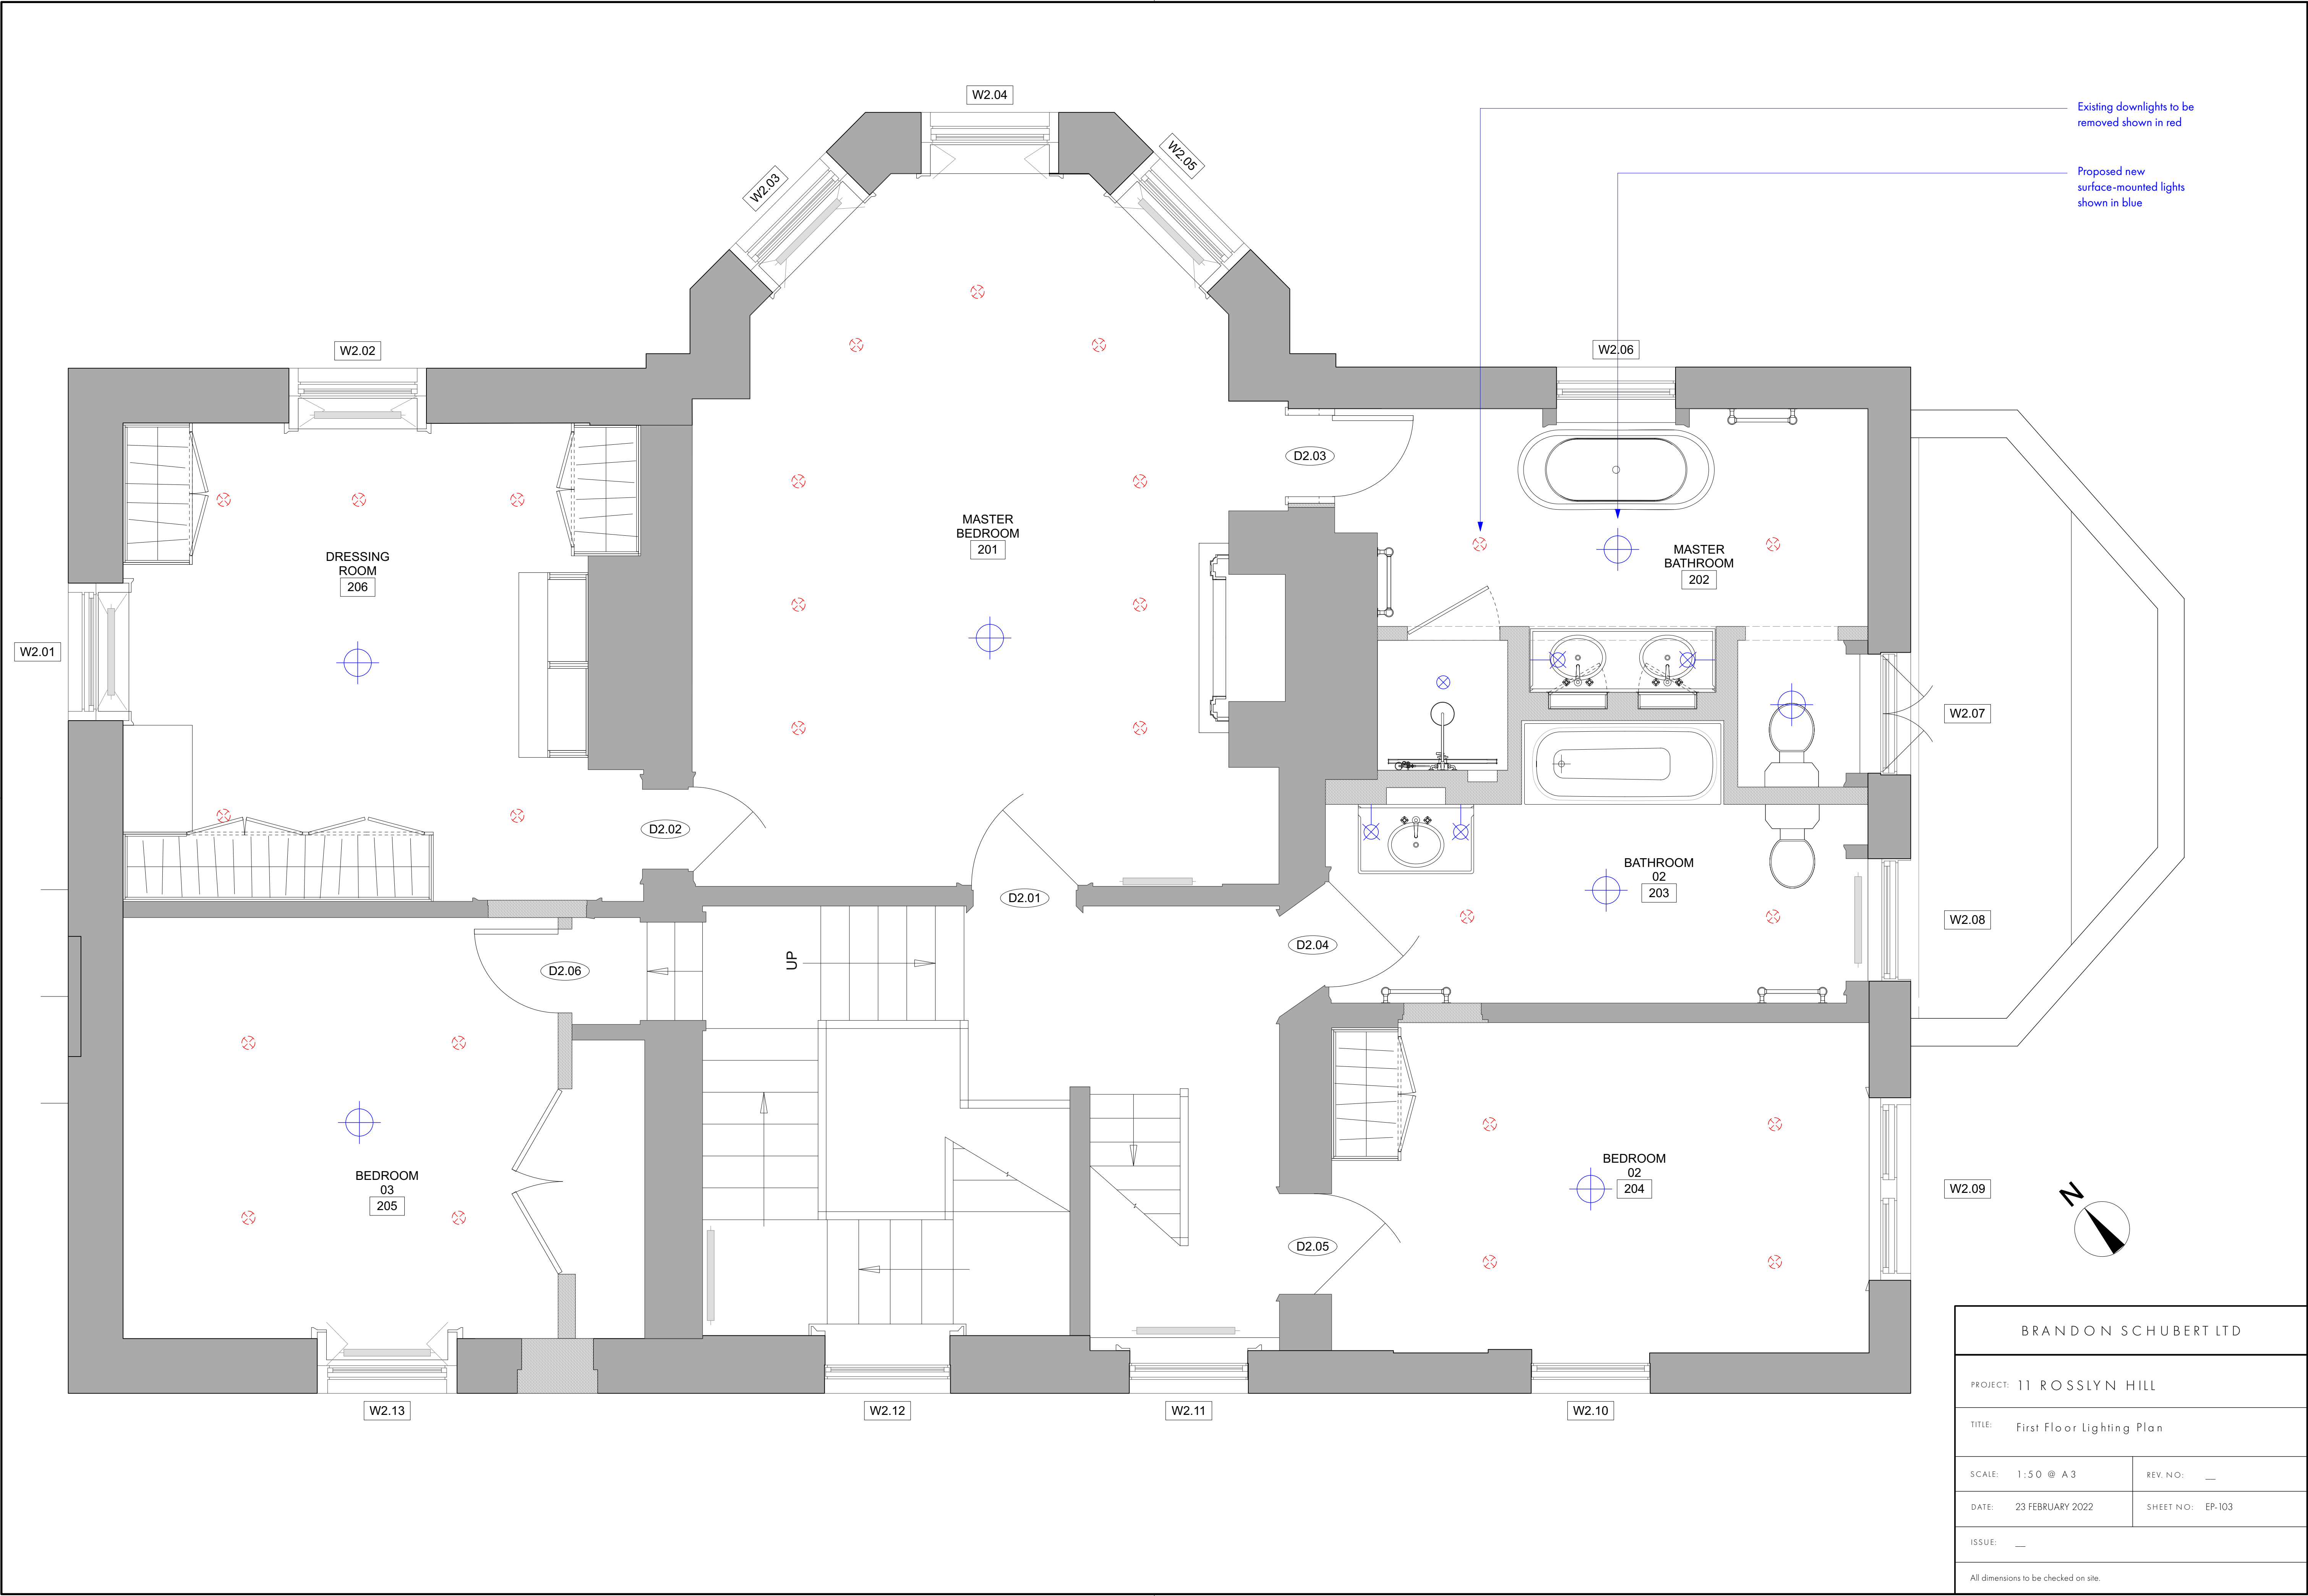


Existing downlights to be removed shown in red

Proposed new surface-mounted lights shown in blue

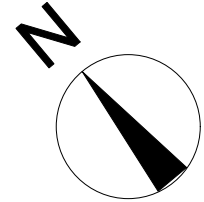

BRANDON SCHUBERT LTD	
PROJECT: 11 ROSSLYN HILL	
TITLE: First Floor Lighting Plan	
SCALE: 1:50 @ A3	REV. NO: —
DATE: 23 FEBRUARY 2022	SHEET NO: EP-103
ISSUE: —	
All dimensions to be checked on site.	

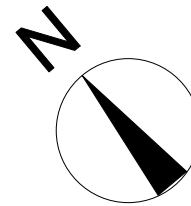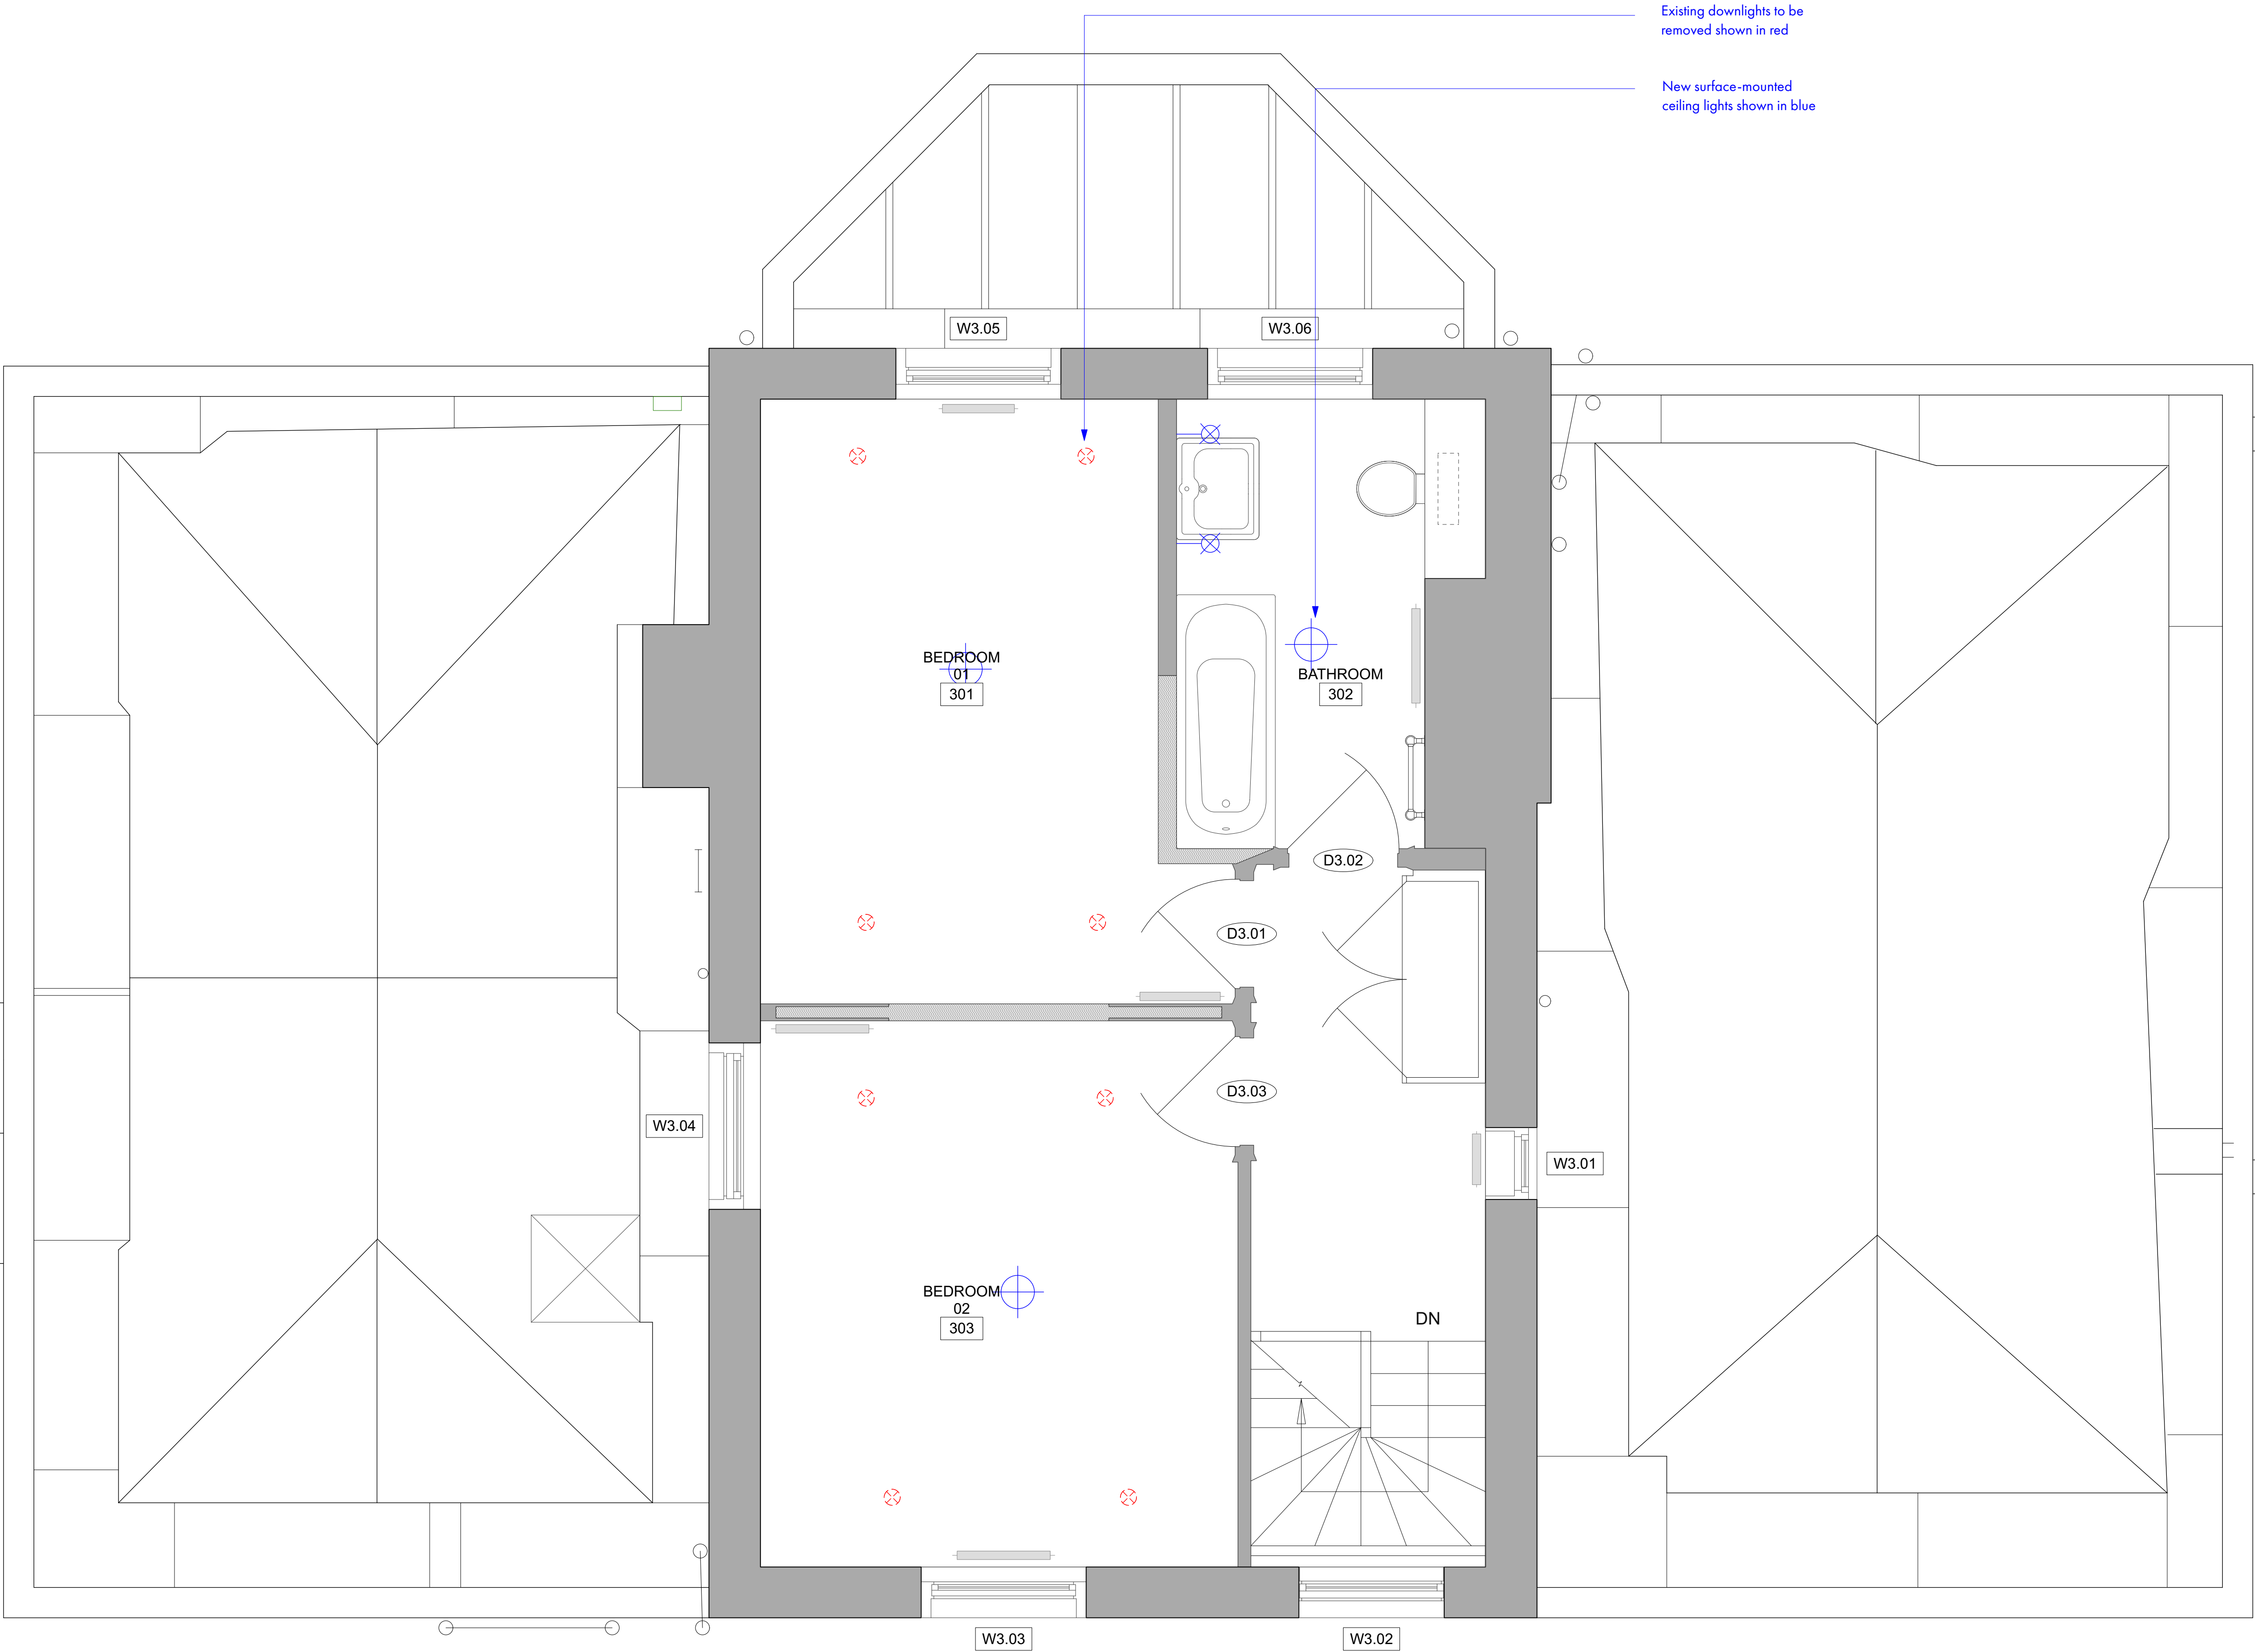

BRANDON SCHUBERT LTD	
PROJECT: 11 ROSSLYN HILL	
TITLE: Second Floor Lighting Plan	
SCALE: 1:50 @ A3	REV. NO: —
DATE: 23 FEBRUARY 2022	SHEET NO: EP-105
ISSUE: —	
All dimensions to be checked on site.	