


LEGEND		LEGEND	
TYPE	DESCRIPTION	TYPE	DESCRIPTION
L2	Opal linear LED profile	ES8	Wall mounted emergency signage
LS1	Backlit signage board	ES9	Wall mounted emergency signage
LS4-EX	Exterior rated backlit signage board	ES10	Wall mounted emergency signage

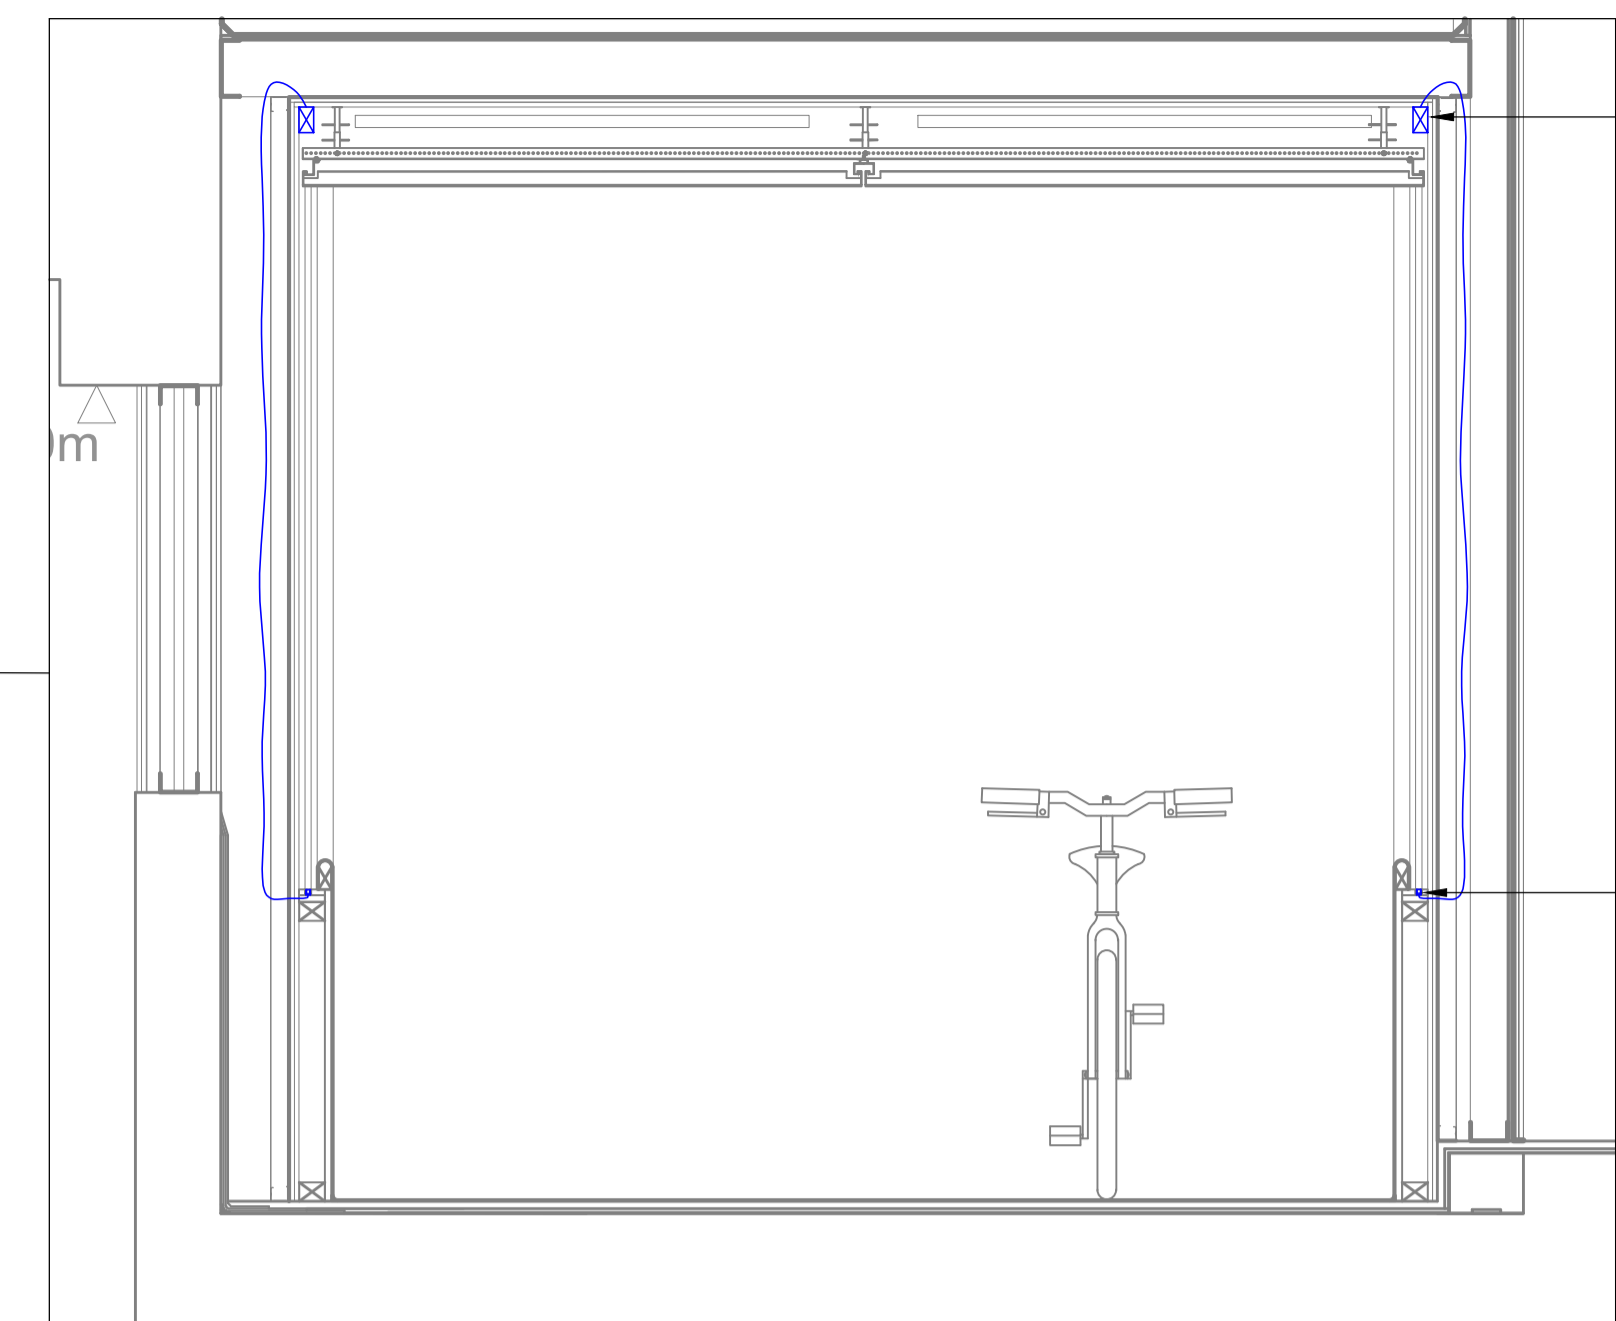

Indicative Section Through Tunnel
1:20 @A1

Driver and power supplies to be located in the ceiling void. Ventilation gap around front and sides to be allowed for. Driver and power supplies to be reviewed on site once installed to see if any suitable covering is required to hide them. Driver and power supply can feed up to 18m of linear LED, however LED requires cable entry every 5m or 10m to minimise volt drop. Contractor to discuss with manufacturer suitable wiring method prior to installation.

Opal linear LED in u-shaped mounting channel to be recessed in joinery detail next to handrail. Front of LED to sit flush with recess

LS1- Backlit illuminated signage board. To be supplied with polycarb diffuser. Signage board to be CDP contractor item.

ES9 - Wall mounted emergency exit sign mounted at 1.8m from the FFL to the centre of the sign with arrow pointing towards the exit

L2 - Linear LED strip integrated into the handrail detail to create a gentle glow up the wall

ES8 - Projecting illuminated emergency exit sign mounted to the wall at 2.2m from the FFL to the centre of the fitting

ES10 - Wall mounted emergency exit sign mounted at 1.8m from the FFL to the centre of the sign

LS4-EX - Exterior backlit illuminated signage board located on the facade of the building. To be supplied with polycarb diffuser. Signage board to be CDP contractor item.

PLEASE REFER TO DRAWING 0185-404 AND 0185-604 FOR LIGHTING TO BASEMENT AREA

Notes

Important Note

Where Dimensions are not given, drawings must not be scaled.

For complete luminaire breakdown refer to schedules

In the event of conflict between this drawing and lead consultants drawing the matter must be referred prior to proceeding

studio 29

Studio 29 Lighting Design
47 Landford Road, London SW15 1AQ
t: 020 8780 9006 w: studio29lighting.com

Date	Rev	Description
25.02.22	A	Signage added
18.02.22	-	First issue as WIP draft

CLIENT	Lazari Investments	
PROJECT	Maple House	PROJECT NO. 0185
STATUS	Stage 4	
SCALE	1:100 @ A1	DATE 18/02/2022
	1:200 @ A3	
TITLE	Basement Tunnel Lighting Plan	
DRAWING NO.	0185-612	REVISION A