


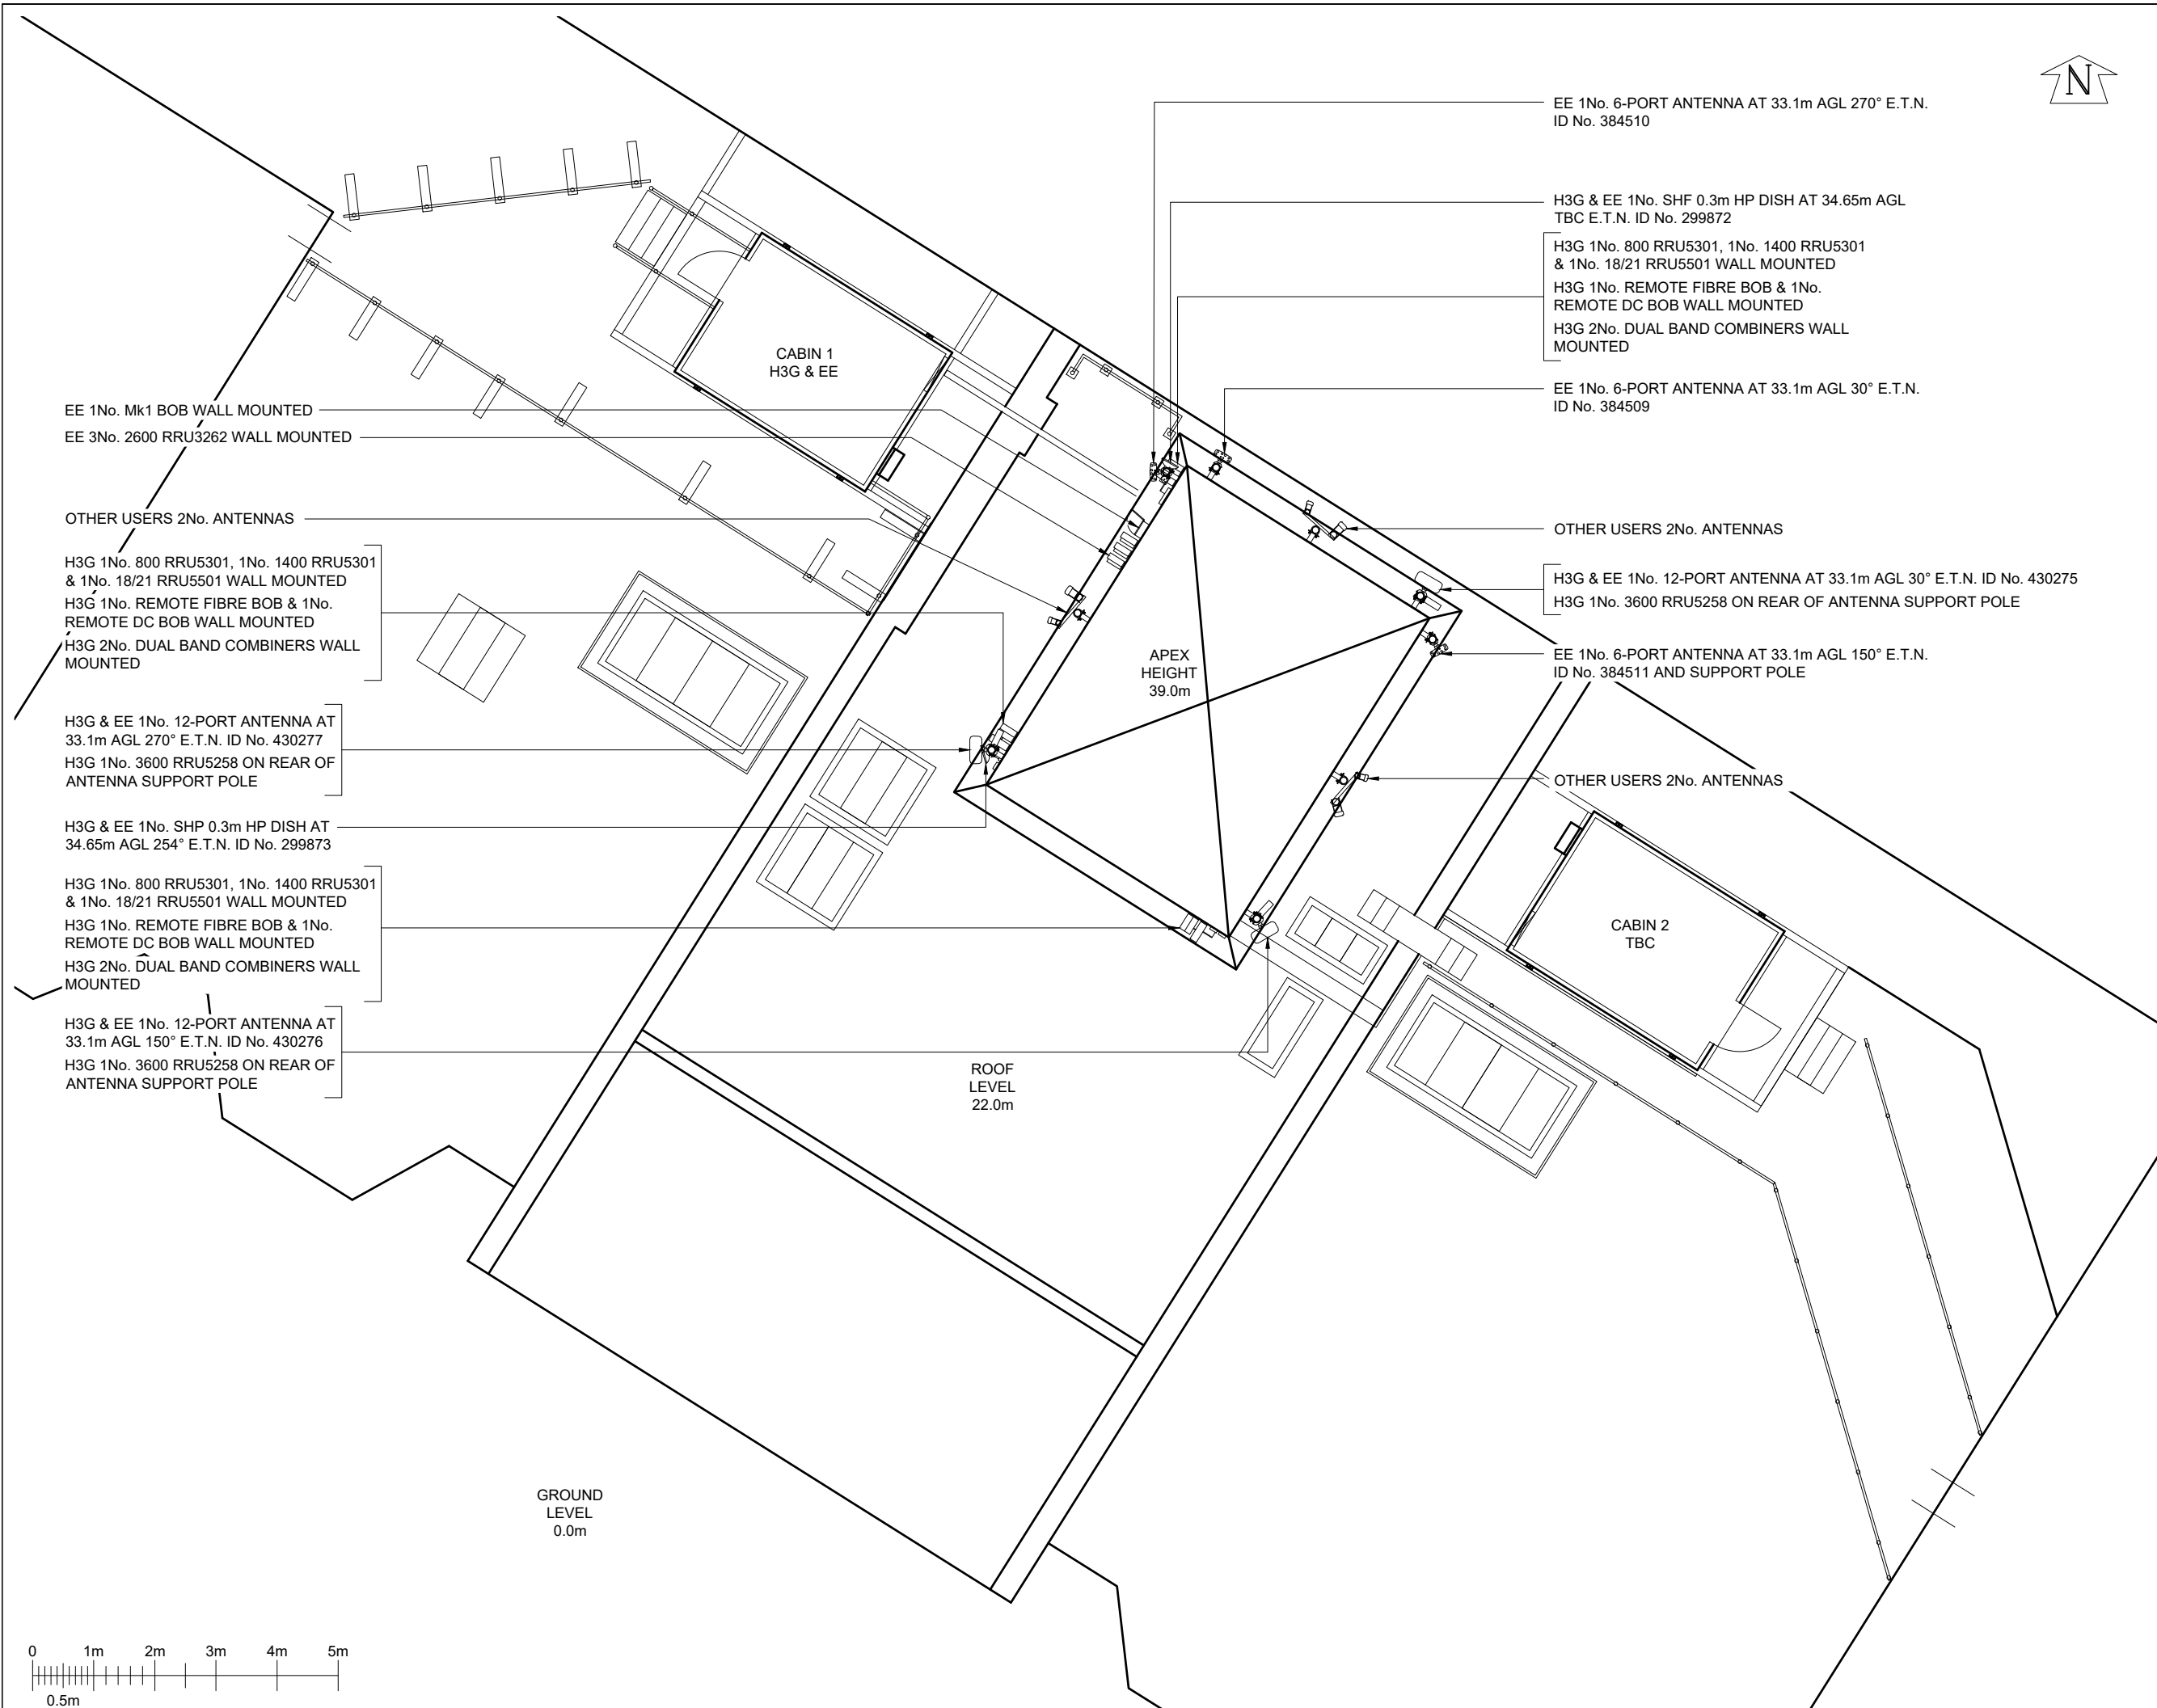

©2020 Cellnex
All rights reserved. No part of this publication may be reproduced, stored in a retrieval system or transmitted in any form or by any means (Electronic, Mechanical, Photocopying, Recording or otherwise), without the prior written consent of the Company.

NOTES
UNDERGROUND SERVICES
UNDERGROUND SERVICES ARE INDICATIVE ONLY. POSITIONS SHOULD BE CONFIRMED ON SITE PRIOR TO ANY DEVELOPMENT

DRAINAGE	---
DUCTS	----
FEEDERS	----
FENCE PLAN	-----○-----○-----○-----○-----
GAS	----
LIGHTNING PROTECTION - EARTHING	----
POWER	----
SERVICES UNKNOWN	----
TELECOMS	----
WATER	----

ACCESS ARRANGEMENTS
KEYS:-

ARQIVA GATE KEY	▲
B KEY	▲
C KEY	▲
LEGGE KEY	▲

SURVEY REQUIRED TO CONFIRM ACCESS KEYS FOR REMAINING ROOMS AND SITE ENTRANCE

	PROJ No			
	PROJ No			
3	PROJ No 238721 AMENDS	16/02/22	WHP	WHP
2	PROJ No 238721 PLANNING	10/02/22	WHP	WHP
1	PROJ No 9BMOBL MASTER CREATION	28/10/19	AN	FC
ISS	REVISION	DATE	DRN	APP



CELLNEX UK
R+, 4TH FLOOR, 2 BLA GRAVE STREET, READING, RG1 1AZ
Tel. 020 4526 8553

SITE No **88326**
LONDON ST PANCRAS WAY
ST PANCRAS HOSPITAL
4 ST PANCRAS WAY
CAMDEN
GREATER LONDON 3
NW1 0PE

NGR TQ 29665 83495

OS GRID 529665 183495

TITLE
SITE PLAN
EXISTING


SCALE 1:100

DRAWN AN 23/10/19

APPROVED WHP 16/02/22

DRG No. Sheet 1 of 1 Rev

88326-00-000-MD003 3

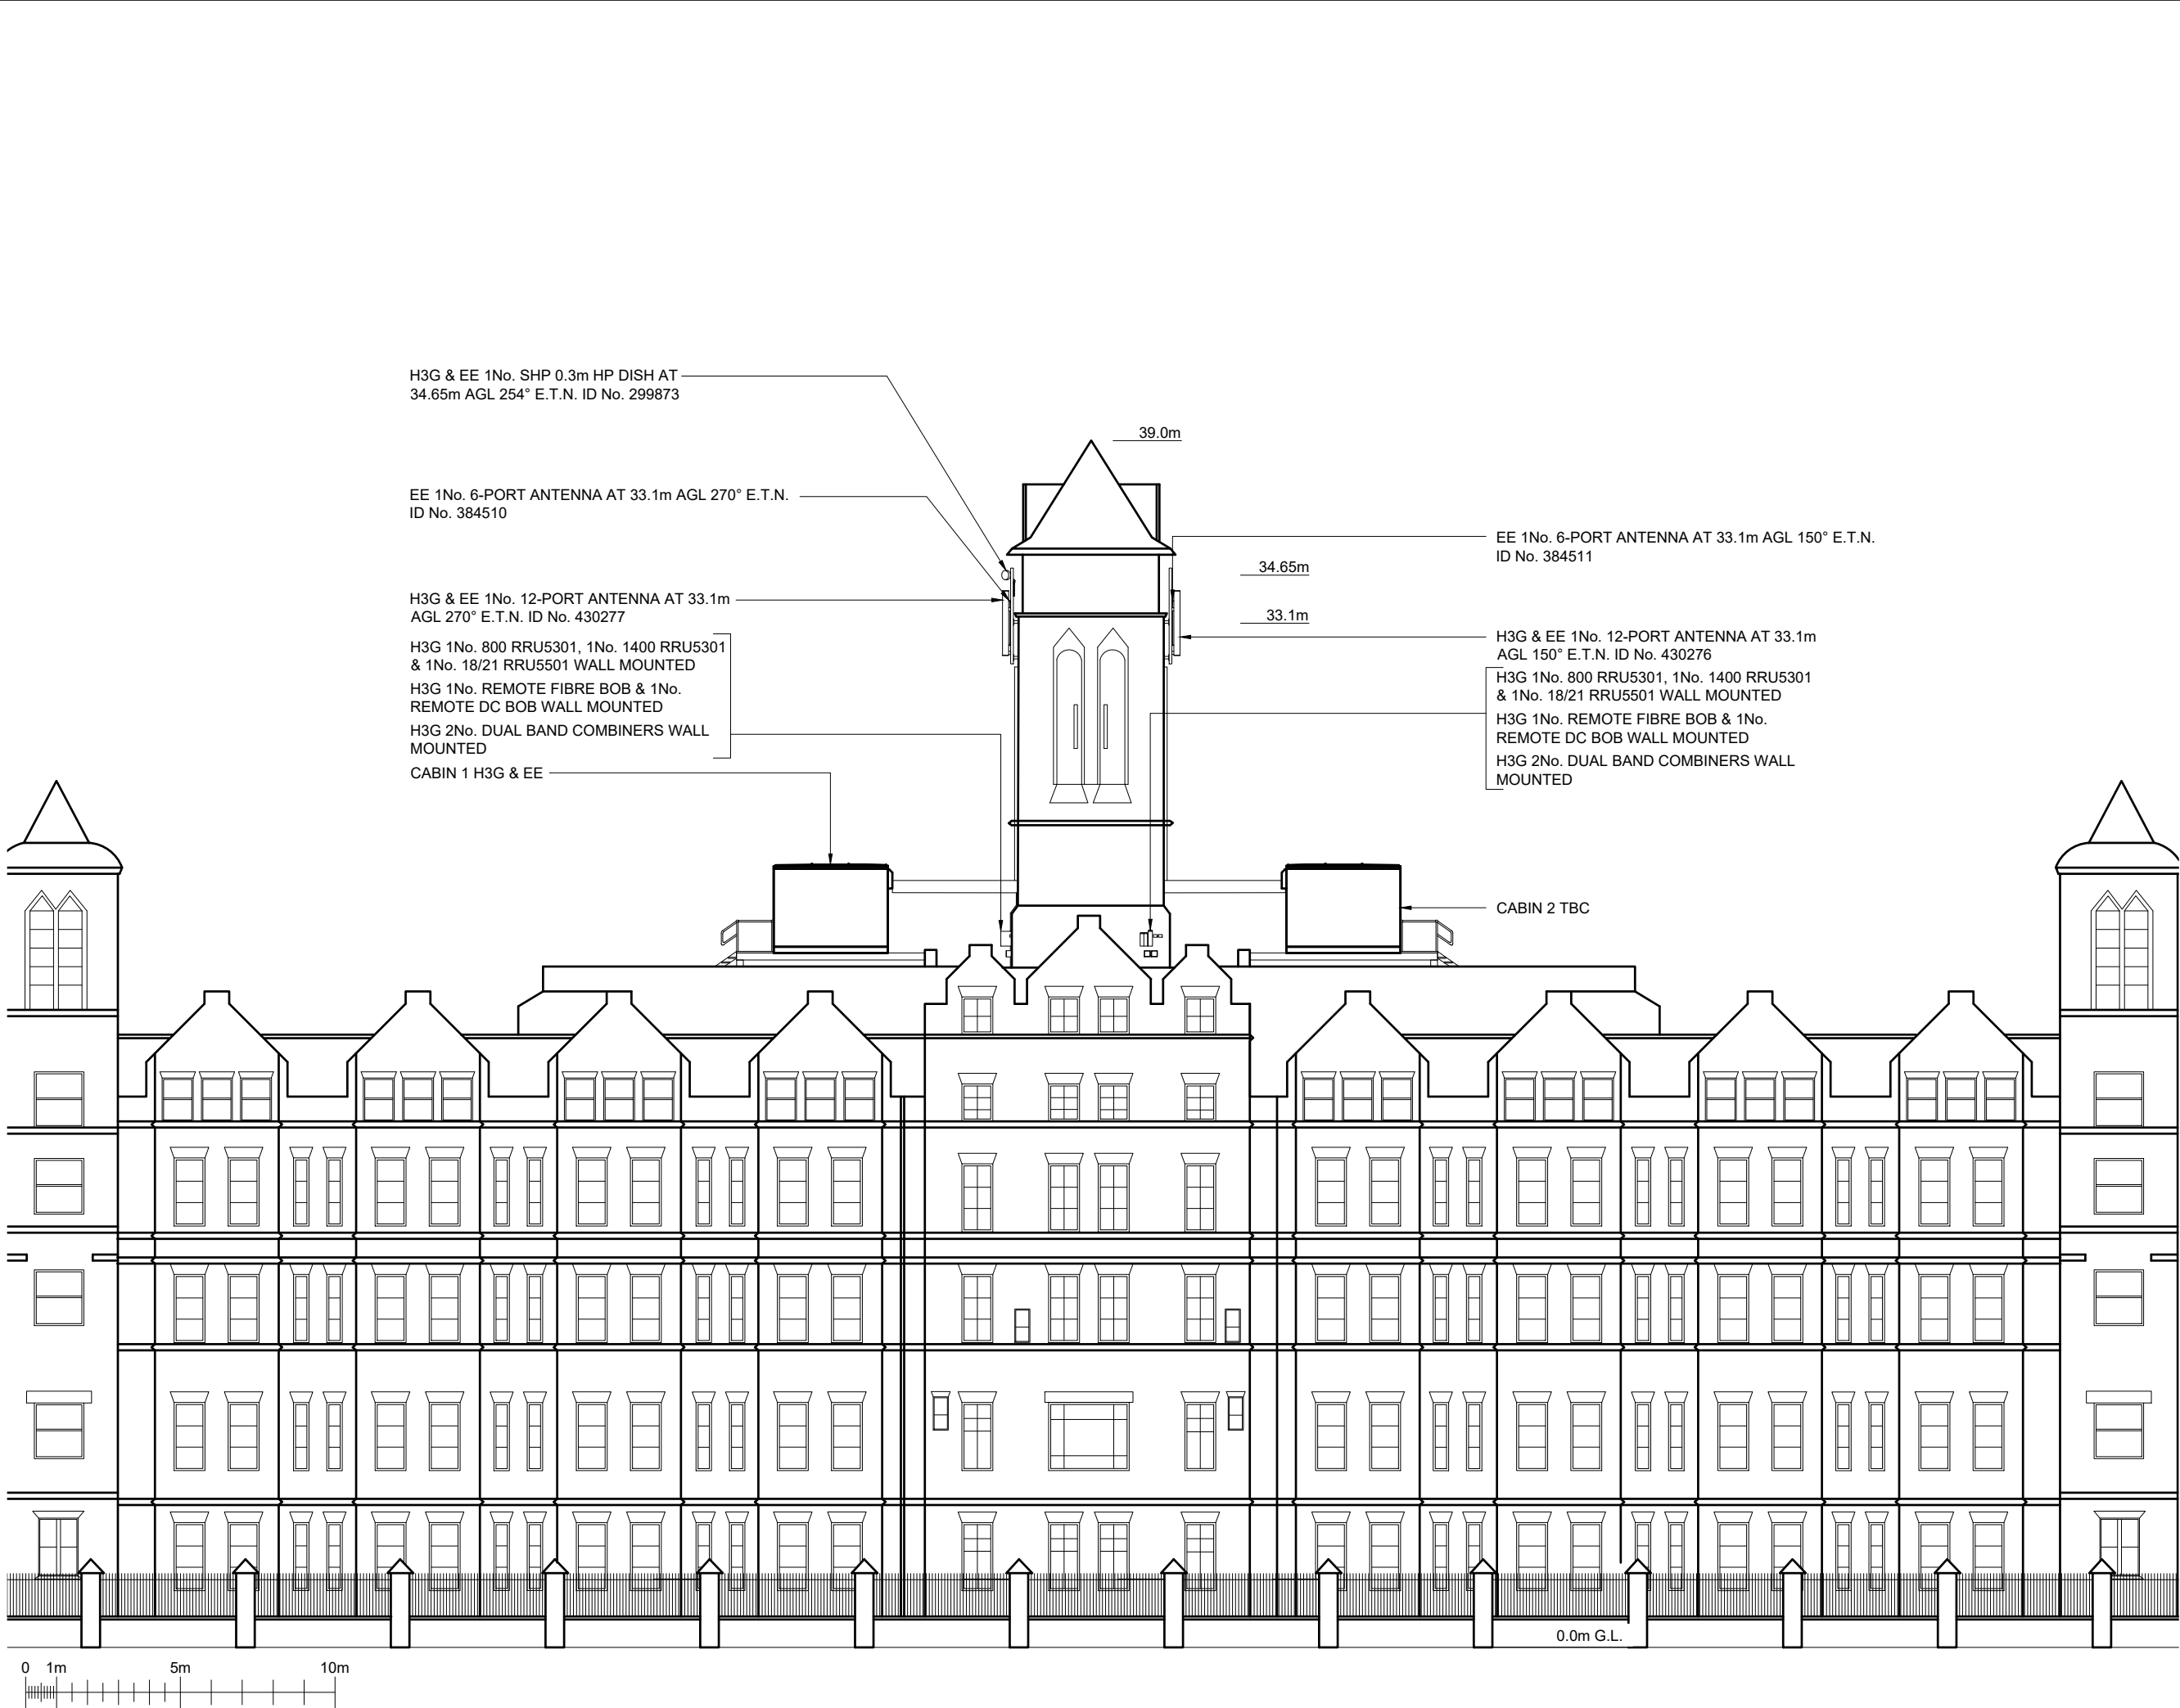

NOTES

PROJ No			
PROJ No			
3	PROJ No 238721 AMENDS	16/02/22	WHPWHP
2	PROJ No 238721 PLANNING	10/02/22	WHPWHP
1	PROJ No 9BMOBL MASTER CREATION	28/10/19	AN FC
ISS	REVISION	DATE	DRN APP

CELLNEX UK
R+, 4TH FLOOR, 2 BLAGRAVE STREET, READING, RG1 1AZ
Tel. 020 4526 8553

SITE No 88326
LONDON ST PANCRAS WAY
ST PANCRAS HOSPITAL
4 ST PANCRAS WAY
CAMDEN
GREATER LONDON 3
NW1 0PE

NGR TQ 29665 83495

OS GRID 529665 183495

TITLE
ELEVATION
EXISTING
SOUTH WEST

SCALE 1:200

DRAWN	AN	23/10/19
APPROVED	WHP	16/02/22

DRG No.	Sheet 1 of 1	Rev
88326-00-002-MD003		3