


GREAT COURT PUBLIC CONCOURSE
(Upper Part)
G/2/010

- Emergency Light
- ⊙ Smoke Detector
- PAVA Speaker
- ⊕ House Lights (fixed to lighting track)
- ⊙ CCTV

12 no 600mm wide slots to plasterboard raft ceiling, with centrally suspended lighting track. Ceiling as K10/230. Decorated M60/110.

Proposed line of retail walls below
Continuous lighting baffle

Suspended lighting track

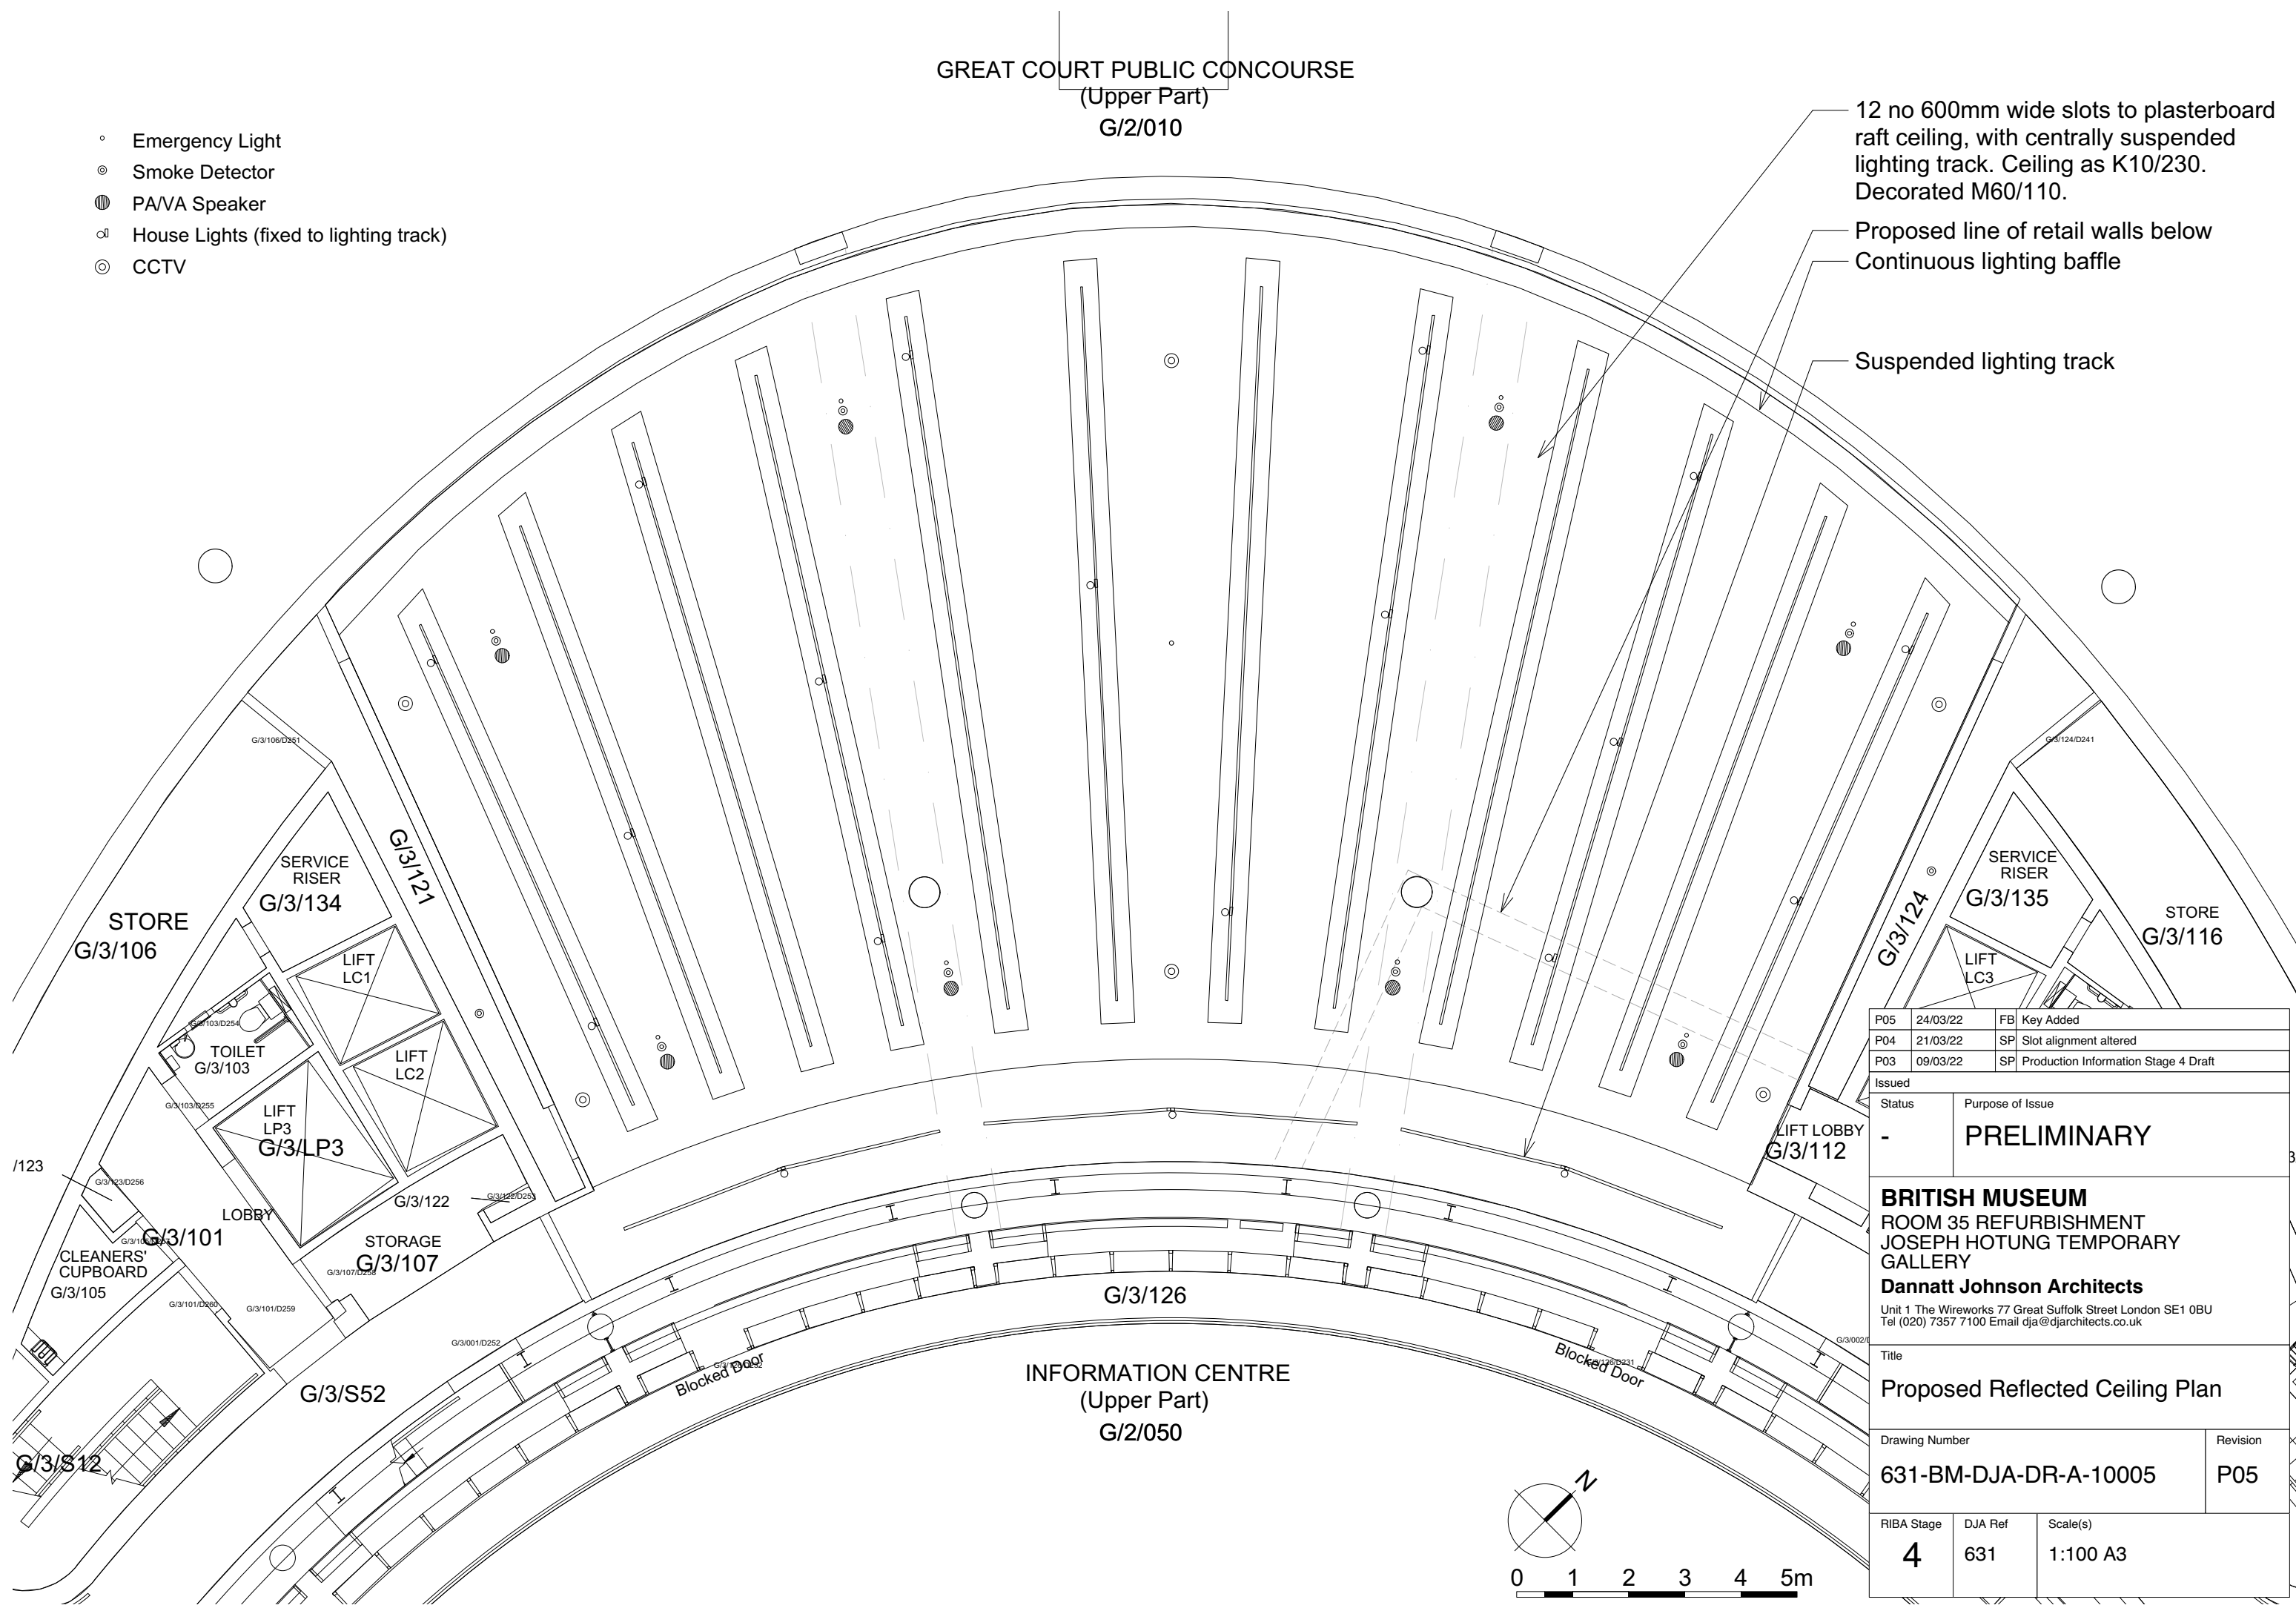

P05	24/03/22	FB	Key Added
P04	21/03/22	SP	Slot alignment altered
P03	09/03/22	SP	Production Information Stage 4 Draft
Issued			
Status	Purpose of Issue		
-	PRELIMINARY		
BRITISH MUSEUM			
ROOM 35 REFURBISHMENT			
JOSEPH HOTUNG TEMPORARY GALLERY			
Dannatt Johnson Architects			
Unit 1 The Wireworks 77 Great Suffolk Street London SE1 0BU Tel (020) 7357 7100 Email dja@djarchitects.co.uk			
Title			
Proposed Reflected Ceiling Plan			
Drawing Number			Revision
631-BM-DJA-DR-A-10005			P05
RIBA Stage	DJA Ref	Scale(s)	
4	631	1:100 A3	