

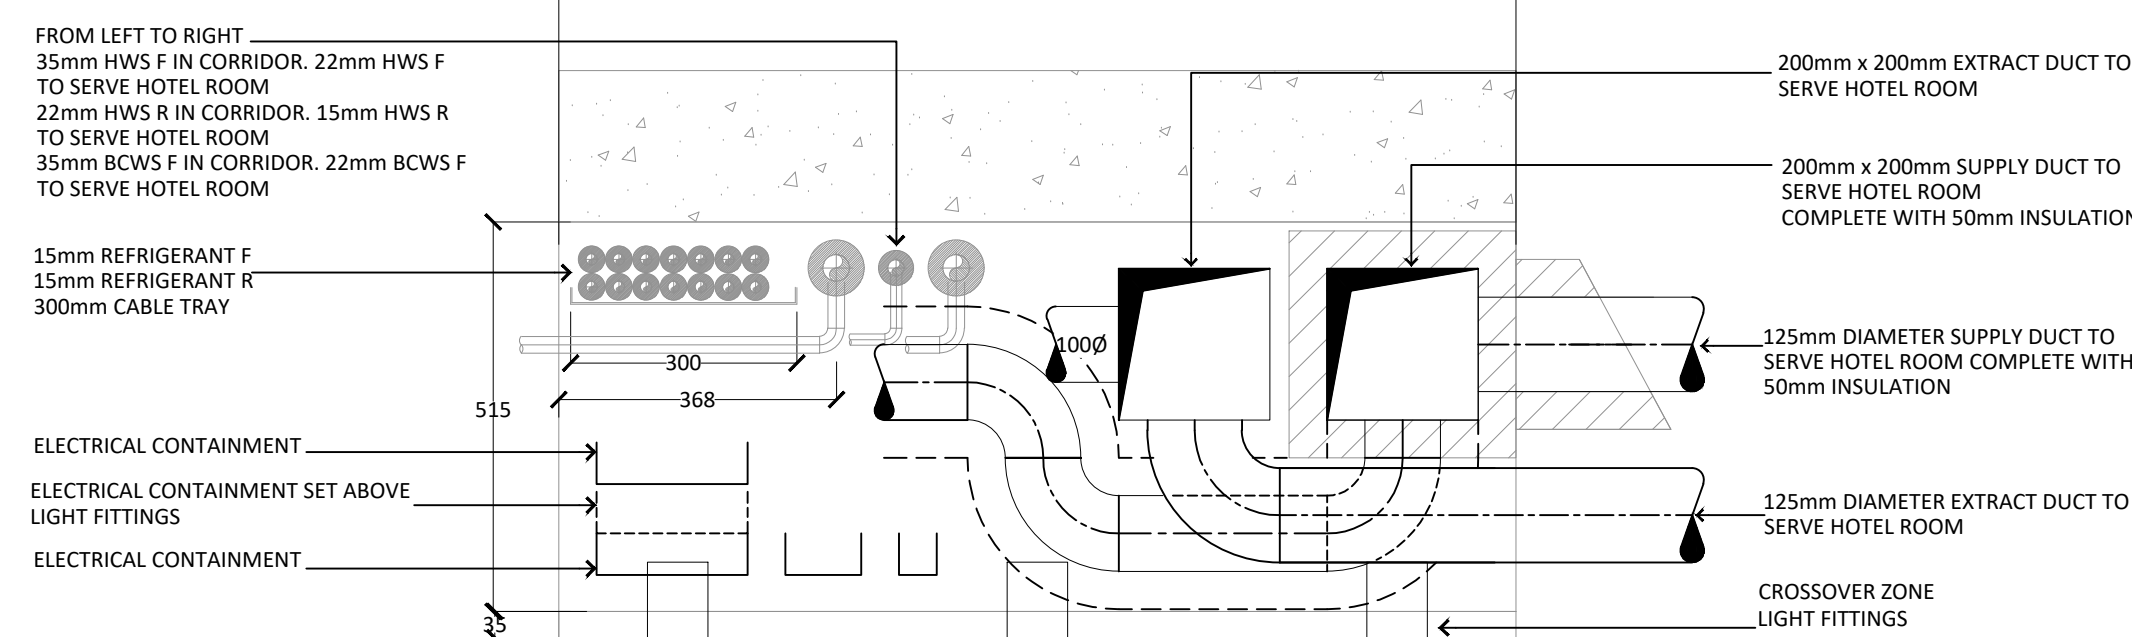



- NOTES:
- THIS DRAWING MUST NOT BE USED FOR CONSTRUCTION OR INSTALLATION PURPOSES UNLESS EXPRESSLY STATED.
  - ALL INFORMATION AND LAYOUT ON THIS DRAWING IS SUBJECT TO SITE DIMENSION CHECKS. DO NOT SCALE FROM THIS DRAWING ALWAYS WORK TO NOTED DIMENSIONS.
  - ALL DIMENSIONS ARE IN MILLIMETERS UNLESS NOTED OTHERWISE.
  - ALL DIMENSIONS MUST BE VERIFIED ON SITE BEFORE COMPLETING SHOP DRAWINGS OR SETTING OUT THE WORKS.
  - THIS DRAWING IS TO BE READ IN CONJUNCTION WITH ALL RELEVANT ARCHITECTS, STRUCTURAL ENGINEERS, MEP CONSULTANT DRAWINGS AND SPECIFICATIONS.
  - ANY DISCREPANCIES BETWEEN DRAWINGS AND SPECIFICATION OR RELATED DOCUMENT, THE ENGINEER SHALL BE NOTIFIED IN WRITING FOR VERIFICATION OF DISCREPANCY.
  - ALL SERVICES PENETRATIONS THROUGH FIRE RATED PARTITIONS SHALL BE SLEEVED AND FIRE STOPPED.
  - ALL DUCTWORK SHALL BE FIRE RATED FOR STABILITY AND INTEGRITY.
  - REFRIGERANT PIPEWORK SHALL DISTRIBUTE WITHIN CORRIDOR CEILING VOIDS ON GALVANIZED STEEL CABLE TRAY.

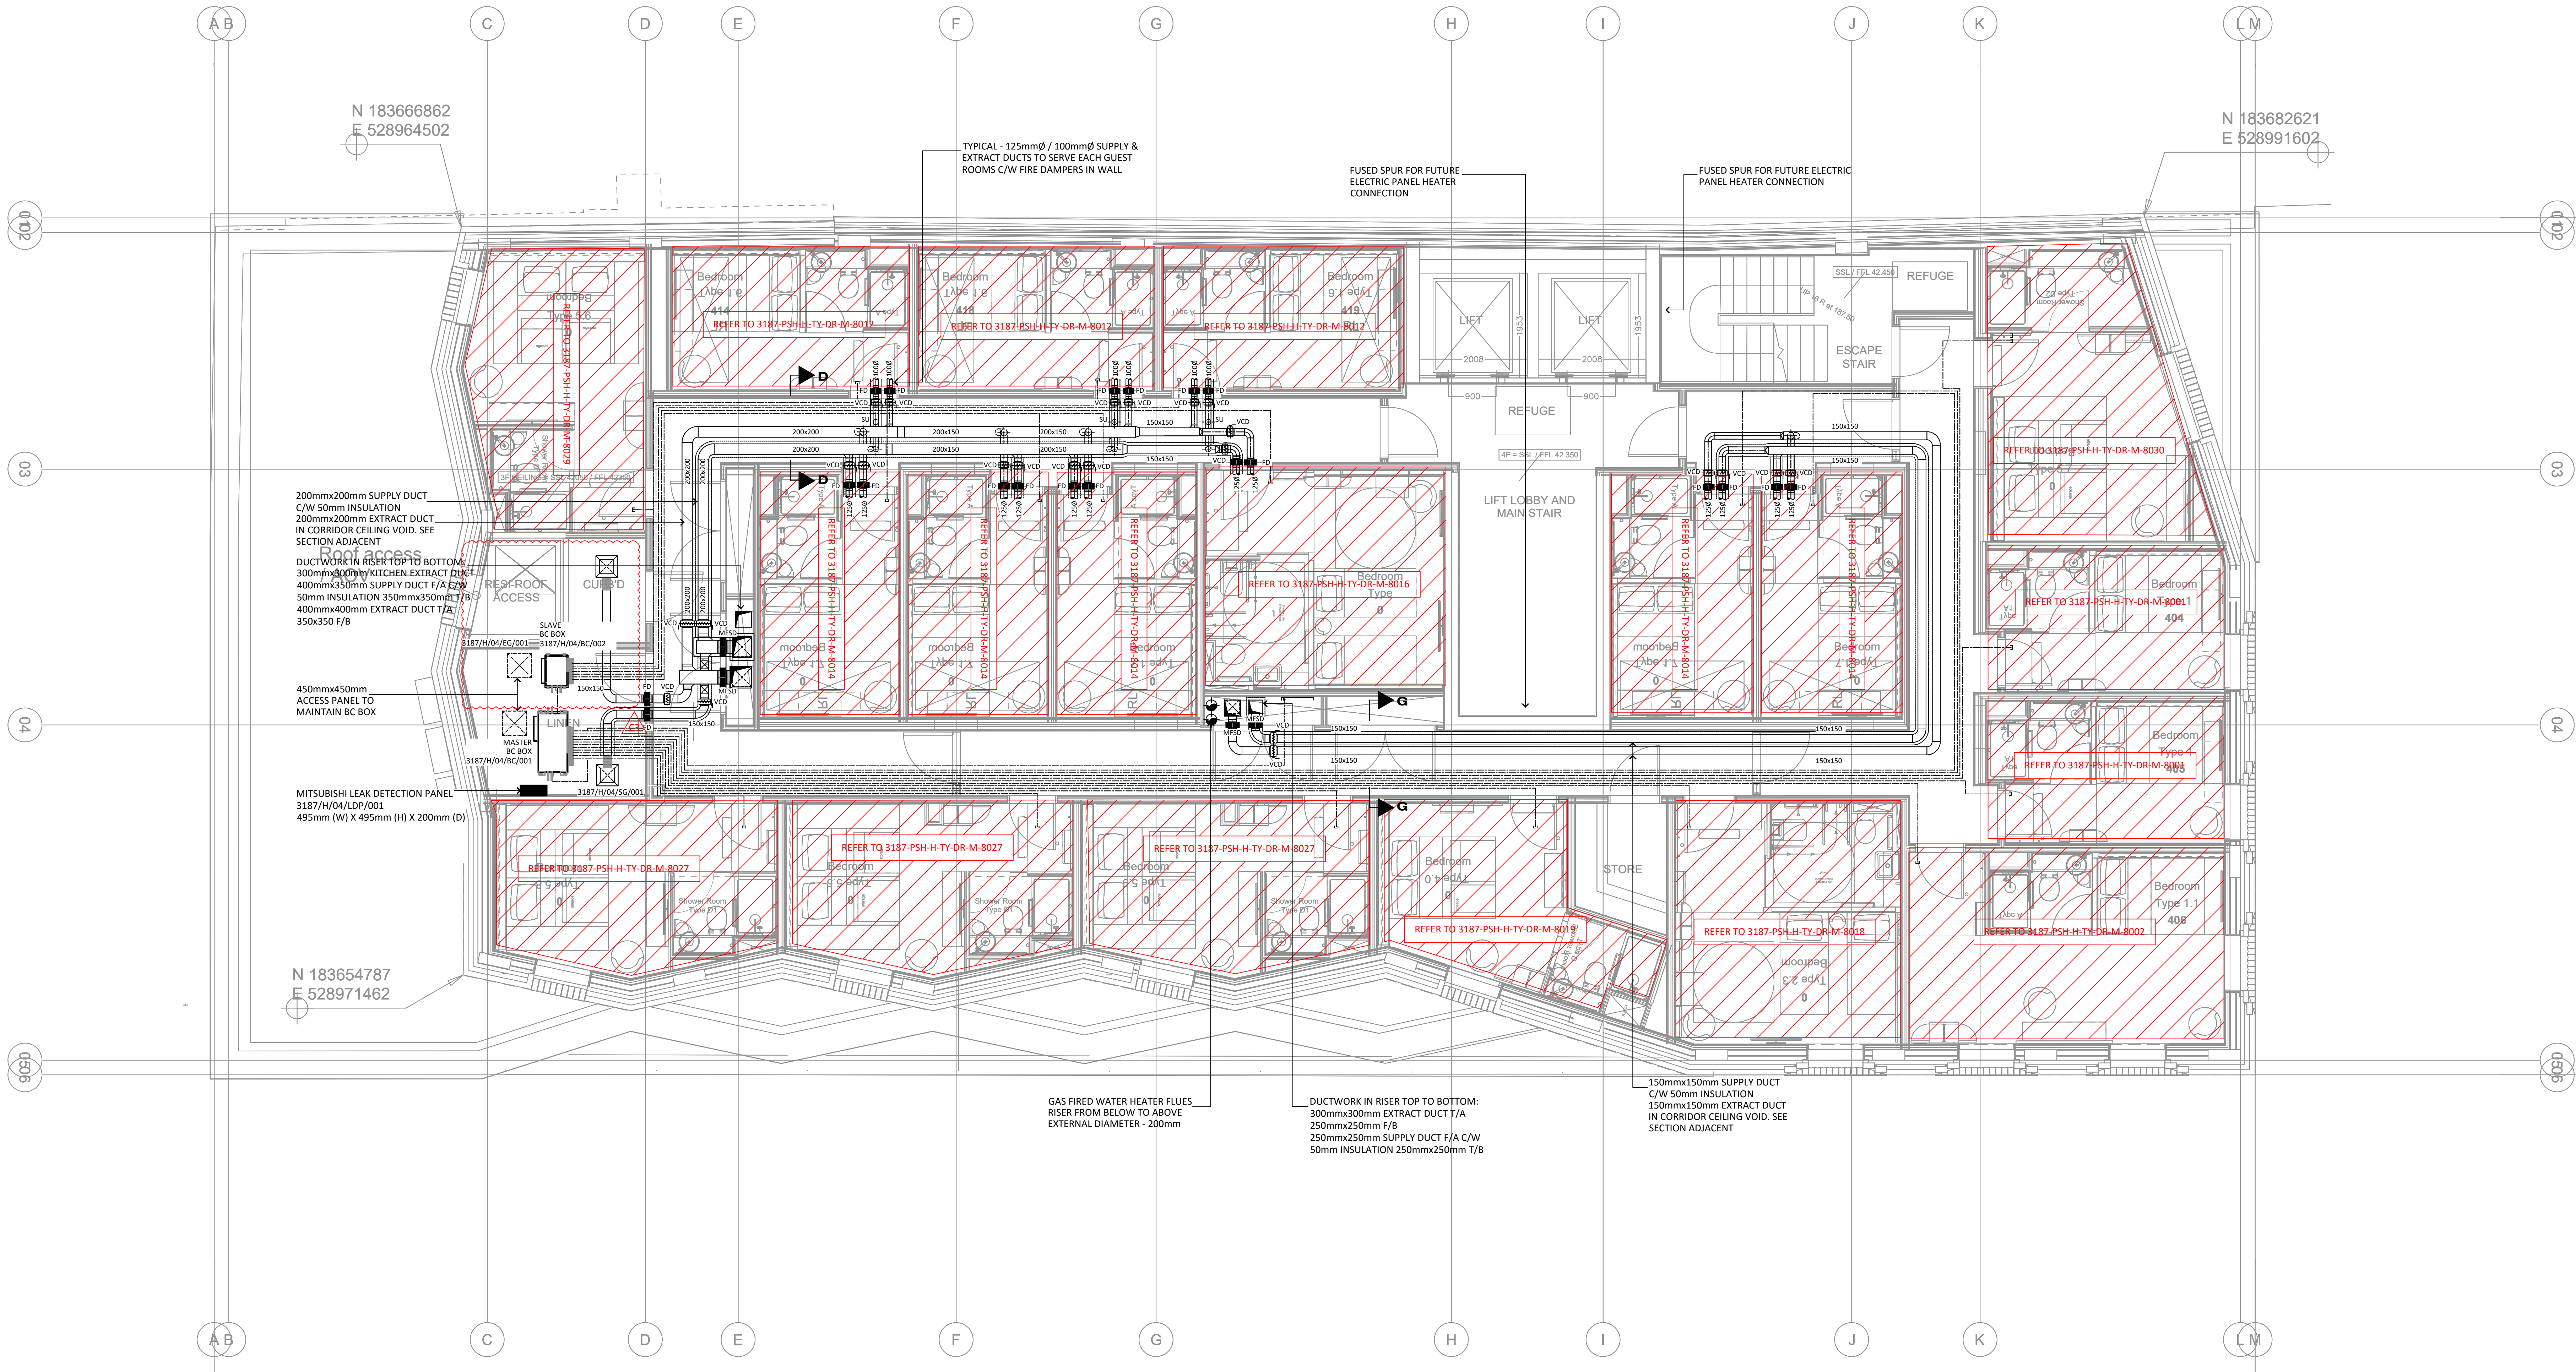

SECTION D-D (1:10)

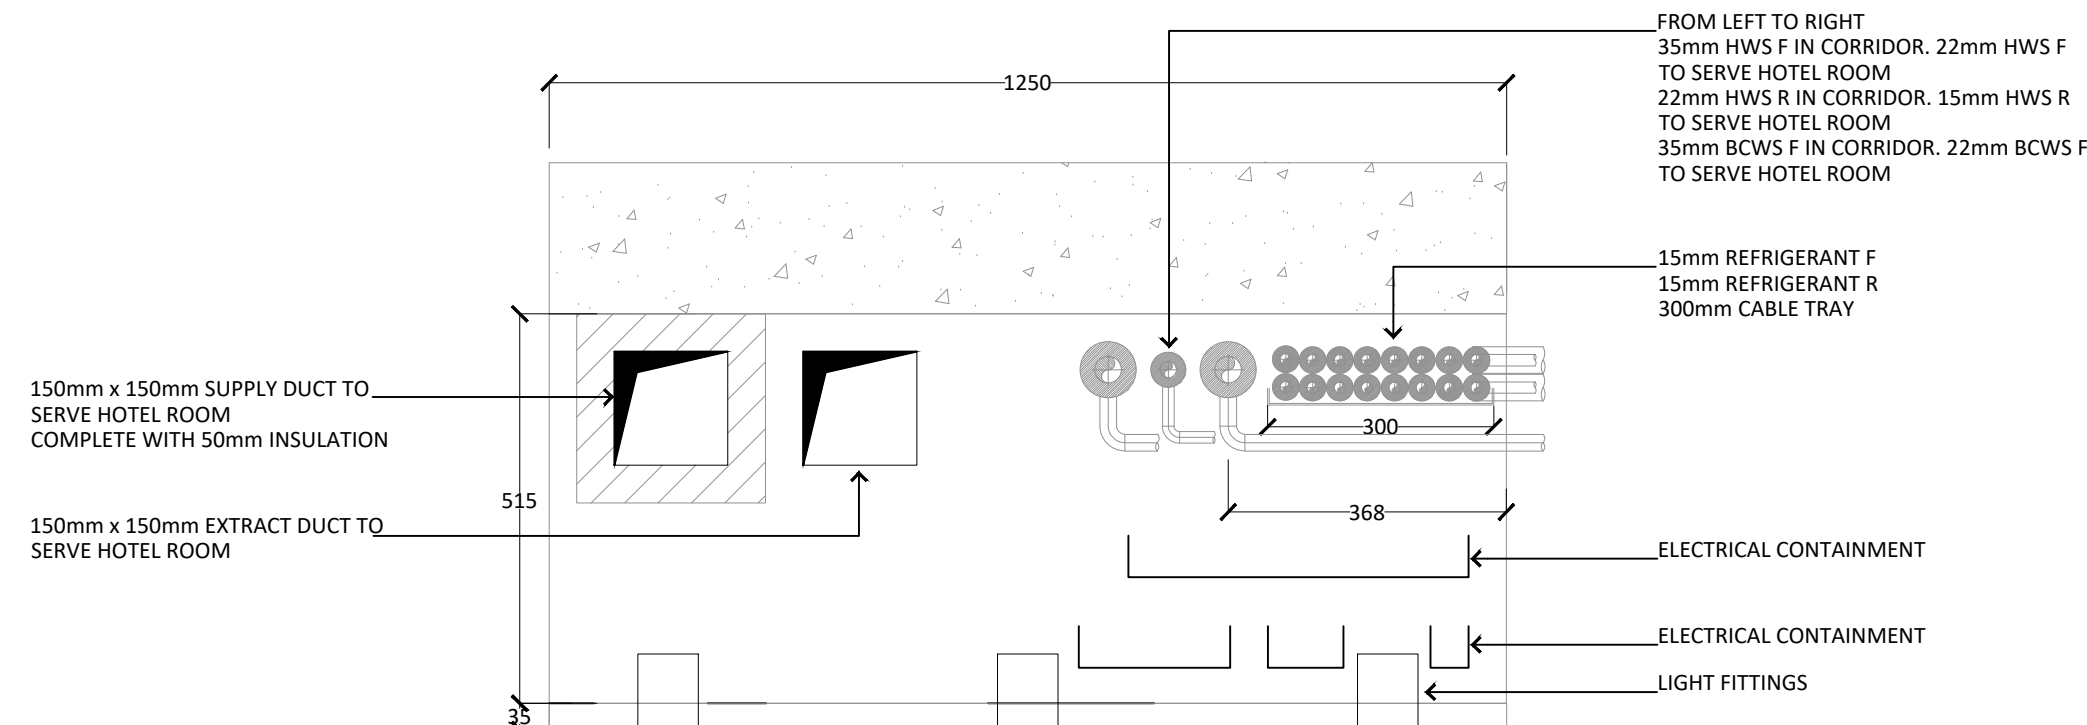

 SECTION G-G (1:10)



C3	REVISED FOR CONTRACT ISSUE	23.12.20
C2	DRAWING REVISED TO SUIT THE ARCHITECTS LAYOUT	20.11.20
C1	CONTRACT ISSUE	31.07.20
T2	STAGE 4 TENDER ISSUE	22.11.19
T1	STAGE 4 TENDER ISSUE	25.10.19
P1	STAGE 3 - PRELIMINARY ISSUE	16.08.19

Revision	Description	Date
----------	-------------	------

Drawing Status
----------------

CONTRACT
----------

PSH.	www.pshconsulting.co.uk
London Office 4th Floor, Alto Tower, 90 Stamford Street, London, SE1 9LQ T: 0202 039 3840 E: info@pshconsulting.co.uk	Wokingham Office 6 Alexandra Court, Wokingham Berkshire, RG40 2SL T: 0118 977 4747 E: info@pshconsulting.co.uk

Architect:	MORRIS + COMPANY
------------	------------------

Client:	DEMAR HOLDINGS
---------	----------------

Project:	115 - 119 CAMDEN HIGH STREET
----------	------------------------------

Title:	FOURTH FLOOR MECHANICAL SERVICES DUCTWORK LAYOUT
--------	--

Drawn:	Chkd/Appd:	Date:
CDL	MB	21.04.19
CDL File:	3187-PSH-H-04-DR-M-7011.DWG	Scale:
3187-PSH-H-04-DR-M-7011		1:50@A0
Drawing Number:		Rev:
		C3