

F FURNITURE SCHEDULE

DESIGN ID	COUNT	DESCRIPTION	RESP	COMMENTS
INDOOR				
10123	1	MANAGER'S DESK	GC	-
10605	1	MANAGER'S DESK KEYBOARD TRAY	GC	-
10809	1	MANAGER'S WORKSTATION SHELVES	GC	-
17644	10	TABLE - TOP ROUND - 24IN 600MM - WHITE OAK WD0073	WH	-
20016	15	CHAIR - CAFE TABLET - WHITE OAK WD0073	WH	-
20018	7	CHAIR - STOOL 28IN 710MM ARCHED CANTED LEGS ROUND - WHITE OAK WD0073	WH	-
21353	10	TABLE BASE - CAFE HEIGHT INOX FLAT BLACK MT 0028	WH	-
VD013	1	CUSTOM CAFE PLAIN (LEATHER F0211, STRUCTURE WD0073)	VD	DIMENSIONS: 3935 (L) x 650 (W) x 915 (H)
XF001	2	MANAGER'S DESK CHAIR	GC	-
XF002	1	TABLE - BOH - 24IN 600MM - WHITE	WH	-
OUTDOOR				
14746	4	TABLE - BASE CAFE X BASE 580X710MM - BLACK MT0028	WH	-
17332	10	CHAIR - CAFE METAL MESH SUITE - BLACK MT0028	WH	-
17361	4	TABLE - TOP ROUND - 600MM - BLACK MT0028	WH	-
UK-XF020	8	CUSTOM BENCH 50X25MM METAL BASE RAL9005 - 82X32MM IROKO SLATS	GC	-
UK-XF021	4	CUSTOM OUTDOOR TABLE - IROKO 113X32 TABLE TOP SLATS - METAL BASE 50X25 FINISH RAL9005 SATIN	GC	-

E SPECIALTY EQUIPMENT SCHEDULE

DESIGN ID	COUNT	DESCRIPTION	RESP	COMMENTS
10091	1	CUP DISPENSER TALL HOT VERTICAL	SB	-
10093	1	MIRROR RESTROOM	GC	-
10099	1	RESTROOM TOILET PAPER HOLDER	GC	-
10110	1	FRIDGE REACH IN 1 DOOR RH	WH	-
10179	1	HAND DRYER SURFACE MOUNTED	GC	-
10267	3	FRIDGE UNDERCOUNTER 1 DOOR	WH	-
10293	1	STORAGE 10 COMP LOCKER	GC	-
10384	1	DIAPER CHANGING STATION HORIZONTAL	GC	-
10396	1	CUP DISPENSER SHORT HOT VERTICAL	SB	-
10416	2	WORKROOM WIRE SHELVING	WH	-
10462	2	STORAGE-WORKROOM SHELVING POSTS - STANDARD	WH	-
10467	1	FILE CABINET 2 DRAWER	GC	-
10698	1	STORAGE MOP RACK WITH 3 HOLDERS	GC	-
10791	2	CUP DISPENSER GRANDE VENTI COLD VERTICAL - STANDARD	SB	-
10836	1	STORAGE 10 COMP LOCKER TOP	GC	-
10855	2	CUP DISPENSER - GRANDE VENTI HOT VERTICAL - STANDARD	SB	-
10858	2	CUP DISPENSER TALL COLD VERTICAL	SB	-
10947	2	SOAP DISPENSER WALL MOUNTED	GC	-
10977	1	PAPER TOWEL DISPENSER WALL MOUNTED	GC	-
11104	1	STORAGE 10 COMP LOCKER BASE	GC	-
12407	2	OVEN TURBOCHEF NEXT GENERATION	SB	-
12508	2	BLENDER QUIET MODEL ON COUNTER	WH	-
13330	1	MOBILE CUP DISPENSER CADDY	SB	-
18295	2	ICE BIN DROP IN 40KG 380X640MM	CS	-
21324	1	TALL REFRIGERATED GRAB AND GO 120	VD	CIAM
21330	1	FOOD CASE - AMBIENT CASE 1200MM	VD	CIAM
XE001	2	WHEELIE BIN	GC	-

FF&E PLAN NOTES

- GENERAL CONTRACTOR TO SWITCH ON ALL ELECTRICAL EQUIPMENT AT LEAST 24 HOURS PRIOR TO HANDOVER. ANY ISSUES TO BE RAISED TO CONSTRUCTION MANAGER/PROJECT MANAGER IMMEDIATELY
- THE SITE IS SERVED BY THE MUNICIPAL WATER AND SEWER SYSTEM UNLESS OTHERWISE NOTED
- ALL EQUIPMENT AND INSTALLATION MUST MEET LOCAL MARKET'S REGULATIONS, AND STARBUCKS STANDARDS.
- EQUIPMENT UNITS SHALL CONTAIN NO EXPOSED THREADS, EMBELLISHMENTS OR OVERHANGING EDGES THAT SERVE AS PLACES FOR ACCUMULATION OF DUST, DIRT AND DETRITUS
- GENERAL CONTRACTOR TO CONFIRM ALL EQUIPMENT OPERATIONAL, READY FOR TESTING AT PROJECT HANDOVER
- ALL HANDWASHING FACILITIES WILL BE SET OUT, INSTALLED AND TESTED IN LINE WITH LOCAL MARKET REGULATIONS/ STARBUCKS REQUIREMENTS OR EQUIVALENT
- FOR PLUMBING FIXTURES, REFER TO THE PLUMBING DESIGN PLAN. FOR DATA DEVICE SCHEDULE, REFER TO THE ELECTRICAL DESIGN PLAN
- CONFIRM ALL NECESSARY CLEARANCES PER PRODUCT CUT SHEET REQUIREMENTS FOR ALL EQUIPMENT (E.G. ICE MACHINE)
- ALL FURNITURE, FIXTURES AND EQUIPMENT WILL CONFORM TO LOCAL FIRE, SURFACE SPREAD OF FLAME, EVOLUTION OF HEAT REGULATIONS, AS SPECIFIED BY THE CONSTRUCTION MANAGER/PROJECT MANAGER
- WHERE AGREED, THE LICENSEE WILL MANUFACTURE AND SUPPLY SPECIFIED ITEMS. LICENSEE WILL FORWARD TO CONSTRUCTION MANAGER/PROJECT MANAGER TO FORWARD TO DESIGN DETAILED MANUFACTURING DRAWINGS FOR REVIEW, COMMENT AND/OR APPROVAL. WHERE NECESSARY, SAMPLES WILL ALSO BE REQUIRED FOR APPROVAL
- ALL FURNITURE TO HAVE RUBBER/NYLON FEET APPLIED TO LEGS OR SUPPORTS TO RAISE OFF FLOOR
- ALL EQUIPMENT TO BE INSTALLED ACCORDING TO MANUFACTURER'S SPECIFICATION. WHERE ANY REQUIREMENTS HAVE THE POTENTIAL TO IMPACT THE DESIGN INTENT, GENERAL CONTRACTOR TO CONTACT STARBUCKS
- ALL LOCALLY SOURCED ITEMS TO MEET LOCAL REQUIREMENTS AND STARBUCKS STANDARDS. ITEMS ARE REQUIRED TO BE APPROVED BY STARBUCKS DESIGNER.

SHEET NOTES

- GENERAL CONTRACTOR TO REVERSE DOOR HINGE ON UNDER COUNTER REFRIGERATOR TO LEFT-HAND SWING, AS SHOWN
- SECURE LOCKERS TO WALL
- PLACE FIRE EXTINGUISHER IN WORKROOM PER FIRE INSPECTOR'S REQUIREMENTS
- SPEAKERS TO BE MOUNTED AT MAXIMUM HEIGHT PER CUTSHEET UNLESS NOTED OTHERWISE
- SEE ELEVATIONS FOR DISTRIBUTION OF CUP DISPENSERS



LINework LEGEND

— LINE INDICATES EXISTING ITEMS RETAINED


RESPONSIBILITY LEGEND

UNLESS OTHERWISE AGREED, ALL ITEMS SUPPLIED ACCORDING TO PARTY LISTED IN "RESPONSIBILITY" COLUMN

GC	GENERAL CONTRACTOR
CS	CASEWORK SUPPLIER
CM	CONSTRUCTION MANAGER
LL	LANDLORD
SB	STARBUCKS
WH	STARBUCKS WAREHOUSE (3PL)
VD	STARBUCKS VENDOR DIRECT
LC	LICENSEE

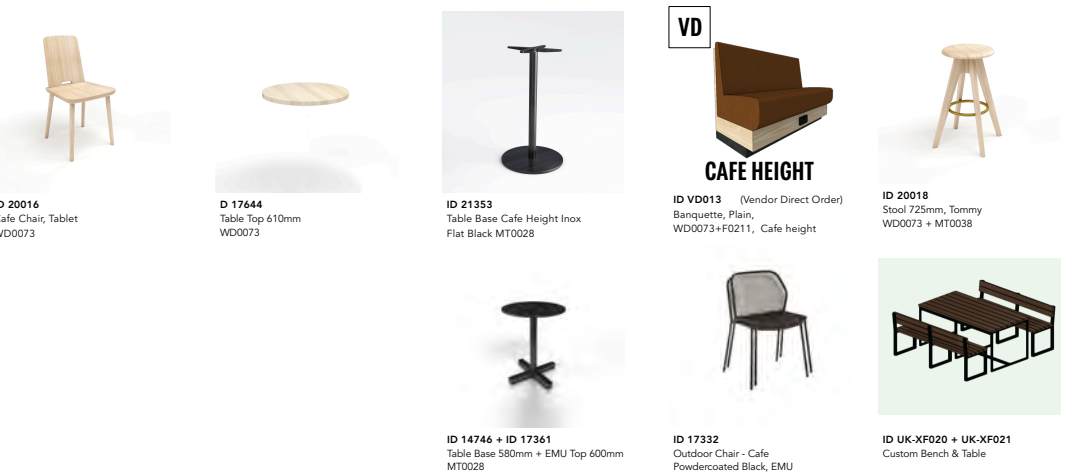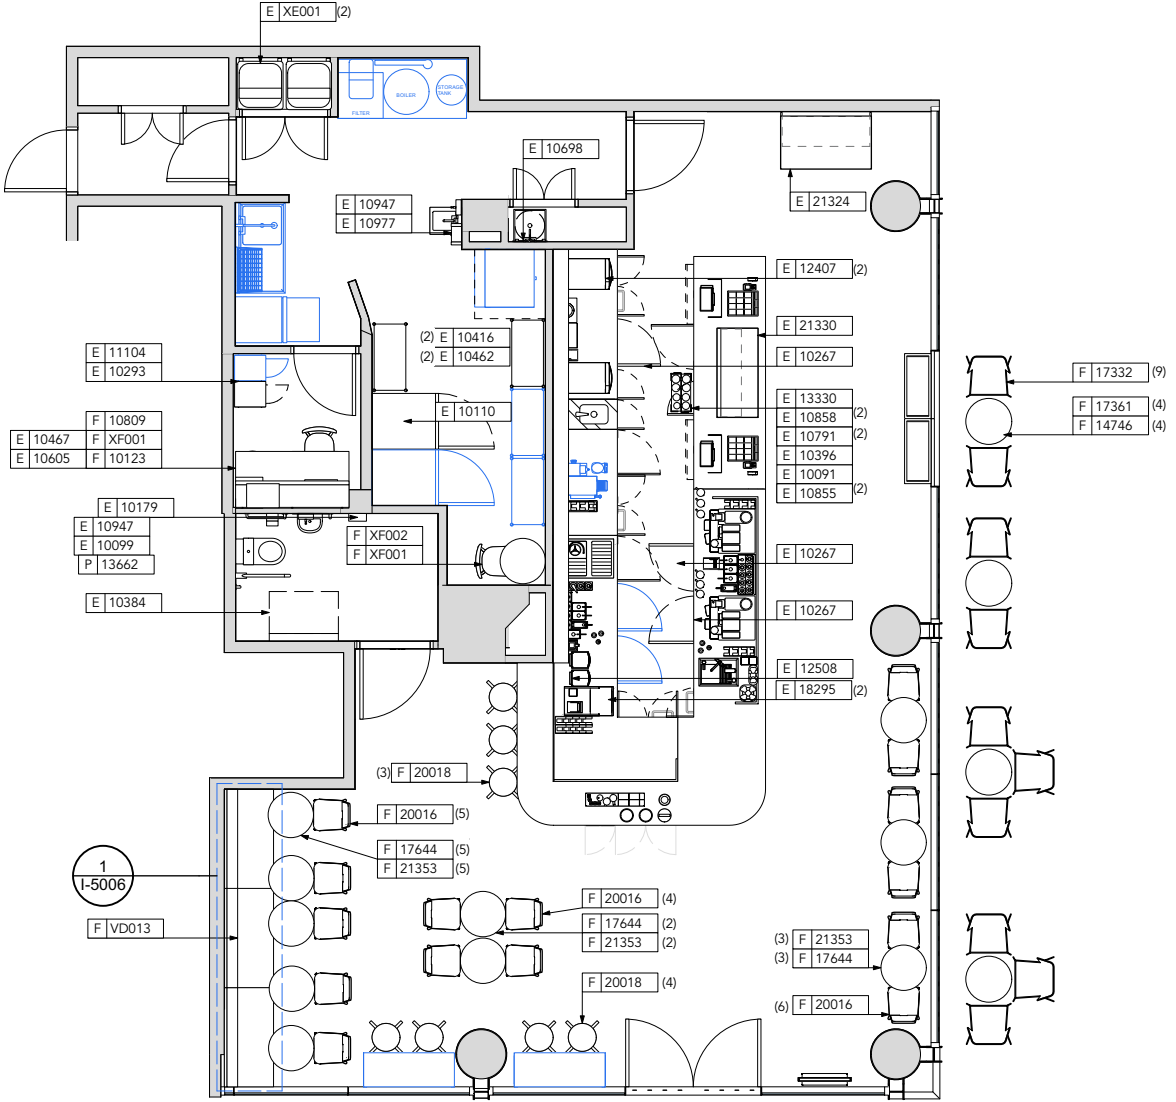

ID 20016 Cafe Chair, Tablet WD0073
 D 17644 Table Top 610mm WD0073
 E 21353 Table Base Cafe Height Inox Flat Black MT0028
 ID VD013 (Vendor Direct Order) Banquette, Plain, WD0073+F0211, Cafe height
 ID 20018 Stool 725mm, Tommy WD0073 + MT0038
 ID 14746 + ID 17361 Table Base 580mm + EMU Top 600mm MT0028
 ID 17332 Outdoor Chair - Cafe Powdercoated Black, EMU
 ID UK-XF020 + UK-XF021 Custom Bench & Table

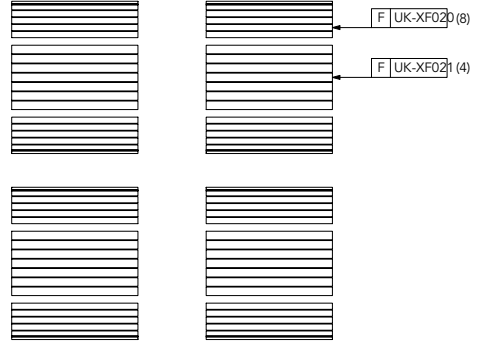

REMOTE OUTDOOR SEATING



Starbucks Coffee Company
 Building 4, Chiswick Park
 566 Chiswick High Road
 London, W4 5YE

These Drawings and Specifications are confidential and shall remain the sole property of Starbucks Corporation, which is the owner of the copyright in this work. They shall not be reproduced (in whole or in part), shared with third parties or used in any manner on other projects or extensions to this project without the prior written consent of Starbucks Corporation. These drawings and specifications are intended to express Design Intent for a prototypical Starbucks store (which is subject to change at anytime) and do not reflect actual site conditions. Neither party shall have any obligation nor liability to the other (except as stated above) until a written agreement is fully executed by both parties.

Architect of Record

Revision Schedule

Rev	Date	By	Description

CONSTRUCTION DRAWING SET

Project Name:
BRUNSWICK CENTRE

Project Address:
 UK
 LONDON, N1 1RU
 BRUNSWICK CENTRE, UNIT 7, WC1N 1AW

Store #: 12420
 Project #: 21365-049
 Concept:
 Palette:
 Issue Date: 28/01/22
 Design Manager: CHRISTOPHER COOK
 Project Designer: ANJA SCHRODER
 Production Designer: GP (EVOLVE)
 Checked by: RM (EVOLVE)

Sheet Title:
FF&E Plan & Schedules

Scale: As indicated

Sheet Number:
I-1105

