


SITE PLAN: Easy As Tap, Basement, 20 Lambs Conduit Street, London WC1N 3LE

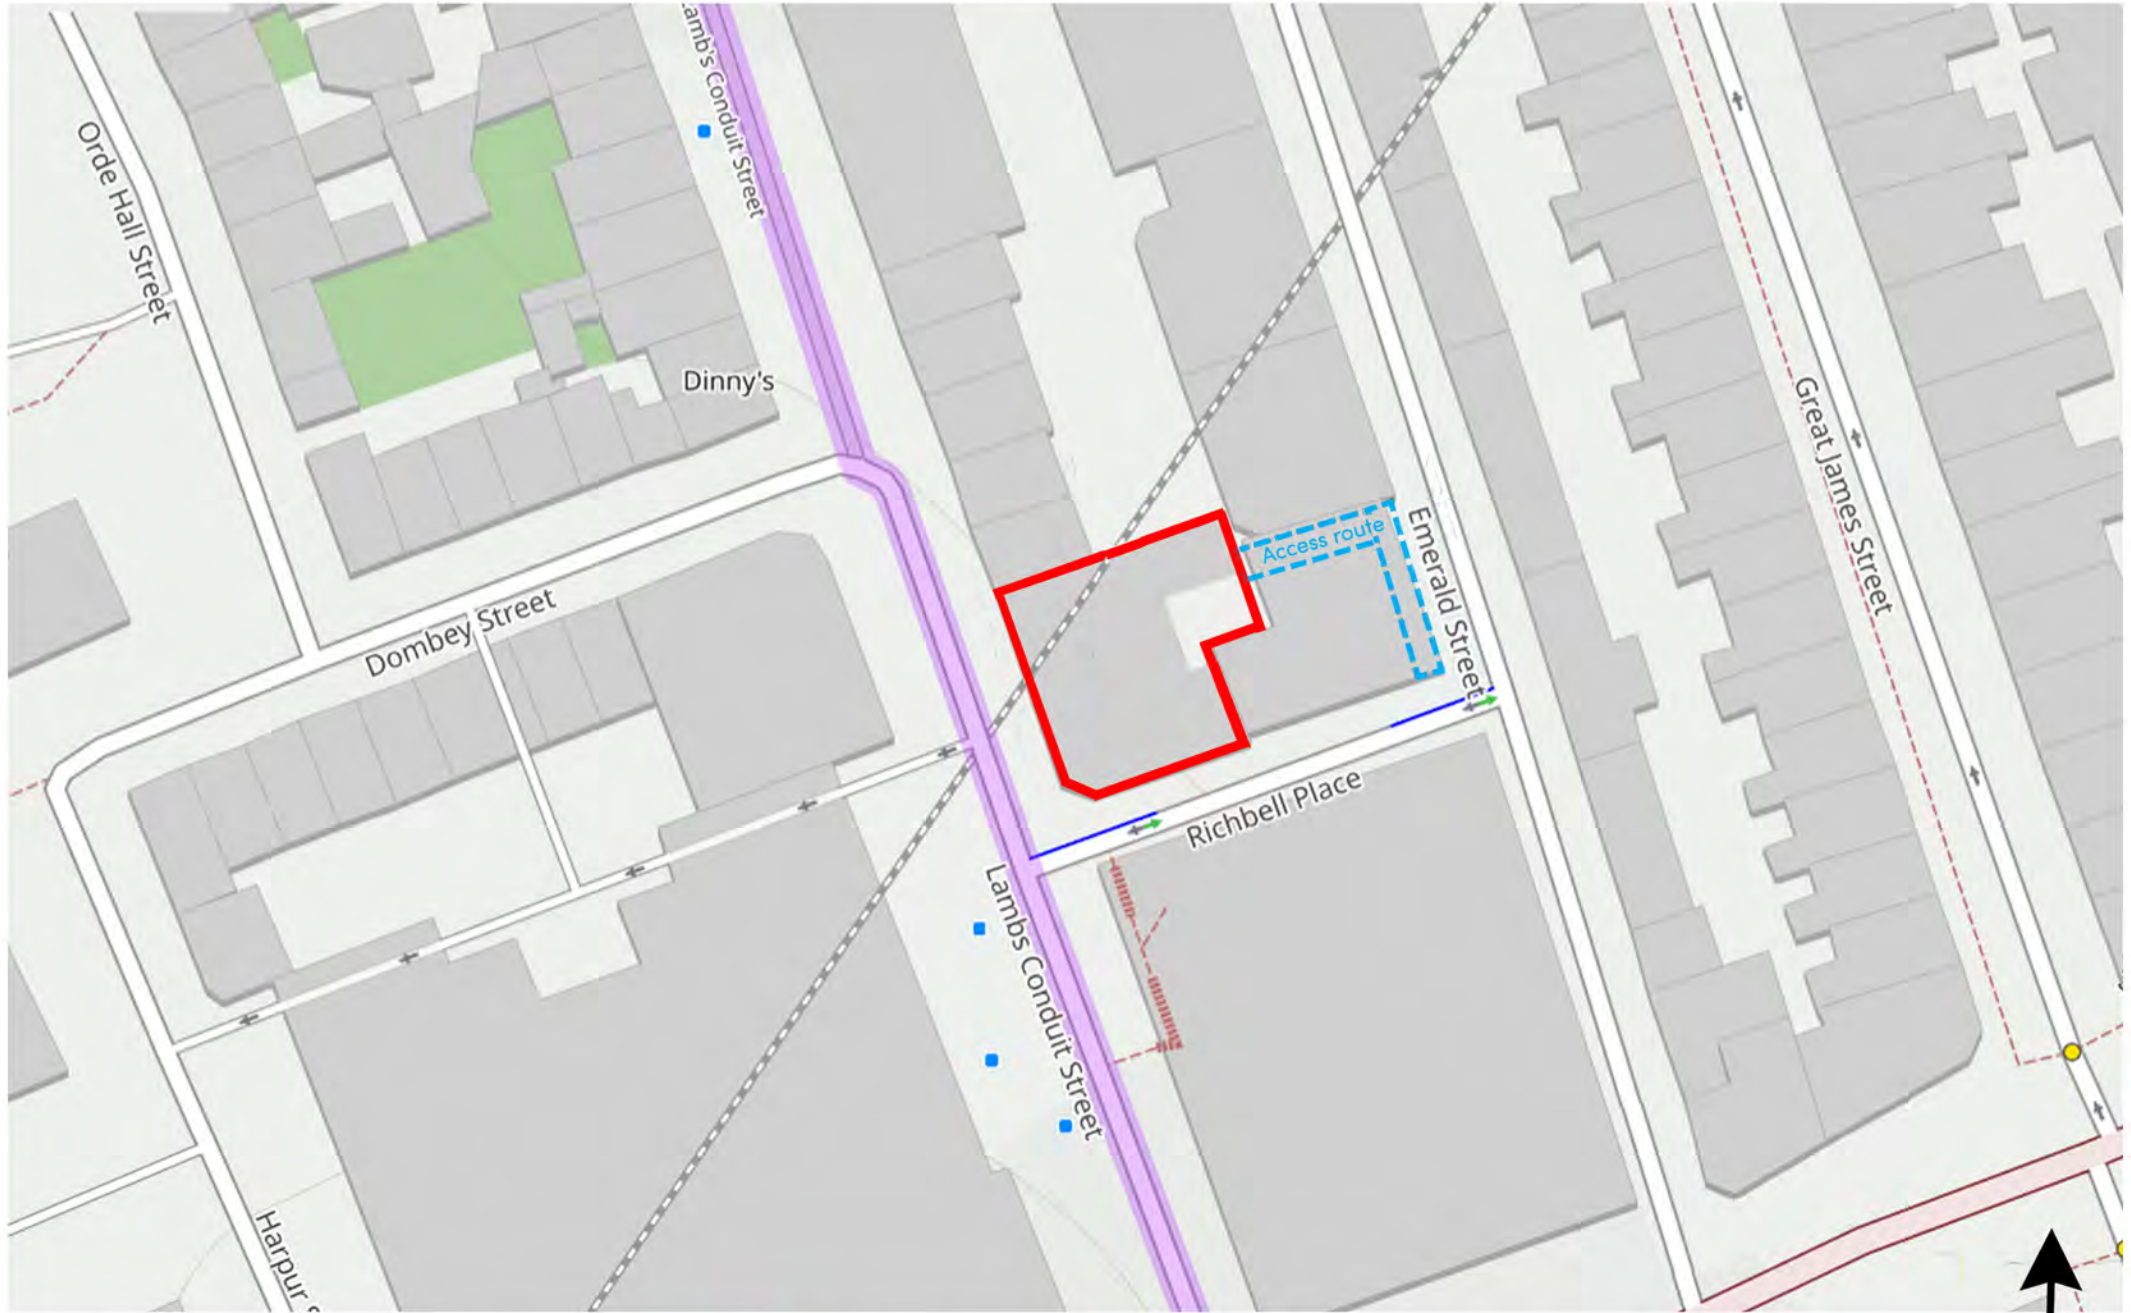


Scale 1:1500 @A4

10m

Premises location



PREMISES PLAN : Easy As Tap, Basement, 20 Lambs Conduit Street, London WC1N 3LE

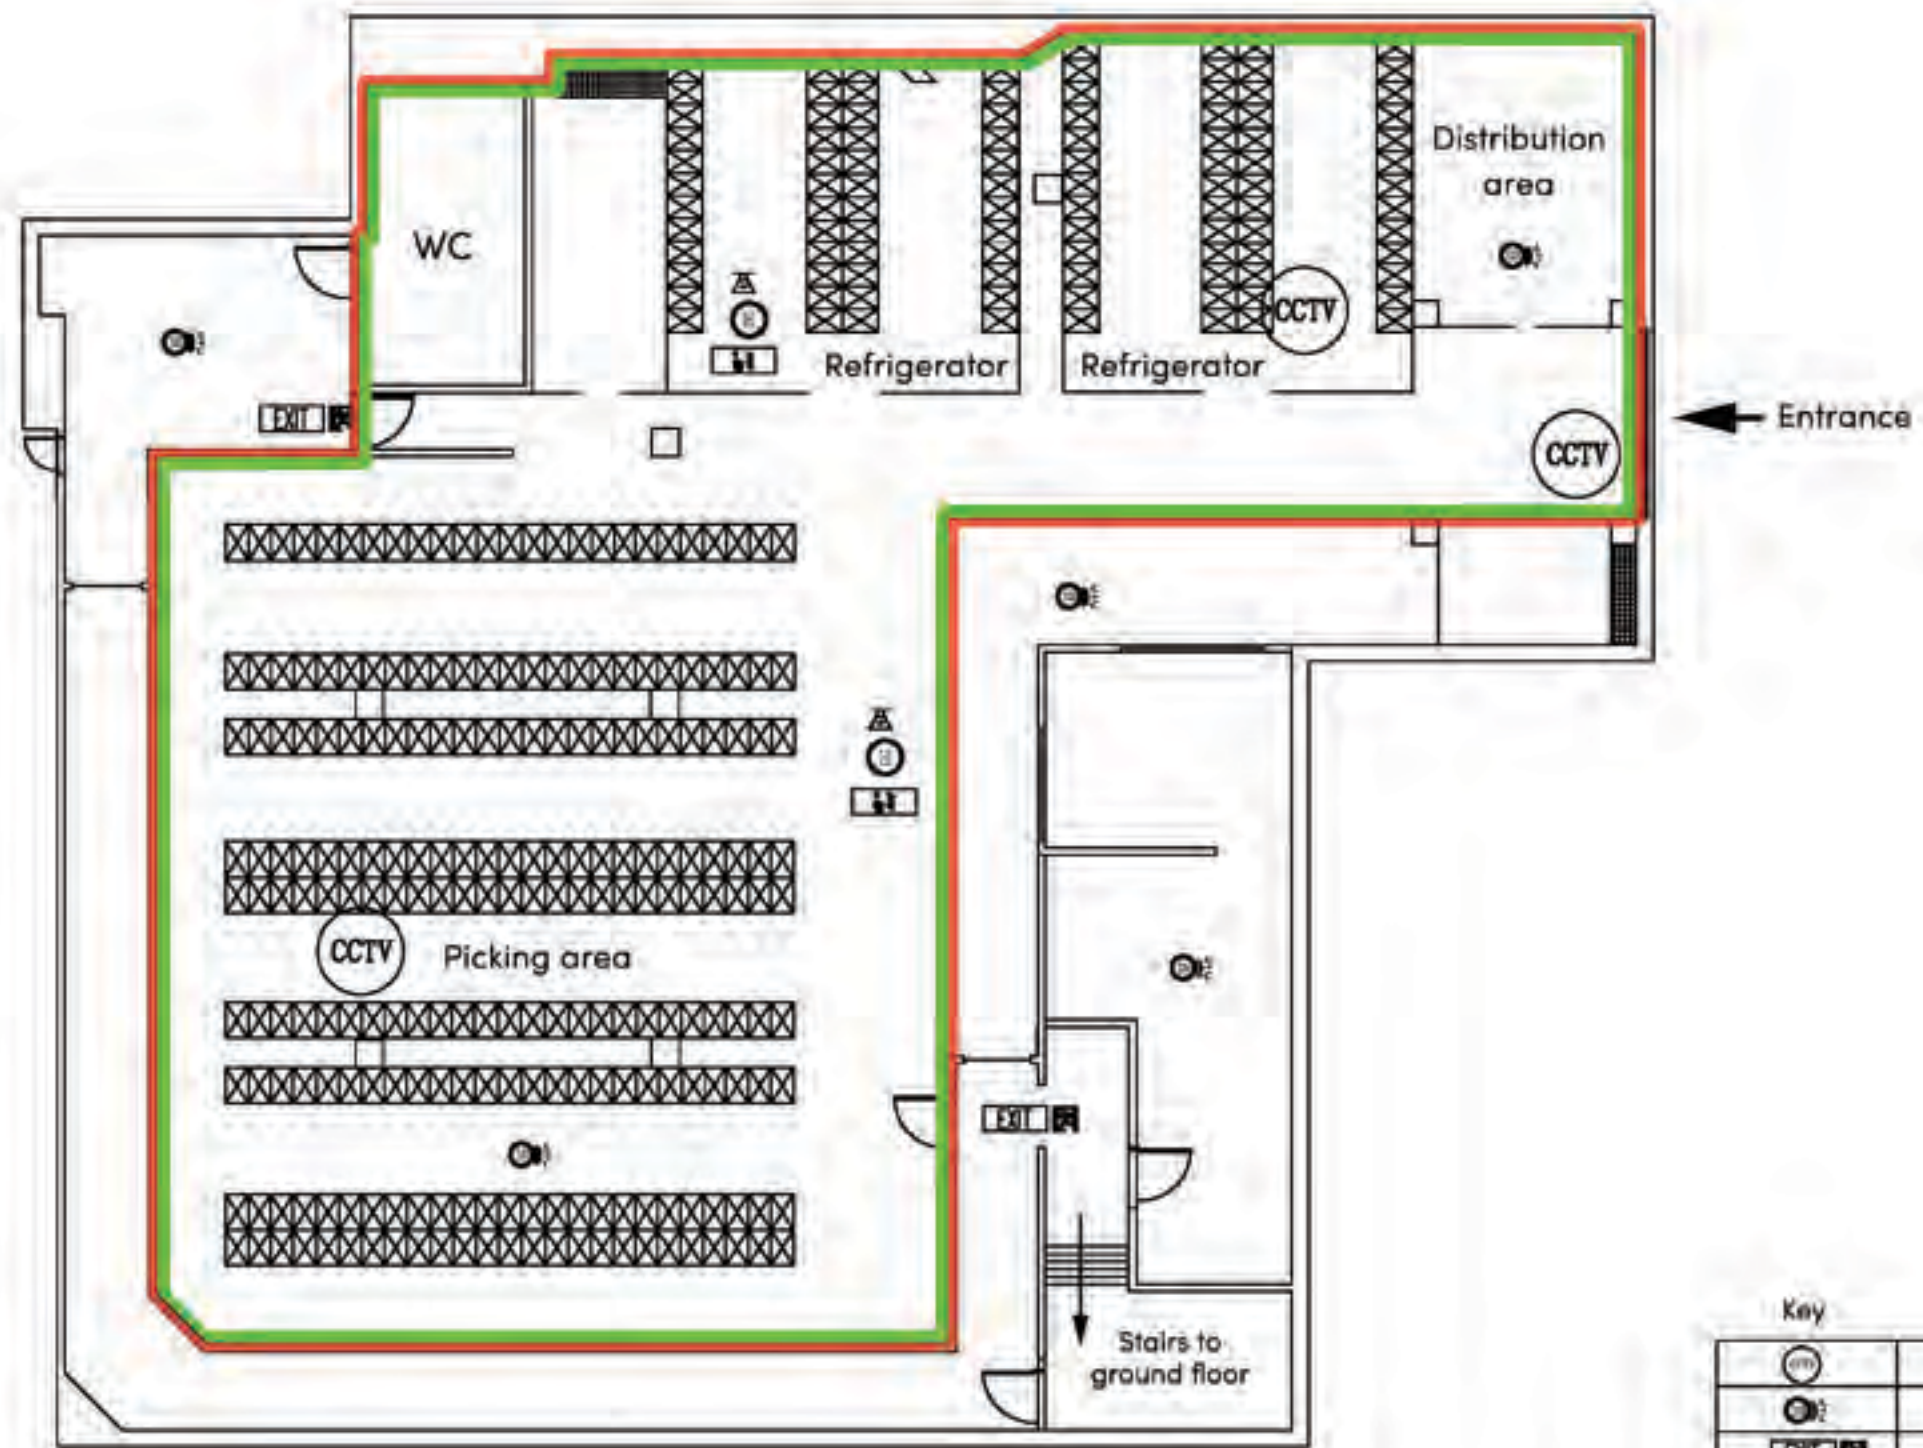

Key	
	CCTV camera
	Smoke detector
	Fire exit
	Fire extinguisher
	Fire blanket
	Heat detector
	Fire control panel
	Alcohol storage/packaging
	Premises boundary



0 1m 5m

Scale 1:100 @ A3