


- Key**
- △ single socket
 - △△ double socket
 - △△△△ 4 gang socket
 - single spur
 - ⊖ shaver socket
 - ⊖ cooker control
 - ⊖ cooker control
 - ⊖ transformer
 - ⊖ distribution board
 - ⊖ isolator
 - ⊖ terminal to earth
 - ⊖ lightning protection
 - ⊖ radio
 - ⊖ television
 - ⊖ private service tv
 - ⊖ cctv
 - ⊖ telephone
 - ⊖ modem
 - ⊖ fax
 - ⊖ CAT 6 socket
 - ⊖ extract fan
 - ↗ single switch
 - ↗ double switch
 - ↗ three pole switch
 - ↗ four pole switch
 - ↗ two-way switch
 - ↗ pull-cord switch
 - ↗ time operated switch
 - ↗ dimmer switch
 - push button switch
 - single light
 - spot light
 - flood light
 - fluorescent light
 - ⊗ emergency light
 - ⊖ wall light
 - light with pull-cord
 - ⊕ mains operated smoke alarm
 - ceiling speakers

Notes:

- Smoke alarms to be provided in each room.
- Extract to bathrooms / W.C.'s
- Burglar alarm to be installed. Contact points on doors.

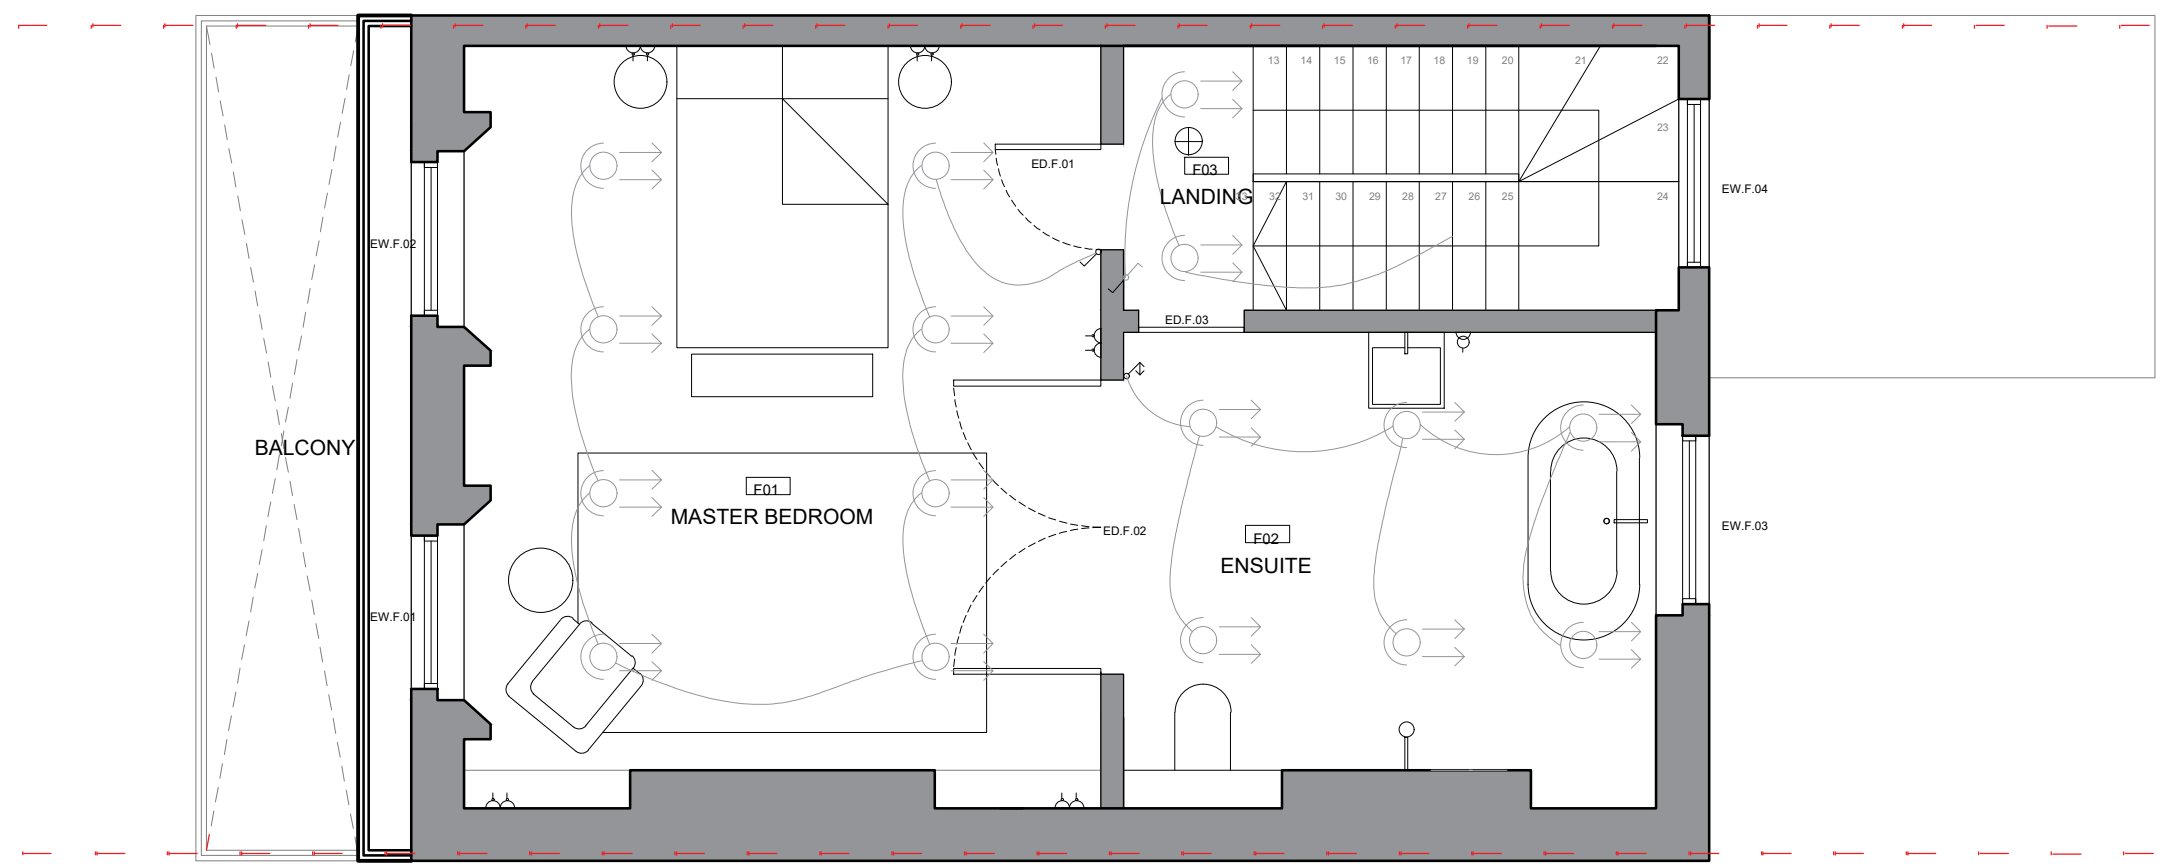

Rev	Date	Notes
LBF Architects		
4 Ash House, Ash Road, New Ash Green, DA3 8JD. Tel: 0207 536 2100 www.lbfarchitects.co.uk		
Project:		
60 DELANCEY STREET, LONDON, NW1 7RY		
Client:		
MR D BROOKS		
Drawing:		
LIGHTING & SMALL POWER - FIRST FLOOR PLAN		
Scale :	Drawn :	Checked : Date :
1 : 50 @ A3		
Drg no:		Rev:
2022-034-003		
DO NOT SCALE FROM THIS DRAWING. ALL DIMENSIONS TO BE CHECKED ON SITE. REFER ANY DISCREPANCIES TO ARCHITECT. THIS DRAWING IS SUBJECT TO COPYRIGHT.		