
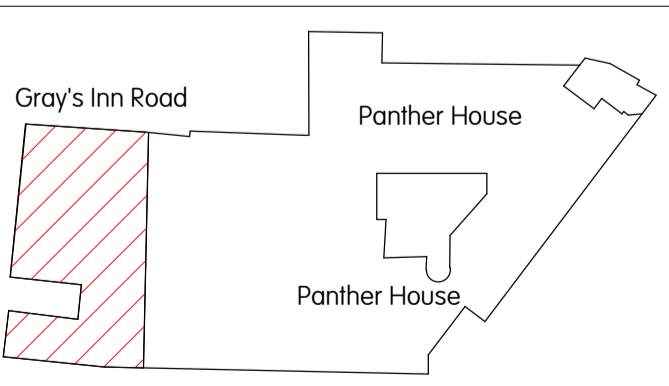


NOTES


1. This drawing is for engineering services only and is to be read in conjunction with all relevant architectural, structural, mTT drawings and the Contract specification.
2. THIS IS NOT AN INSTALLATION DRAWING.
3. All services routes and equipment locations are indicative, actual location and configuration to be determined by contractor following completion of contractor design and coordination.
4. This drawing will only be issued in PDF format.

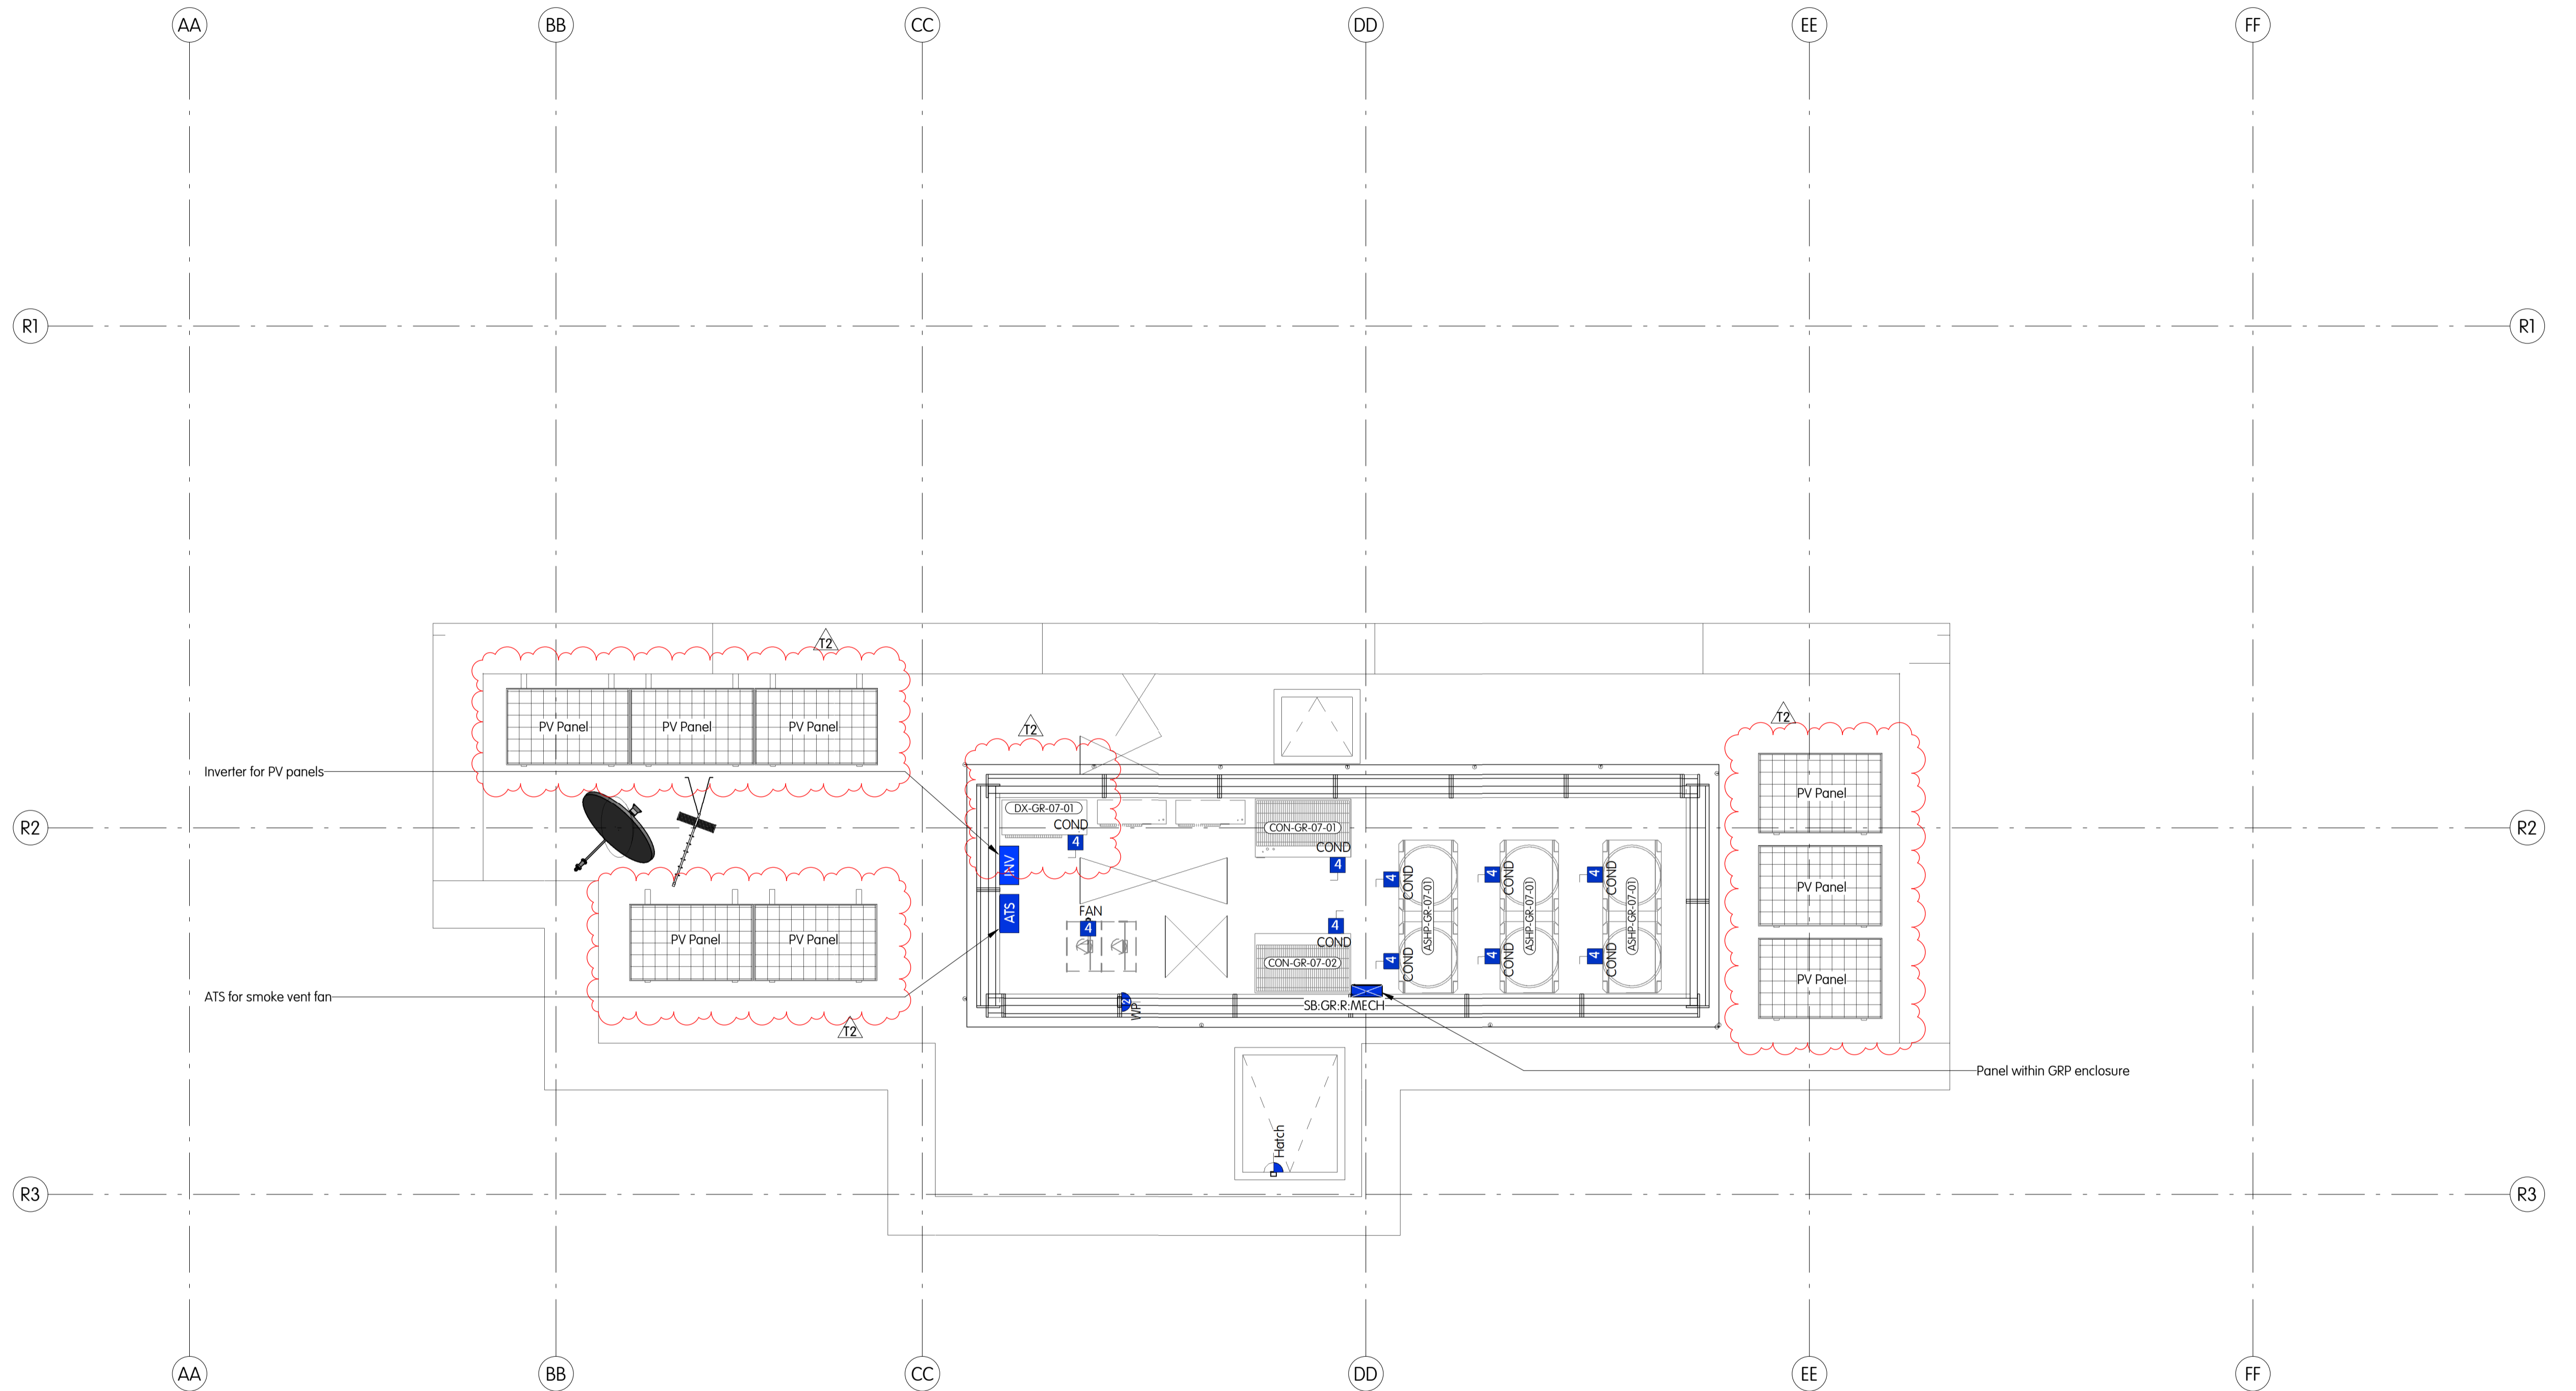

Copyright by mTT.
No copies of this drawing, however produced and/or transmitted may be made or undertaken, without the express permission of mTT.

This drawing should not be scaled. All dimensions to be checked on site any discrepancies to be notified to mTT.

Based on architectural model: 100%_RevA_ZZ_ZZ_A3_A-0001 Date: 2021-09-22 Based on structural model: PAH-EDC-XX_ZZ_A3-S-1000 Date: 2021-09-28	T2	16.06.2022	Stage 4 Issue addendum.	MC	LC
	T1	08.10.2021	Stage 4 Issue.	MV	LC
Rev.	Date	Description	Drawn	Checked	

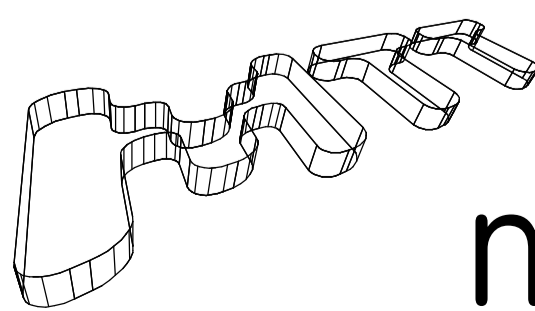

MTT/DRAWING

A 9 KINGSWAY
LONDON
WC2B 6XF
T +44 (0)20 7836 1133
F +44 (0)20 7836 1153
E info@mtt-limited.com
W mtt-limited.com

PM M.Ruzickova
Cad M.Castaldo
Date March 2021
Scale 1:50 @ A1
Status **Stage 4**

Panther House
Electrical Services
Gray's Inn Road - Roof
Small Power Layout

Drw No. 7127-MTT-GR-07-DR-E-2300

Revision T2

