


NOTES:

1. THIS DRAWING IS TO BE READ IN CONJUNCTION WITH HERITAGE APPRAISAL MARCH 2022, EEC PLANT IMPACT REPORT & PLANT SPECIFICATIONS & SCHEDULES.

LOCATION PLAN:-

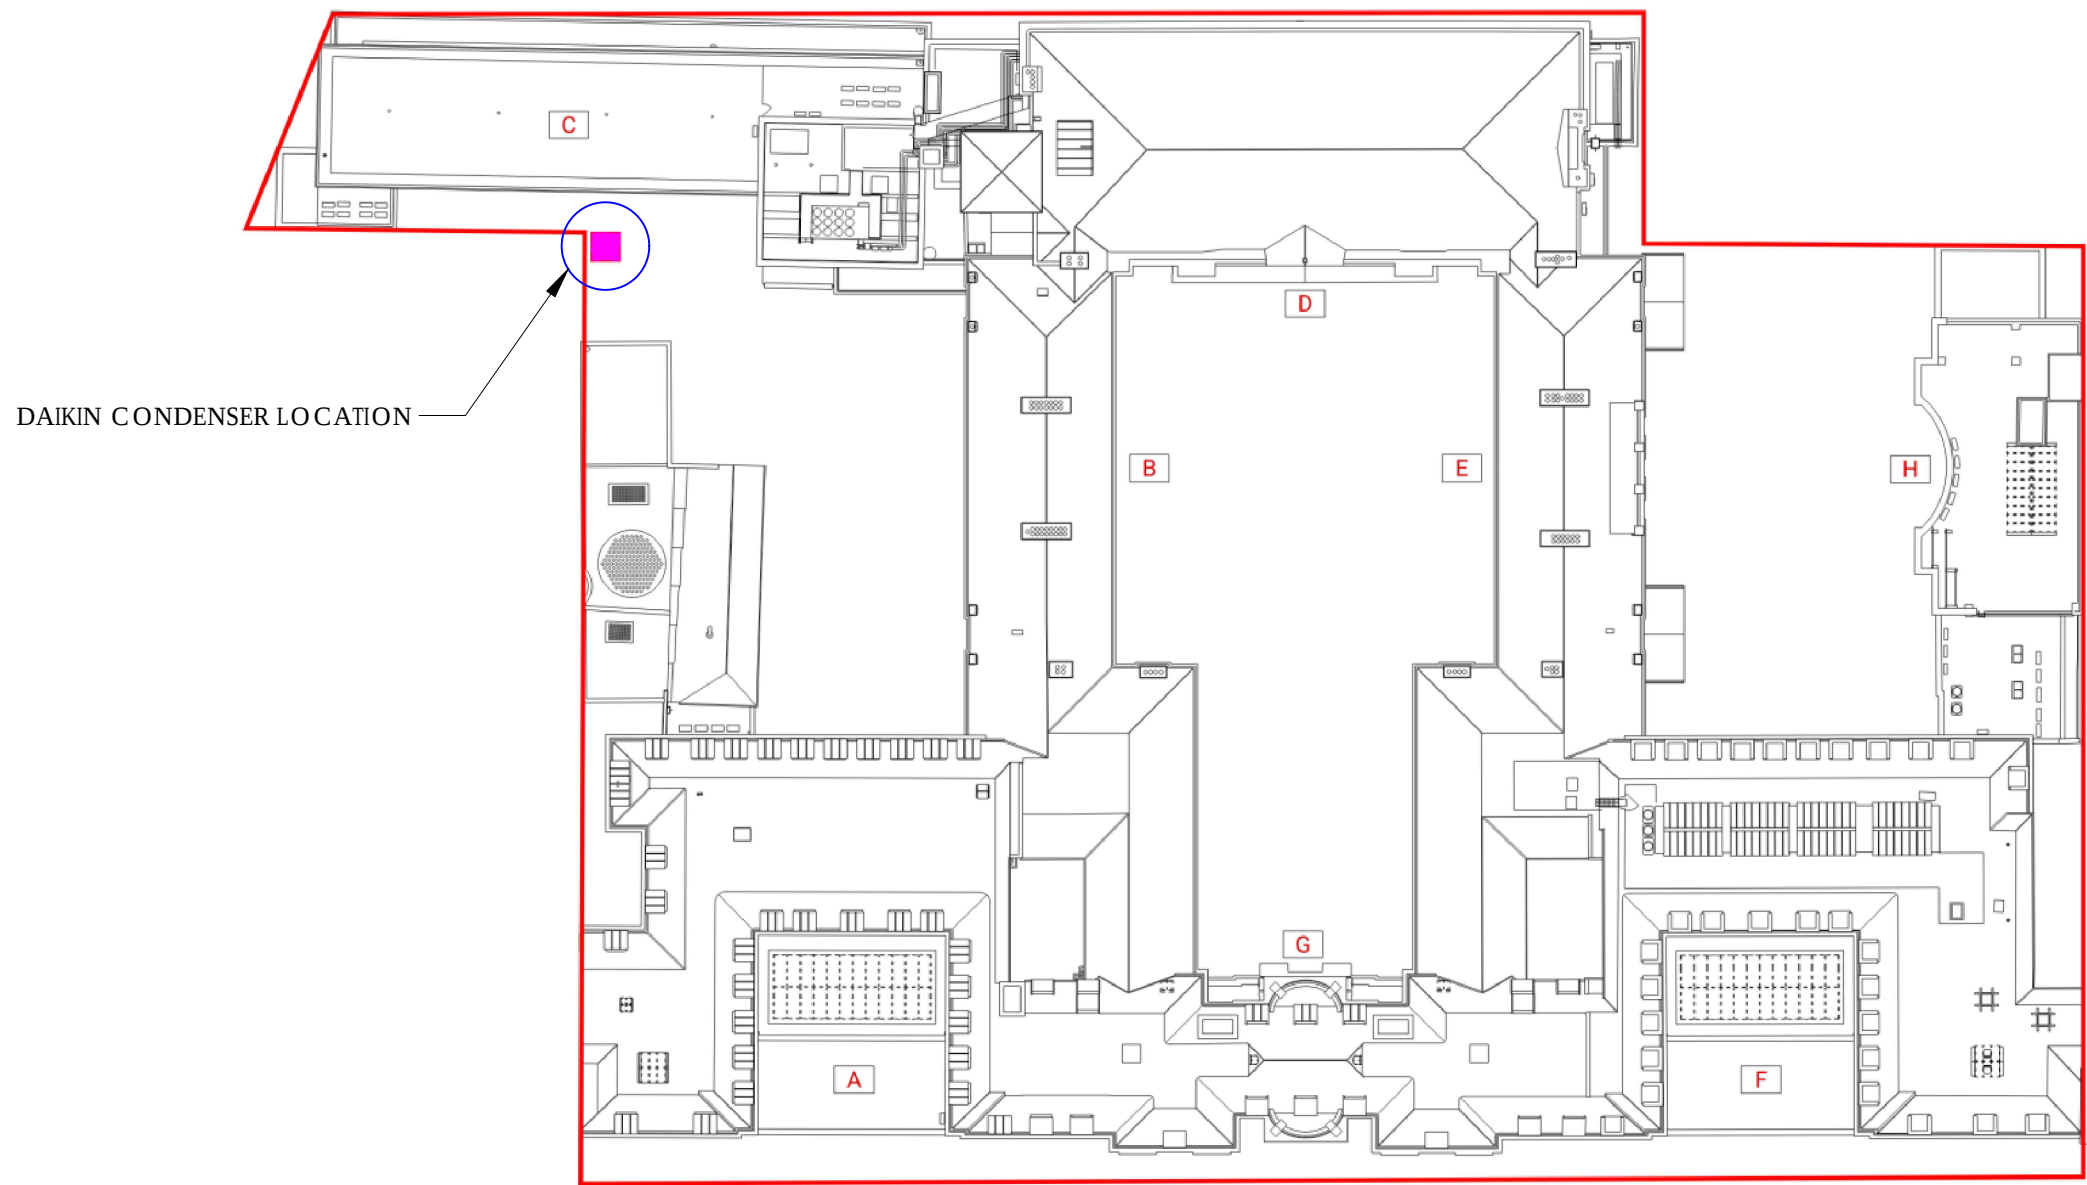

DUCTWORK SECTION c/w Bird Mesh

CONDENSER c/w ATTENUATOR
IN DUCTWORK ABOVE.




DUCTWORK SECTION c/w Bird Mesh

UNI-STRUT SUPPORT.

CONDENSER c/w ATTENUATOR
IN DUCTWORK ABOVE.



LOCATION PLAN:-

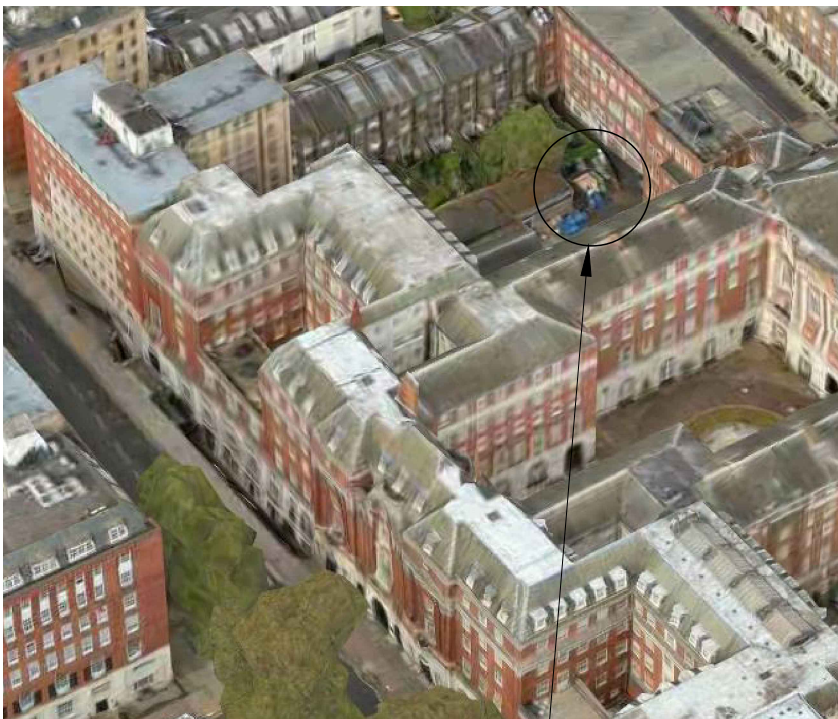


DUCTWORK SECTION c/w Bird Mesh

CONDENSER c/w ATTENUATOR
IN DUCTWORK ABOVE.

ISOLATOR

FRONT ELEVATION

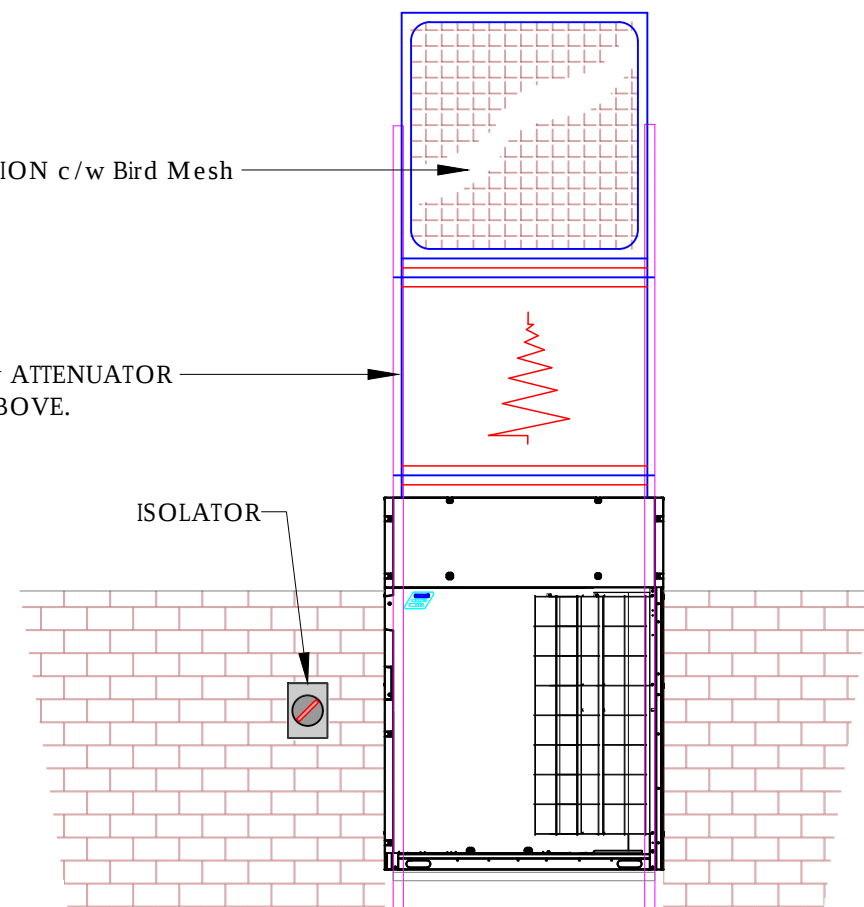


AIRFLOW

DUCTWORK SECTION c/w Bird Mesh

UNI-STRUT SUPPORT.

CONDENSER c/w ATTENUATOR
IN DUCTWORK ABOVE.

SIDE ELEVATION

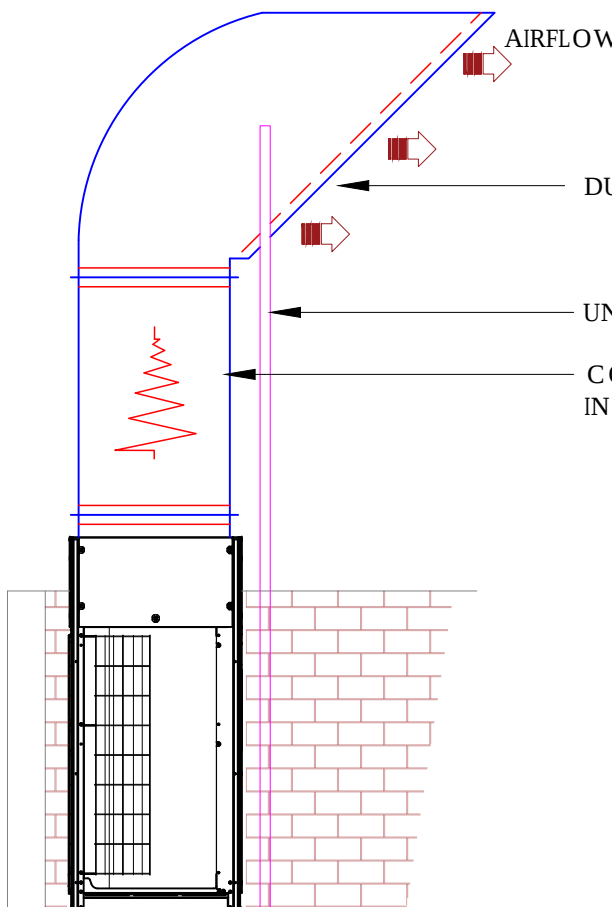


STREET MAP LOCATION PLAN:-



RETAINING BRICK WALL

ISOLATOR

PART PLAN

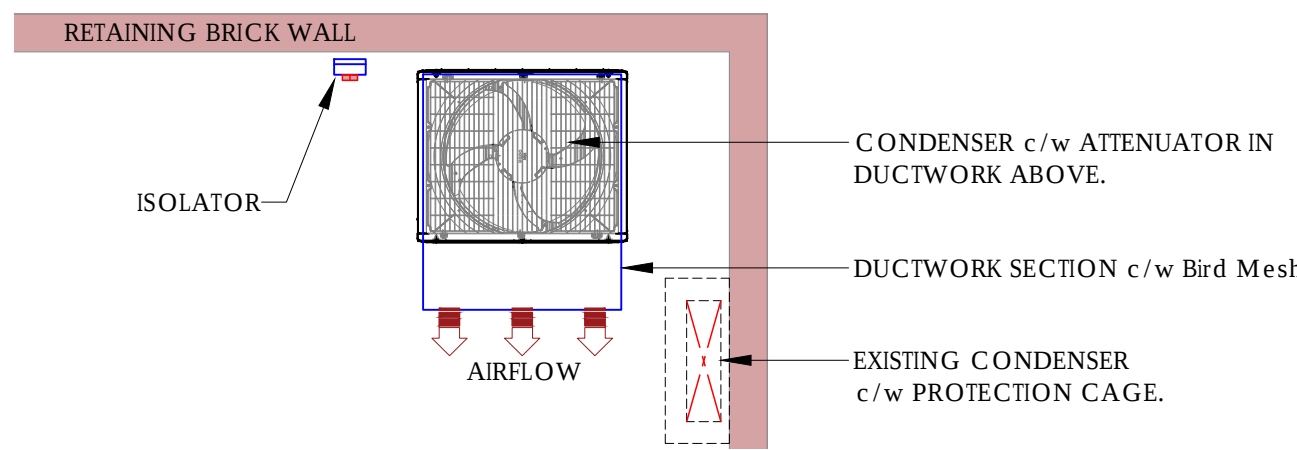

Drawing Status:

PLANNING APPROVAL



PROJECT

BRITISH MEDICAL ASSOCIATION
TAVISTOCK SQUARE,
LONDON

TITLE

CONDENSER LOCATION PLAN
LAYOUT

SCALE	DATE	PROJECT NO.	
N.T.S @ A1	27.05.2022		
DRAWN	AUTHORISED	DRAWING NO.	REV
Brett Williams	Darren Jedrzejewski	M_02	