


NOTES:
1. Do not scale the drawings.

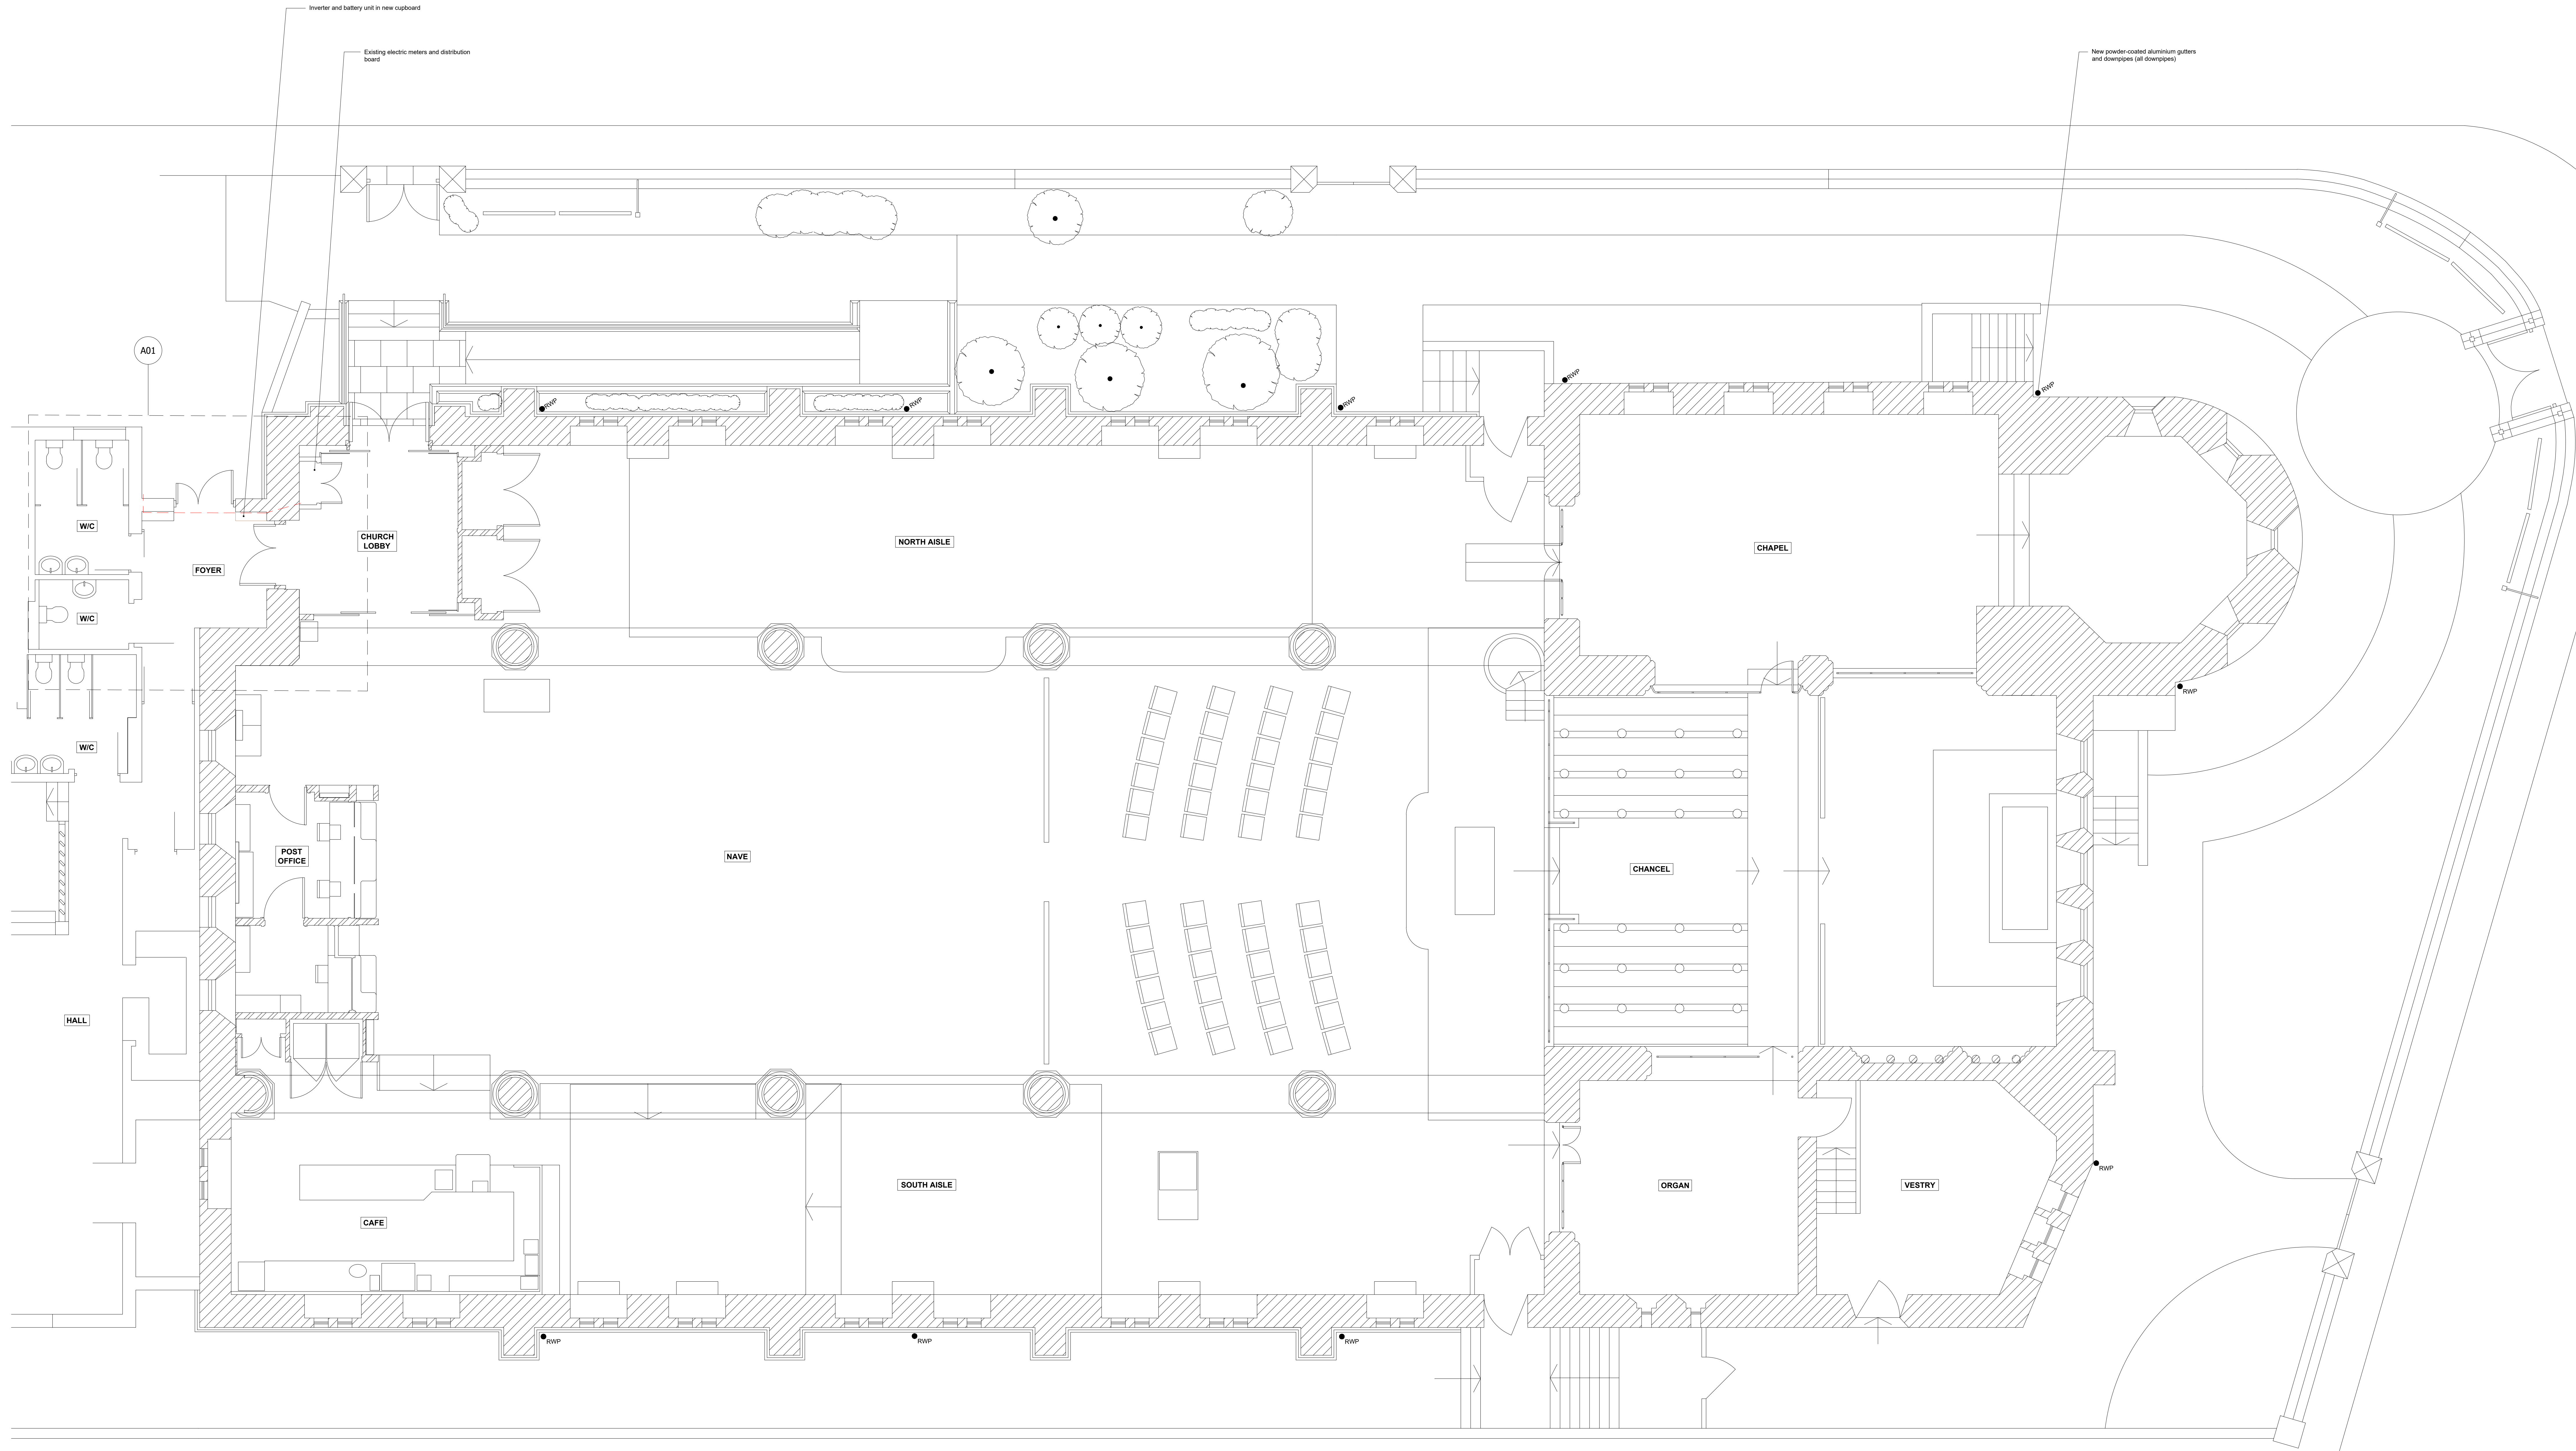

2022 01	Revised scale	Rev A
PROJECT		
ST JAMES', WEST HAMPSTEAD PHOTOVOLTAIC INSTALLATION		
TITLE		
PROPOSED FLOOR PLAN		
SCALE 1:50 @ A0	DATE 2021.11	DRAWN EJW/RLK
DRAWN EJW/RLK		
21-07A		
L07A		