
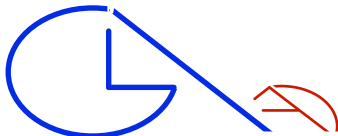



SKIRTING HEATING SYSTEM TYPE

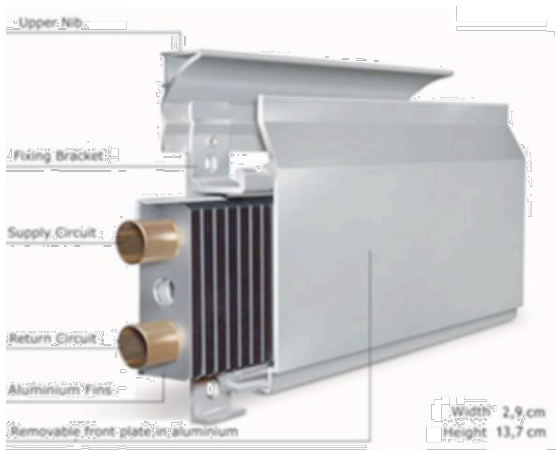

GLA Architecture and Design

Southgate Office Village, Block E,
286A Chase Road, London, N14 6HF
T 020 8886 5100 E g@glaad.co.uk

Client ALL SAINTS GREEK ORTHODOX CATHEDRAL		
Main Contractor		
Project ALL SAINTS GREEK ORTHODOX CATHEDRAL, CAMDEN STREET, LONDON NW1 0JA		
Drawing Title PROPOSED GROUND FLOOR SKIRTING HEATING DETAILS		
Scale 1:200 @ A3	Date June 2022	Drawn By DK
Project No. 0700	Drawing No. 05	Rev. A-
DO NOT SCALE THIS DRAWING. ALL DIMENSIONS TO BE CHECKED ON SITE		
© Copyright This drawing is the copyright of GLA Architecture and Design Ltd. This drawings and any works executed from this drawing shall, unless otherwise agreed in writing by GLA Architecture and Design Ltd, remain the property of the architect.		
DRAWING STATUS A SCHEME - Outline/Scheme drawings for proposals, budgets, etc. B DESIGN DEVELOPMENT - Evolving final design drawings for approvals, tenders, billing etc. C CONSTRUCTION - Fully developed drawings issued under instruction for construction. ONLY STATUS 'C' DRAWINGS TO BE USED FOR CONSTRUCTION PURPOSES		

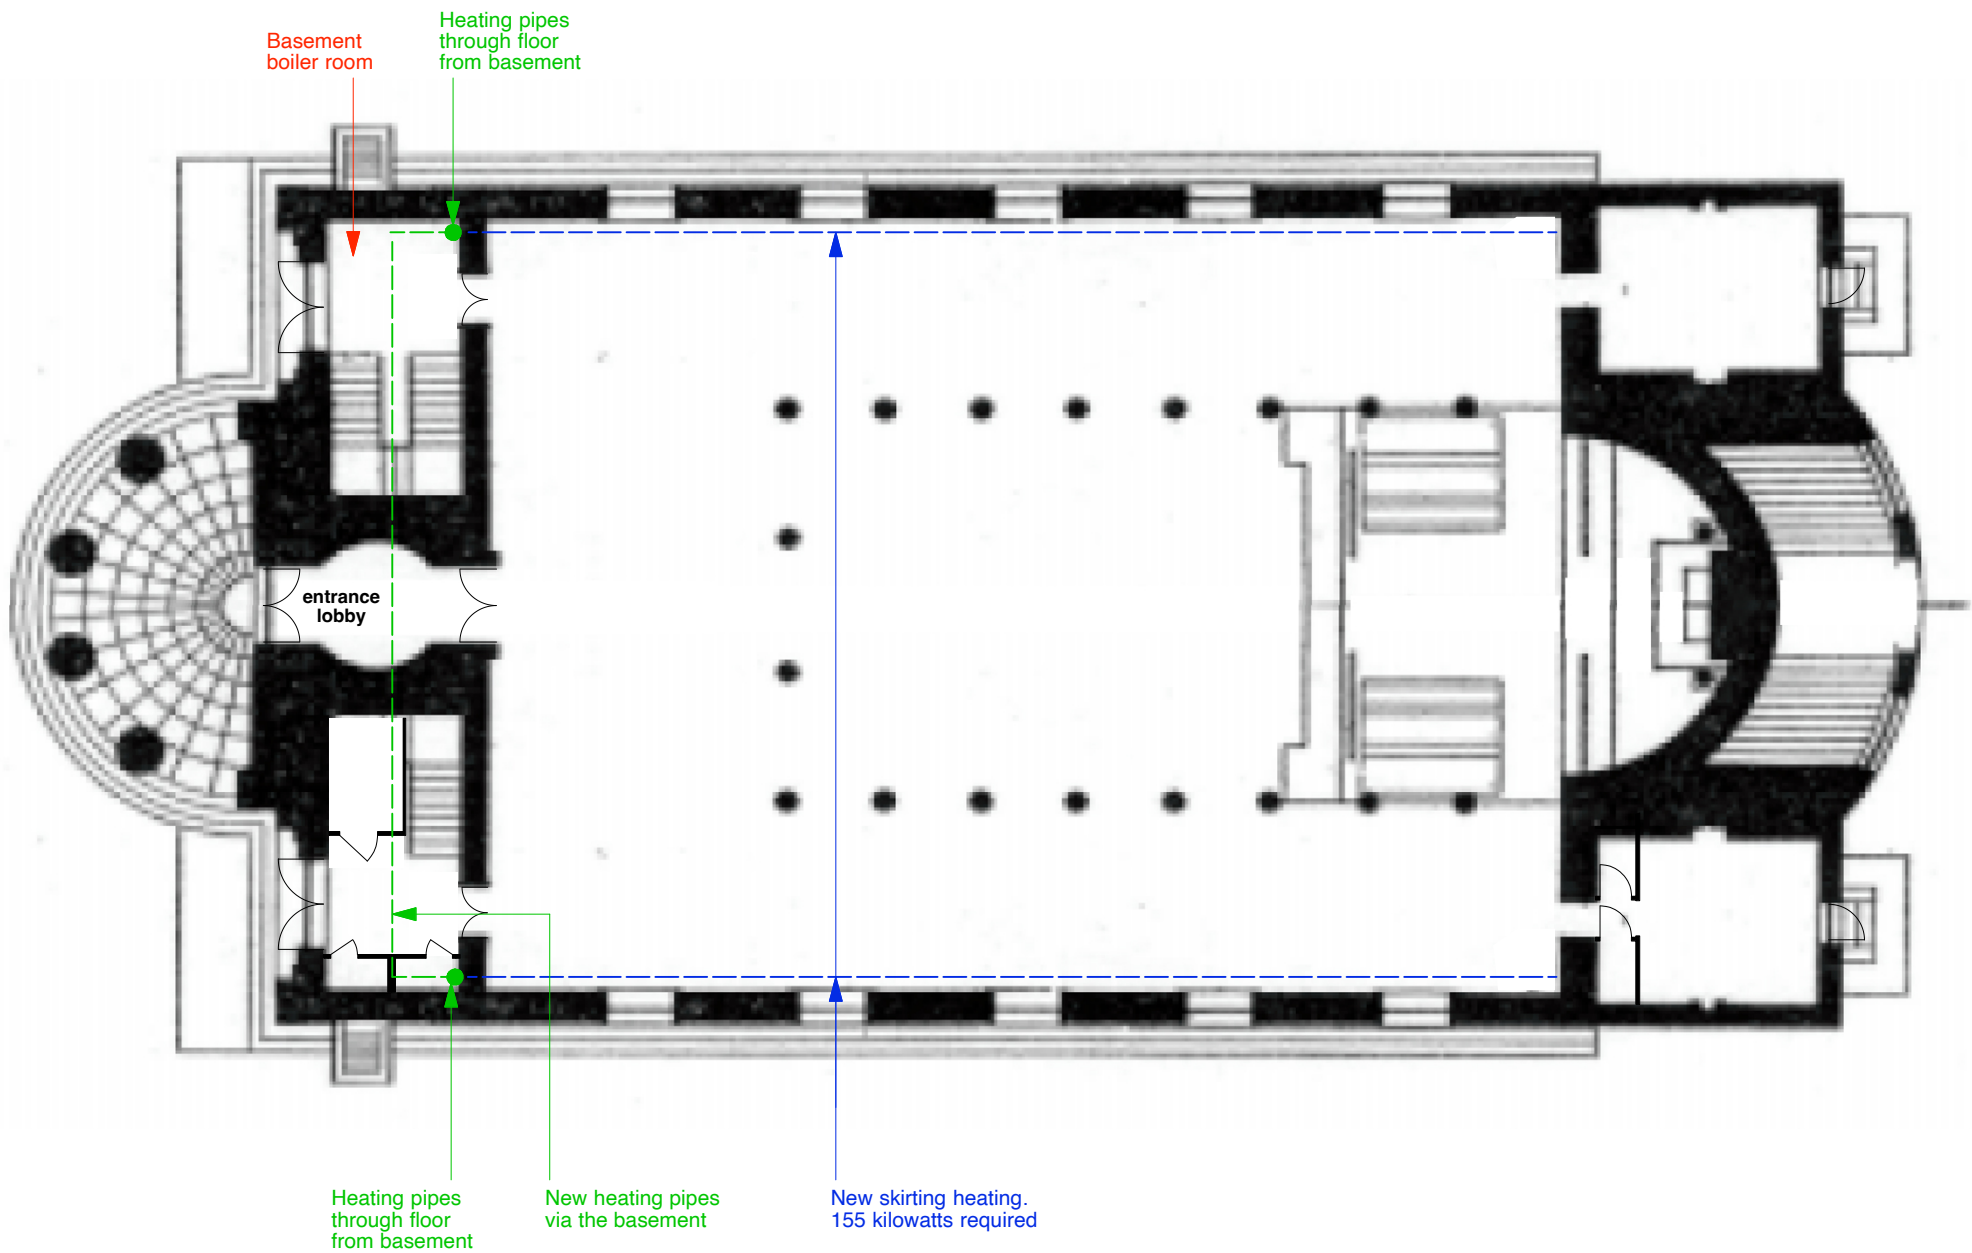

PROPOSED GROUND FLOOR PLAN
scale: 1:200
0 4 6 8 10 M