


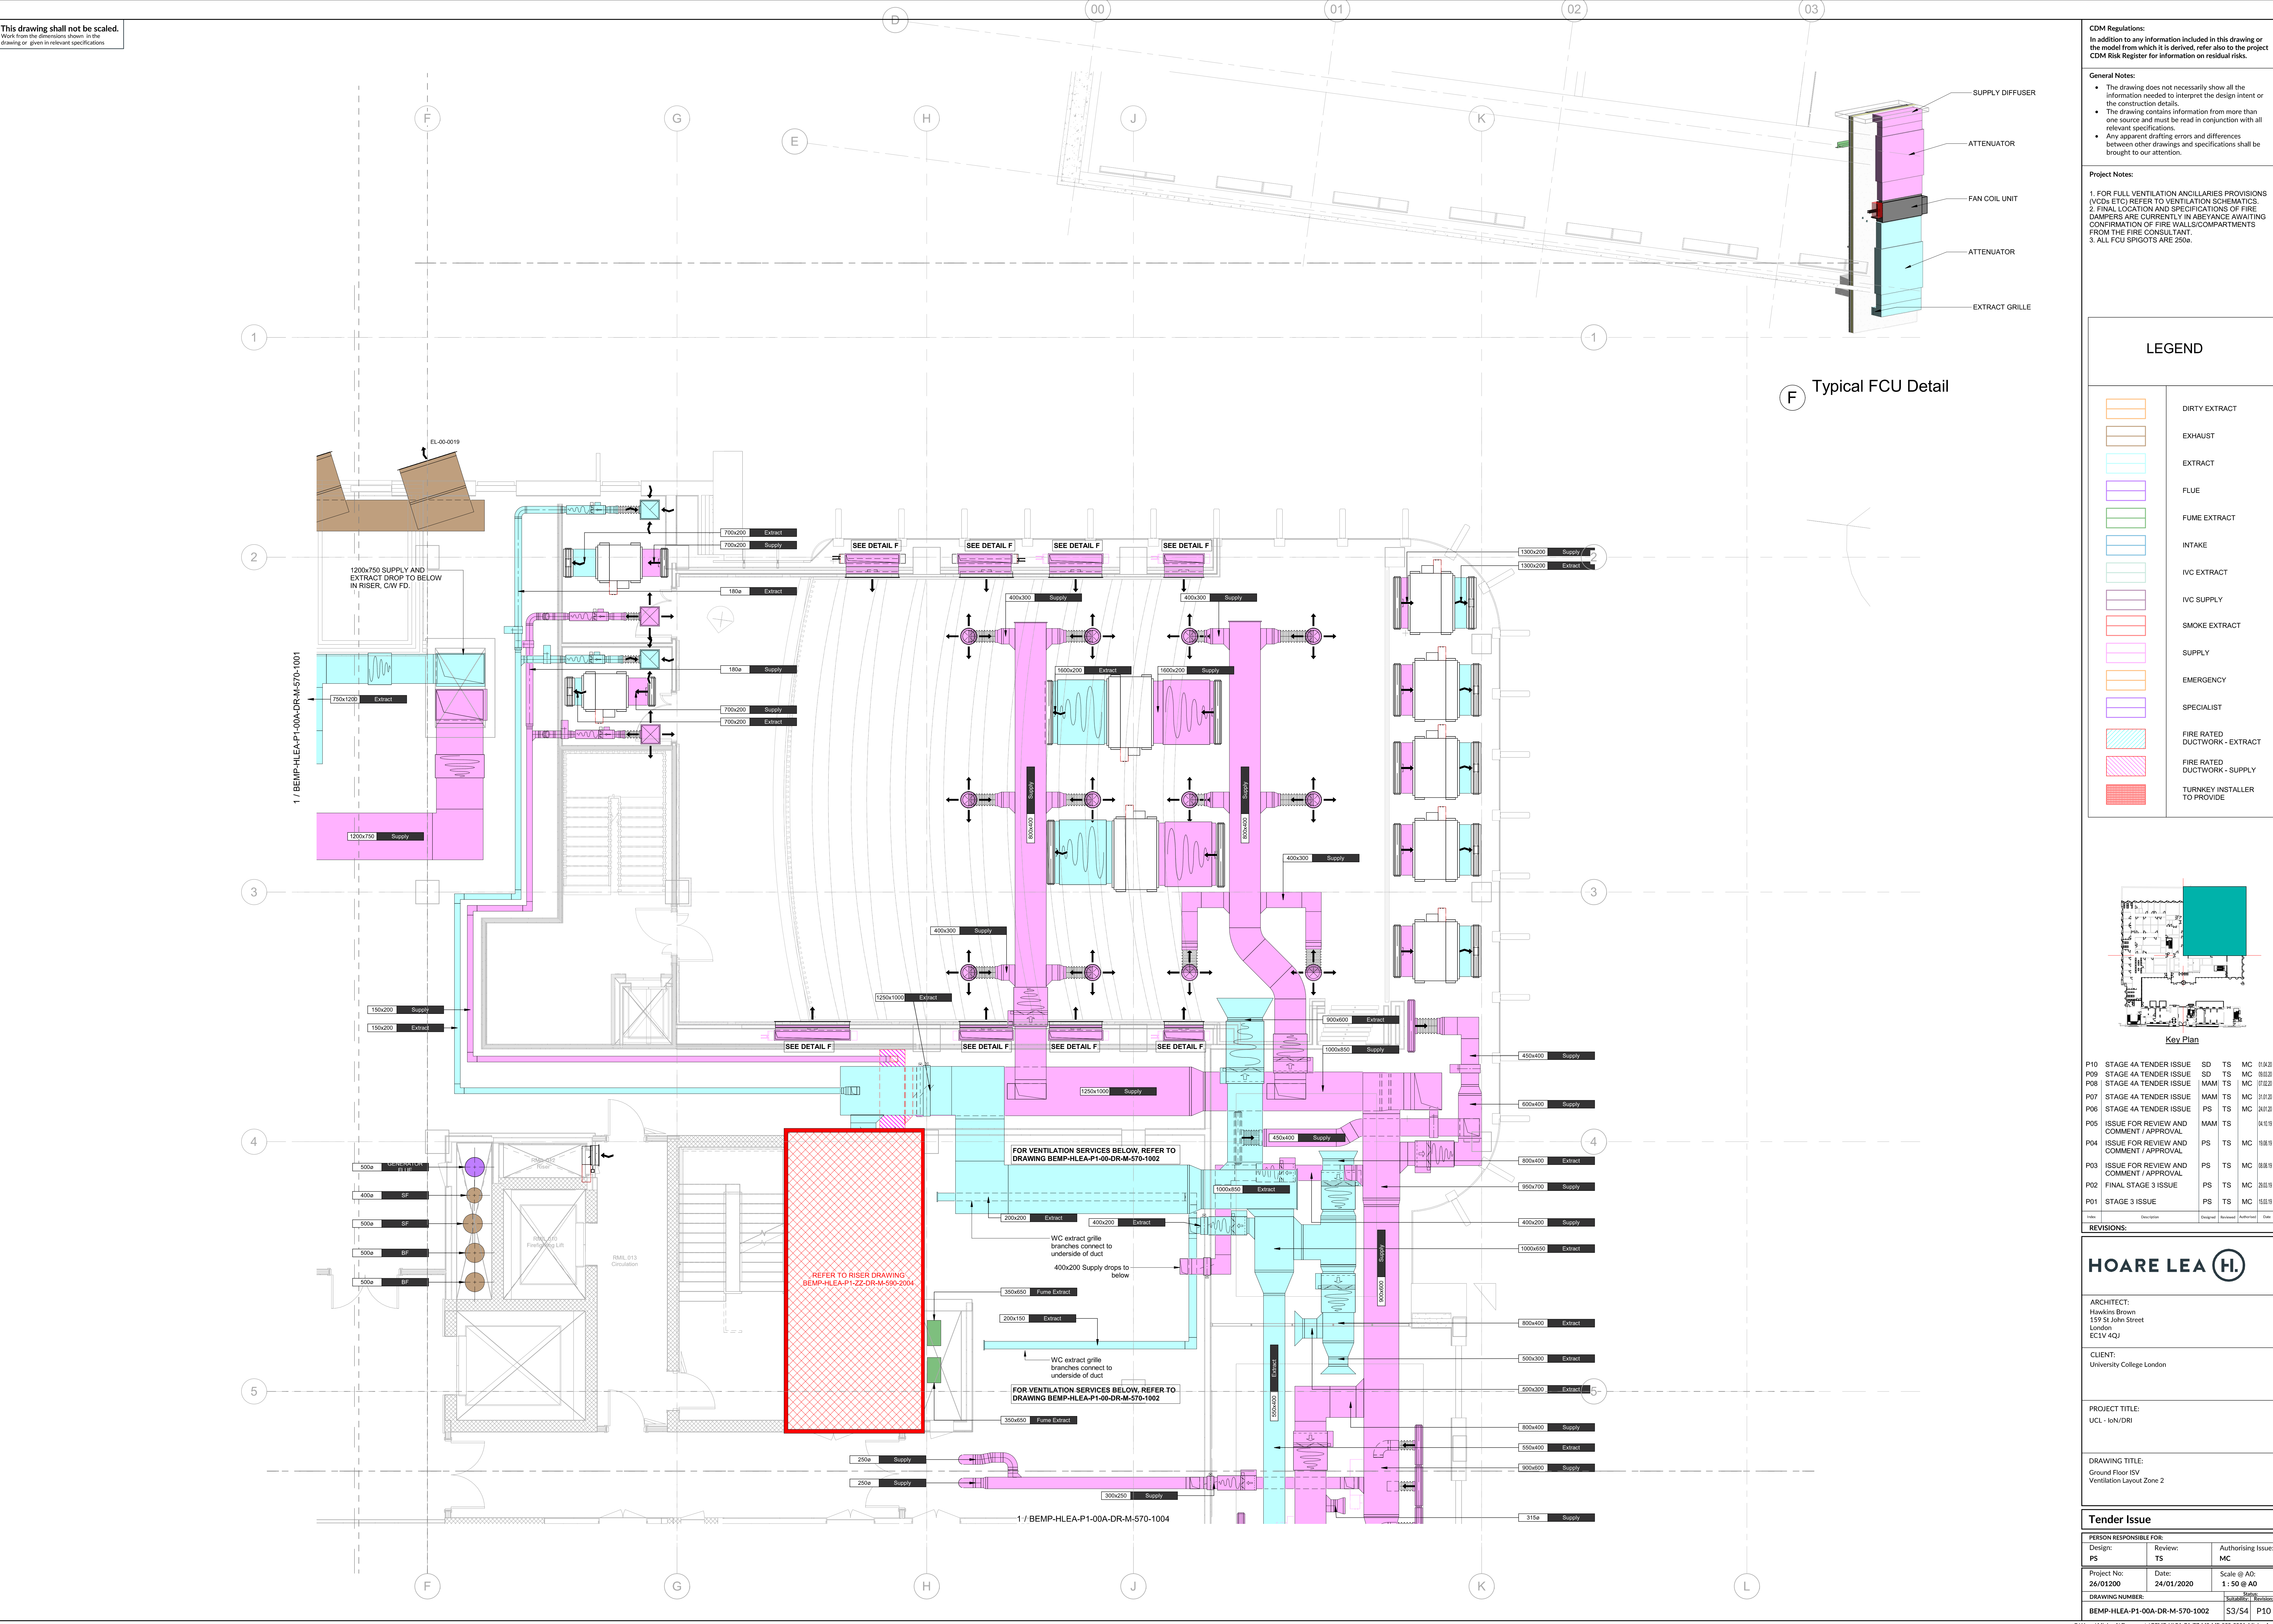

CDM Regulations:
In addition to any information included in this drawing or the model from which it is derived, refer also to the project CDM Risk Register for information on residual risks.

General Notes:

- The drawing does not necessarily show all the information needed to interpret the design intent or the construction details.
- The drawing contains information from more than one source and must be read in conjunction with all relevant specifications.
- Any apparent drafting errors and differences between other drawings and specifications shall be brought to our attention.

Project Notes:

- FOR FULL VENTILATION ANCILLARIES PROVISIONS (VCDs ETC) REFER TO VENTILATION SCHEMATICS
- FINAL LOCATION AND SPECIFICATIONS OF FIRE DAMPERS ARE CURRENTLY IN ABEYANCE AWAITING CONFIRMATION OF FIRE WALLS/COMPARTMENTS FROM THE FIRE CONSULTANT.
- ALL FCU SPIGOTS ARE 250ø.

LEGEND

	DIRTY EXTRACT
	EXHAUST
	EXTRACT
	FLUE
	FUME EXTRACT
	INTAKE
	IVC EXTRACT
	IVC SUPPLY
	SMOKE EXTRACT
	SUPPLY
	EMERGENCY
	SPECIALIST
	FIRE RATED DUCTWORK - EXTRACT
	FIRE RATED DUCTWORK - SUPPLY
	TURNKEY INSTALLER TO PROVIDE

Key Plan

P10	STAGE 4A TENDER ISSUE	SD	TS	MC	11/12/20
P09	STAGE 4A TENDER ISSUE	SD	TS	MC	03/02/20
P08	STAGE 4A TENDER ISSUE	MAM	TS	MC	17/02/20
P07	STAGE 4A TENDER ISSUE	MAM	TS	MC	11/12/20
P06	STAGE 4A TENDER ISSUE	PS	TS	MC	11/12/20
P05	ISSUE FOR REVIEW AND COMMENT / APPROVAL	MAM	TS	MC	04/11/19
P04	ISSUE FOR REVIEW AND COMMENT / APPROVAL	PS	TS	MC	03/08/19
P03	ISSUE FOR REVIEW AND COMMENT / APPROVAL	PS	TS	MC	03/08/19
P02	FINAL STAGE 3 ISSUE	PS	TS	MC	20/03/19
P01	STAGE 3 ISSUE	PS	TS	MC	15/03/19

REVISIONS:

Issue	Description	Designed	Reviewed	Authorised	Date

HOARE LEA

ARCHITECT:
Hawkins Brown
159 St John Street
London
EC1V 4QJ

CLIENT:
University College London

PROJECT TITLE:
UCL - IoN/DRI

DRAWING TITLE:
Ground Floor ISV
Ventilation Layout Zone 2

Tender Issue

PERSON RESPONSIBLE FOR:		
Design: PS	Review: TS	Authorising Issue: MC
Project No: 26/01200	Date: 24/01/2020	Scale @ A0: 1: 50 @ A0
DRAWING NUMBER: BEMP-HLEA-P1-00A-DR-M-570-1002		Sheet: S3/S4 P10