



LEGEND

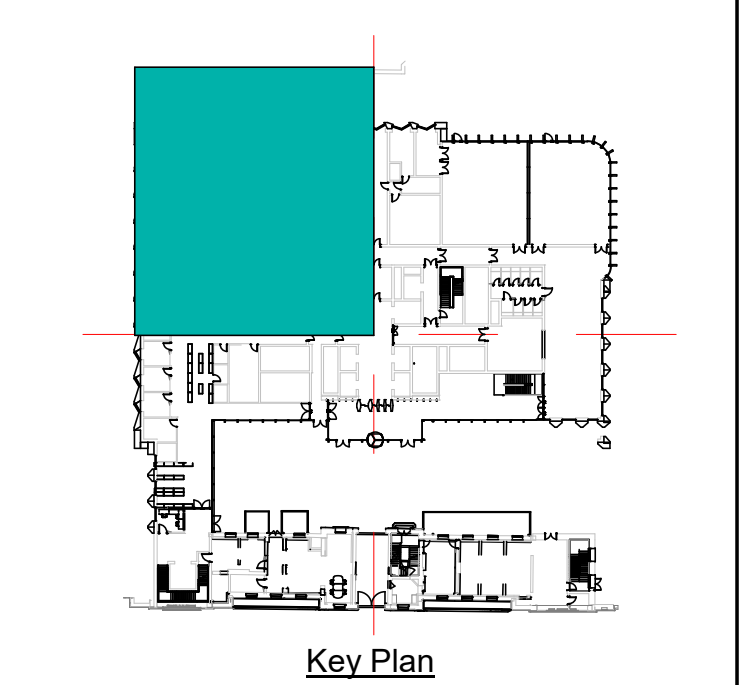

P06	STAGE 4A TENDER ISSUE	MAM	TS	MC	17/02/20
P07	STAGE 4A TENDER ISSUE	MAM	TS	MC	31/01/20
P06	STAGE 4A TENDER ISSUE	PS	TS	MC	04/01/20
P05	ISSUE FOR REVIEW AND COMMENT / APPROVAL	MAM	TS		04/01/20
P04	ISSUE FOR REVIEW AND COMMENT / APPROVAL	PS	TS	MC	03/01/20
P03	ISSUE FOR REVIEW AND COMMENT / APPROVAL	PS	TS	MC	02/01/20
P02	FINAL STAGE 3 ISSUE	PS	TS	MC	02/01/20
P01	STAGE 3 ISSUE	PS	TS	MC	02/01/20
Index	Description	Designed	Reviewed	Authorised	Date

REVISIONS:

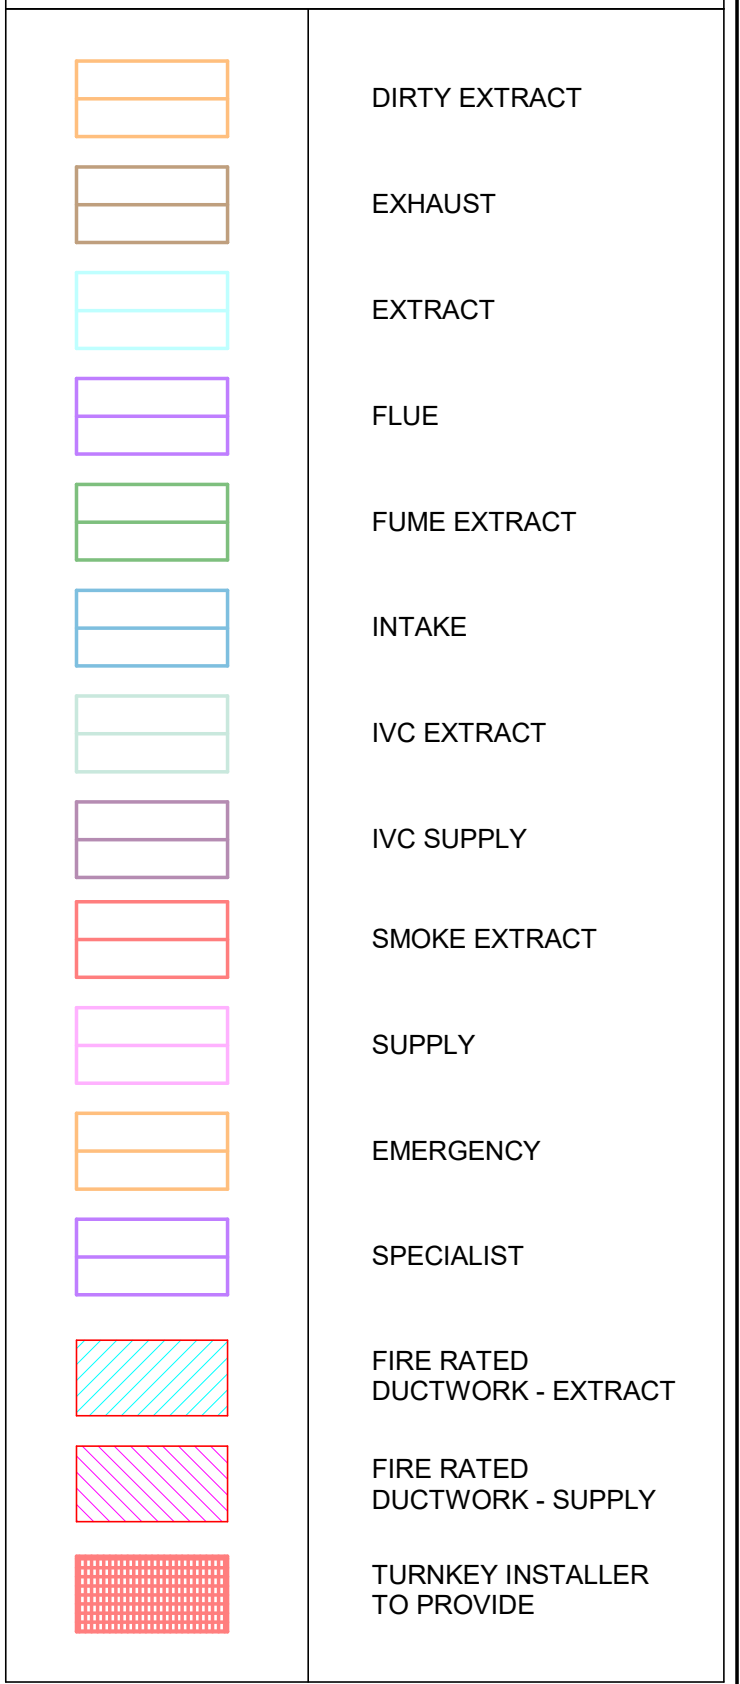

ARCHITECT:
Hawkins Brown
159 St John Street
London
EC1V 4QJ

CLIENT:
University College London

PROJECT TITLE:
UCL - IoN/DRI

DRAWING TITLE:
Ground Floor
Ventilation Layout Zone 1

Tender Issue

PERSON RESPONSIBLE FOR:		
Design: PS	Review: TS	Authorising Issue: MC
Project No: 26/01200	Date: 24/01/2020	Scale @ AD: 1 : 50 @ A0
DRAWING NUMBER:	Submittal: Status: ☐ Revisions: ☐	
BEMP-HLEA-P1-00-DR-M-570-1001	S3/S4	P08

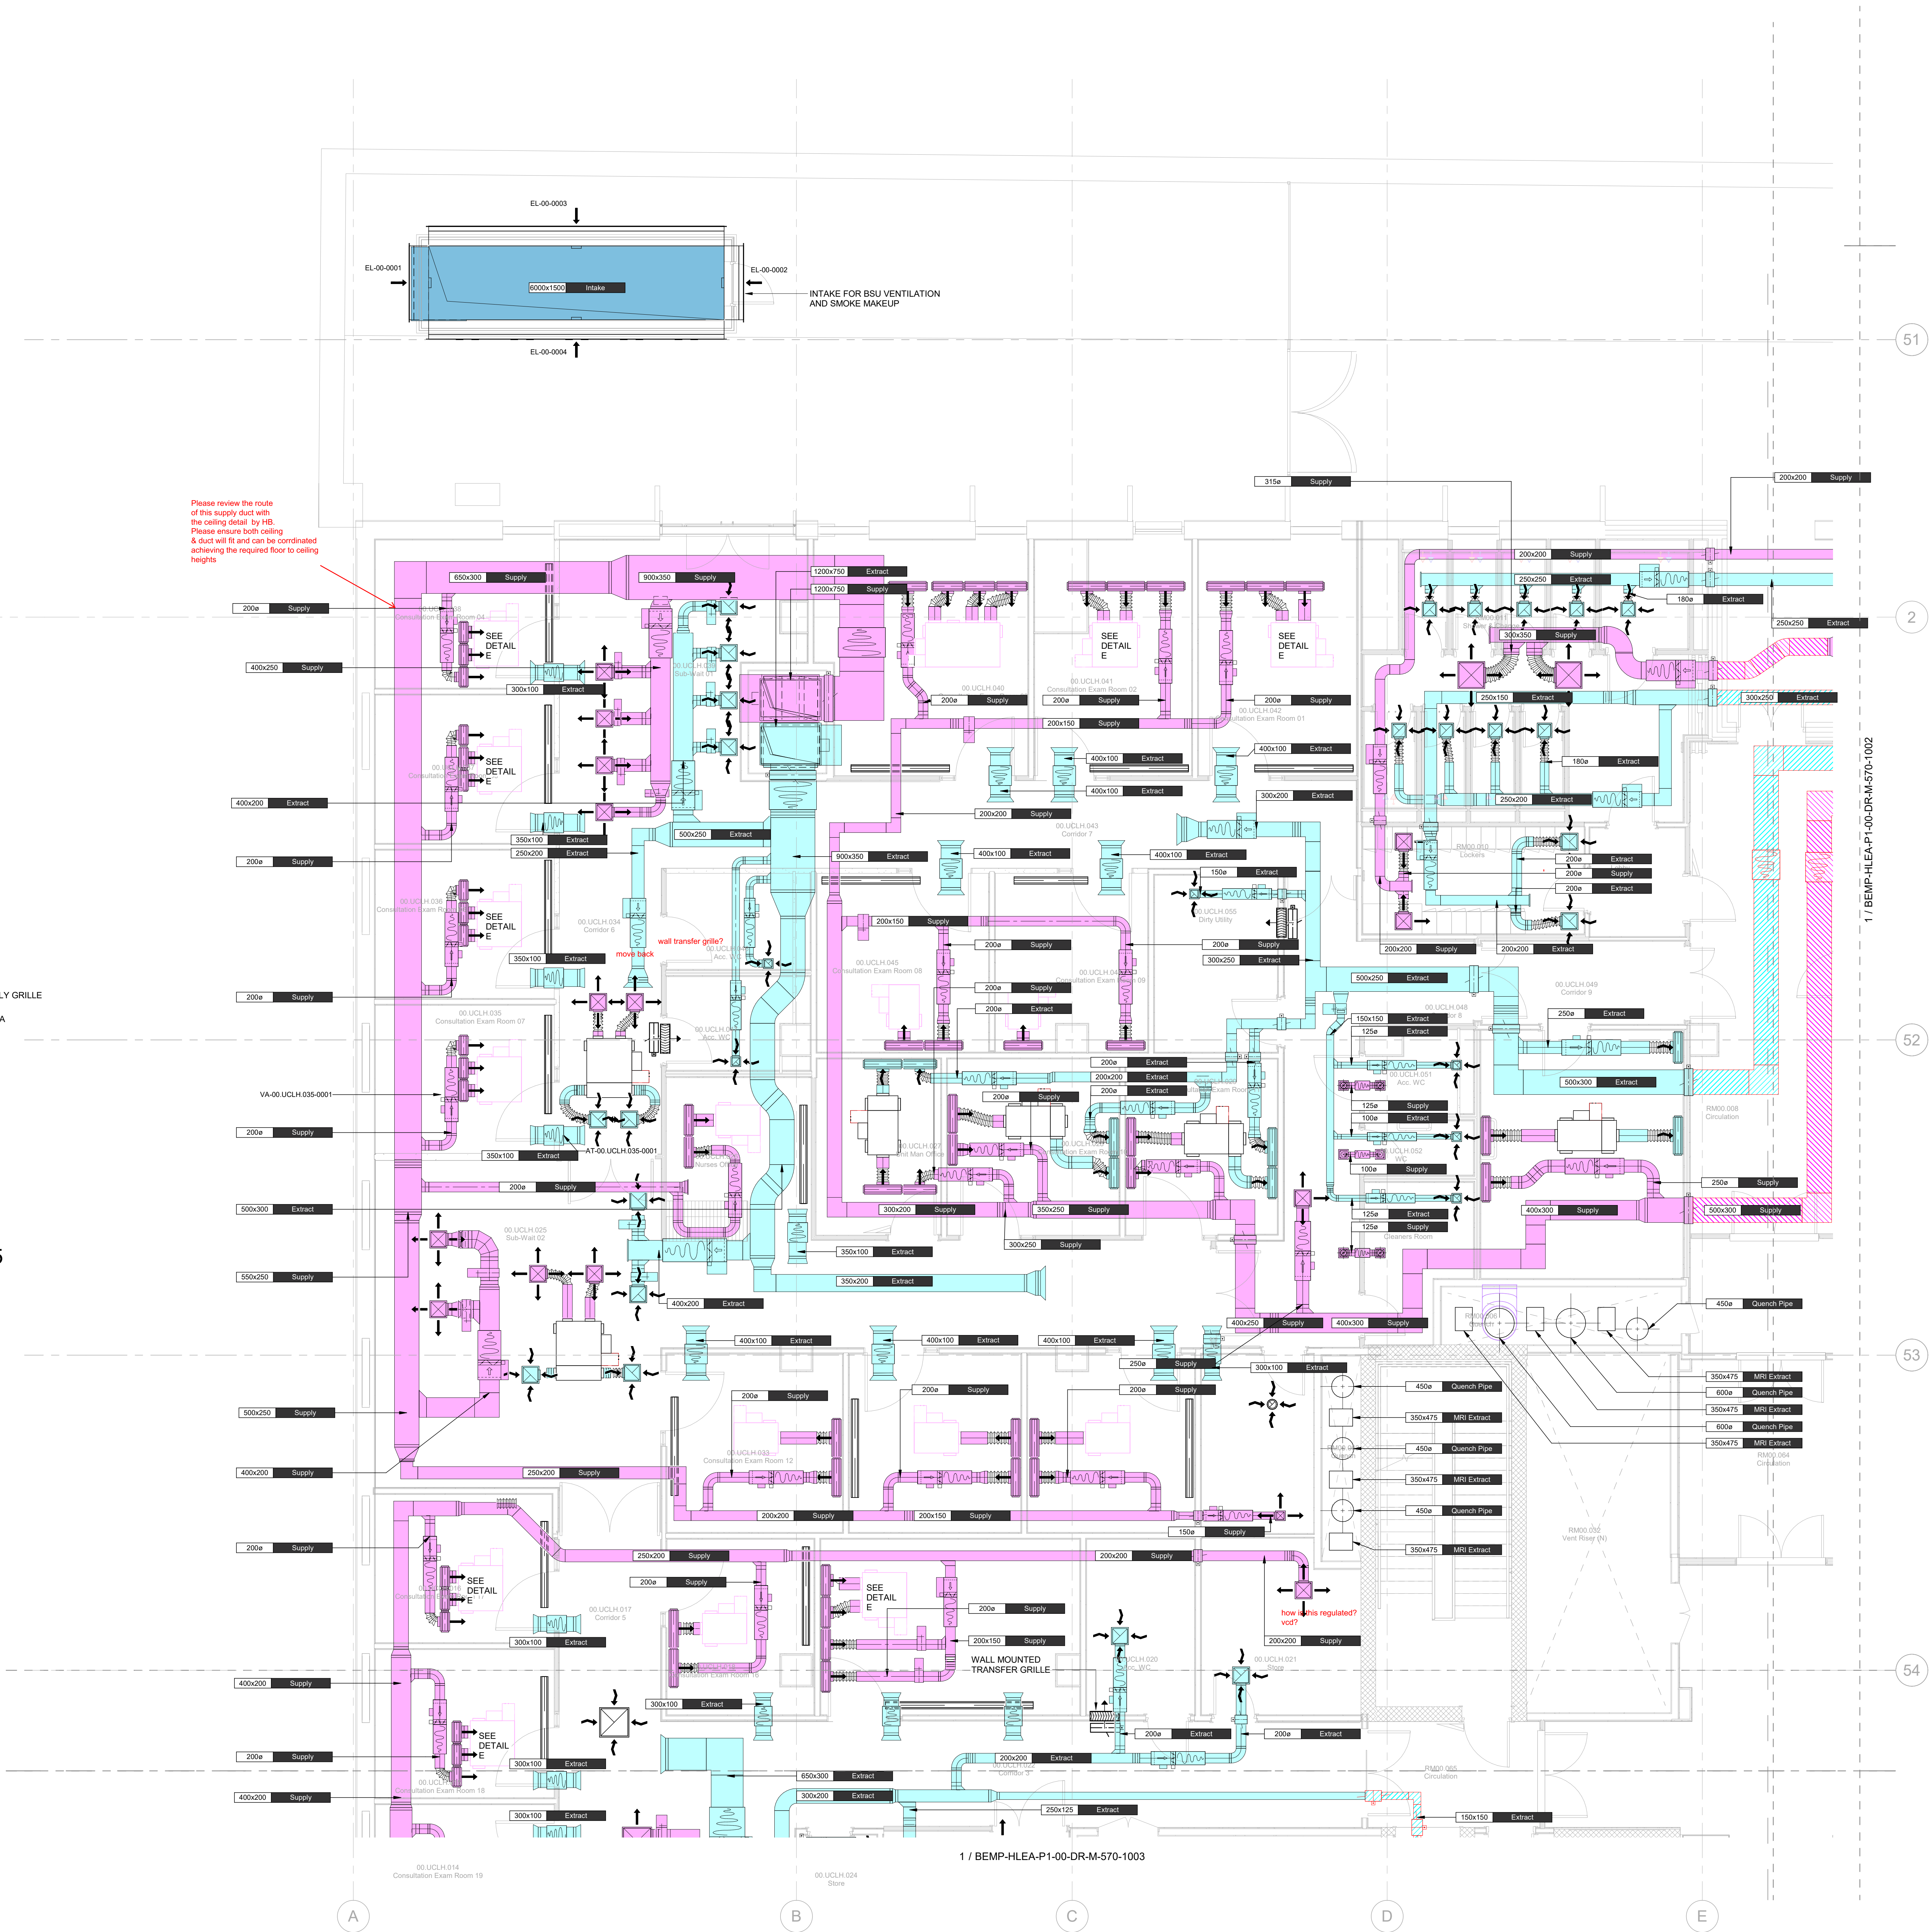


Diagram illustrating the components and airflow paths of a linear slot supply grille assembly:

- FRESH AIR LINEAR SLOT SUPPLY GRILLE
- FCU RETURN AIR PROVIDED VIA LINEAR SLOT RETURN GRILLE
- EXTRACT AIR ATTENUATED TRANSFER PATH
- 2 No FCU SUPPLY AIR LINEAR SLOT DIFFUSERS, WITH 250mm DUCTED CONNECTIONS FROM SPIGOTS
- SUPPLY AIR VAV
- SUPPLY AIR DUCTWORK

FCU Detail Consultation Suite 00.UCLH.035