

SCALE	2007/2022	BLACKBURN UNIVERSITY	T.S	M.T
DATE	12/06/22	INFORMATION	AS	L.T
SCALE	1:100	INFORMATION	AS	L.T
SCALE	1:100	INFORMATION	AS	L.T

PROJECT INFORMATION

OXFORD VICTORIA HOUSE
 VICTORIA HOUSE
 VICTORIA HOUSE

OXFORD VICTORIA HOUSE
 VICTORIA HOUSE
 VICTORIA HOUSE


OXFORD VICTORIA HOUSE
 VICTORIA HOUSE
 VICTORIA HOUSE

OXFORD VICTORIA HOUSE
 VICTORIA HOUSE
 VICTORIA HOUSE

OXFORD VICTORIA HOUSE
 VICTORIA HOUSE
 VICTORIA HOUSE

OXFORD VICTORIA HOUSE
 VICTORIA HOUSE
 VICTORIA HOUSE

OXFORD VICTORIA HOUSE
 VICTORIA HOUSE
 VICTORIA HOUSE

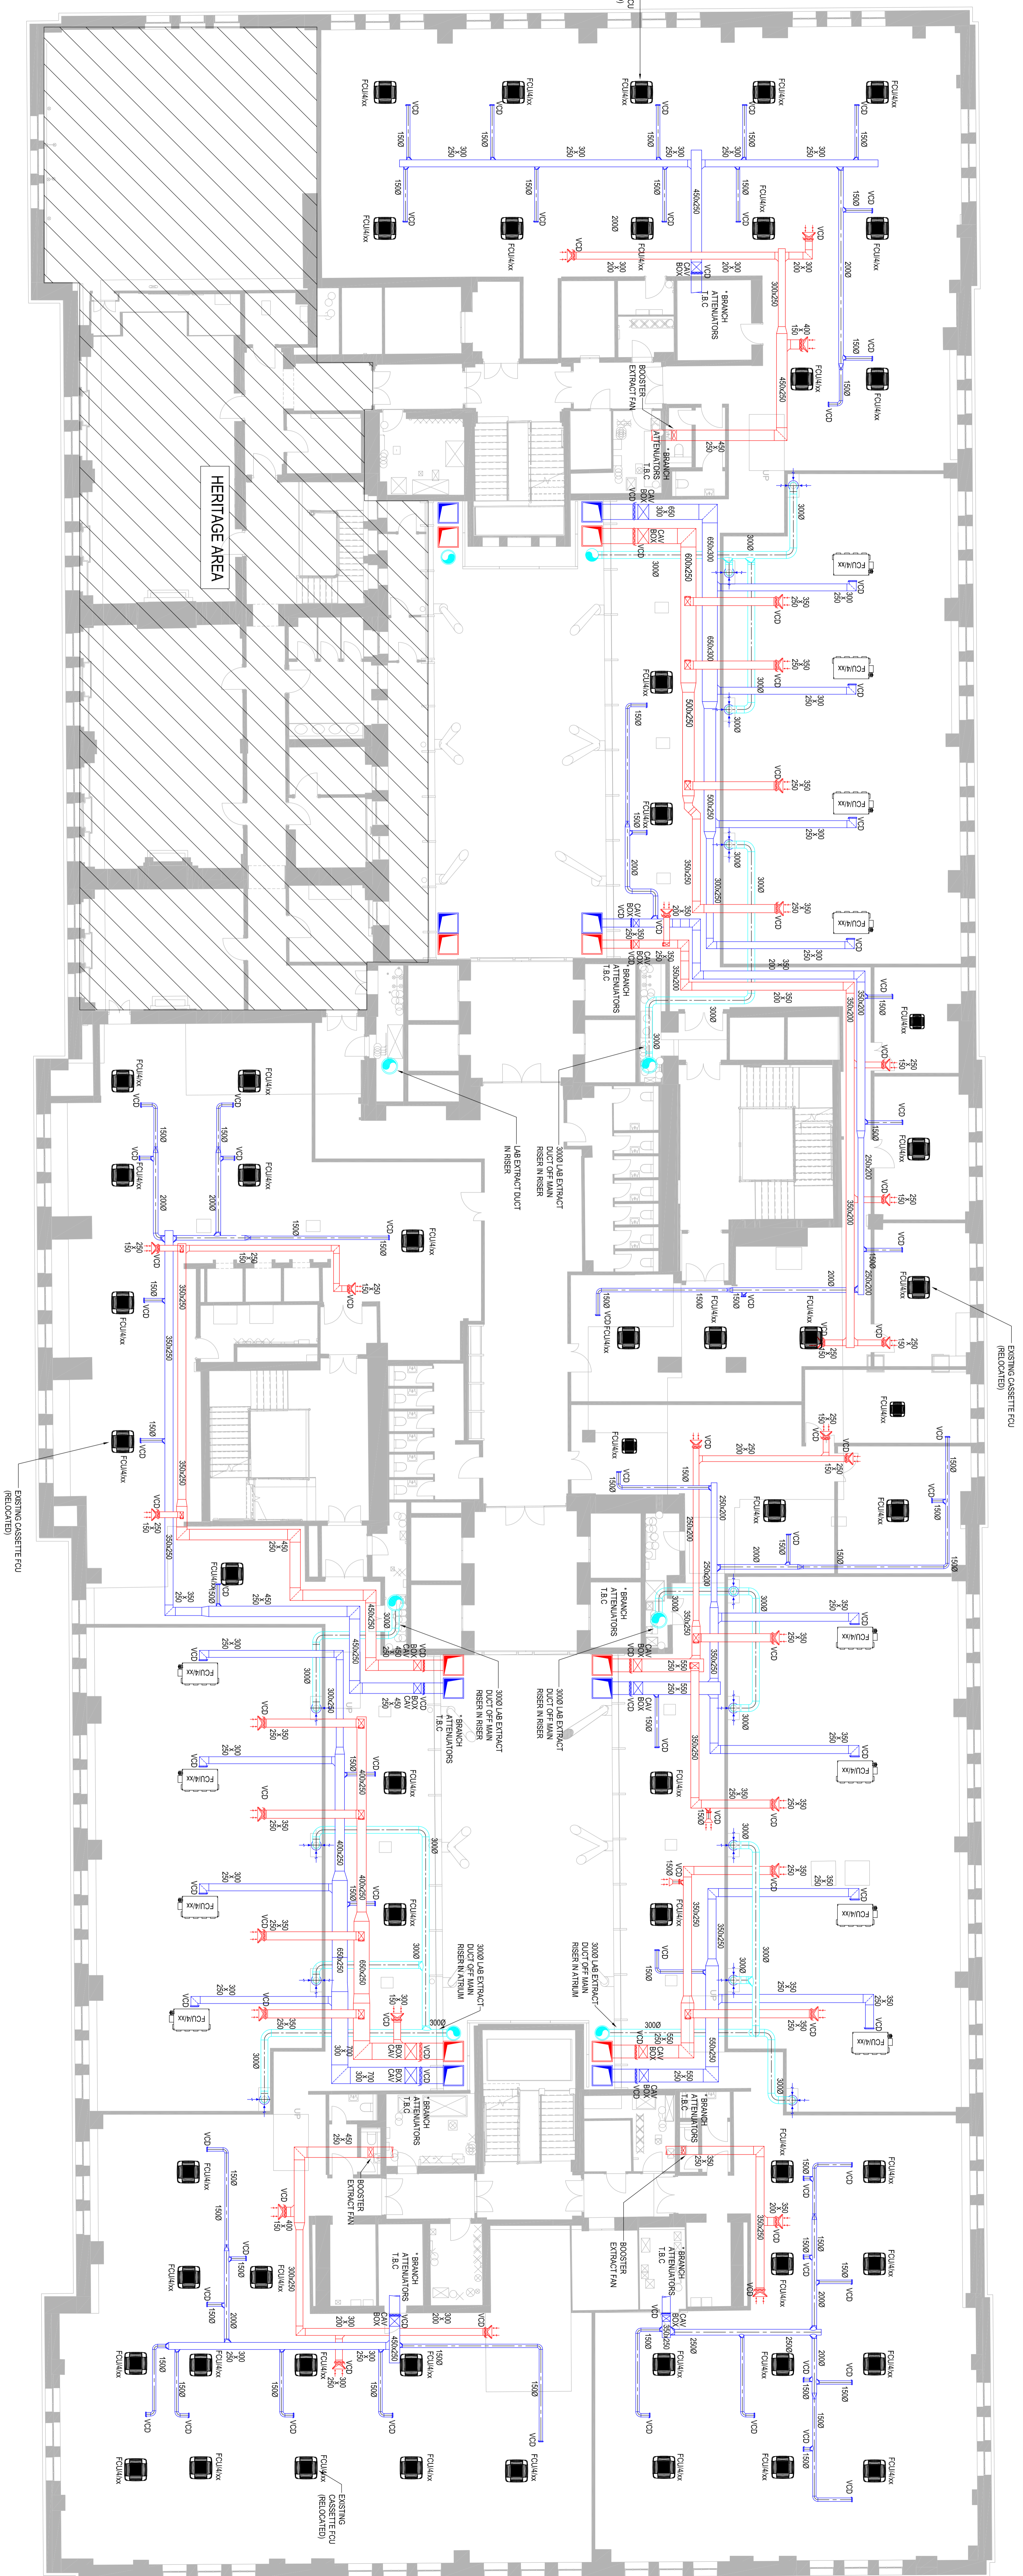

SCALE	200/7000	DATE	13 JUN 21
STATUS	ISSUED FOR CONSTRUCTION	PROJECT	OXFORD VICTORIA HOUSE
DATE	13 JUN 21	CLIENT	OXFORD VICTORIA HOUSE
ISSUED FOR CONSTRUCTION		PROJECT	VICTORIA HOUSE, OXFORD, MK3B 4DA

INFORMATION

THIS DRAWING IS COPYRIGHT © OF KJ TAIT AND SHOULD NOT BE REPRODUCED OR TRANSMITTED IN ANY FORM OR BY ANY MEANS, ELECTRONIC OR MECHANICAL, INCLUDING PHOTOCOPYING, RECORDING, OR BY ANY INFORMATION STORAGE AND RETRIEVAL SYSTEM, WITHOUT THE WRITTEN PERMISSION OF KJ TAIT.

KJ TAIT
 11 RIVERWAY
 WINDYBUSH, OXFORD, OX2 0EJ
 T: 01865 850000
 E: info@kj-tait.co.uk
 W: www.kj-tait.co.uk

PROJECT INFORMATION
 CLIENT: OXFORD VICTORIA HOUSE
 PROJECT: VICTORIA HOUSE, OXFORD, MK3B 4DA

DRAWING INFORMATION
 DRAWING TITLE: LEVEL 4 VENTILATION LAYOUT
 DRAWING NO: L3221
 DATE: 13 JUN 21
 SCALE: 1:1000

DATE: 13 JUN 21
 SCALE: 1:1000
 DRAWING NO: L3221
 PROJECT: VICTORIA HOUSE, OXFORD, MK3B 4DA
 CLIENT: OXFORD VICTORIA HOUSE
 PROJECT: VICTORIA HOUSE, OXFORD, MK3B 4DA