

Accessible Homes

- M4(2)
- M4(3)(2)(a)
- M4(3)(2)(b)
- Commercial Areas

DRAWING SERIES

Series 00 - Accommodation Schedules
Series 00 - NBS Specification
Series 02 - Conveyance Plans
Series 03 - GA Plans, GA Setting out Plans & Marketing Plans
Series 04 - GA Sections
Series 05 - GA Elevations
Series 07 - Bay Studies
Series 09 - 3D Views
Series 10 - Substructure
Series 20 - Superstructure
Series 21 - External Wall Types & Details
Series 22 - Internal Wall Types & Details
Series 23 - Floor Types & Details
Series 24 - Staircases & Lifts
Series 27 - Roof Types & Details
Series 31 - Window & Doors Types, Details & Schedules
Series 35 - Reflected Ceiling Plans
Series 36 - Balconies & External Metalwork
Series 40 - Internal Finishes
Series 60 - Electrical Plans
Series 67 - Fire Strategy Plans
Series 71 - Signage Plans
Series 73 - Kitchen Layouts & Schedules
Series 74 - Bathroom Layouts & Schedules
Series 82 - Commercial Units
Series 83 - Offices

GENERAL NOTES


SETTING OUT - DO NOT SCALE from this drawing, use figured dimensions ONLY. If in doubt, ASK! Dimensions are shown to structural face generally, or to finished face of ducts and lining. All dimensions are shown in millimeters unless otherwise indicated. Angular dimensions are shown in decimal degrees to the nearest whole degree. Where items are to be fabricated off-site, site dimensions are to be used and confirmed prior to ordering or manufacturing.

STRUCTURAL - For design, detailing and setting out of structural elements refer to Structural Engineers drawings.

SERVICES - For design, detailing & setting out of services, including SVP's, Gas, Water, Electricals & Telecoms etc refer to M&E Engineers and Structural Engineers drawings.

FIRE CONSULTANT - Peter Taylor Associates Ltd (PTAL), through specific endorsement and exclusion to its current Professional Indemnity Insurance (PII) policy, are no longer able to advise on compliance with, or lead the design and specification of, elements, in relation to Approved Document B (Fire Safety) Volumes 1 and 2. Where such elements are indicated in drawings and specifications, the appropriate design information will have been prepared, documented and issued to PTAL by a suitably qualified Specialist Consultant (Fire Consultant).*

All information on this drawing must be read in conjunction with relevant series and specifications.

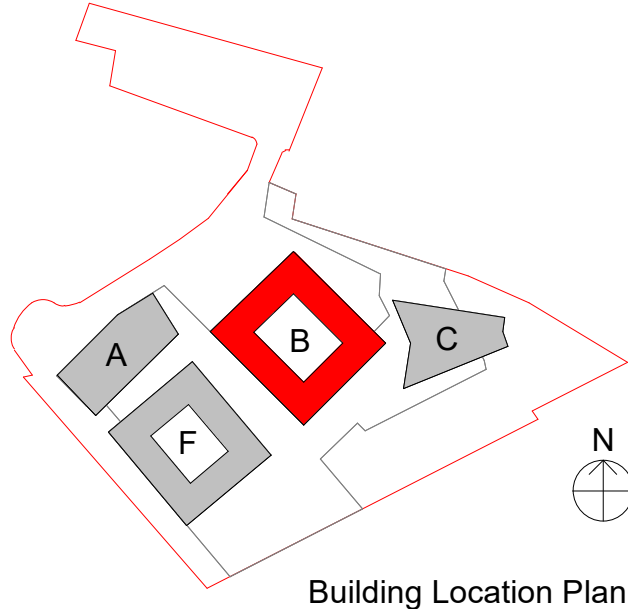

P1	Initial Issue	DBN	CJ	21.01.22
rev	description	drawn	checked	date
revisions				

status: STAGE 4

reason for issue:

ISSUED FOR FINALISING THE PROCUREMENT PROCESS AND NOT FOR CONSTRUCTING THE FRAME

This drawing is protected under The Copyright, Designs and Patents Act 1988. Do not scale. Figured dimensions only are to be taken from this drawing. All dimensions are to be checked on site before any work is put in hand. If in doubt, ASK.

P T A L
| Architects | Masterplanners | Designers |

Peter Taylor Associates Limited
Kilnara House, 25-26 Poland Street
Soho, London W1F 8QN
T: +44 (0)20 7495 3837
W: www.ptal.co.uk



project: Camden Goods Yard
Phase 2A

title: BUILDING B
LEVEL 04
GA COLOURED PLAN

scale: 1 : 100 @ A0

date: 01/13/22

drawn: DBN

checked: CJ

file name: project no: originator: zone: level: type: role: dwg number: revision:
CGYB0 - PTA - ZZZ - 04 - DR - AR - 84035 P1

PTAL Project Number: 200035

