




Internal Room Elevation
Scale: 1:10

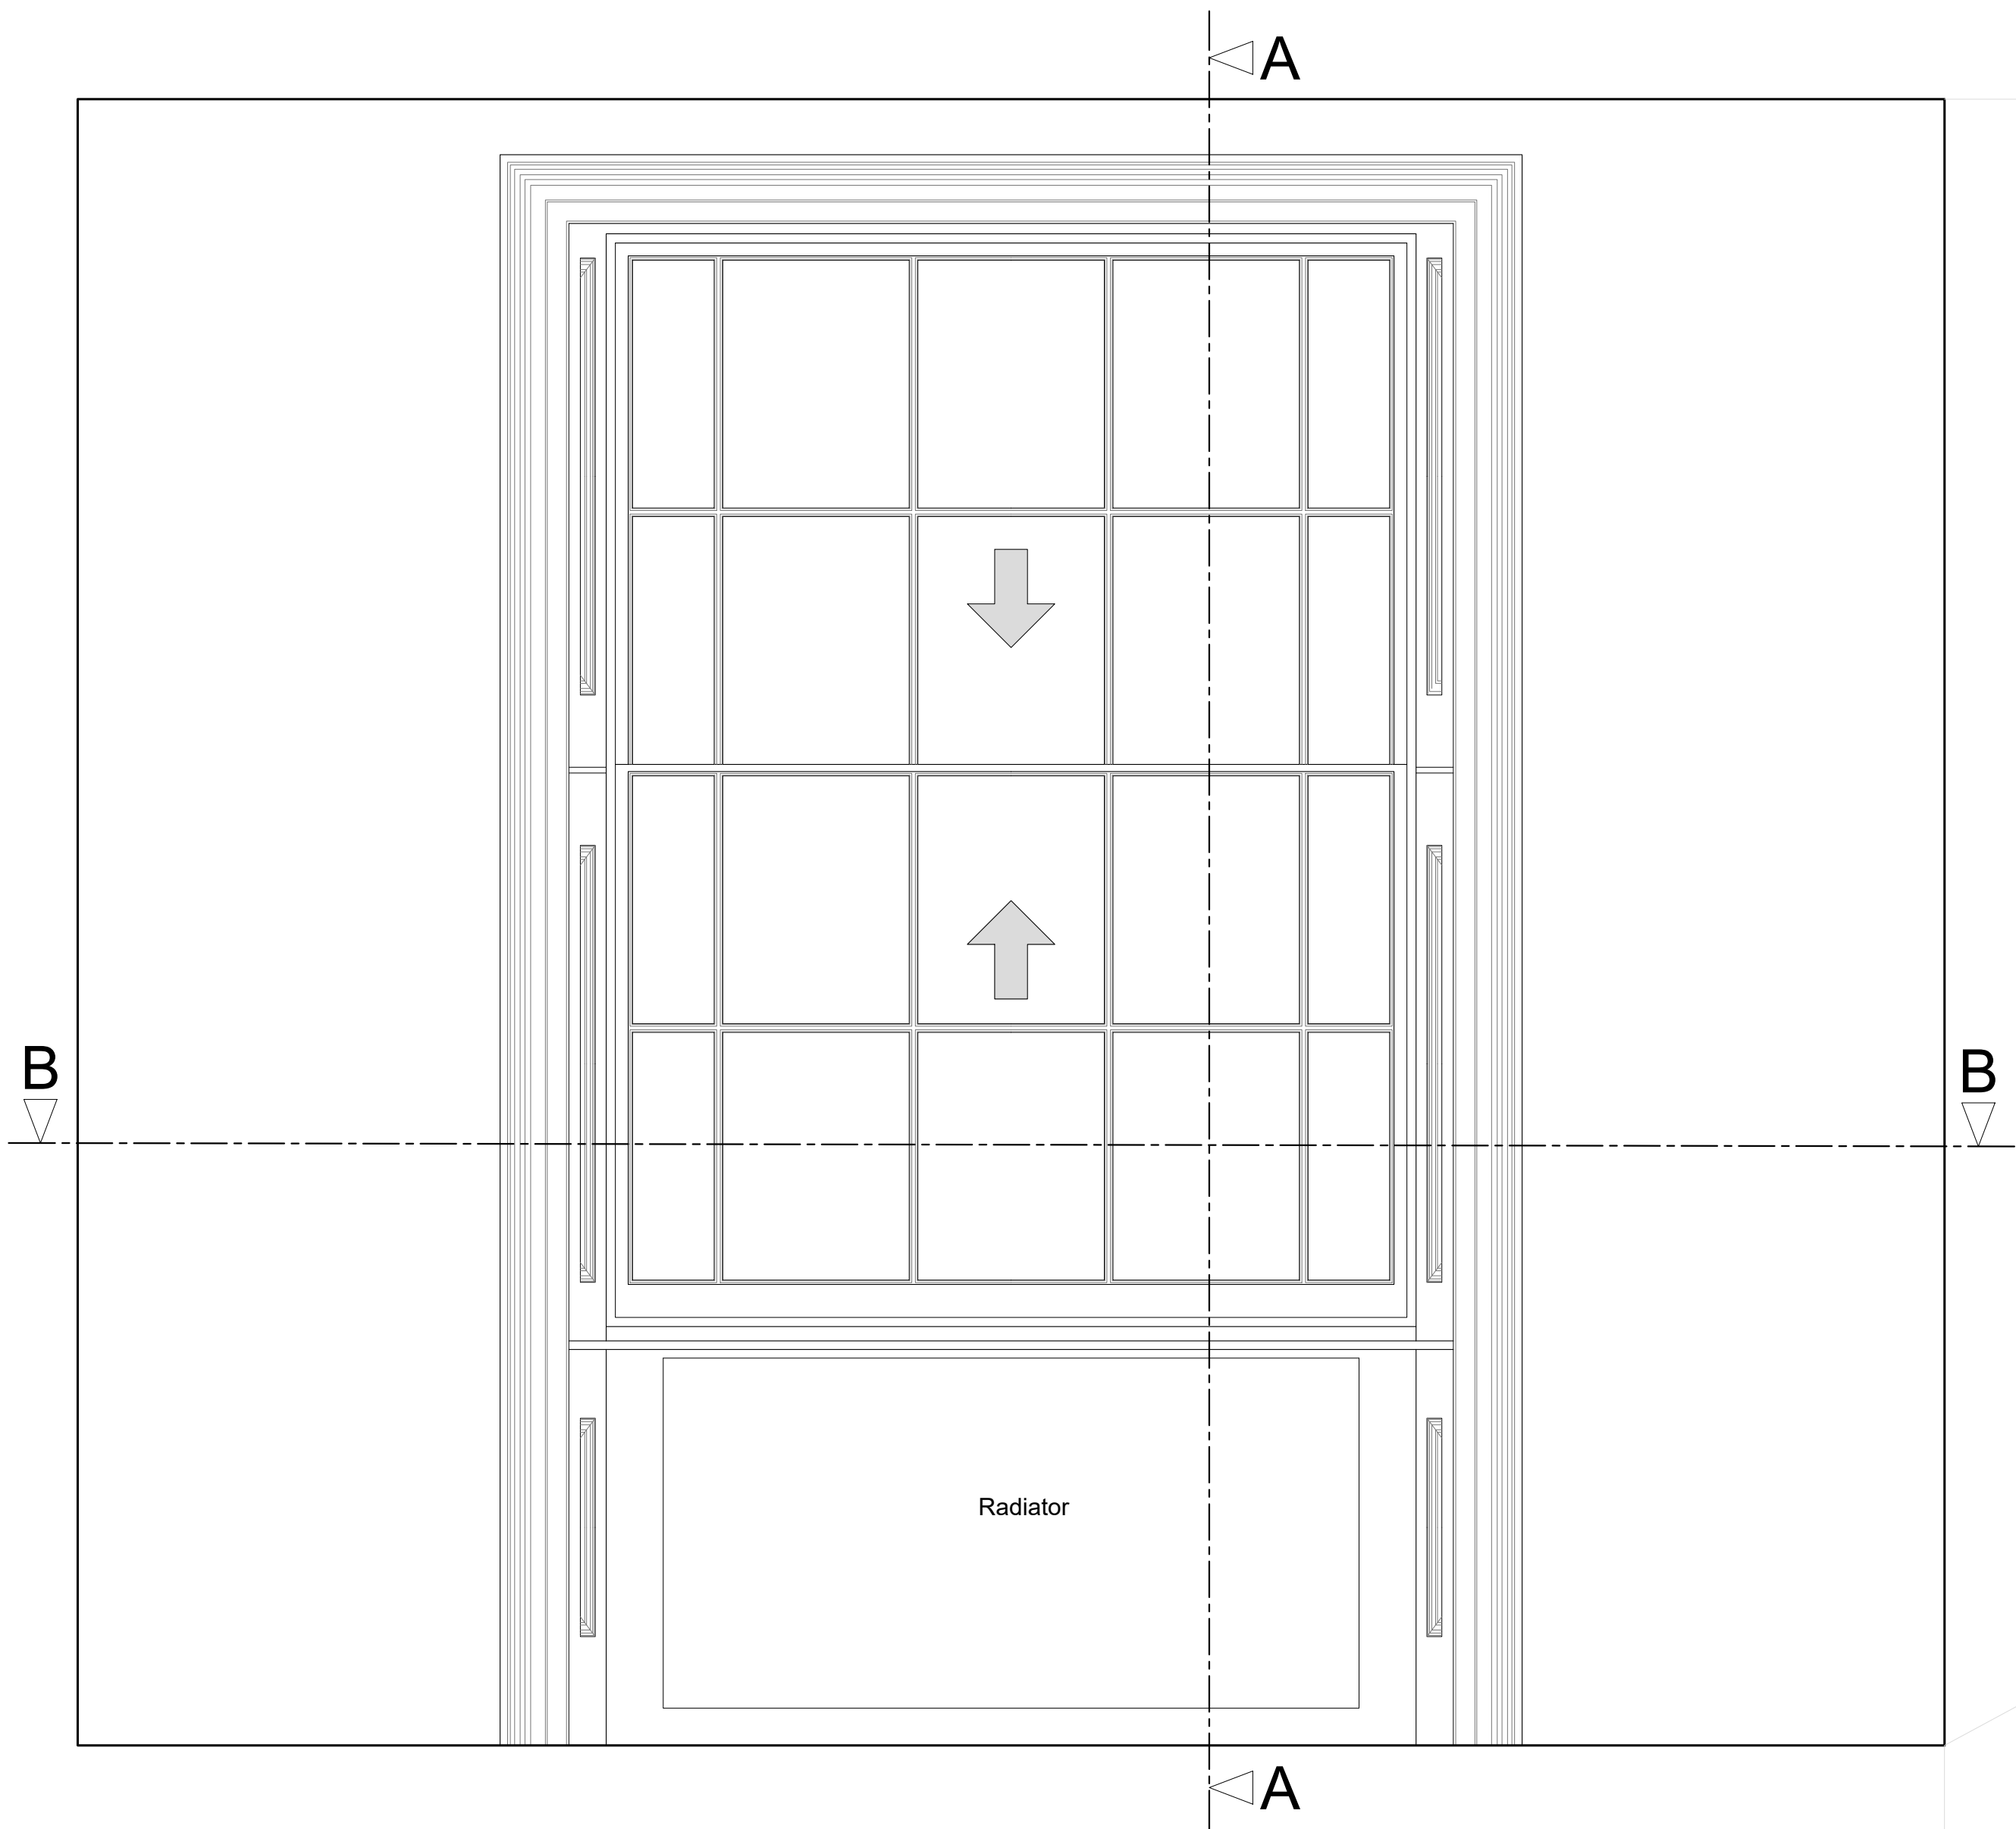

Section A-A through External Wall
Scale: 1:10

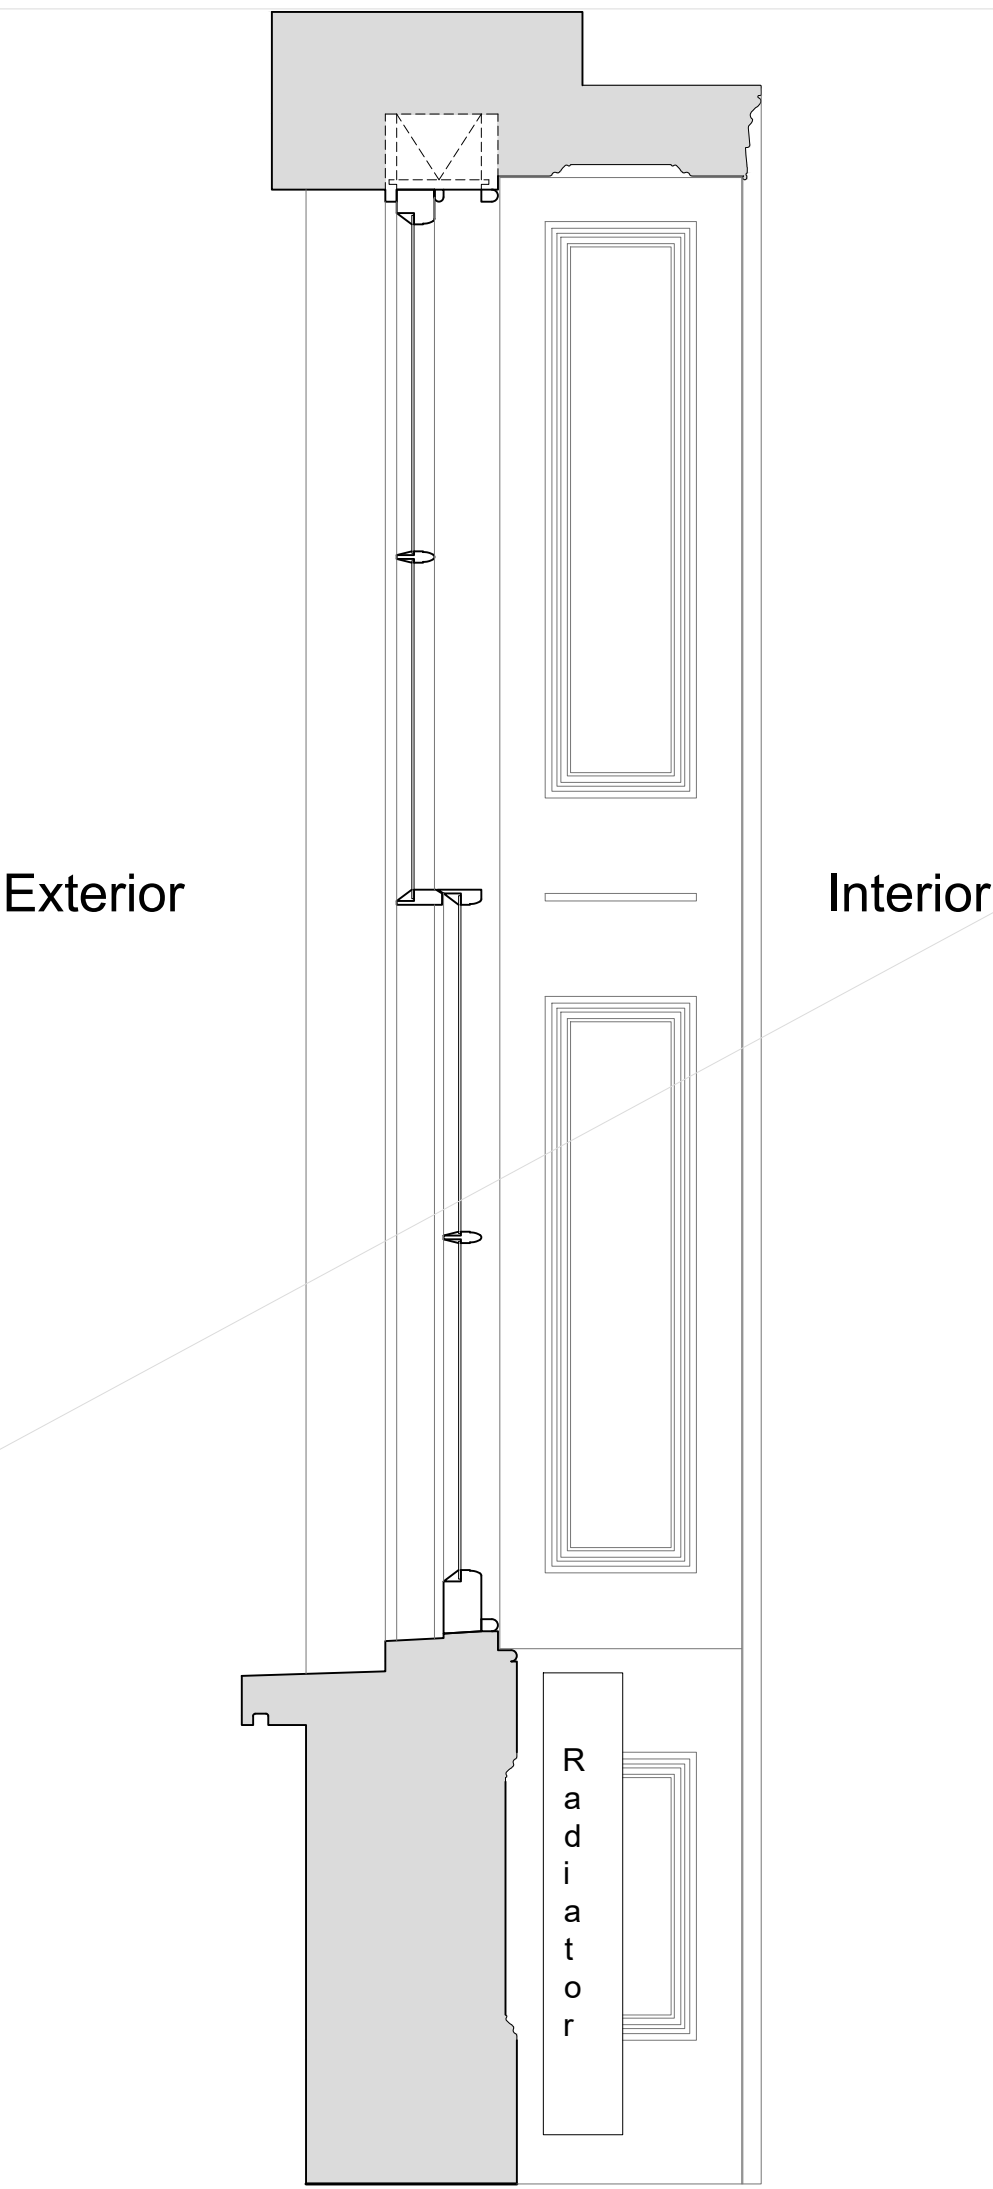

Plan Section B-B
Scale: 1:10

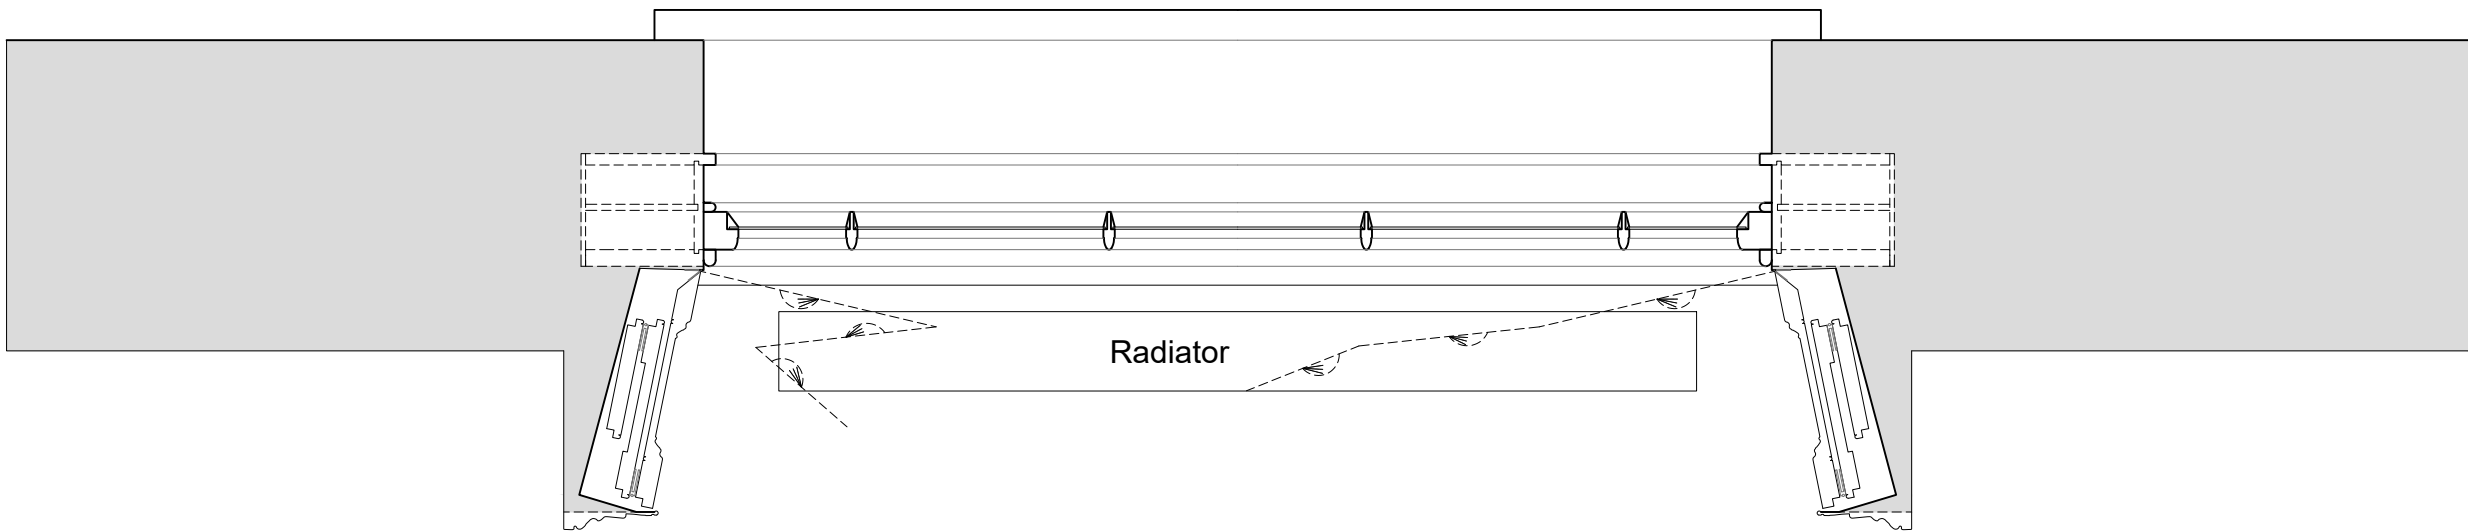

Revision	Date	Amendment
1.0	29-07-2022	Issued for listed building consent Application

Do not reproduce this drawing without written permission
All dimensions are in millimetres unless stated otherwise

Drawing Not For Construction

HS2

High Speed (HS2) Limited
1st/3rd Floor
The Podium
1 Eversholt Street
London NW1 2DN

SKANSKA

STRABAG

Skanska Costain Strabag Joint Venture

5A Granby Terrace
London NW1 3SA

Site Address:
62B Delacey Street, London NW1


Drawing Title:
Ground Floor - Dining Room: EXISTING Window Joinery Details -
Sheet 1 of 3

Submitted by: AP & PB
Primary Drawn by: PB
Secondary Drawn by: AP
Checked by: OB
Presentation Scale: as shown @ A1

Date: 27-09-2021
Drawing No: WPI P066 NI - 62B DeS-EX-GF-J-02
Revision: 1.0


Internal Room Elevation with Secondary Glazing Installed

Scale: 1:10

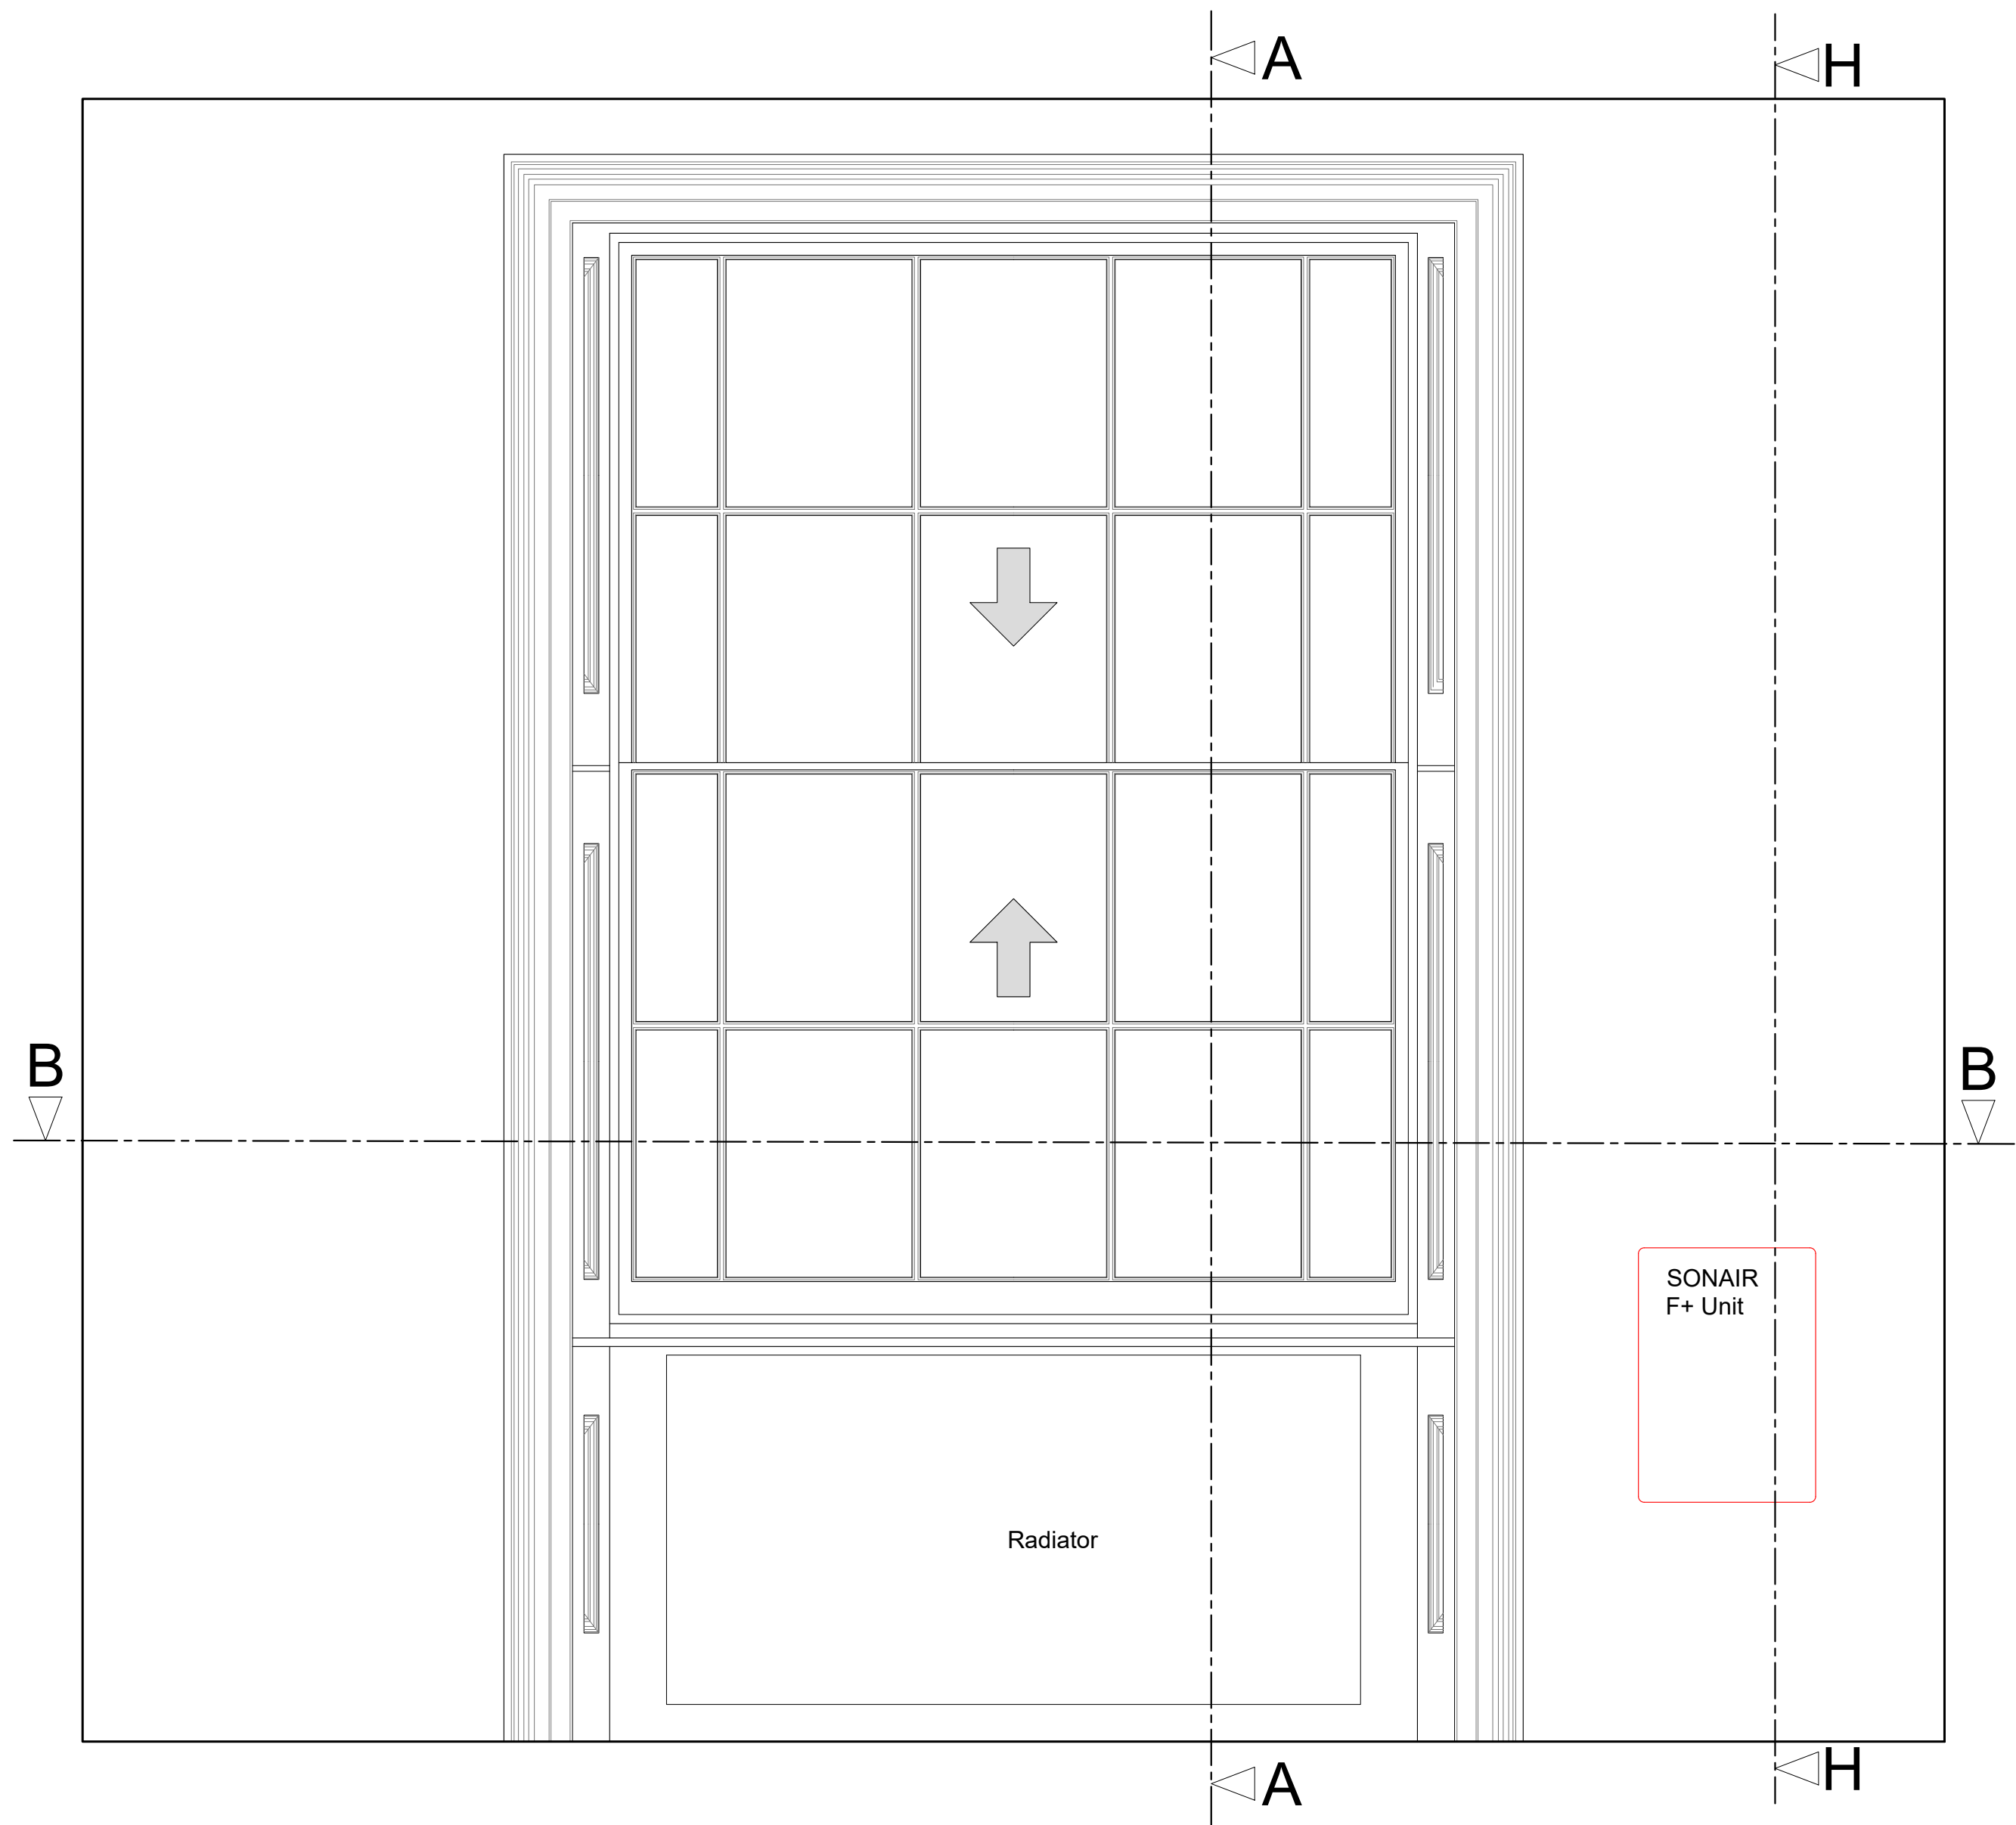


Section H-H through External Wall with Mechanical Ventilation Installed

Scale: 1:10

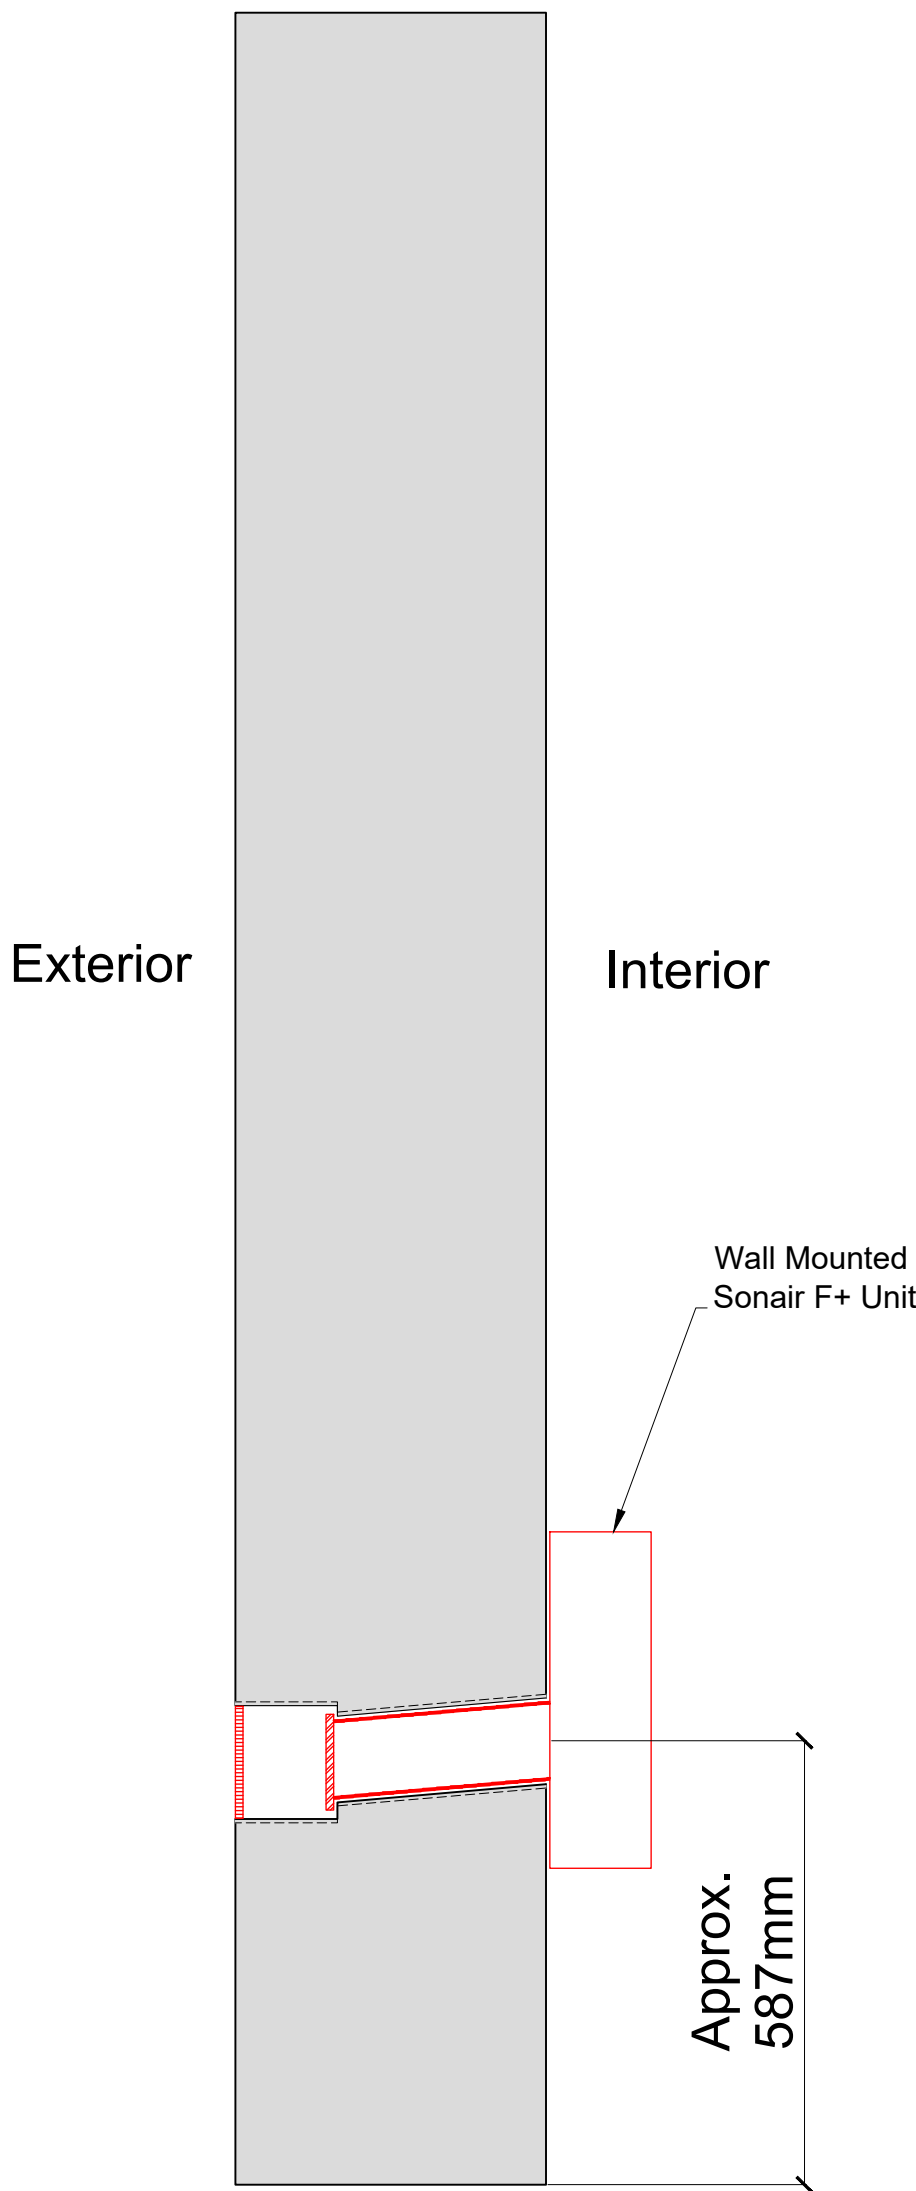


Plan Section B-B with Secondary Glazing Installed

Scale: 1:10

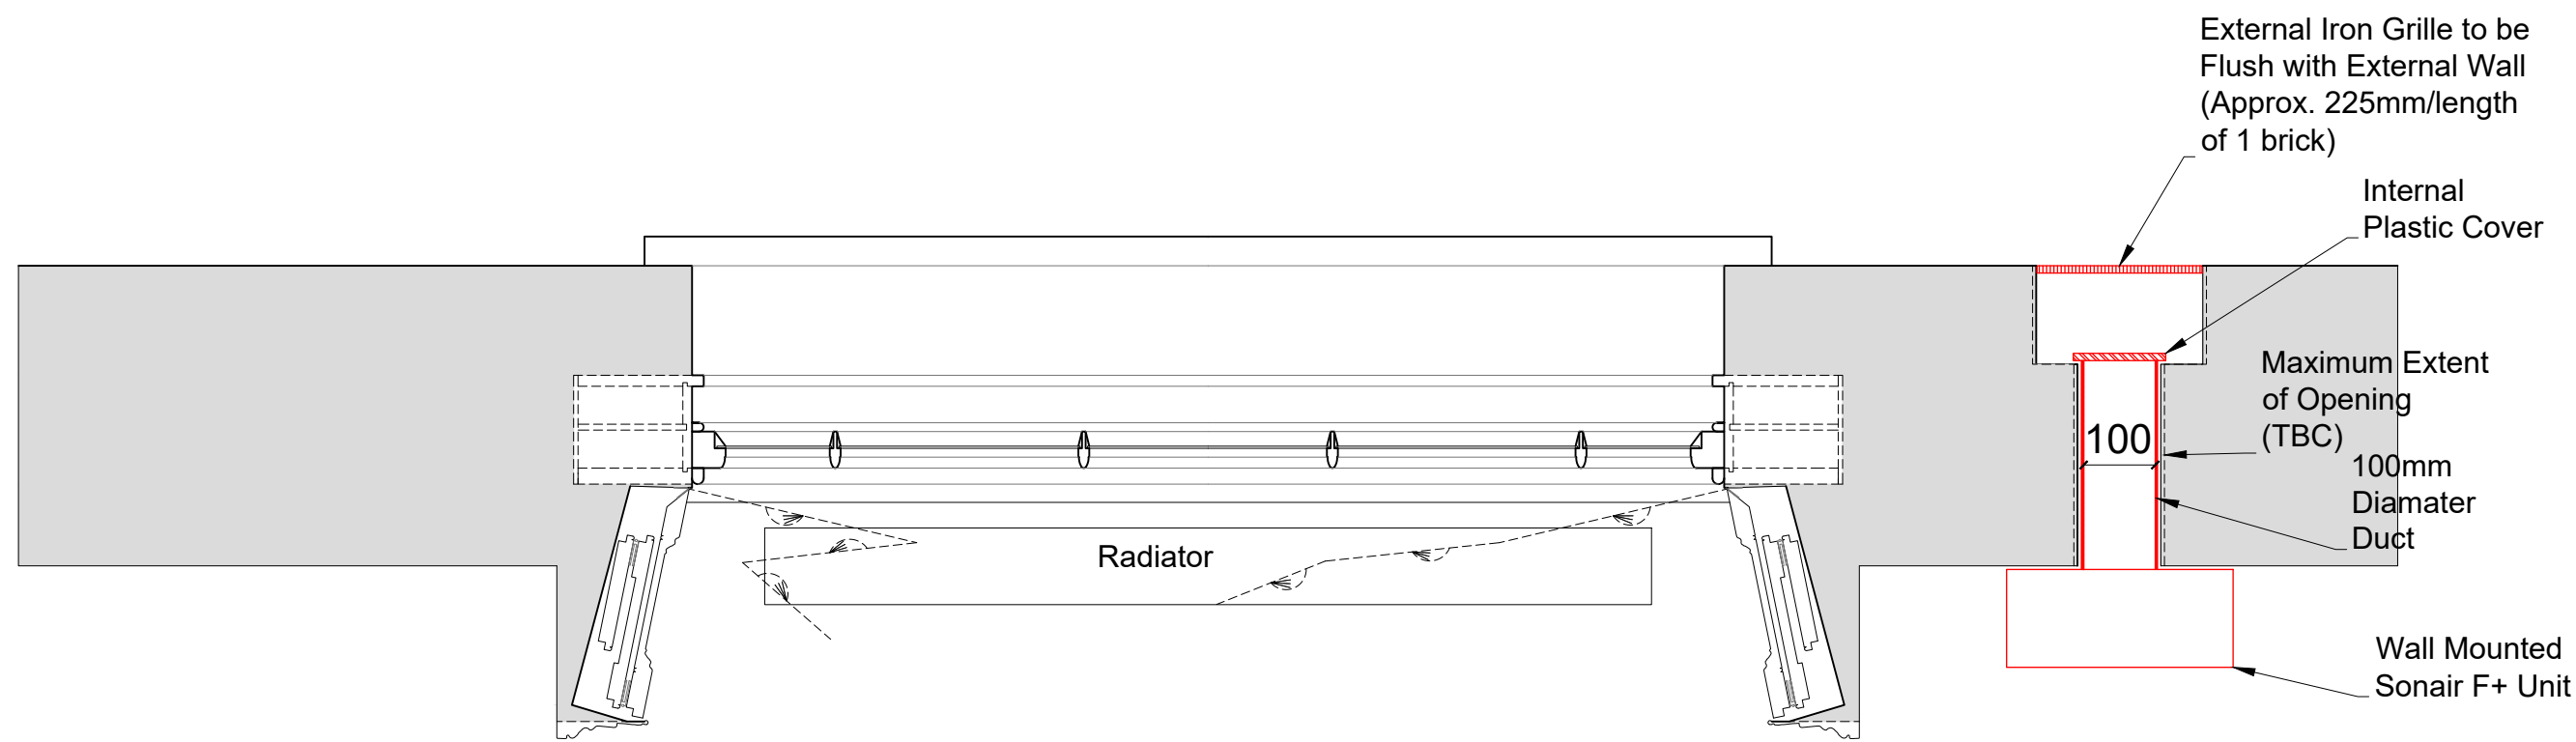

Detail of Sonair Unit

Scale: 1:5

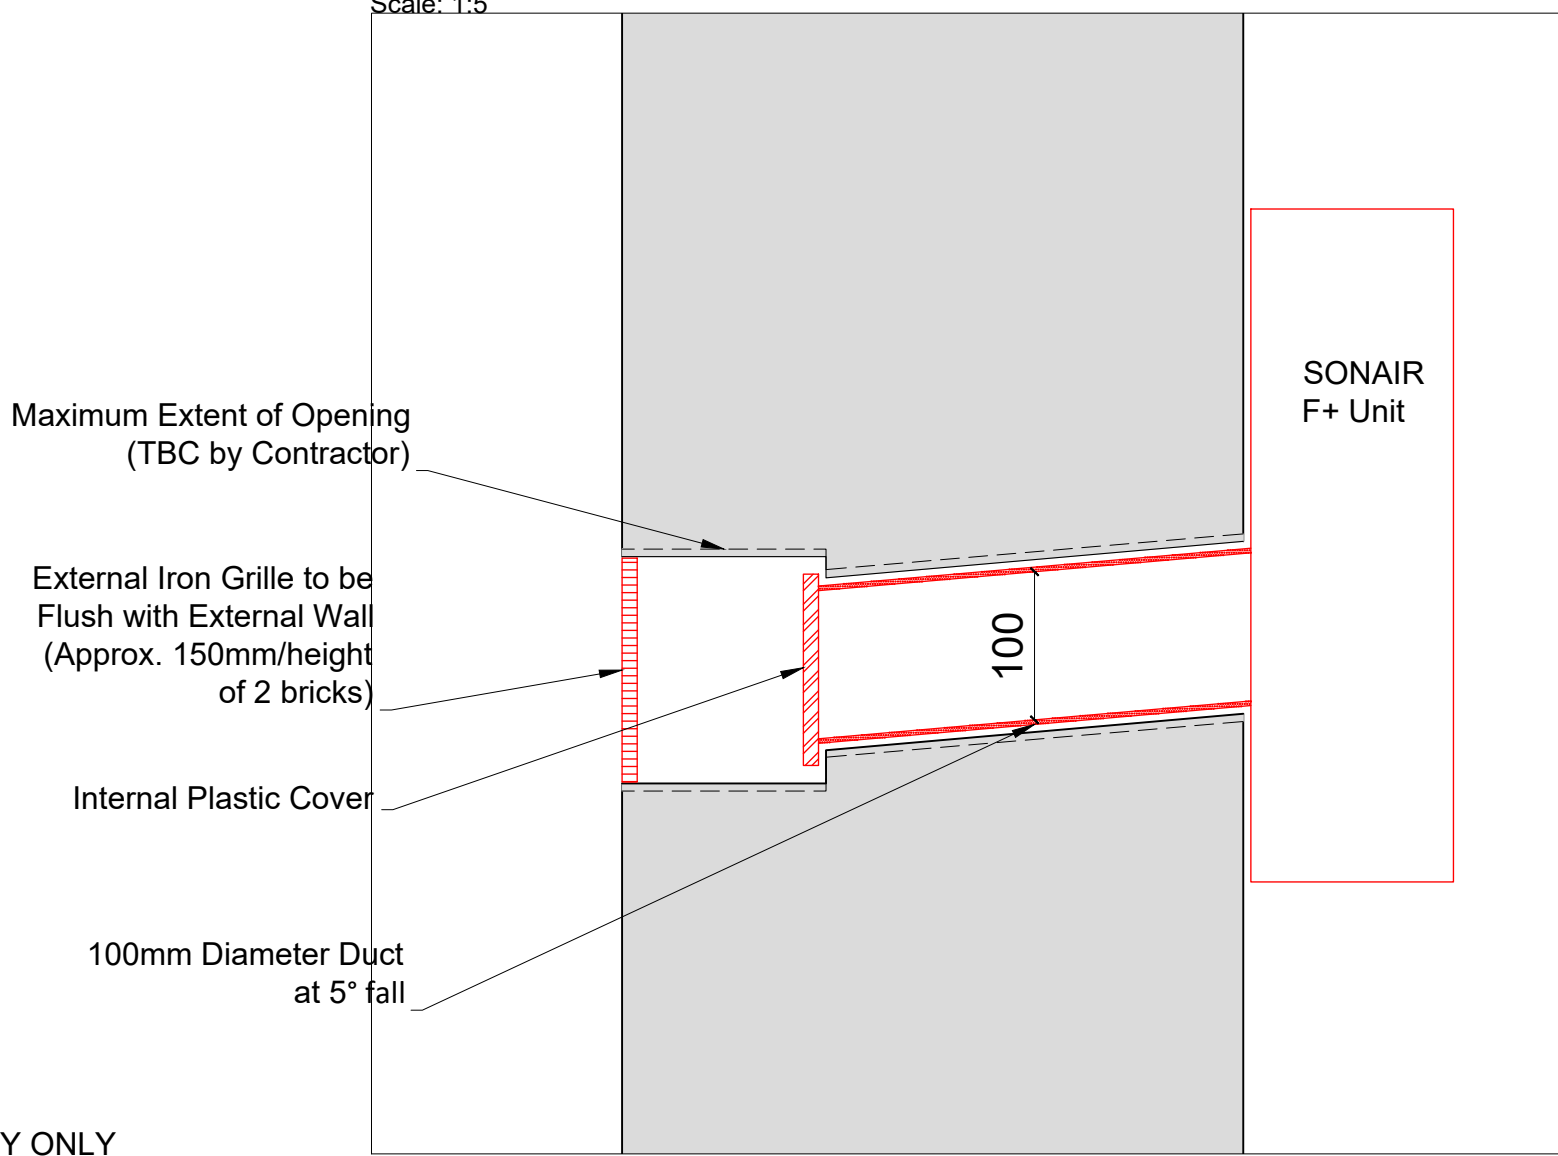

SECONDARY GLAZING SHOWN IN RED FOR VISUAL CLARITY ONLY

Revision	Date	Amendment
1.0	29-07-2022	Issued for listed building consent Application

Do not reproduce this drawing without written permission
All dimensions are in millimetres unless stated otherwise

Drawing Not For Construction

HS2

High Speed (HS2) Limited
1st/3rd Floor
The Podium
1 Eversholt Street
London NW1 2DN


SKANSKA

Skanska Costain Strabag Joint Venture
Xavier House
5A Granby Terrace
London NW1 3SA

Site Address: 56 Delancey Street, London NW1			
Drawing Title: Ground Floor - Dining Room: PROPOSED Mechanical Ventilation Details - Sheet 2 of 3			
Submitted by: AP & PB	Primary Drawn by: PB	Secondary Drawn by: AP	Checked by: OB
Presentation Scale: as shown @ A1			Revision: 1.0
Date: 27-09-2021	Drawing No: WPI P066 NI - 62B DeS-PR-GF-J-02.1		Revision: 1.0


Internal Room Elevation

Scale: 1:10

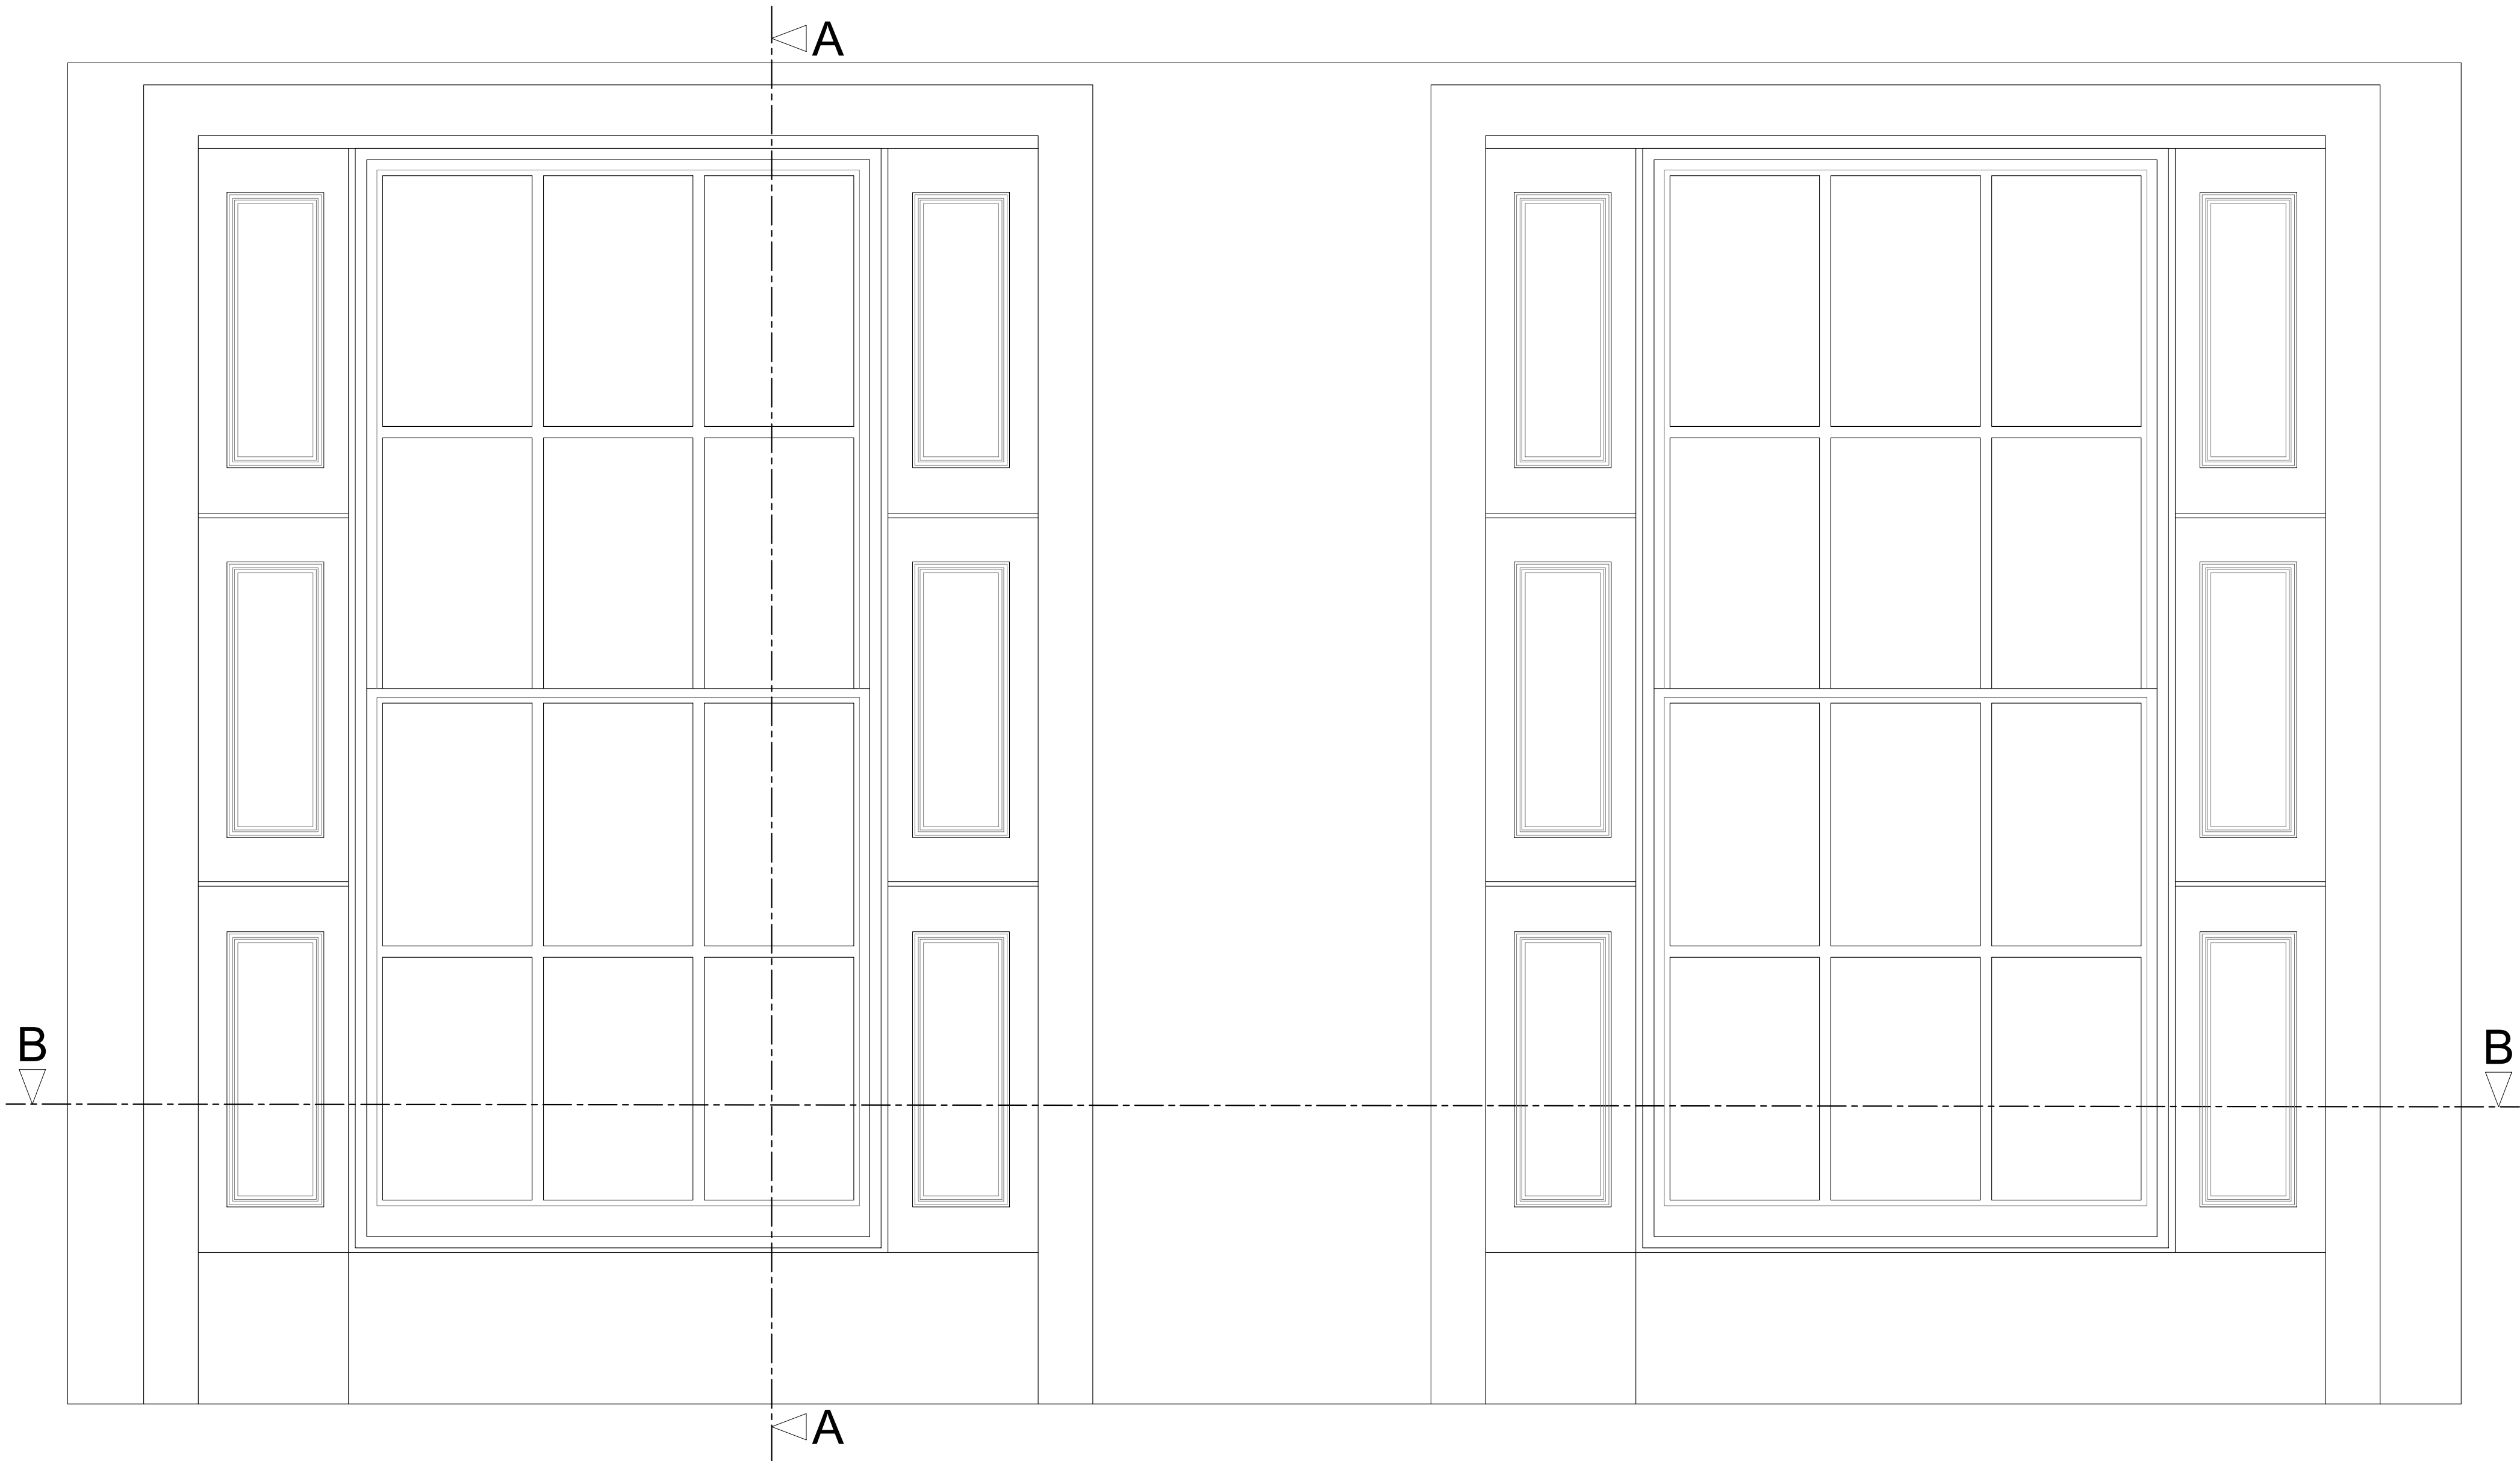


Section A-A through External Wall

Scale: 1:10

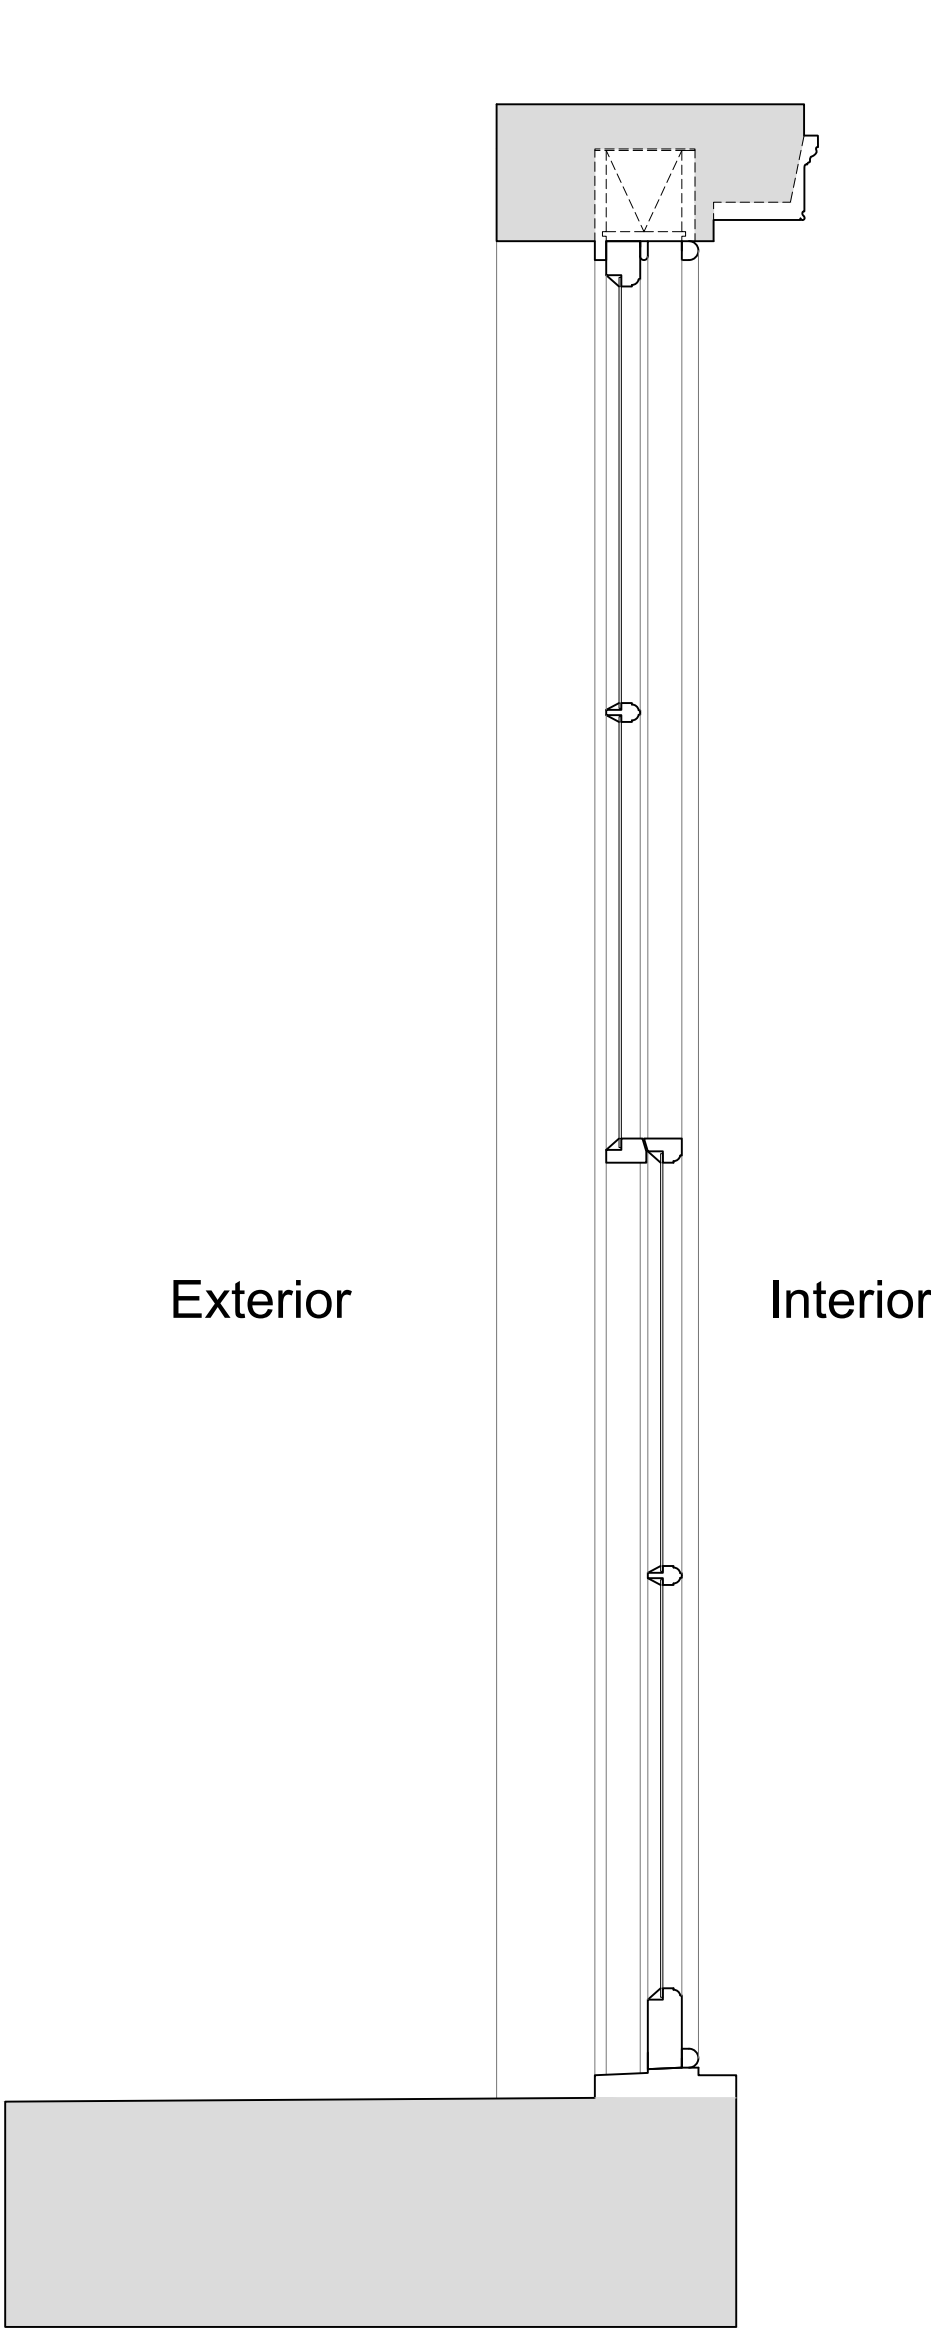

Plan Section B-B

Scale: 1:10

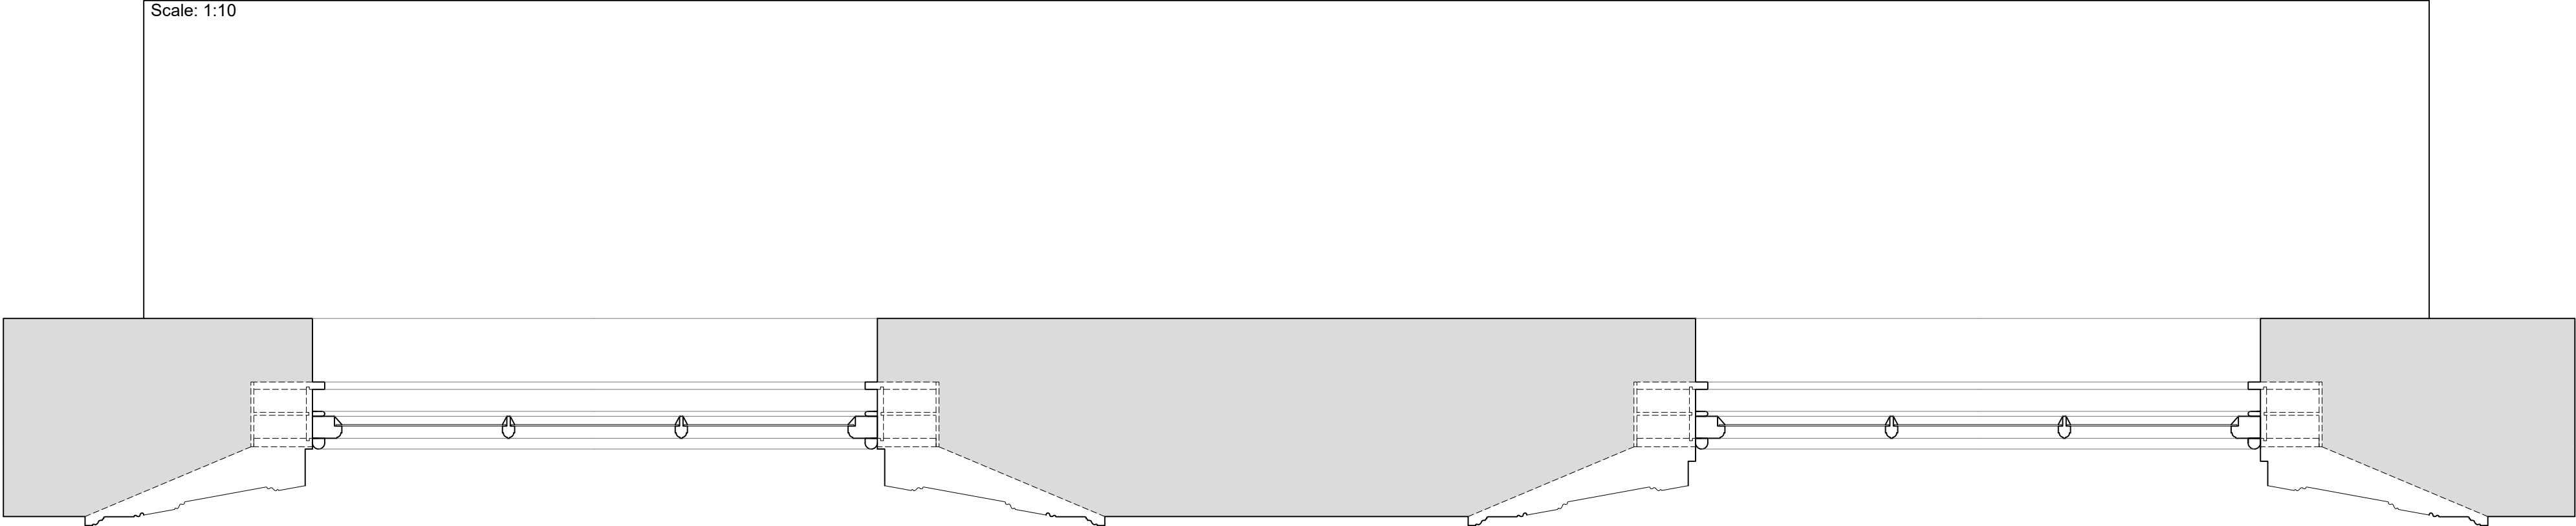

Revision	Date	Amendment
1.0	29-07-2022	Issued for listed building consent Application

Do not reproduce this drawing without written permission
All dimensions are in millimetres unless stated otherwise

HS2

High Speed (HS2) Limited
1st-3rd Floor
The Podium
1 Eversholt Street
London NW1 3DN

SKANSKA

STRABAG

Skanska Costain Strabag Joint Venture
Xavier House
5A Granby Terrace
London NW1 3SA

Site Address:
62B Delacey Street, London NW1

Drawing Title:
First Floor - Lounge: EXISTING Window Joinery Details -
Sheet 1 of 3


Submitted by:	Primary Drawn by:	Secondary Drawn by:	Checked by:	Presentation Scale:
AP & PB	PB	AP	OB	as shown @ A1

Date:	Drawing No:	Revision:
27-09-2021	WPI P066 NI - 62B DeS-EX-FF-J-03	1.0

Drawing Not For Construction


Internal Room Elevation with Secondary Glazing Installed

Scale: 1:10

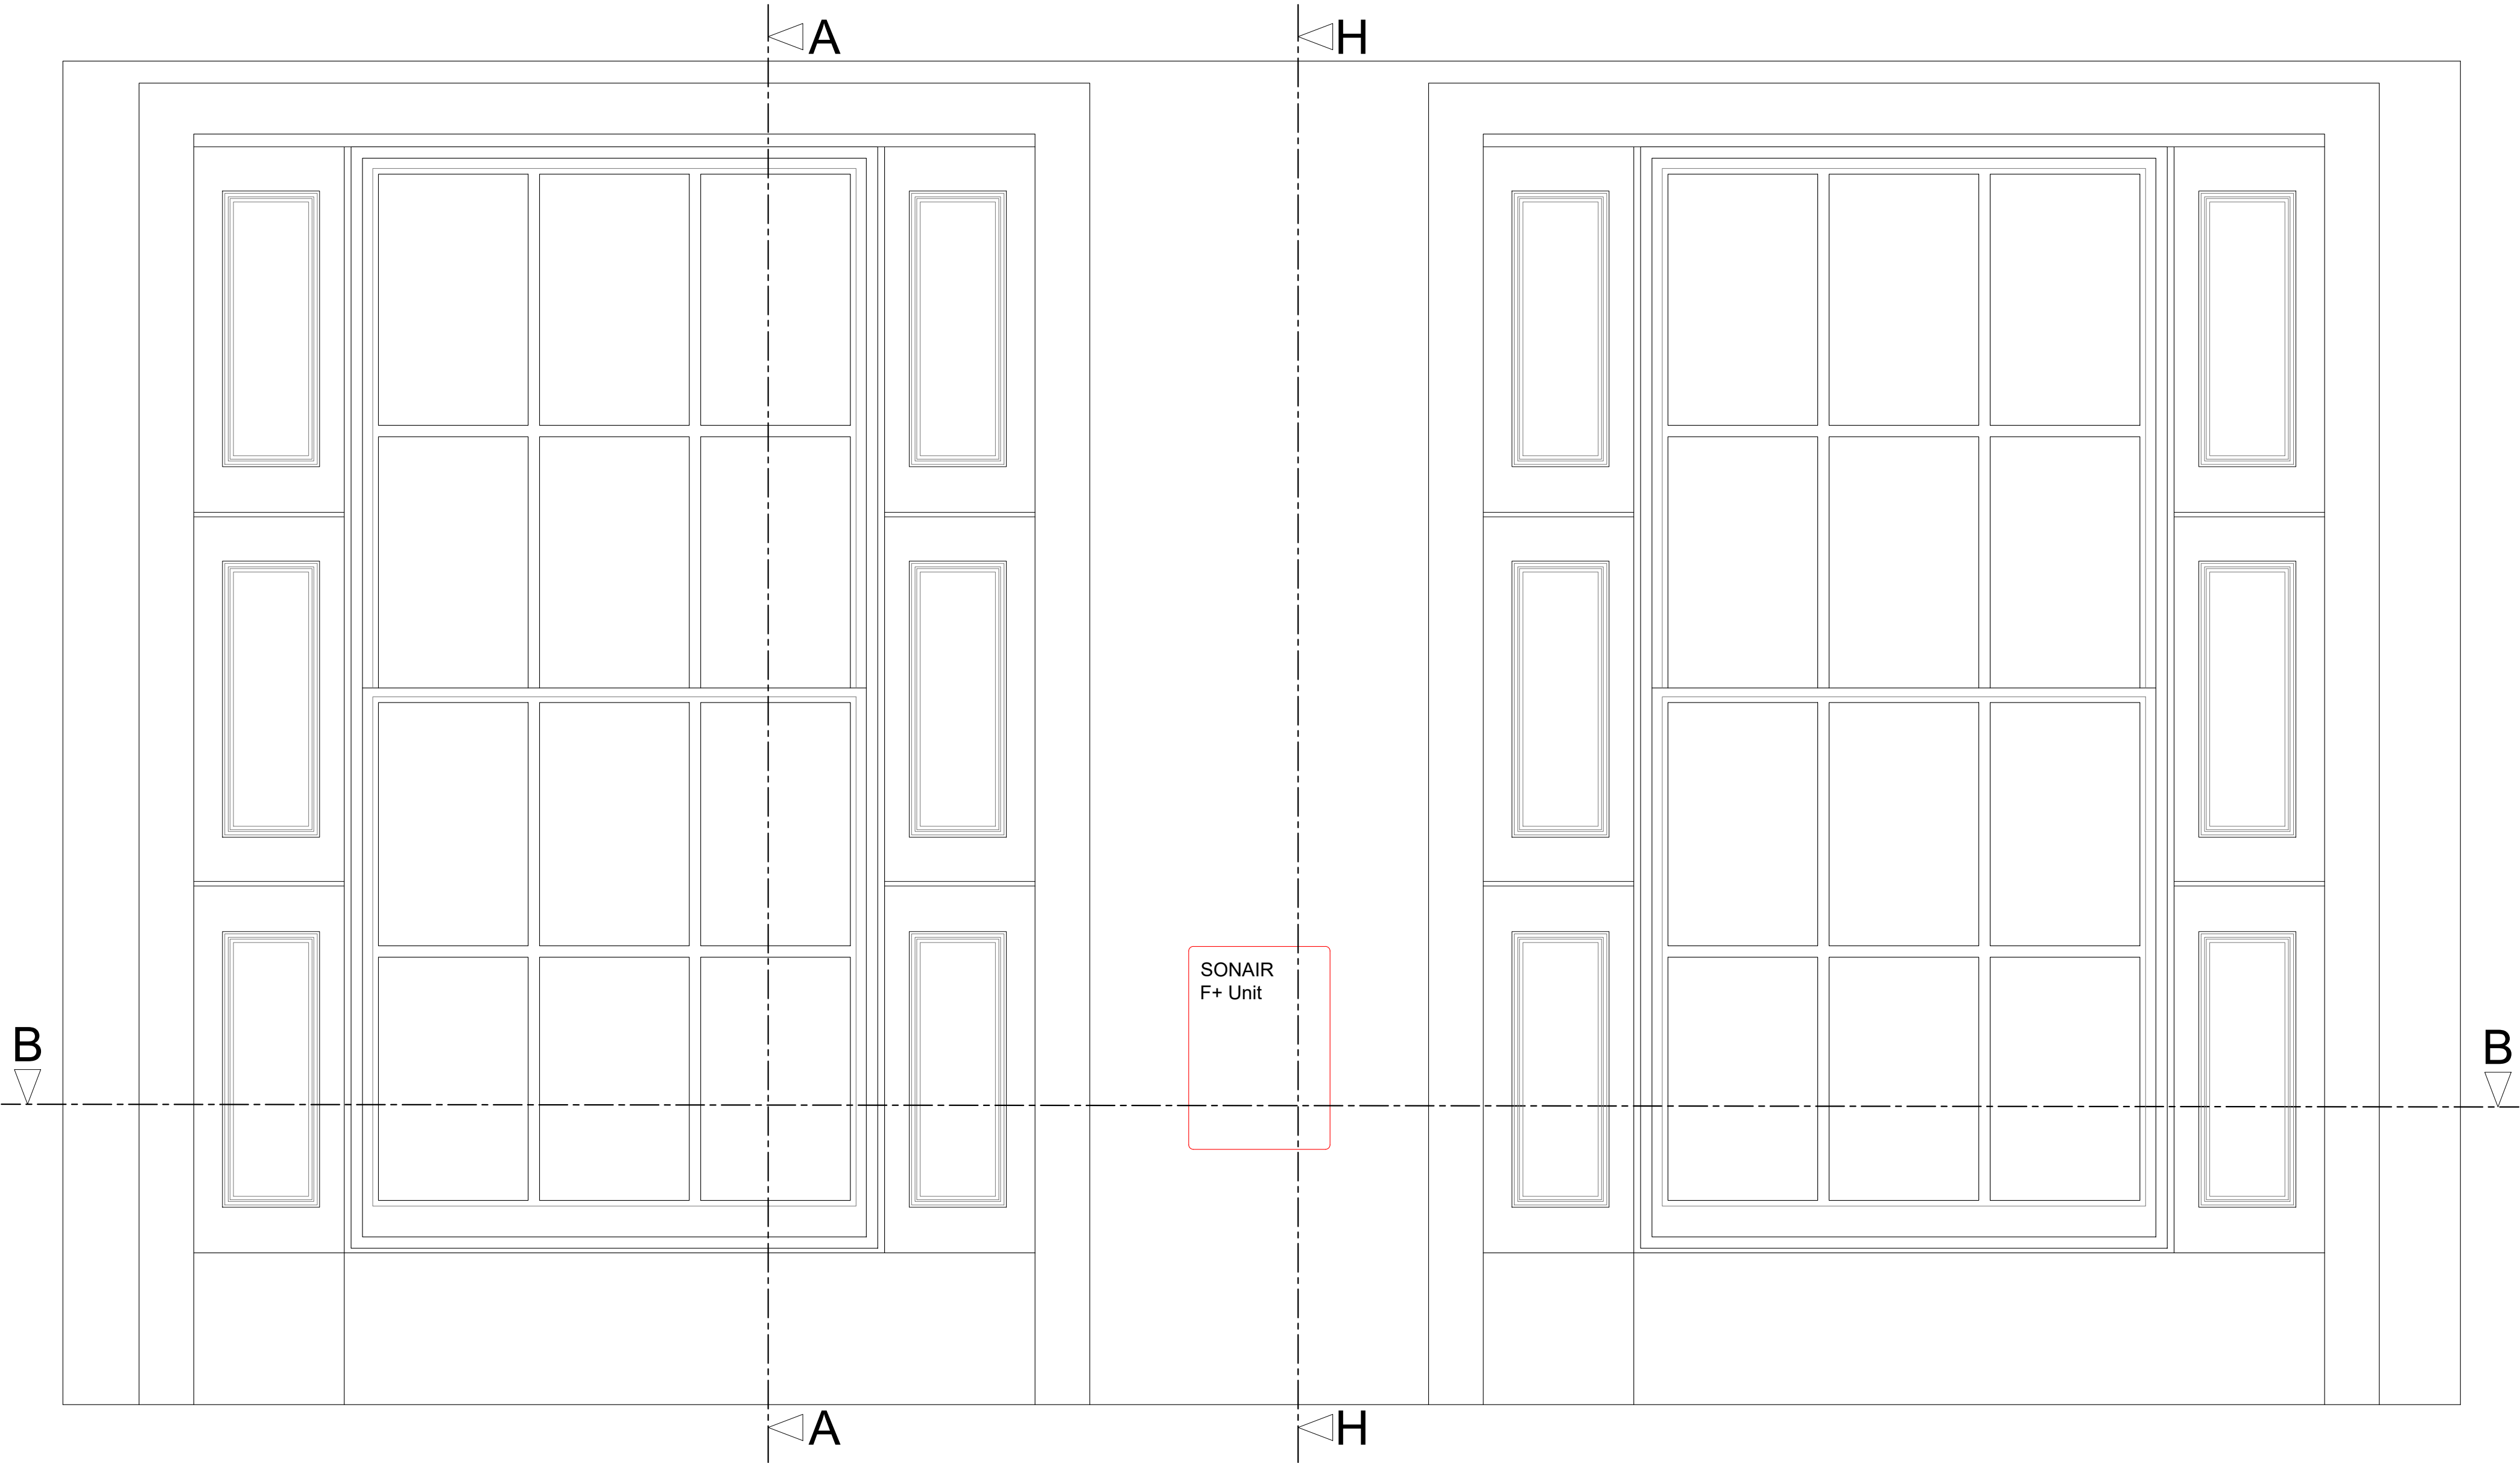


Section H-H through External Wall with Mechanical Ventilation Installed

Scale: 1:10

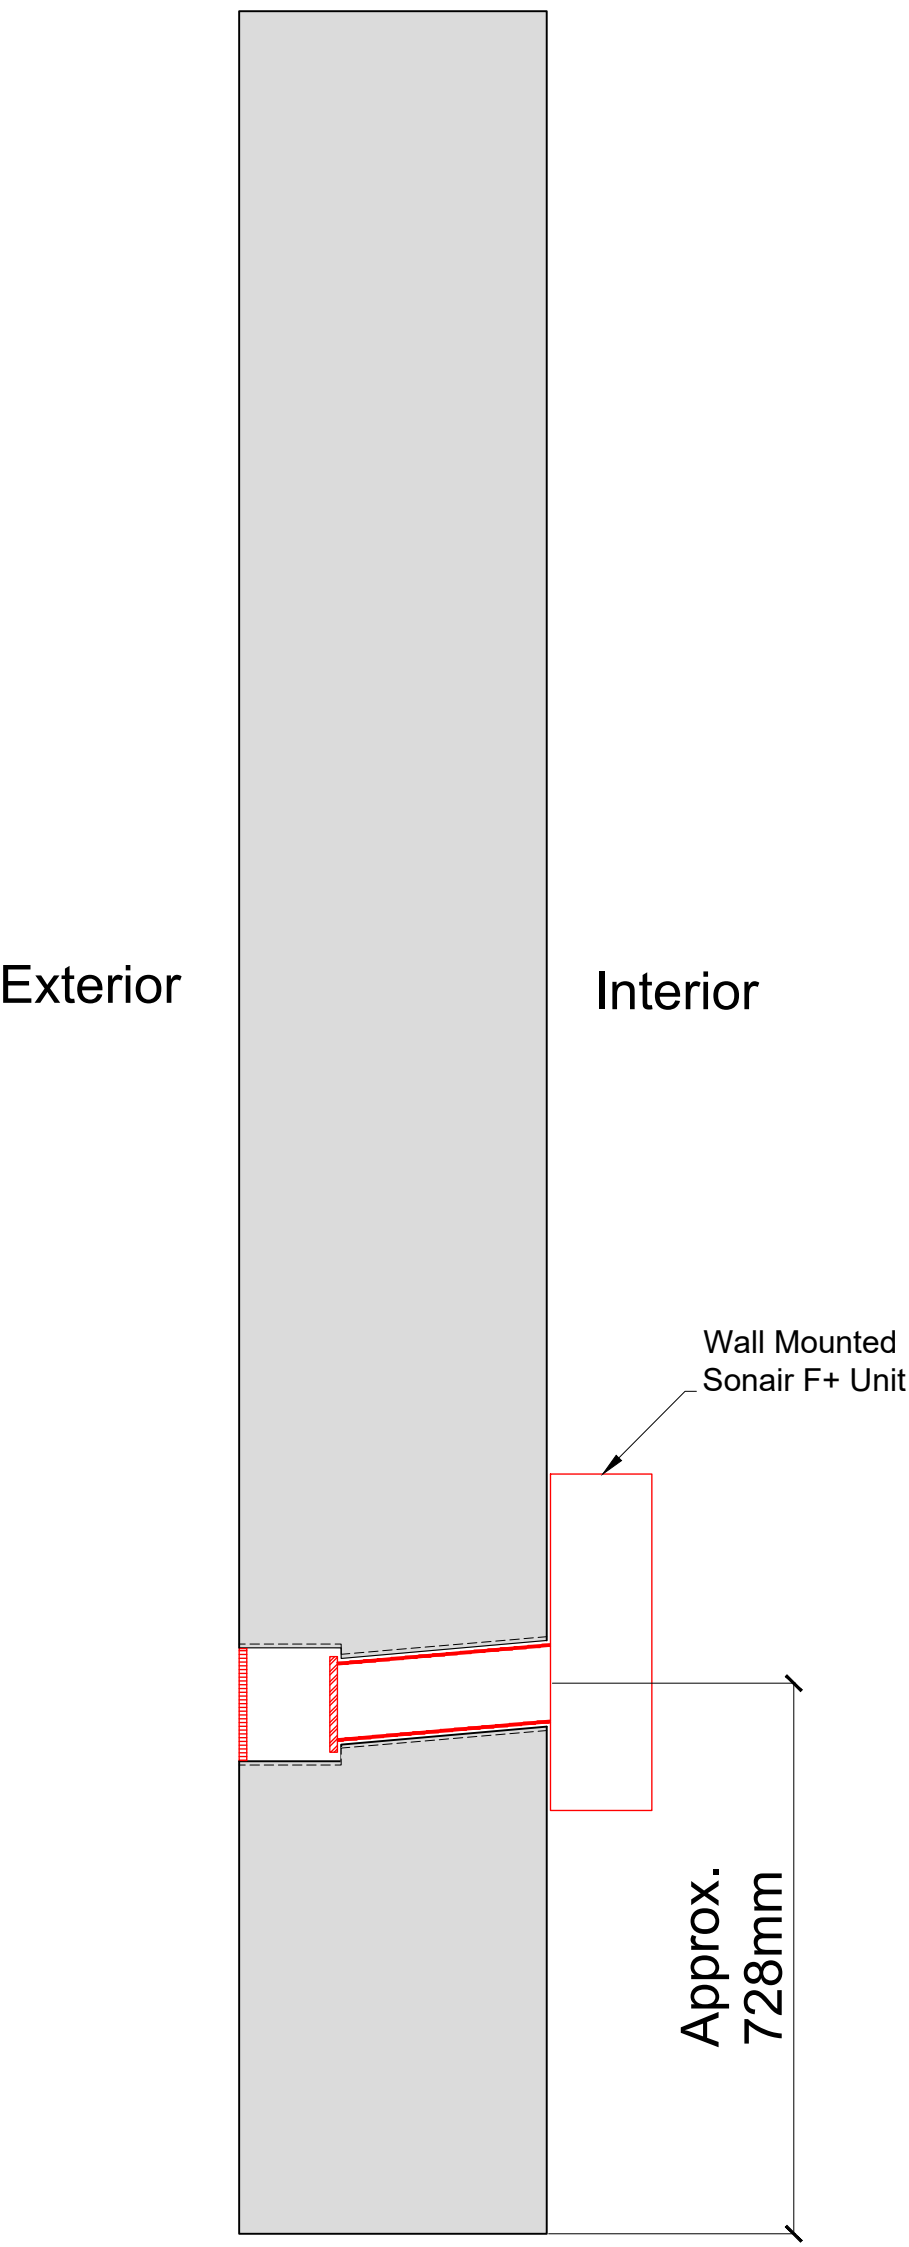


Plan Section B-B with Secondary Glazing Installed

Scale: 1:10

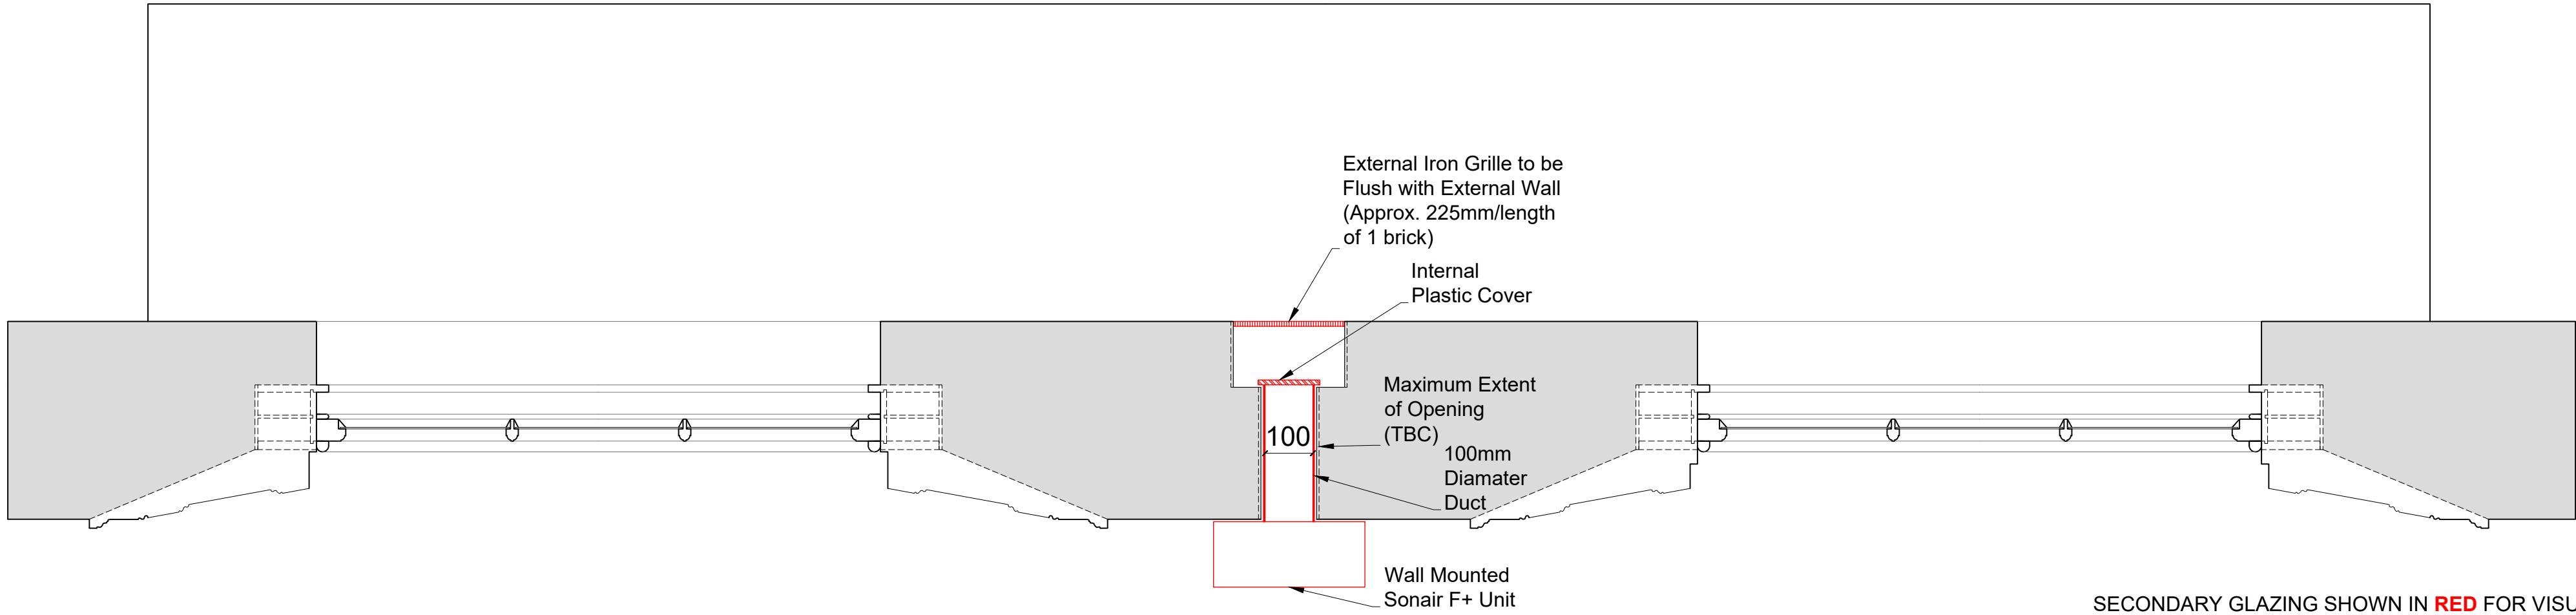

Detail of Sonair Unit

Scale: 1:5

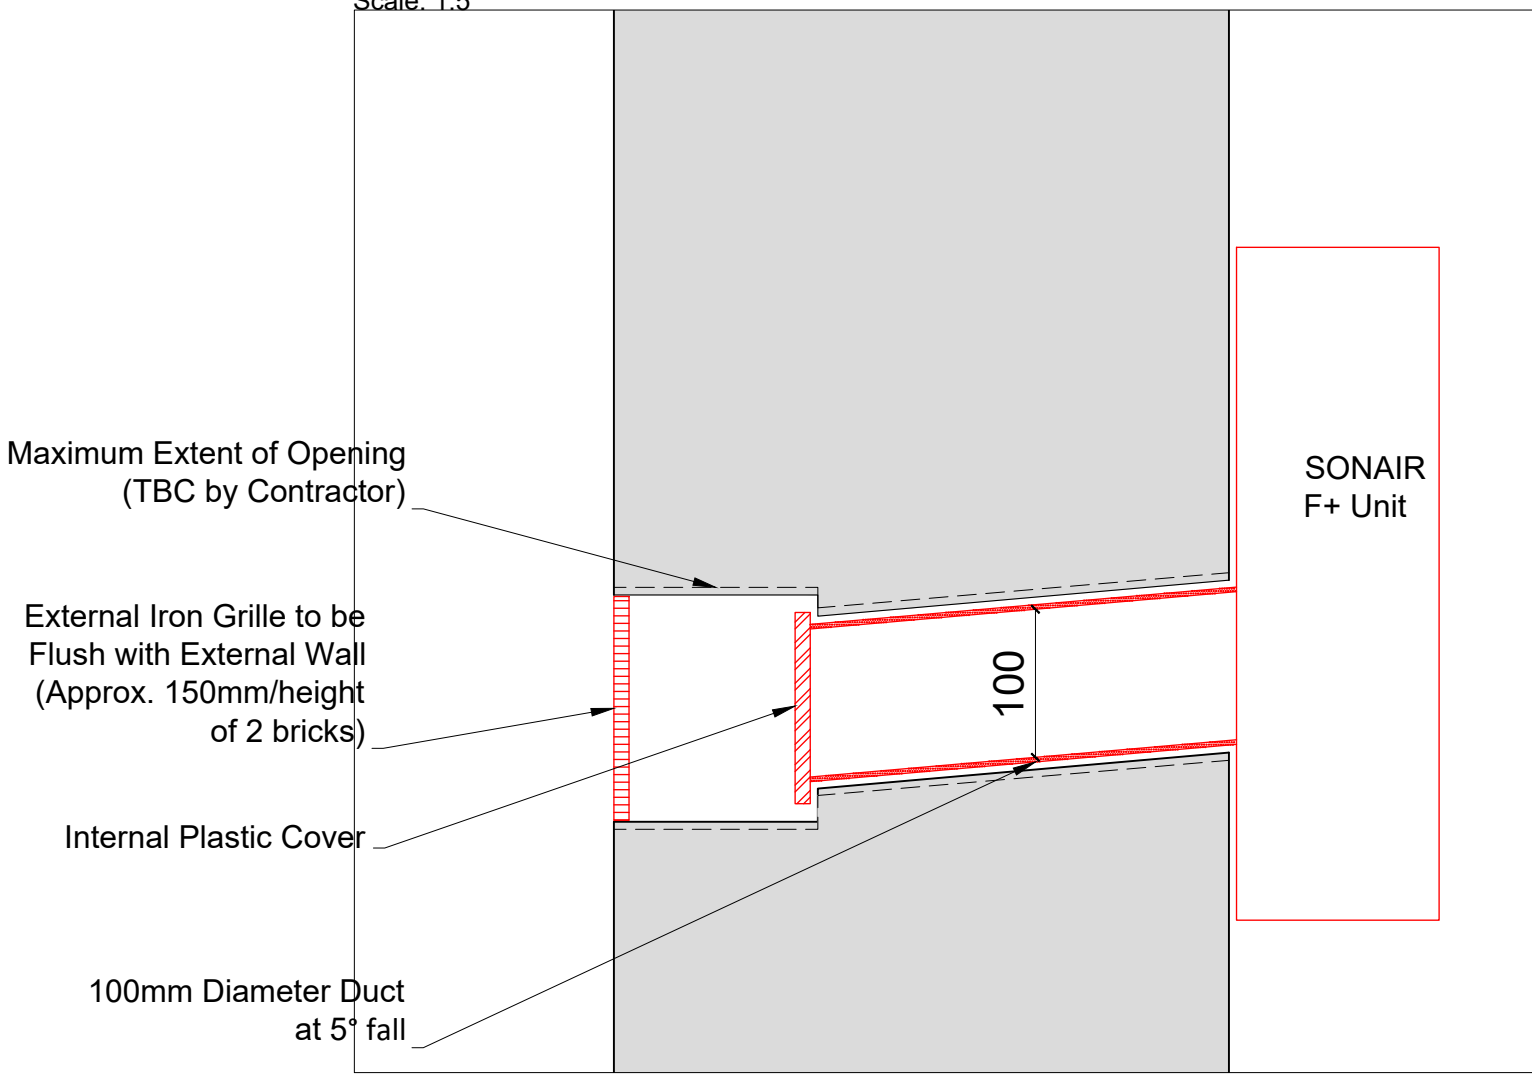

SECONDARY GLAZING SHOWN IN RED FOR VISUAL CLARITY ONLY

Revision	Date	Amendment
1.0	29-07-2022	Issued for listed building consent Application

Do not reproduce this drawing without written permission
All dimensions are in millimetres unless stated otherwise

Drawing Not For Construction

HS2

High Speed (HS2) Limited
1st/3rd Floor
The Podium
1 Eversholt Street
London NW1 2DN

SKANSKA

Skanska Costain Strabag Joint Venture
Xavier House
5A Granby Terrace
London NW1 3SA


Site Address:
62B Delacey Street, London NW1

Drawing Title:
First Floor - Lounge: PROPOSED Mechanical Ventilation Details - Sheet 2 of 3

Submitted by:	Primary Drawn by:	Secondary Drawn by:	Checked by:	Presentation Scale:
AP & PB	PB	AP	OB	as shown @ A1

Date:	Drawing No:	Revision:
27-09-2021	WPI P066 NI - 62B DeS-PR-FF-J-03.1	1.0

Internal Room Elevation
Scale: 1:10

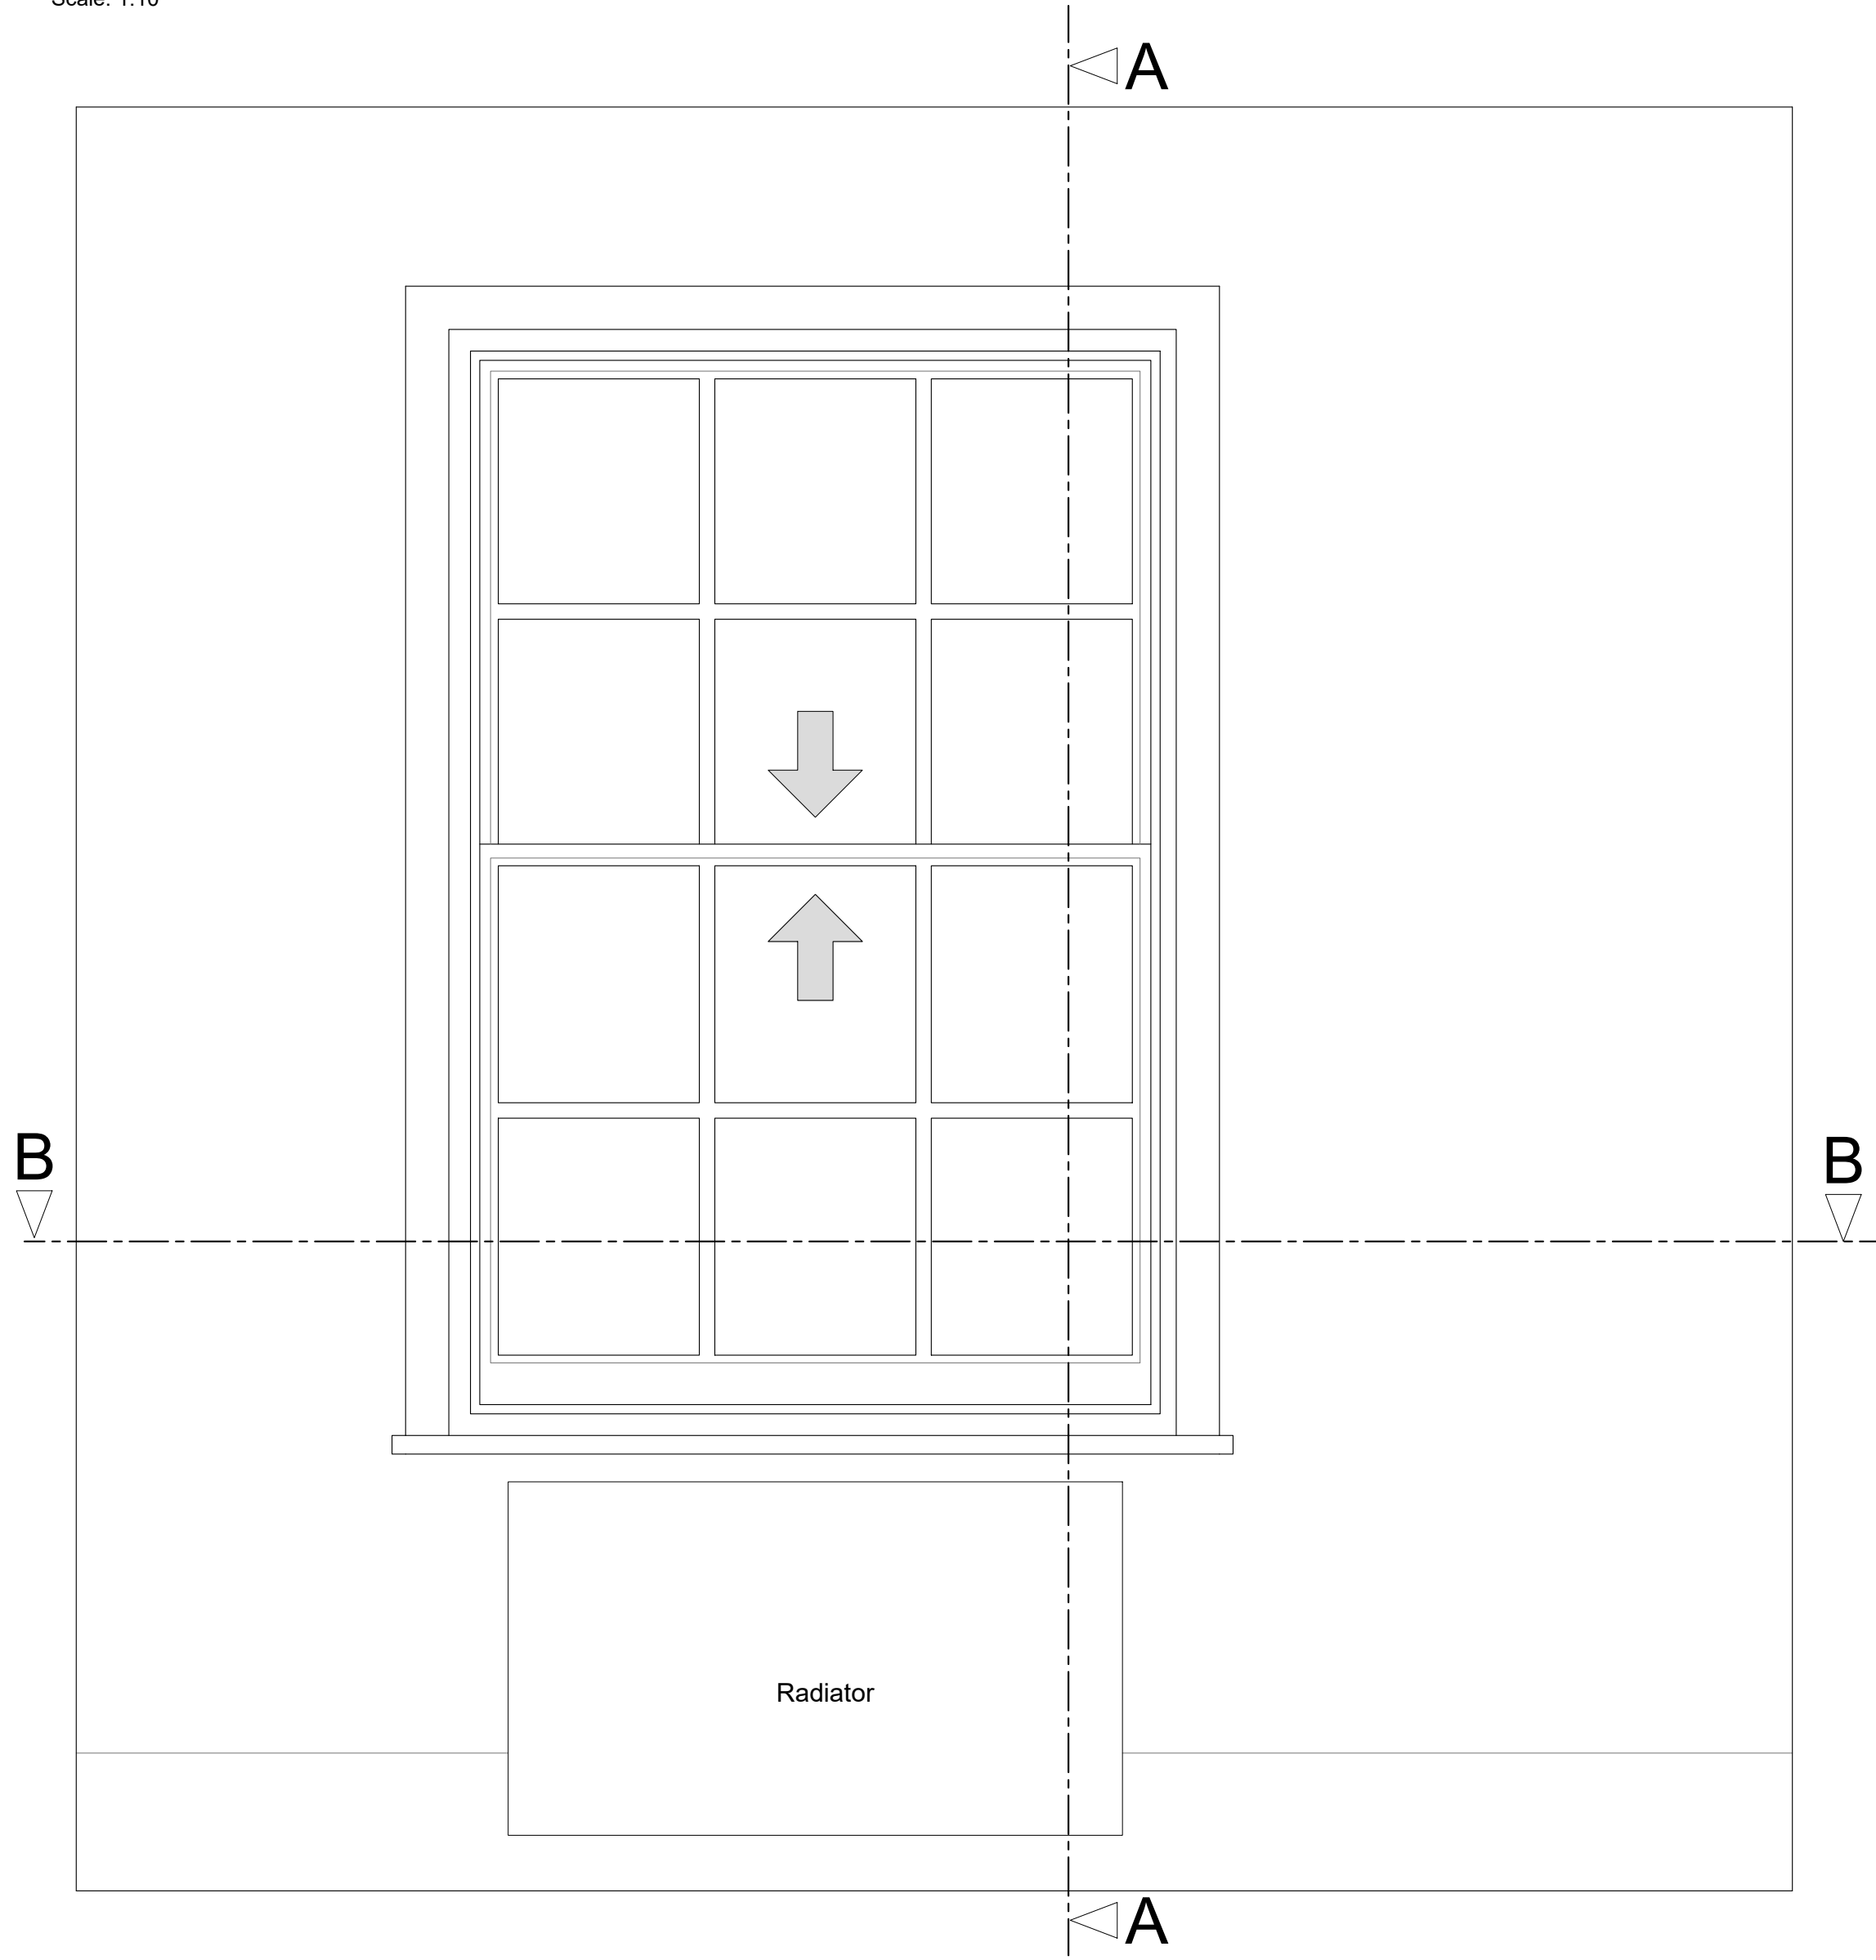


A

B

A

B

Plan Section B-B
Scale: 1:10

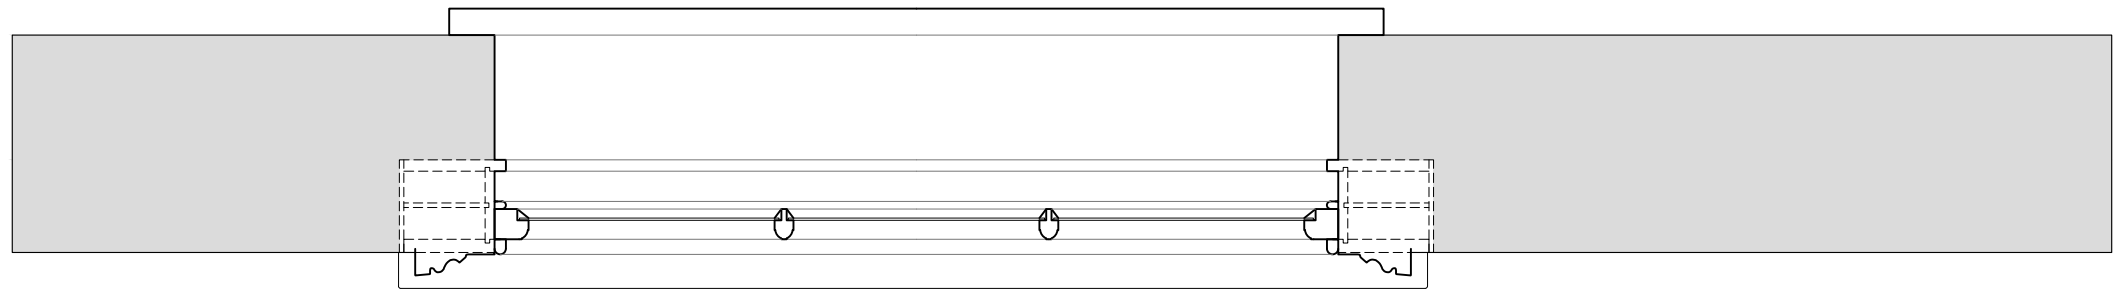

A



B

A

Section A-A through External Wall
Scale: 1:10

Left

Right

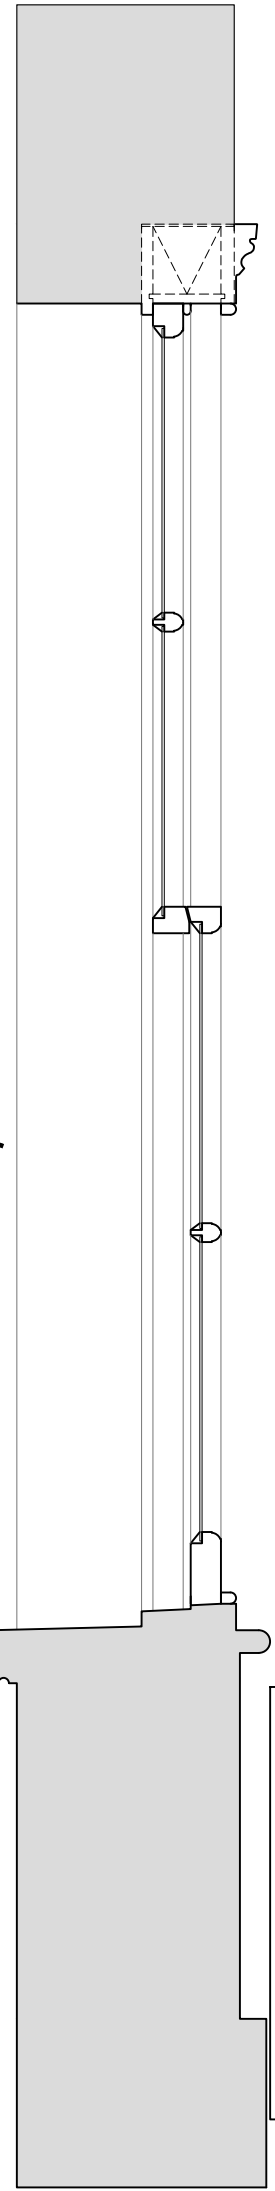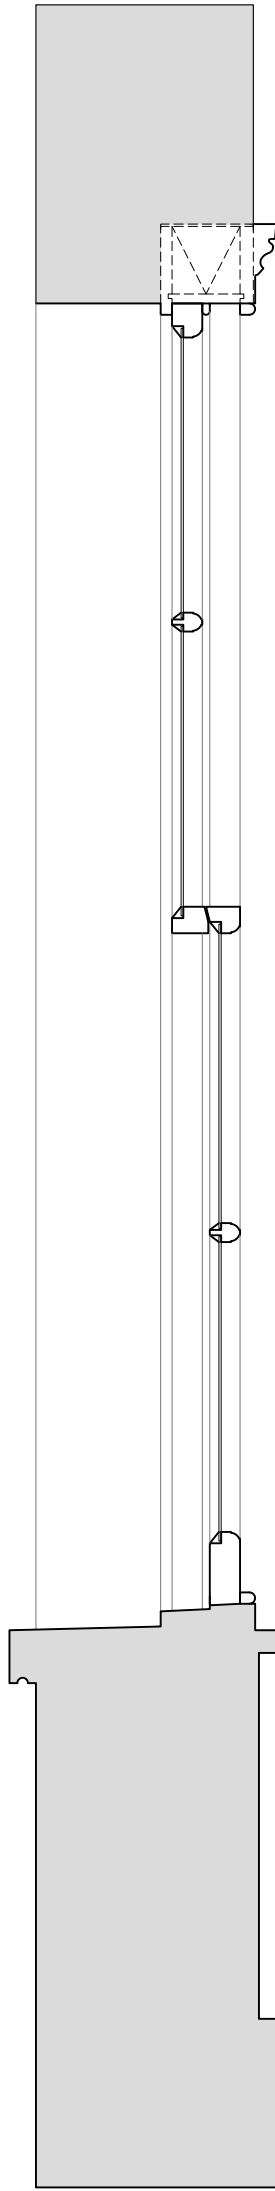

Exterior

Interior

Exterior

Interior

R
a
d
i
a
t
o
r

R
a
d
i
a
t
o
r

Revision	Date	Amendment
1.0	29-07-2022	Issued for listed building consent Application

Do not reproduce this drawing without written permission
All dimensions are in millimetres unless stated otherwise

HS2

High Speed (HS2) Limited
1st/3rd Floor
The Podium
1 Eversholt Street
London NW1 2DN

SKANSKA

STRABAG

Skanska Costain Strabag Joint Venture

5A Granby Terrace
London NW1 3SA

Site Address:

62B Delacey Street, London NW1

Drawing Title:

Second Floor - Bedroom Left&Right: EXISTING Window Joinery Details -
Sheet 1 of 3

Submitted by:

AP & PB

Primary Drawn by:

PB

Secondary Drawn by:

AP

Checked by:

OB

Presentation Scale:

as shown @ A1

Date:

27-09-2021

Drawing No:



WPI P066 NI - 62B DeS-EX-SF-J-04

Revision:


1.0

Drawing Not For Construction



Internal Room Elevation with Secondary Glazing Installed
Scale: 1:10

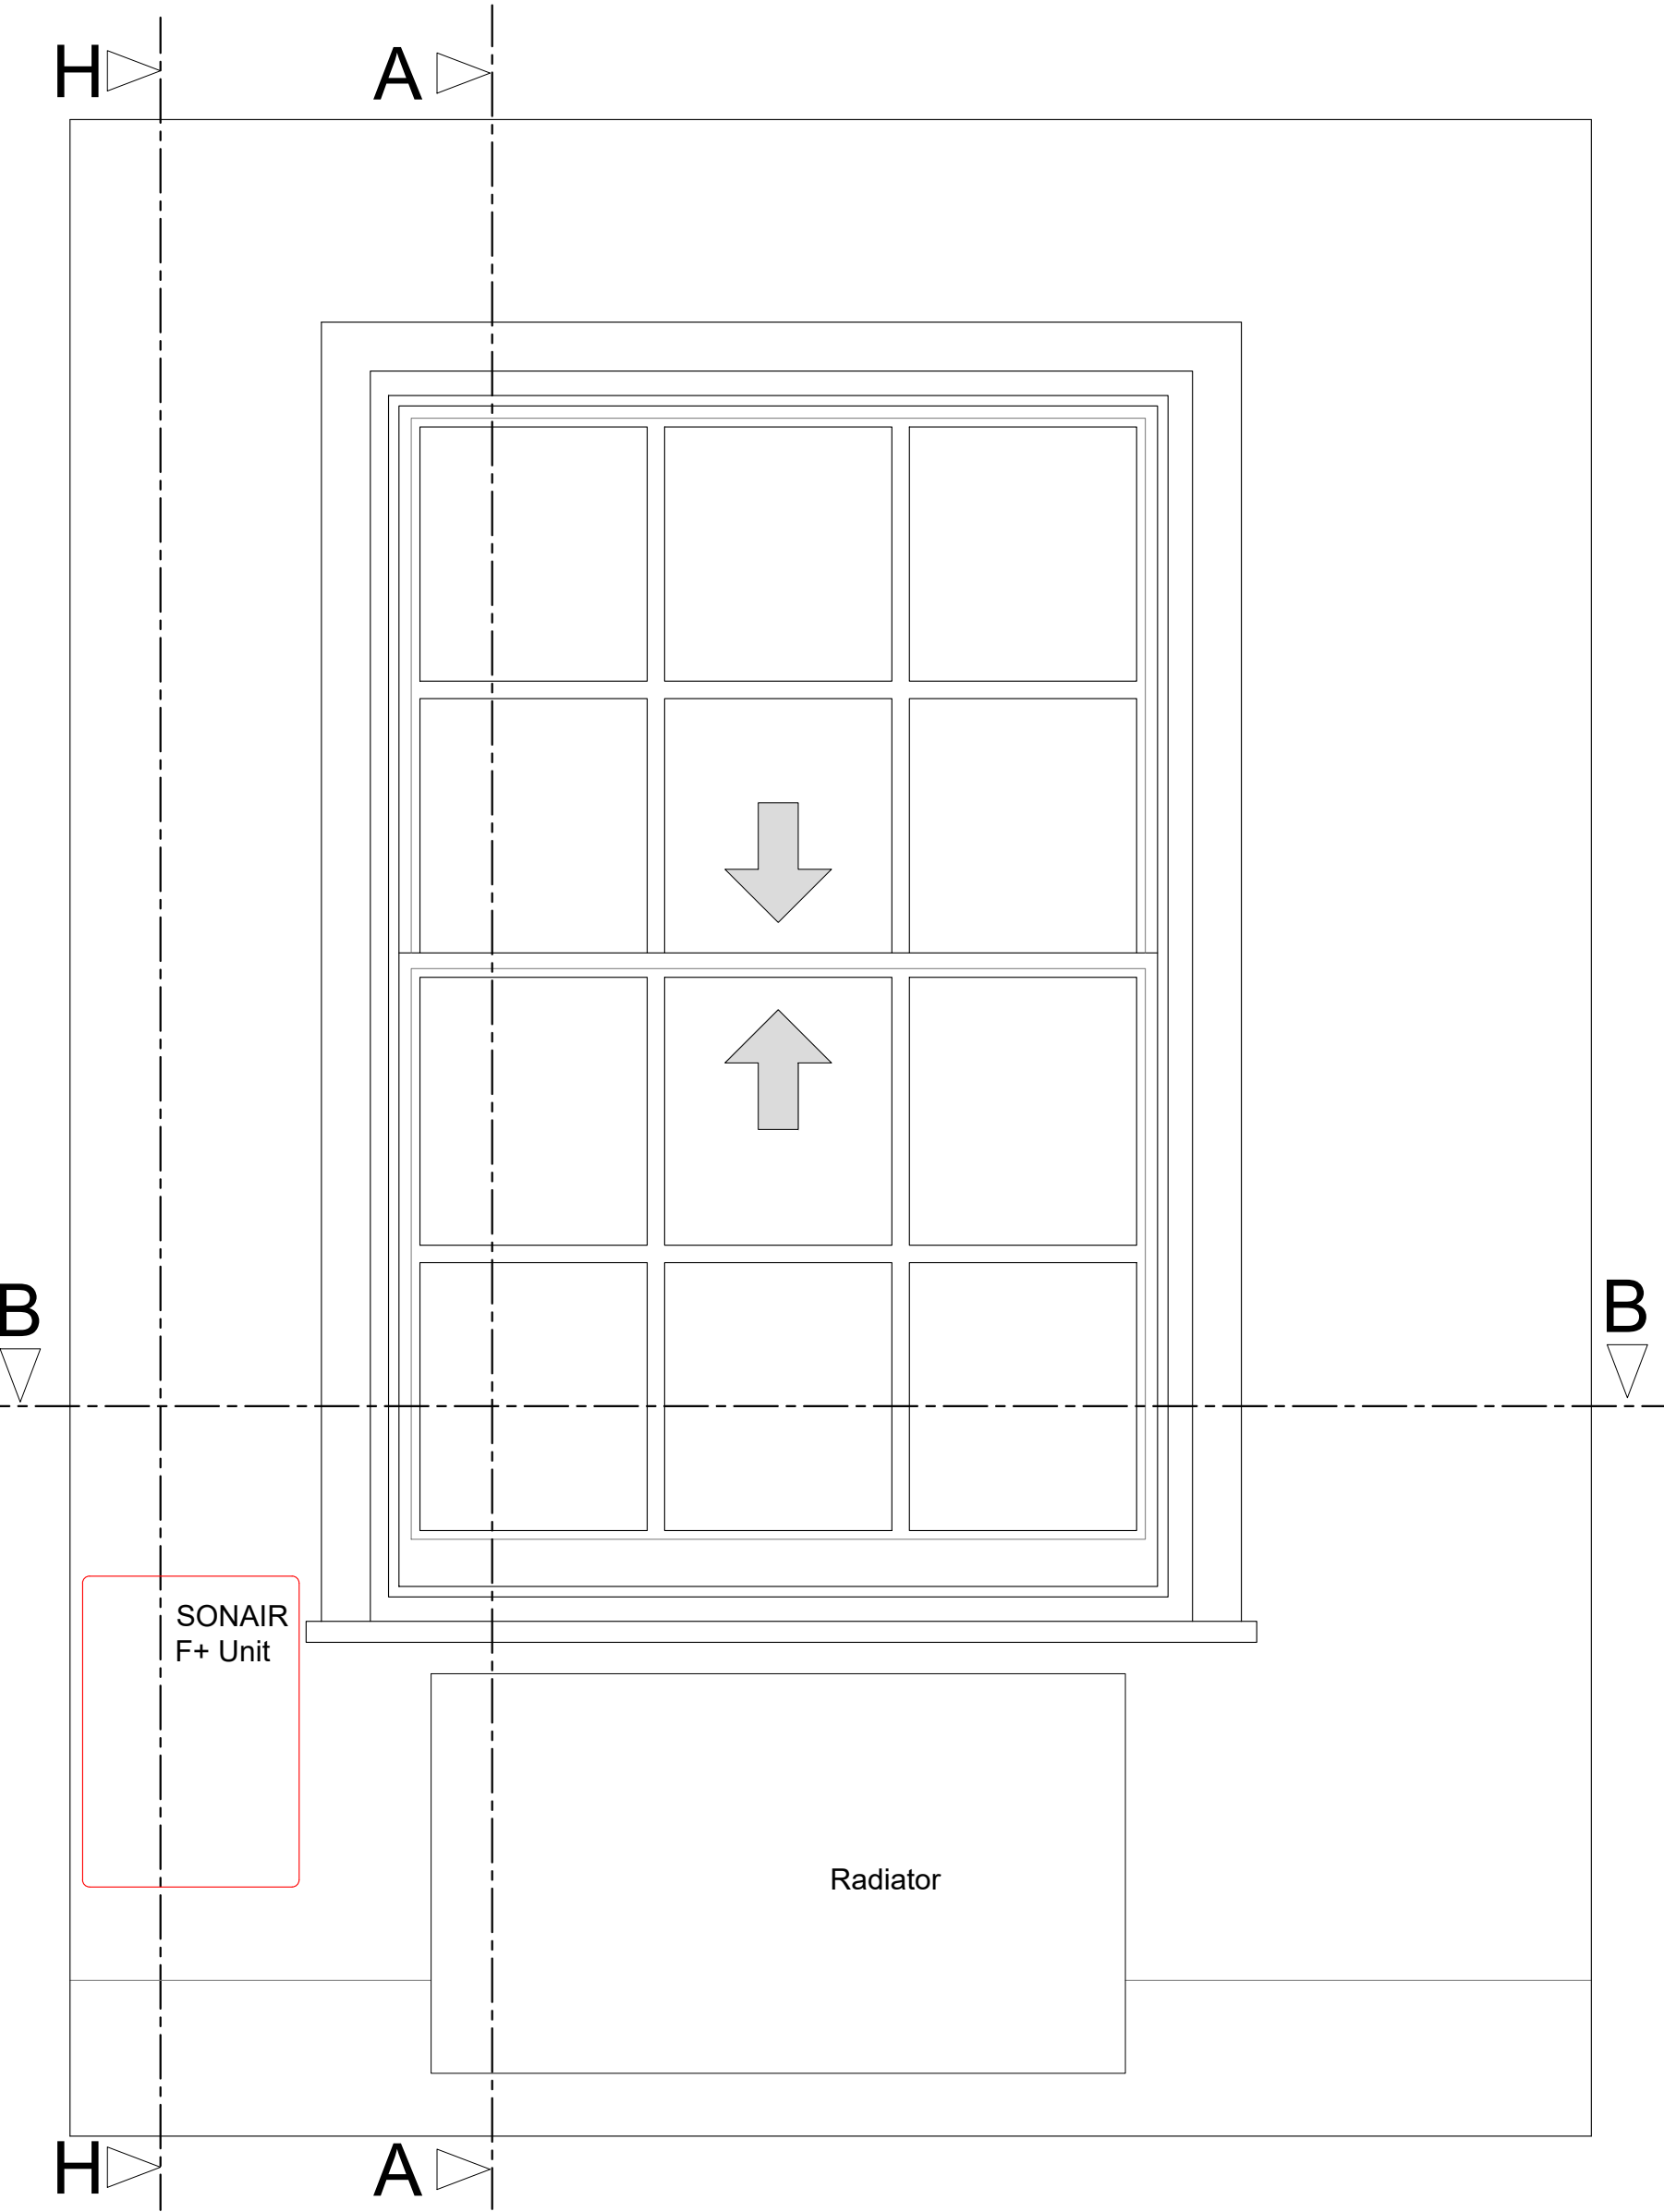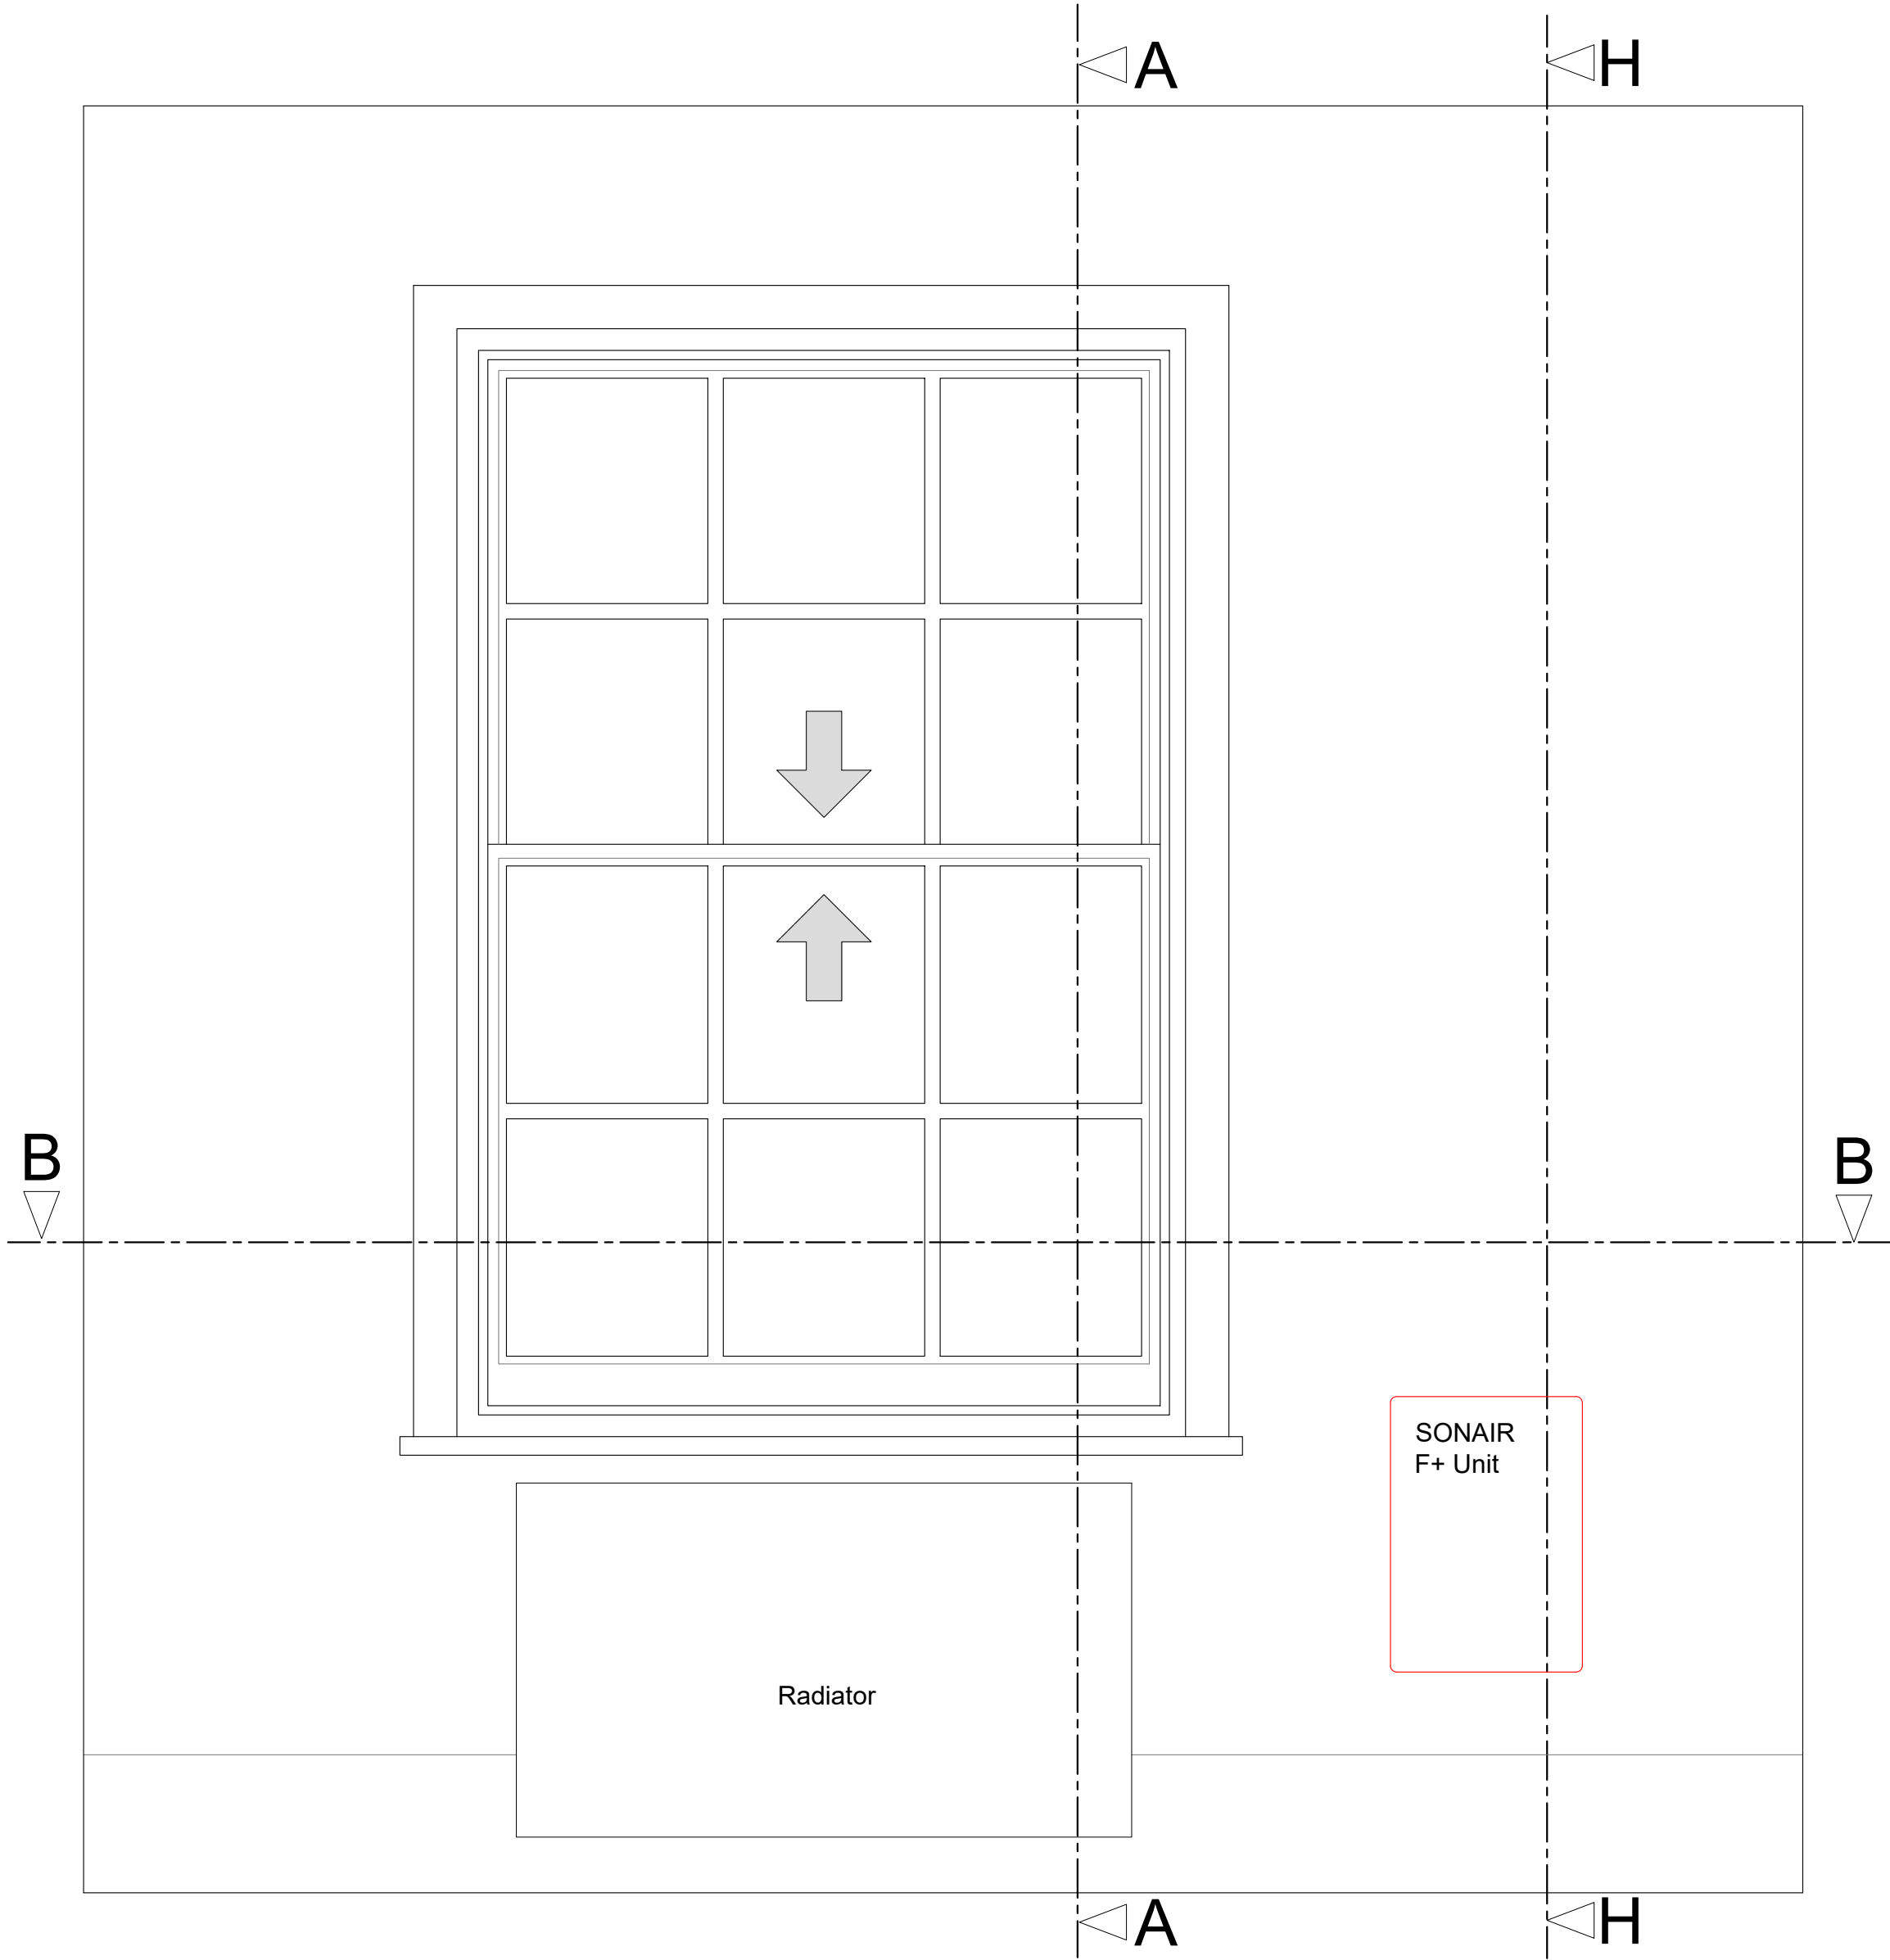


Section H-H through External Wall with Mechanical Ventilation Installed
Scale: 1:10

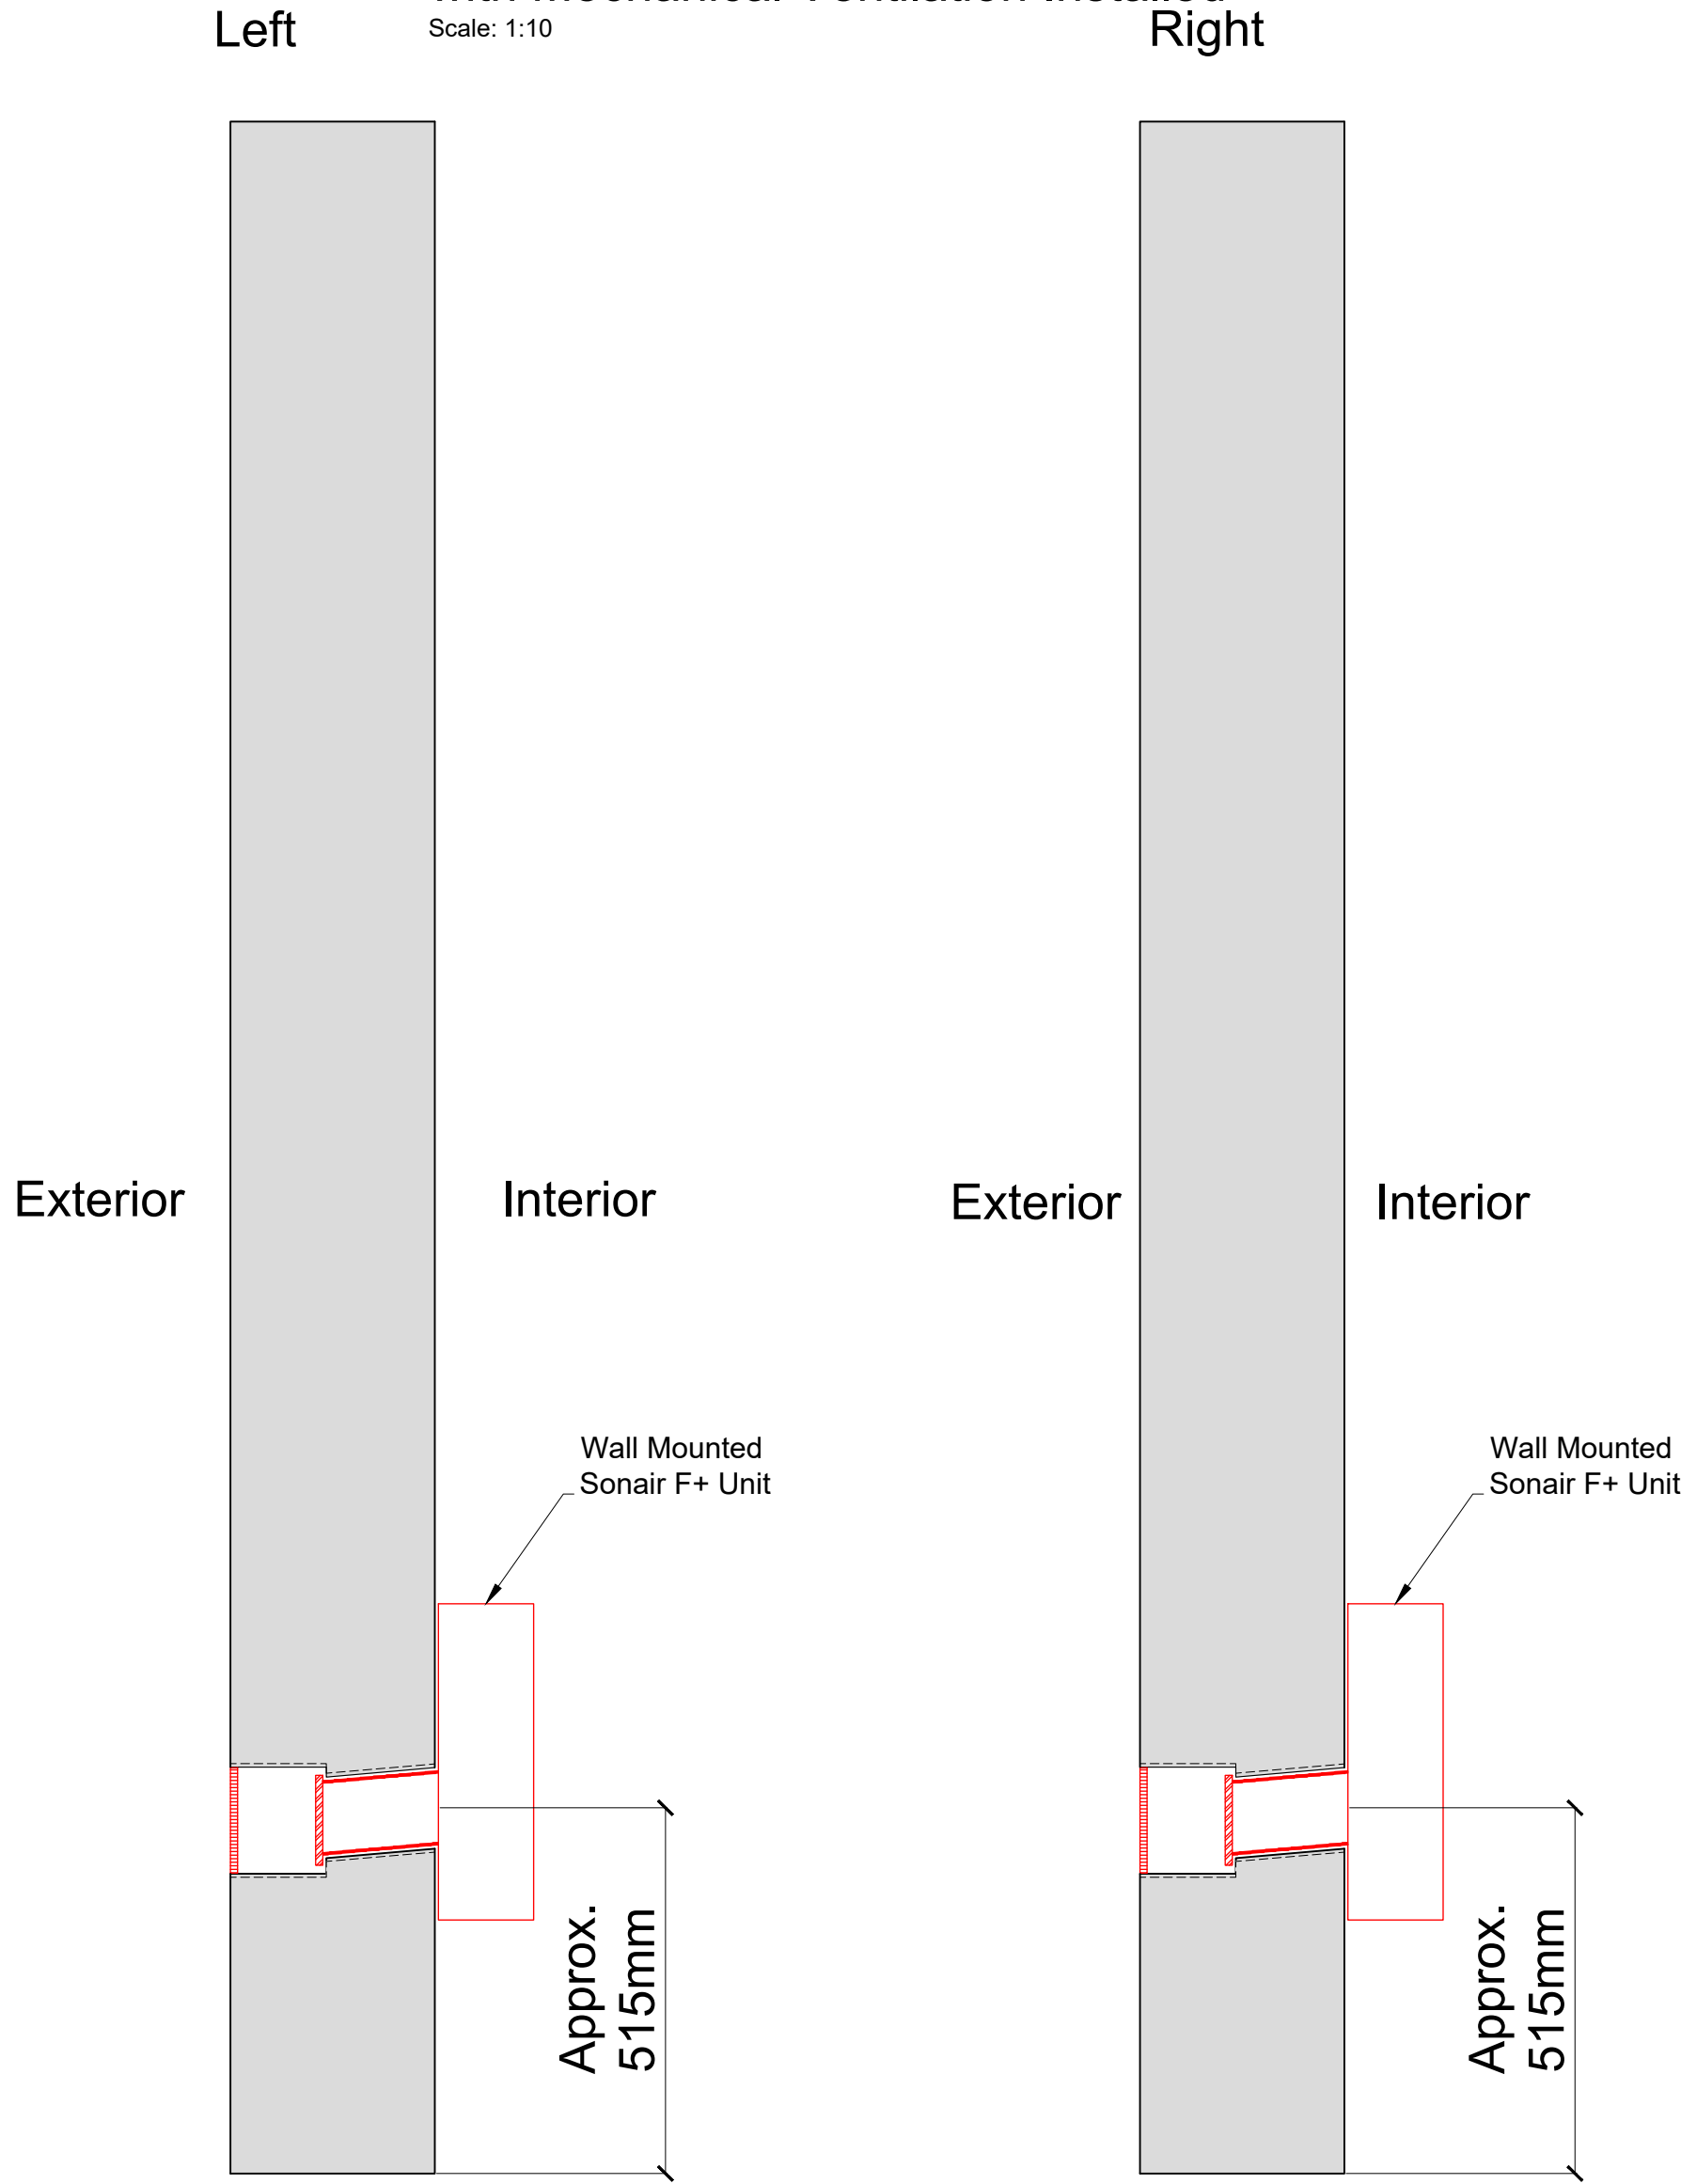

Plan Section B-B with Secondary Glazing Installed
Scale: 1:10

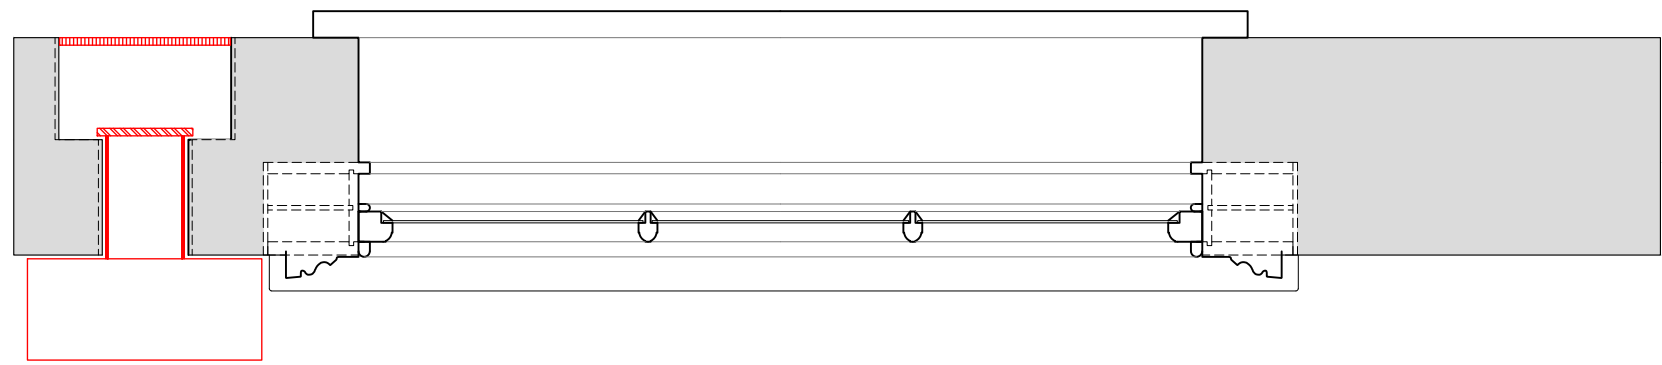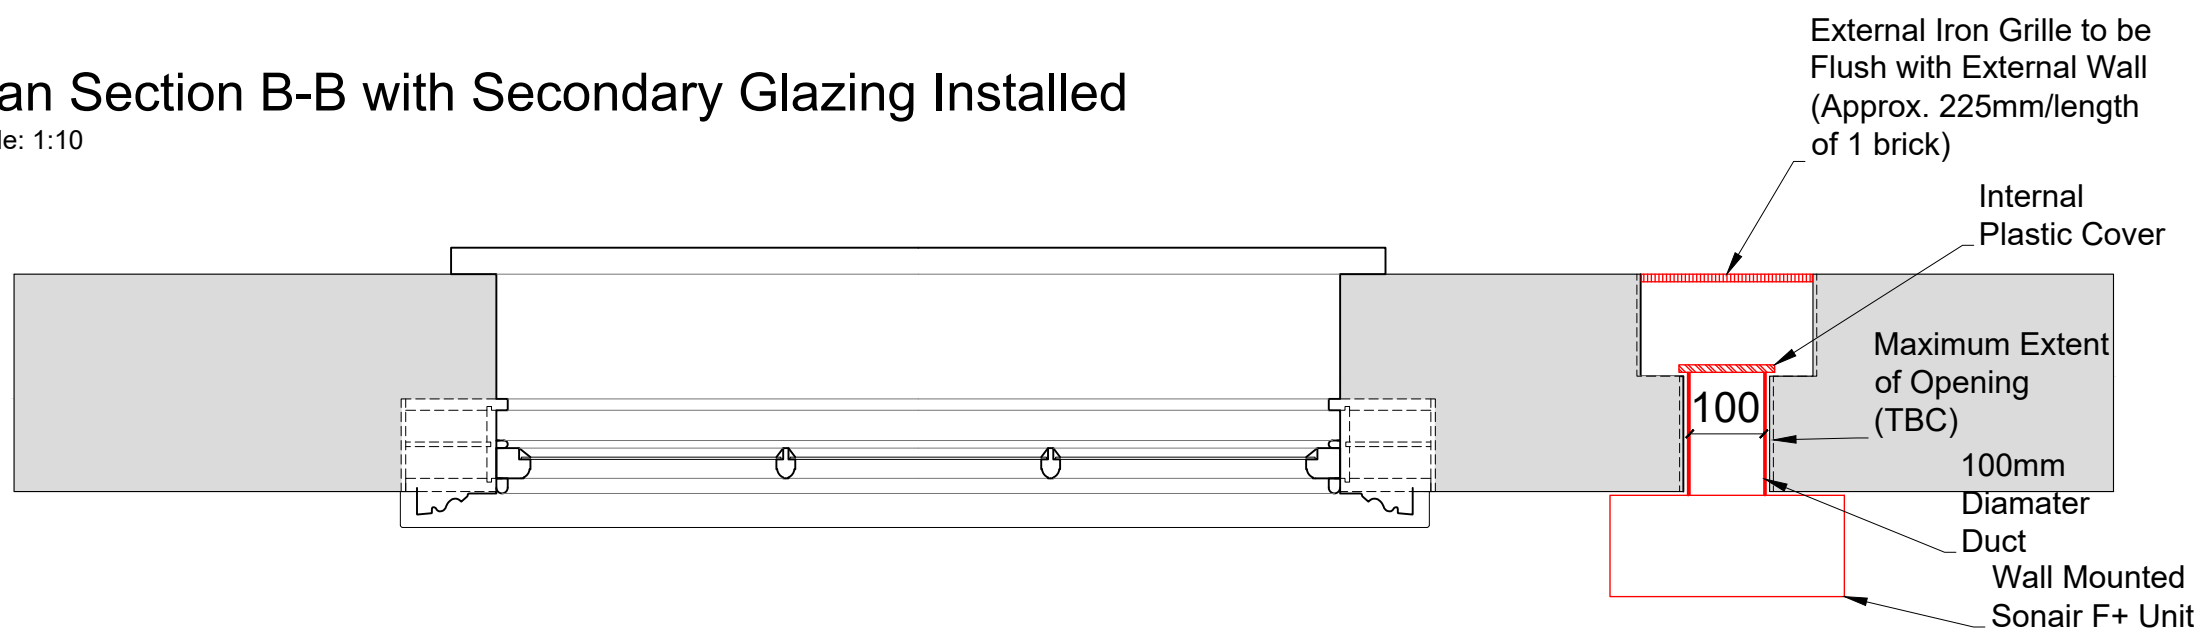

Detail of Sonair Unit
Scale: 1:5

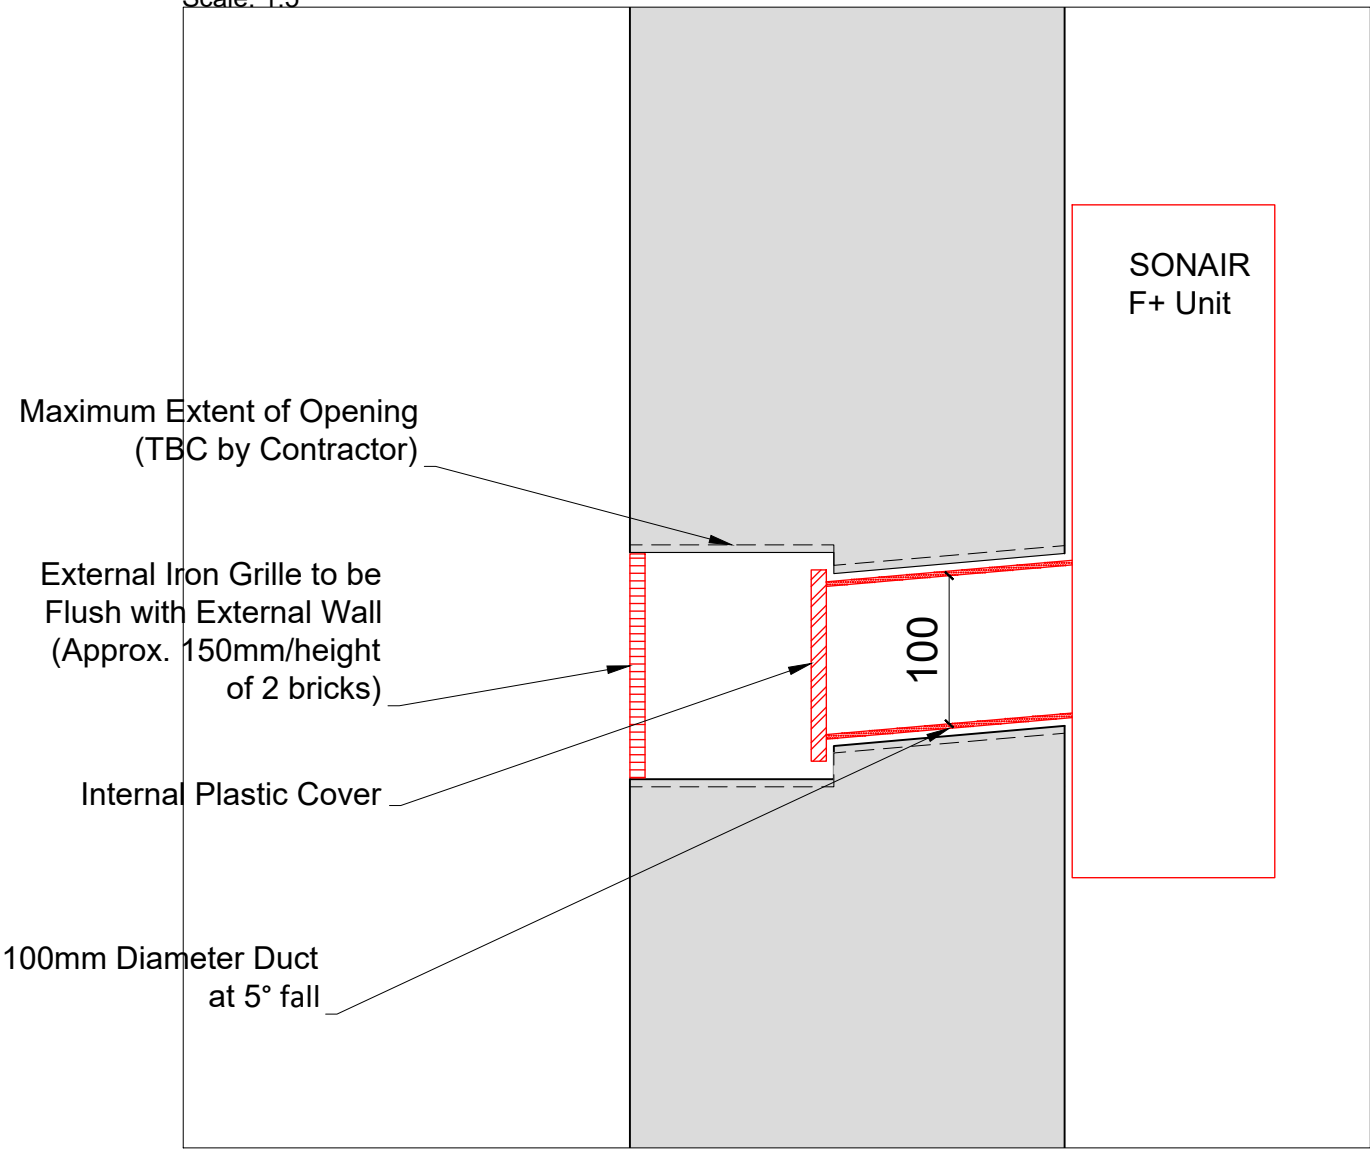

Revision	Date	Amendment
1.0	29-07-2022	Issued for listed building consent Application

Do not reproduce this drawing without written permission
All dimensions are in millimetres unless stated otherwise

Drawing Not For Construction

HS2

High Speed (HS2) Limited
1st/3rd Floor
The Podium
1 Eversholt Street
London NW1 2DN

SKANSKA

Skanska Costain Strabag Joint Venture
Xavier House
5A Granby Terrace
London NW1 3SA

Site Address: 62B Delacey Street, London NW1			
Drawing Title: Second Floor - Bedroom Left&Right: PROPOSED Mechanical Ventilation Details - Sheet 2 of 3			
Submitted by: AP & PB	Primary Drawn by: PB	Secondary Drawn by: AP	Checked by: OB
Presentation Scale: as shown @ A1			Revision: 1.0
Date: 27-09-2021			
Drawing No: WPI P066 NI - 62B DeS-EX-SF-J-04.1			