




 

Notes


This drawing is copyright Piercy&Company. Do not scale from this drawing. All dimensions and levels to be checked on site by the contractor and such dimensions to be his responsibility. Report all drawing errors, omissions and discrepancies to the architect.

Disclaimer


This document may be issued in an editable digital CAD format to enable others to use it as background information to make alterations and/or additions. In that instance the file will be accompanied by a PDF version as a record of the original file. It is for those parties making such alterations and/or additions to ensure that they make use of current background information.

Piercy&Company accepts no liability for either: any such alterations and/or additions to the background information by others; or any other changes made by others to the architectural content of the background information itself.

-  Existing Fabric
-  Proposed Fabric
-  Proposed M&E
-  Deeper arched ceiling
-  Lighting Layout

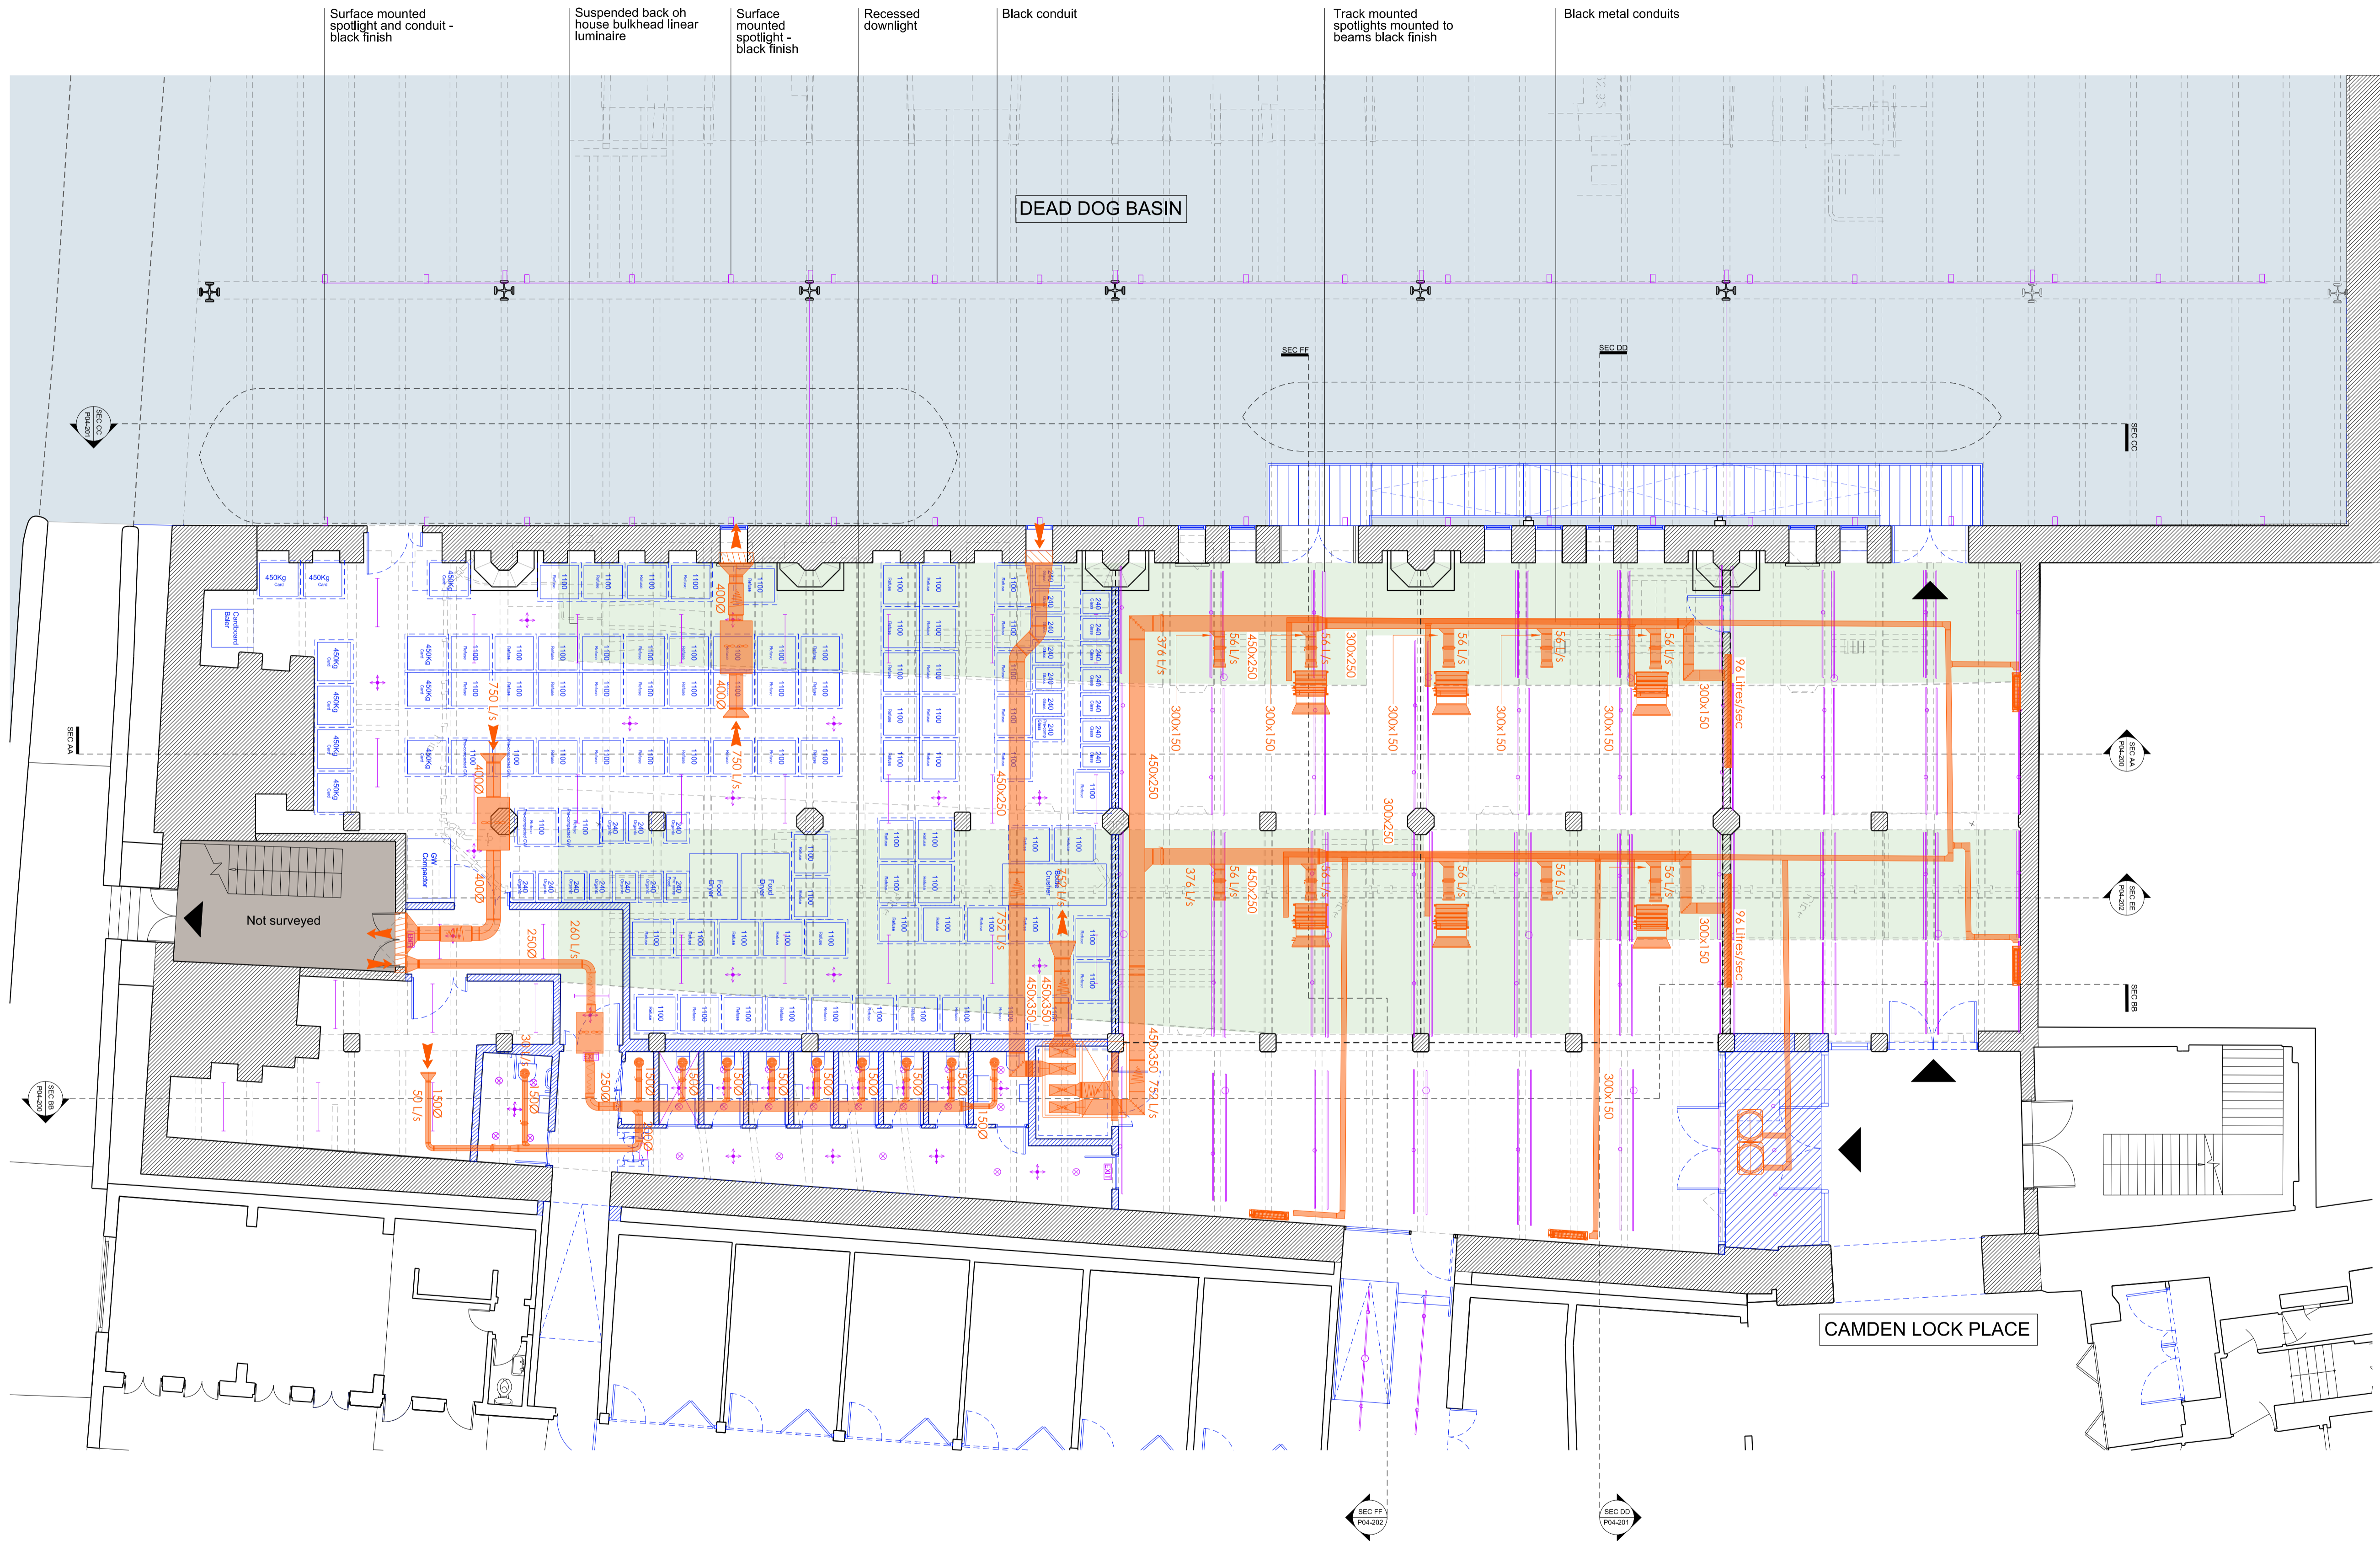

C	30.08.22	Planning Application
Rev	Date	Description

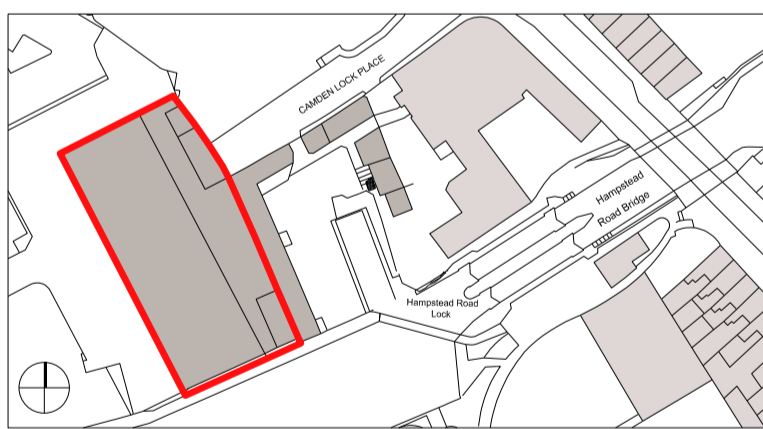

Project
Camden Lock Market

Client
Camden Lock Market Limited

Drawing Title
Proposed Ceiling Plan

Drawn	Checked	Approved
SB	VP	ML
Date	Scale	
06.07.22	1:100 at A1 1:200 at A3	

Drawing Status
PLANNING

Project	Disc	Level	Series	Drw no.	Rev
13663	A	L00	03	101	C

The Centro Building, 39 Plender St
London NW1 0DT
Telephone
+44 (0) 207 424 9611

info@piercyandco.com
www.piercyandco.com