
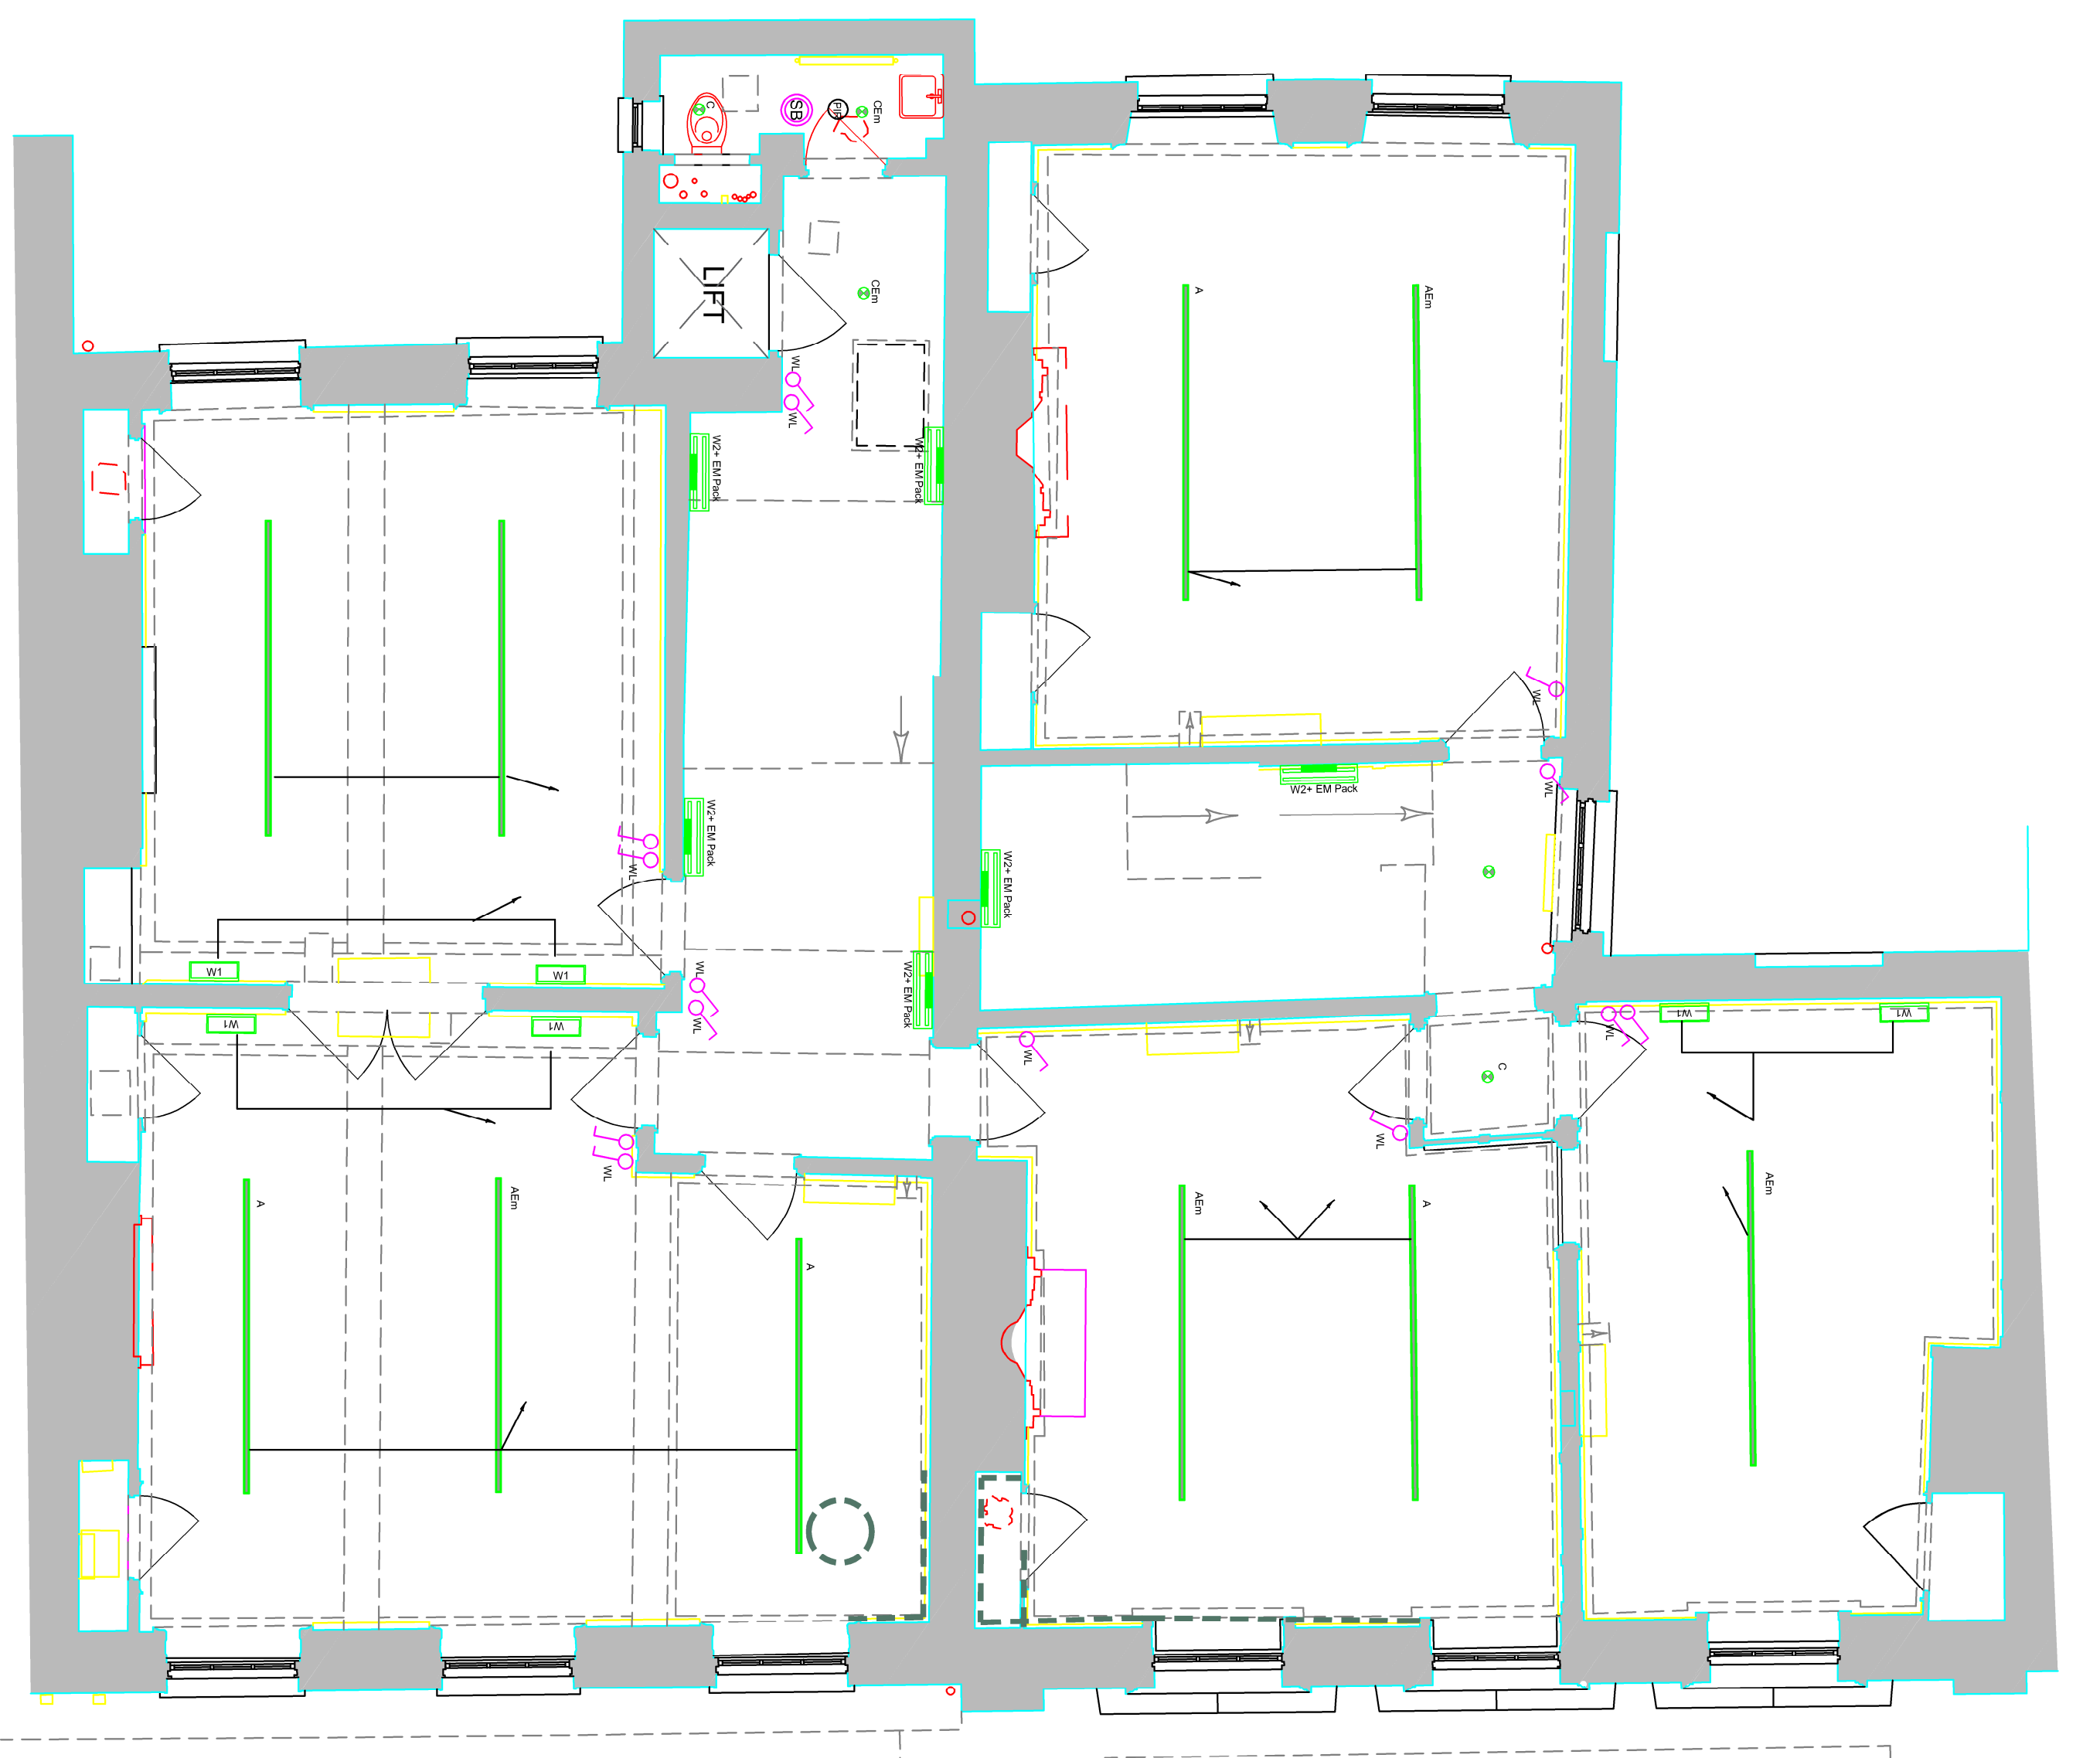


No Additional Lighting Positions. Lights must be installed to existing layout!

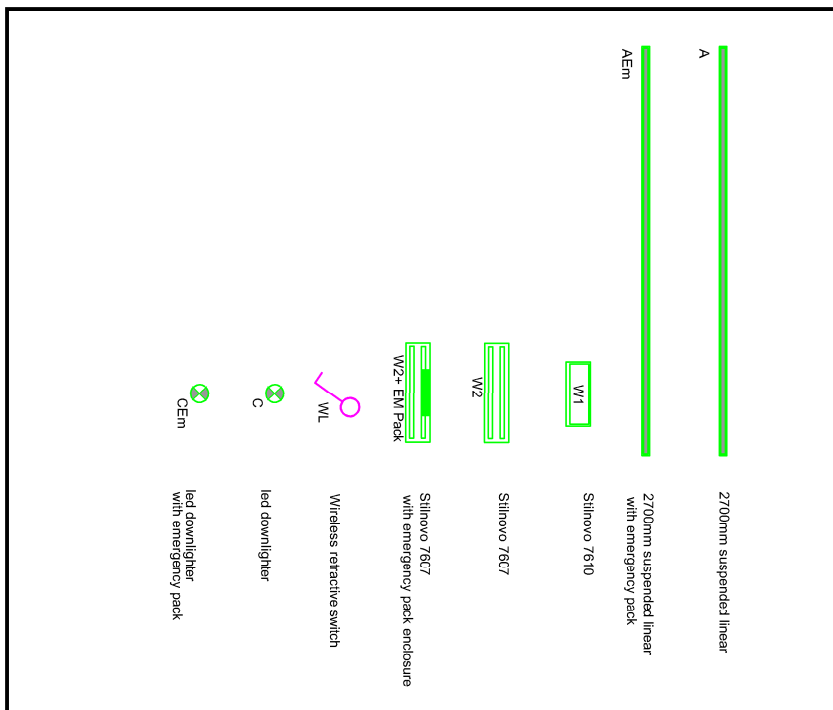

2ND FLOOR - PROPOSED LIGHTING LAYOUT

This drawing is protected under Copyright and at no time must any portion of this drawing be reproduced or copied in anyway without the permission of Morgan Lovell.

SUBJECT TO SITE SURVEY
CHECK SURVEY UNDERTAKEN ONLY
BUILDING PARAMETERS TAKEN FROM
DRAWINGS PROVIDED
BUILDING PARAMETERS TAKEN FROM
AS BUILT DRAWINGS PROVIDED

[illegible]

Morgan Lovell

16 Noel Street London W1F 8DA
T: 0207 734 4466 F: 0207 734 2963 E: contact@morganlovell.com
W: <http://www.morganlovell.com>

W: <http://www.morganlovell.com>

Client

Hogarth Properties (Rothschild)

PROJECT 04
18 & 19 SOUTHAMPTON PLACE

CONSTRUCTION ISSUE

2ND FLOOR PROPOSED LIGHTING LAYOUT

Scale	Date	Designer/Drawn By	Checked By / Date
1:50 @ A0	DEC21	RW	-

Project No.	Floor	Drawing No.	Rev
ML3953	02	LGT	A



Unit 14 Woodlands Business Park
Woodlands Park Avenue
Maidenhead
SL6 3UA

Tel: 01628 822444
Email: info@sovereign-electrical.co.uk
Web: www.sovereign-electrical.co.uk