
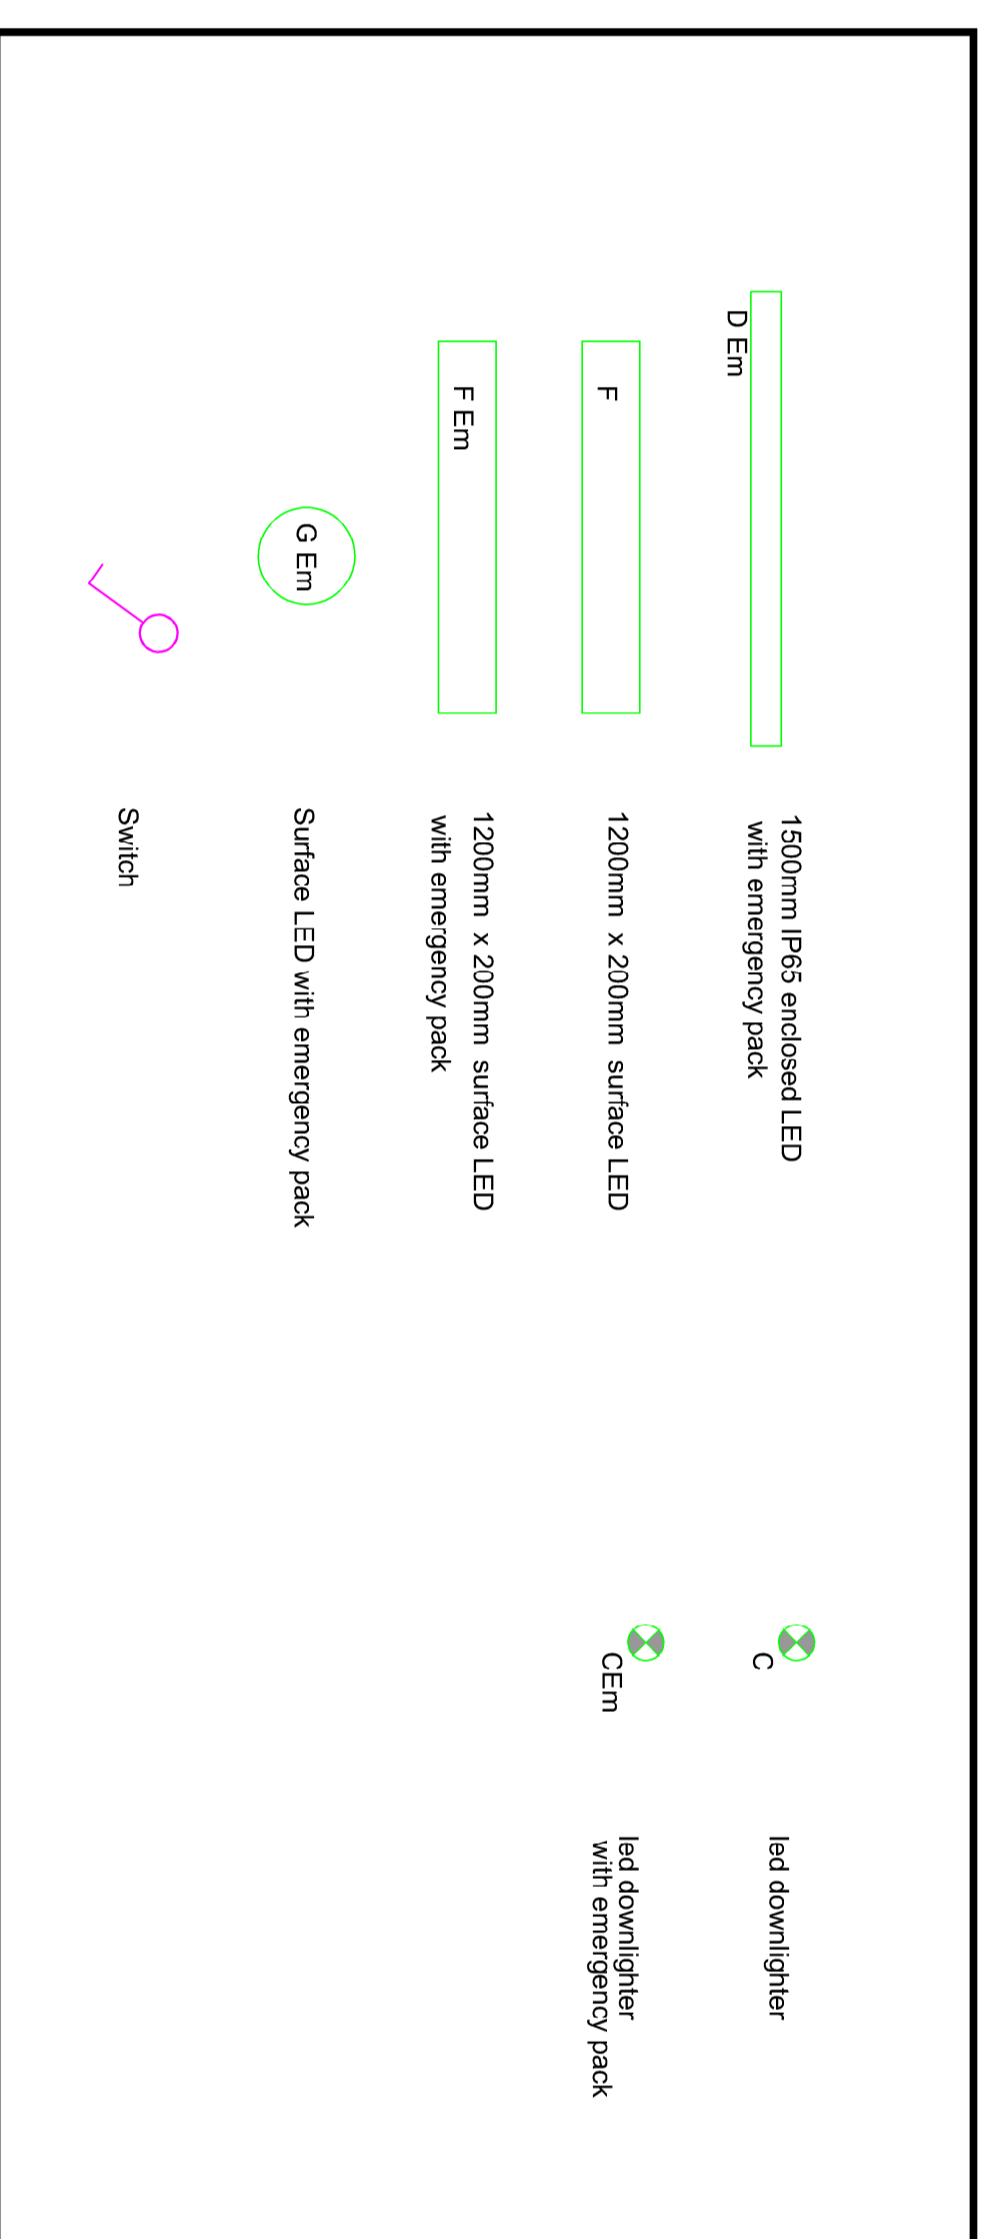


No Additional Lighting Positions. Lights must be installed to existing layout!

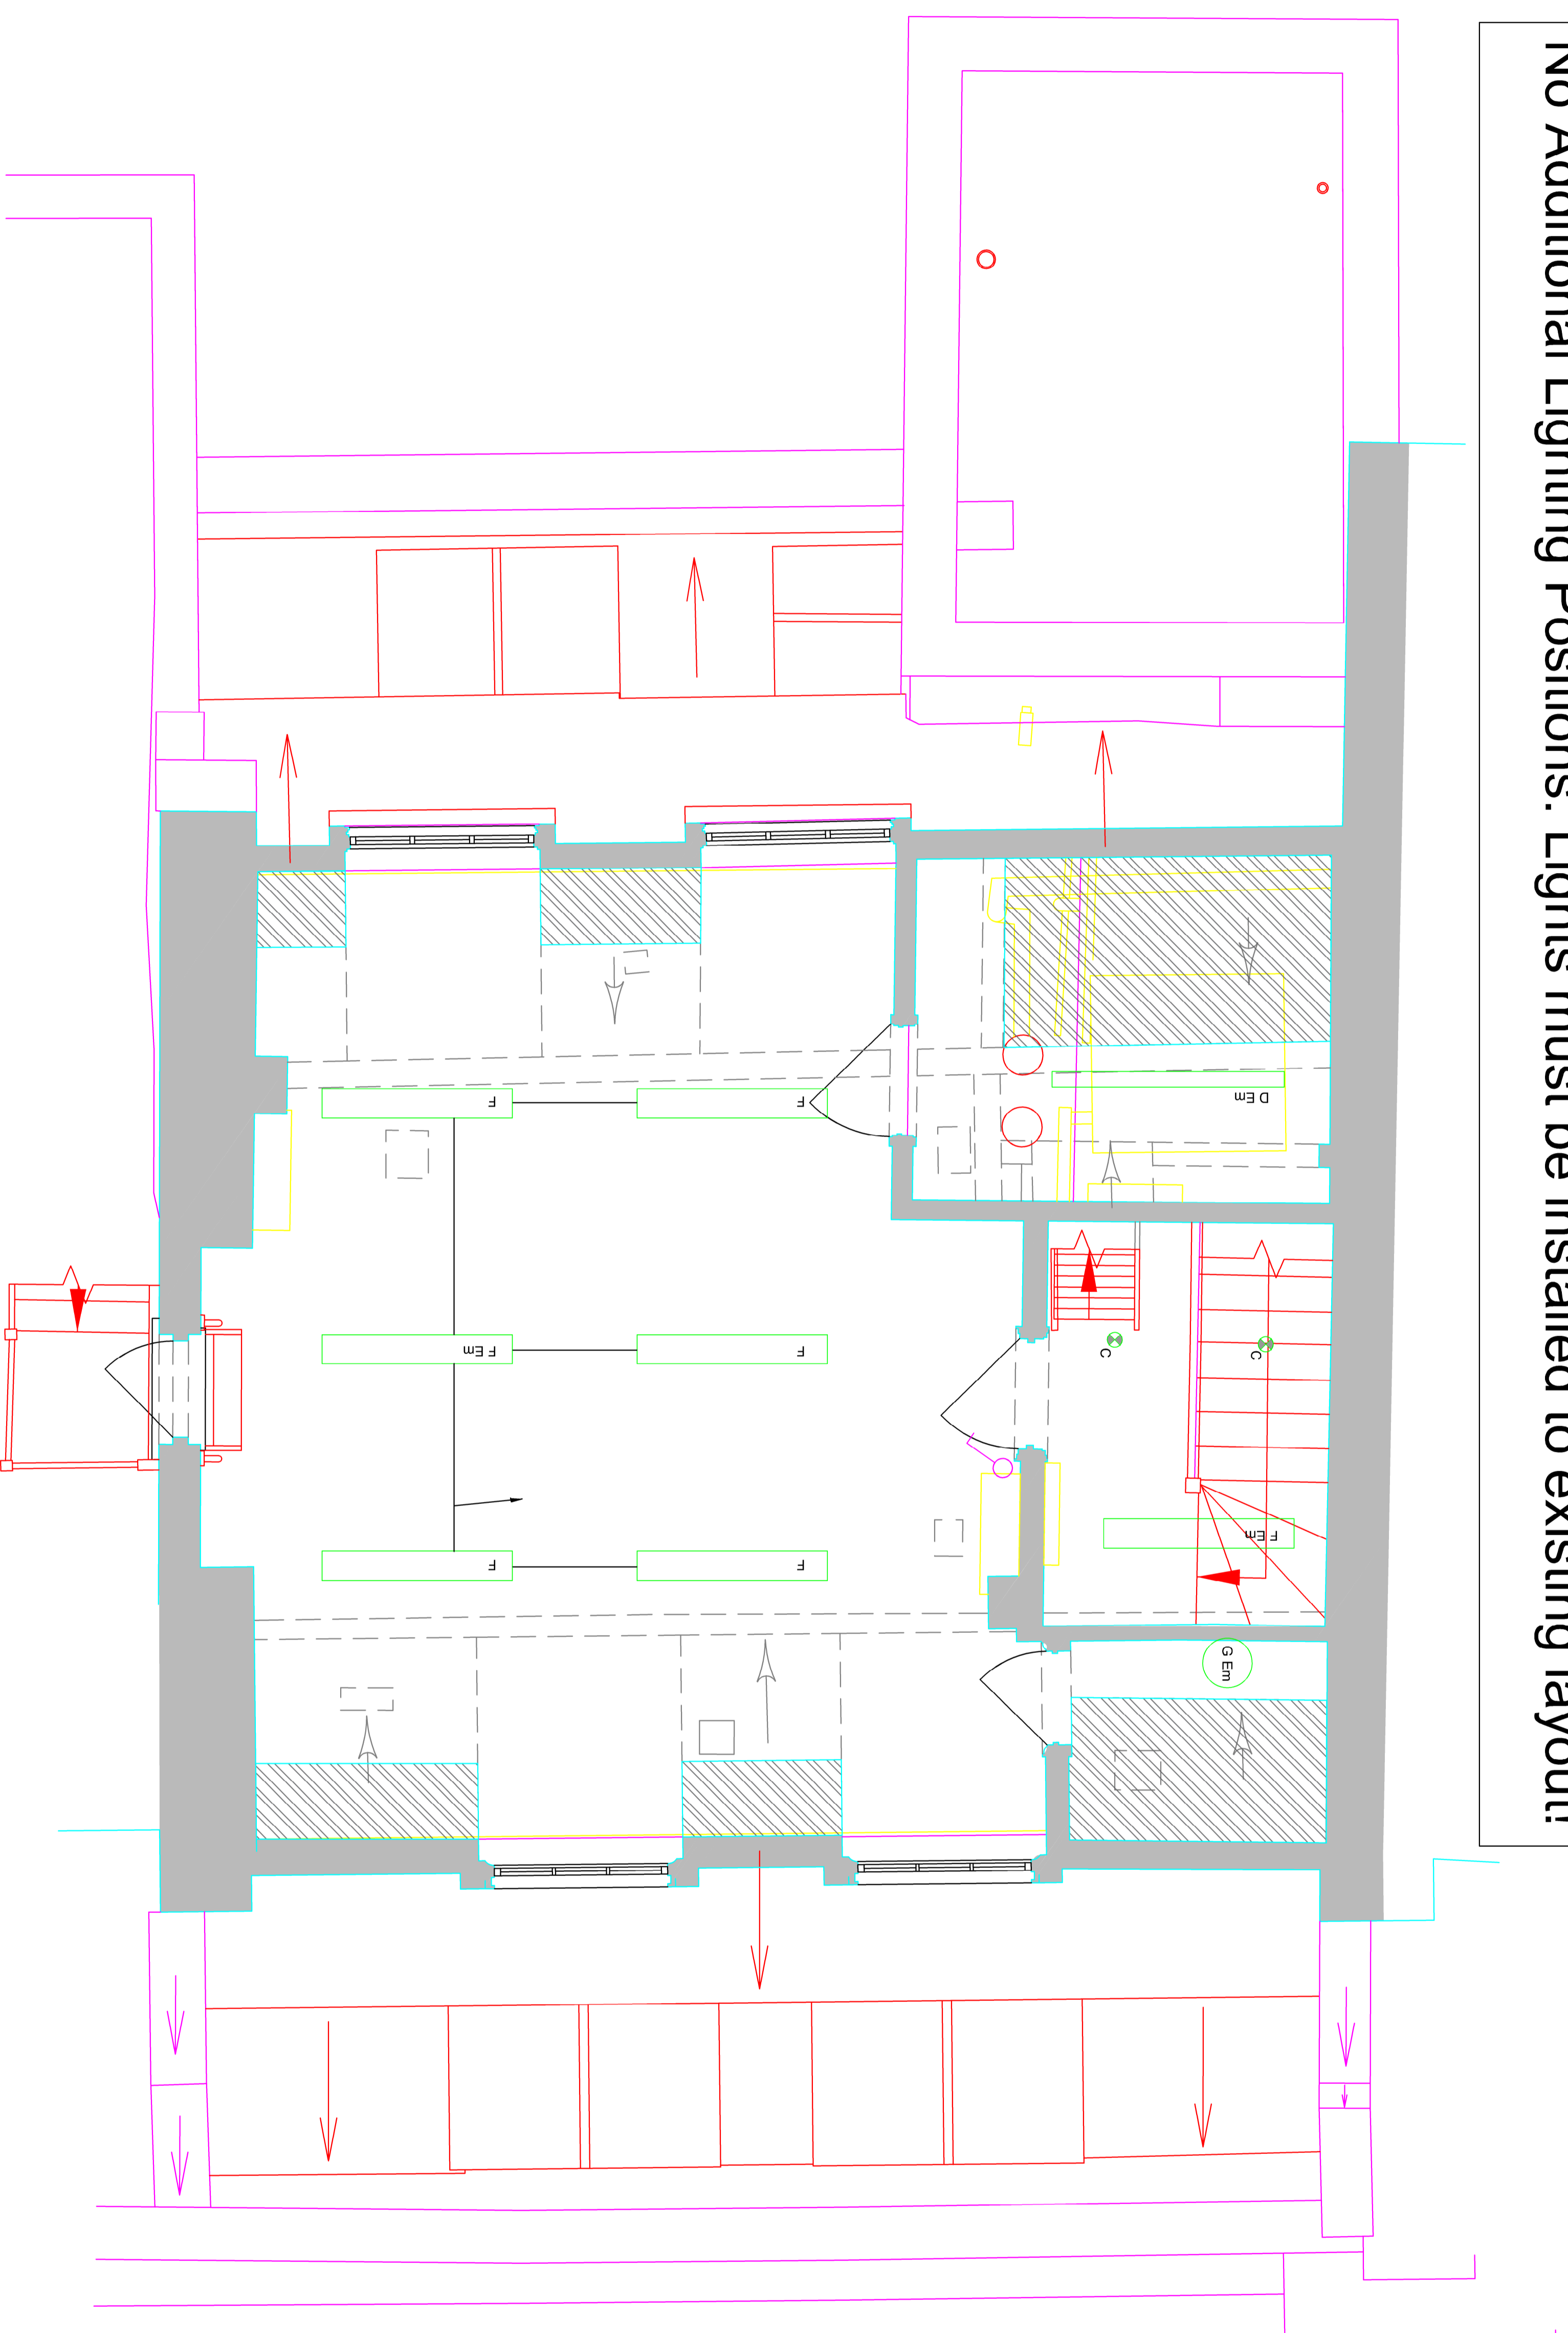

4TH FLOOR - PROPOSED LIGHTING LAYOUT

This drawing is protected under Copyright and at no time must any portion of this drawing be reproduced or copied in anyway without the permission of Morgan Lovell. All dimensions must be checked on site and NOT scaled from this drawing.

SUBJECT TO SITE SURVEY
CHECK SURVEY UNDERTAKEN ONLY
BUILDING PARAMETERS TAKEN FROM
DRAWINGS PROVIDED
BUILDING PARAMETERS TAKEN FROM
AS BUILT DRAWINGS PROVIDED

Rev	Revision	By	Chk	Date
A	Note Added "No Additional Lighting Positions"	SW		16/08/2022

Morgan Lovell
16 Noel Street London W1F 8DA
T: 0207 734 4466 F: 0207 734 2969 E: contact@morganlovell.com
W: http://www.morganlovell.com

Client: **Hogarth Properties (Rechtschild)**
Project: **PROJECT 04**
18 & 19 SOUTHAMPTON PLACE

Title: 4TH FLOOR PROPOSED LIGHTING LAYOUT		Drawing No: ML3953	
Scale: 1:25 @ A0	Date: DEC 21	Floor: 04	Drawing No: LGT
Designed/Drawn By: RV	Checked By: RV	Rev: A	

sovereign
ELECTRICAL SERVICES
Unit 14 Woodside Business Park
Woodlands Park Avenue
Malden Kent
SLE 20A
Tel: 01823 822444
Email: info@sovereign-electrical.co.uk
Web: www.sovereign-electrical.co.uk

CONSTRUCTION ISSUE