
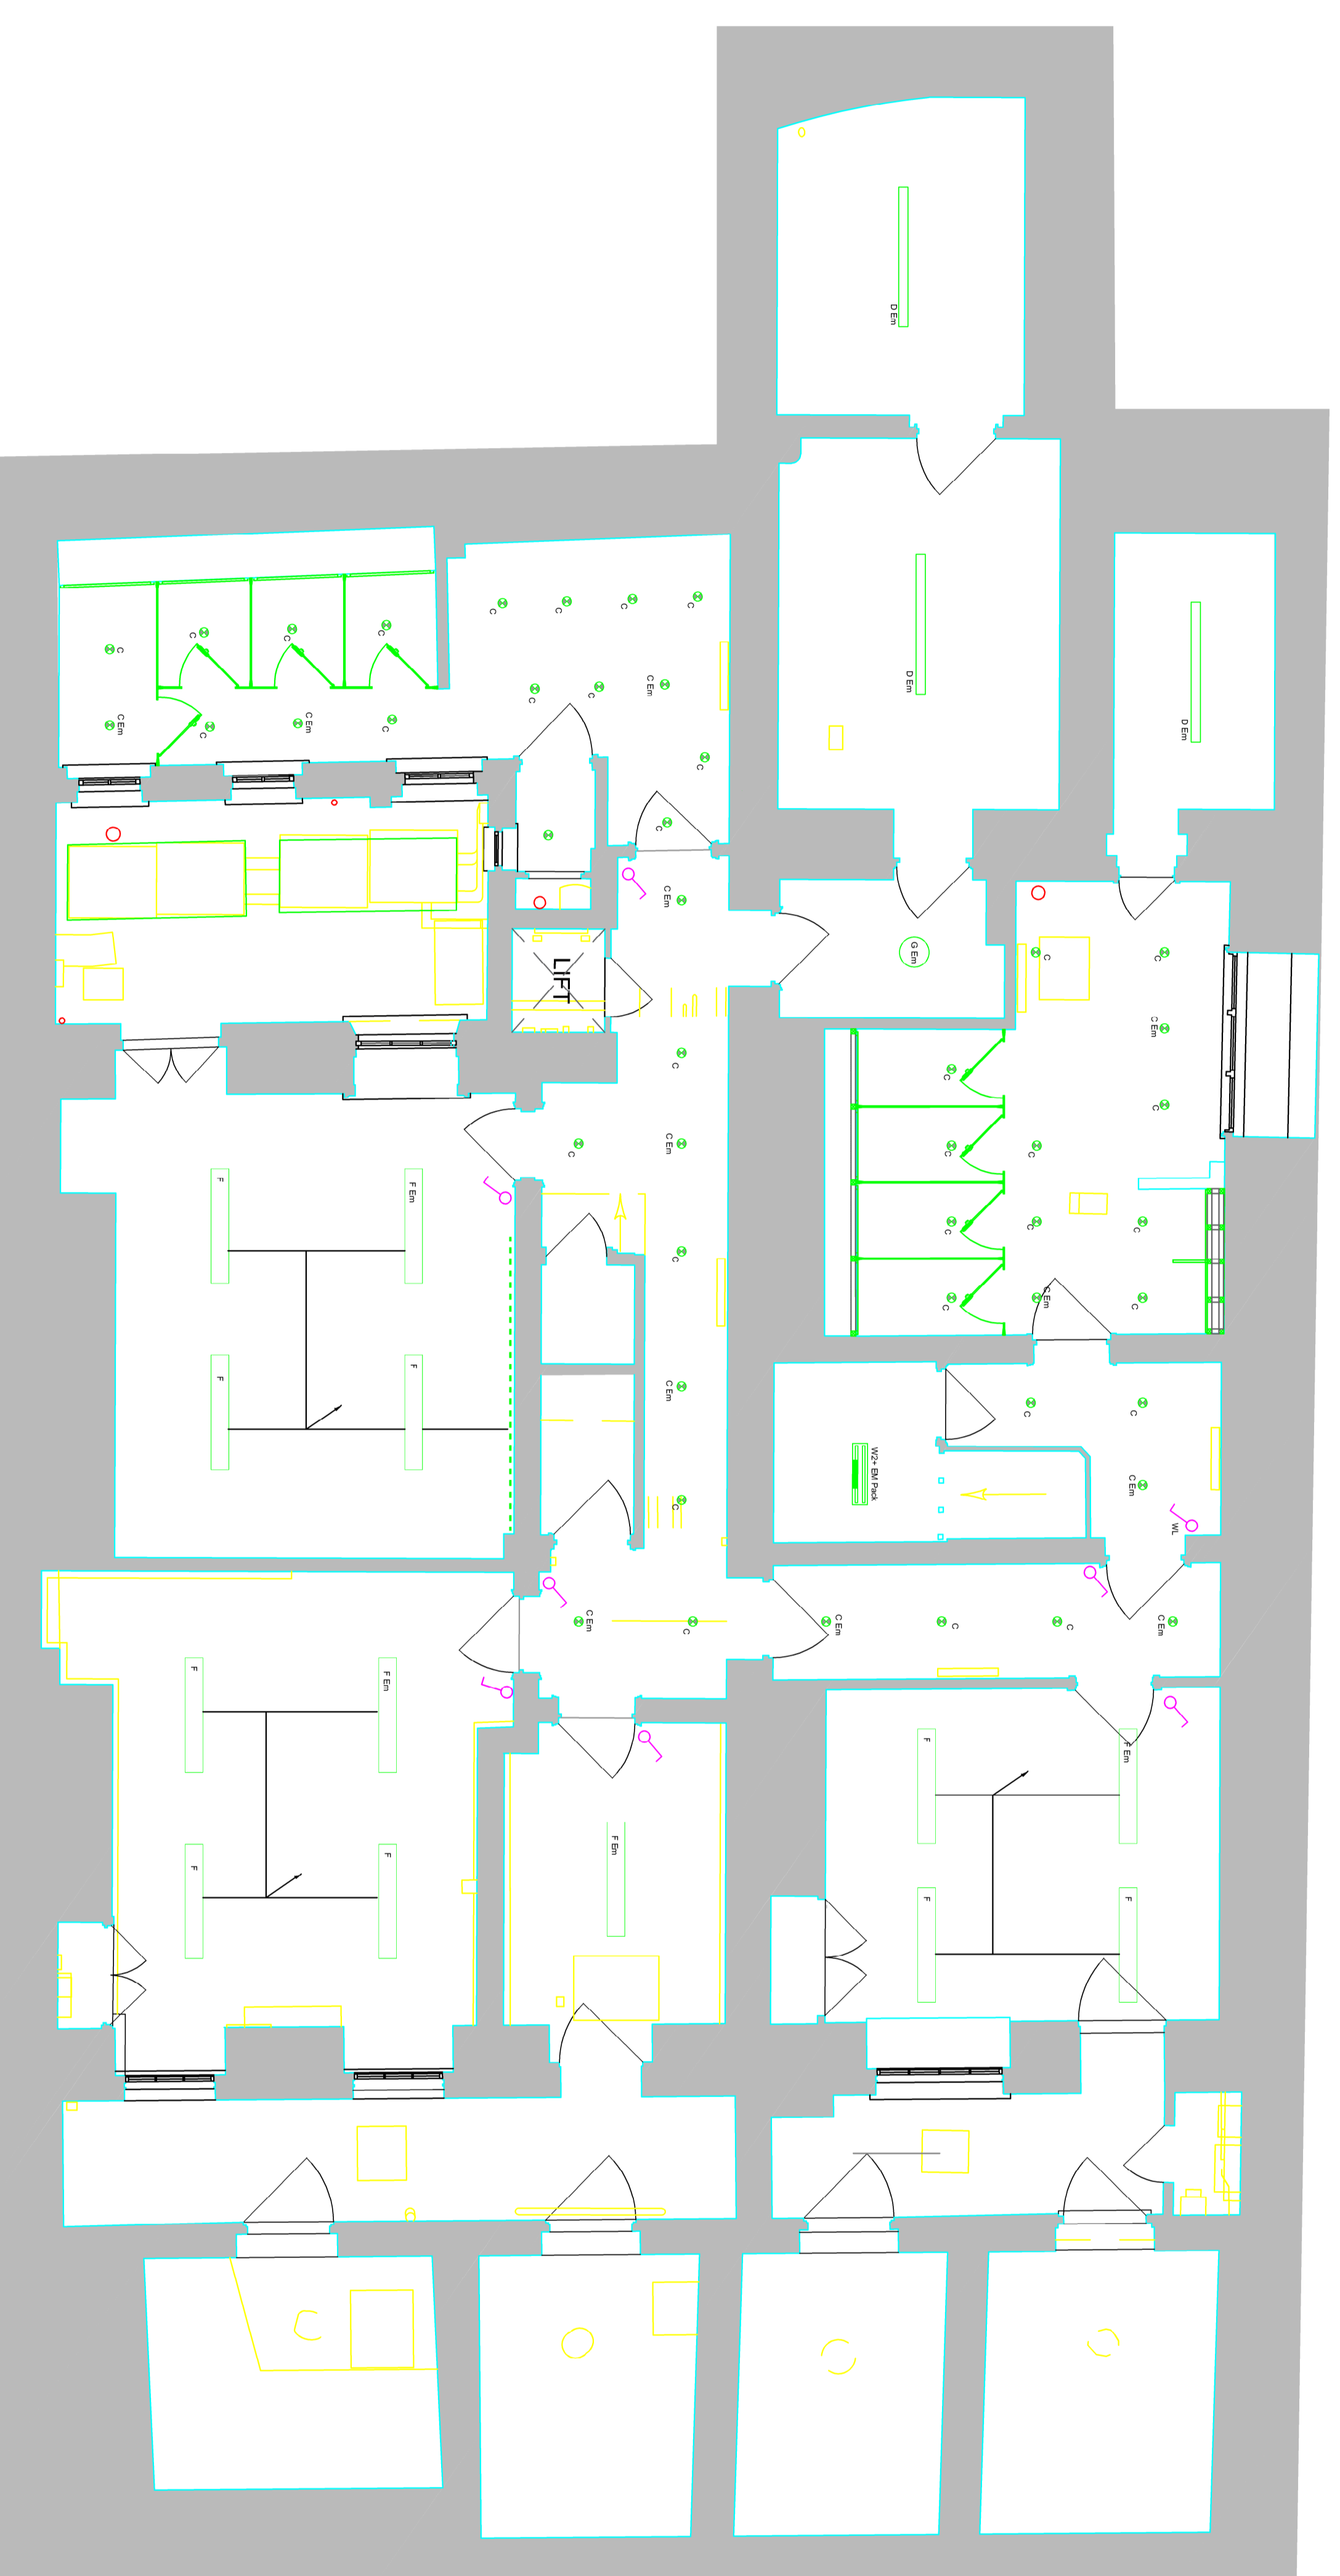
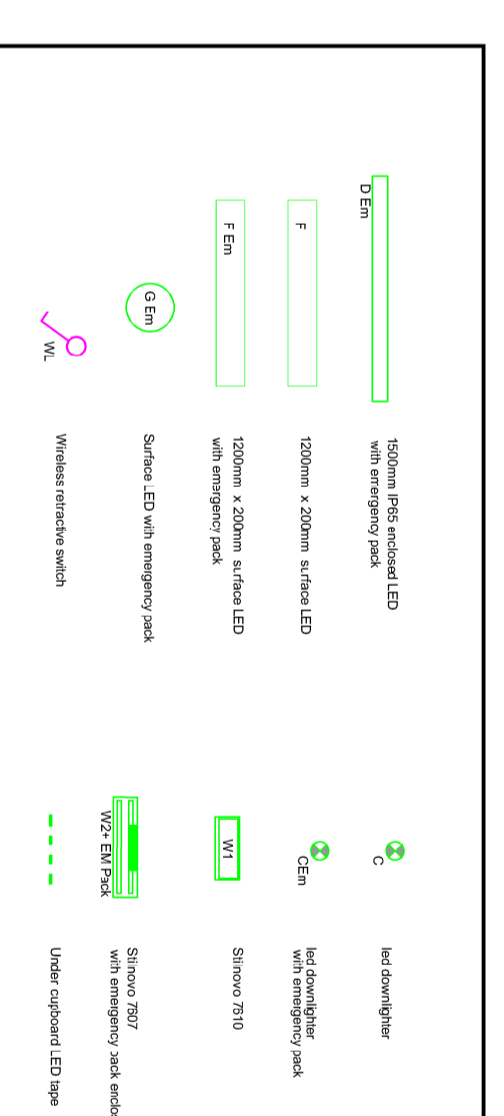


NO ADDITIONAL LIGHTING POSITIONS. LIGHTS MUST BE INSTALLED TO EXISTING LAYOUT!

### UPPER LANDING PLAN

1:50 @ A0

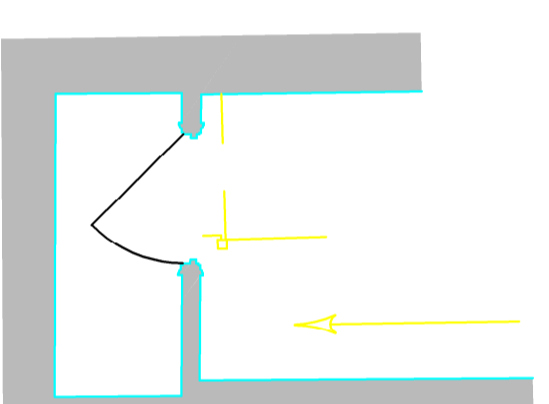

## BASEMENT FLOOR - LIGHTING LAYOUT

This drawing is protected under Copyright and at no time must any portion of this drawing be reproduced or copied in anyway without the permission of Morgan Lovell. All dimensions must be checked on site and NOT scaled from this drawing.

SUBJECT TO SITE SURVEY  
CHECK SURVEY UNDERTAKEN ONLY  
BUILDING PARAMETERS TAKEN FROM  
DRAWINGS PROVIDED  
BUILDING PARAMETERS TAKEN FROM  
AS BUILT DRAWINGS PROVIDED

Rev	By	Date	Reason
A	RW	14/12/23	Under cupboard LED added
B	SW	16/02/24	Note added 'No additional Lighting Positions'

**Morgan Lovell**

16 Neal Street London, W1F 8DA  
T: 0207 734 4496 F: 0207 734 2998 E: contact@morganlovell.com  
W: <http://www.morganlovell.com>

Client  
**Hogarth Properties (Rothschild)**

Project  
**PROJECT 04  
18 & 19 SOUTHAMPTON PLACE**

**CONSTRUCTION ISSUE**

This  
**BASEMENT FLOOR  
LIGHTING LAYOUT**

Scale	Date	Design/Drawn By	Checked By	Date
1:50 @ A0	DEC 21	RW		

Drawing Number	Floor	Drawing No.	Rev
<b>ML3953</b>	<b>0B</b>	<b>LGT</b>	<b>B</b>

**sovereign**  
ELECTRICAL SERVICES  
Unit 14 Woodlane Business Park  
Woodlands Park Avenue  
Middletown  
S16 5LN  
Tel: 01628 822444  
Email: [info@sovereign-electrical.co.uk](mailto:info@sovereign-electrical.co.uk)  
Web: [www.sovereign-electrical.co.uk](http://www.sovereign-electrical.co.uk)