
 


1 LOWER GROUND FLOOR PLAN  
1:25 @ A1 / 1:50 @ A3

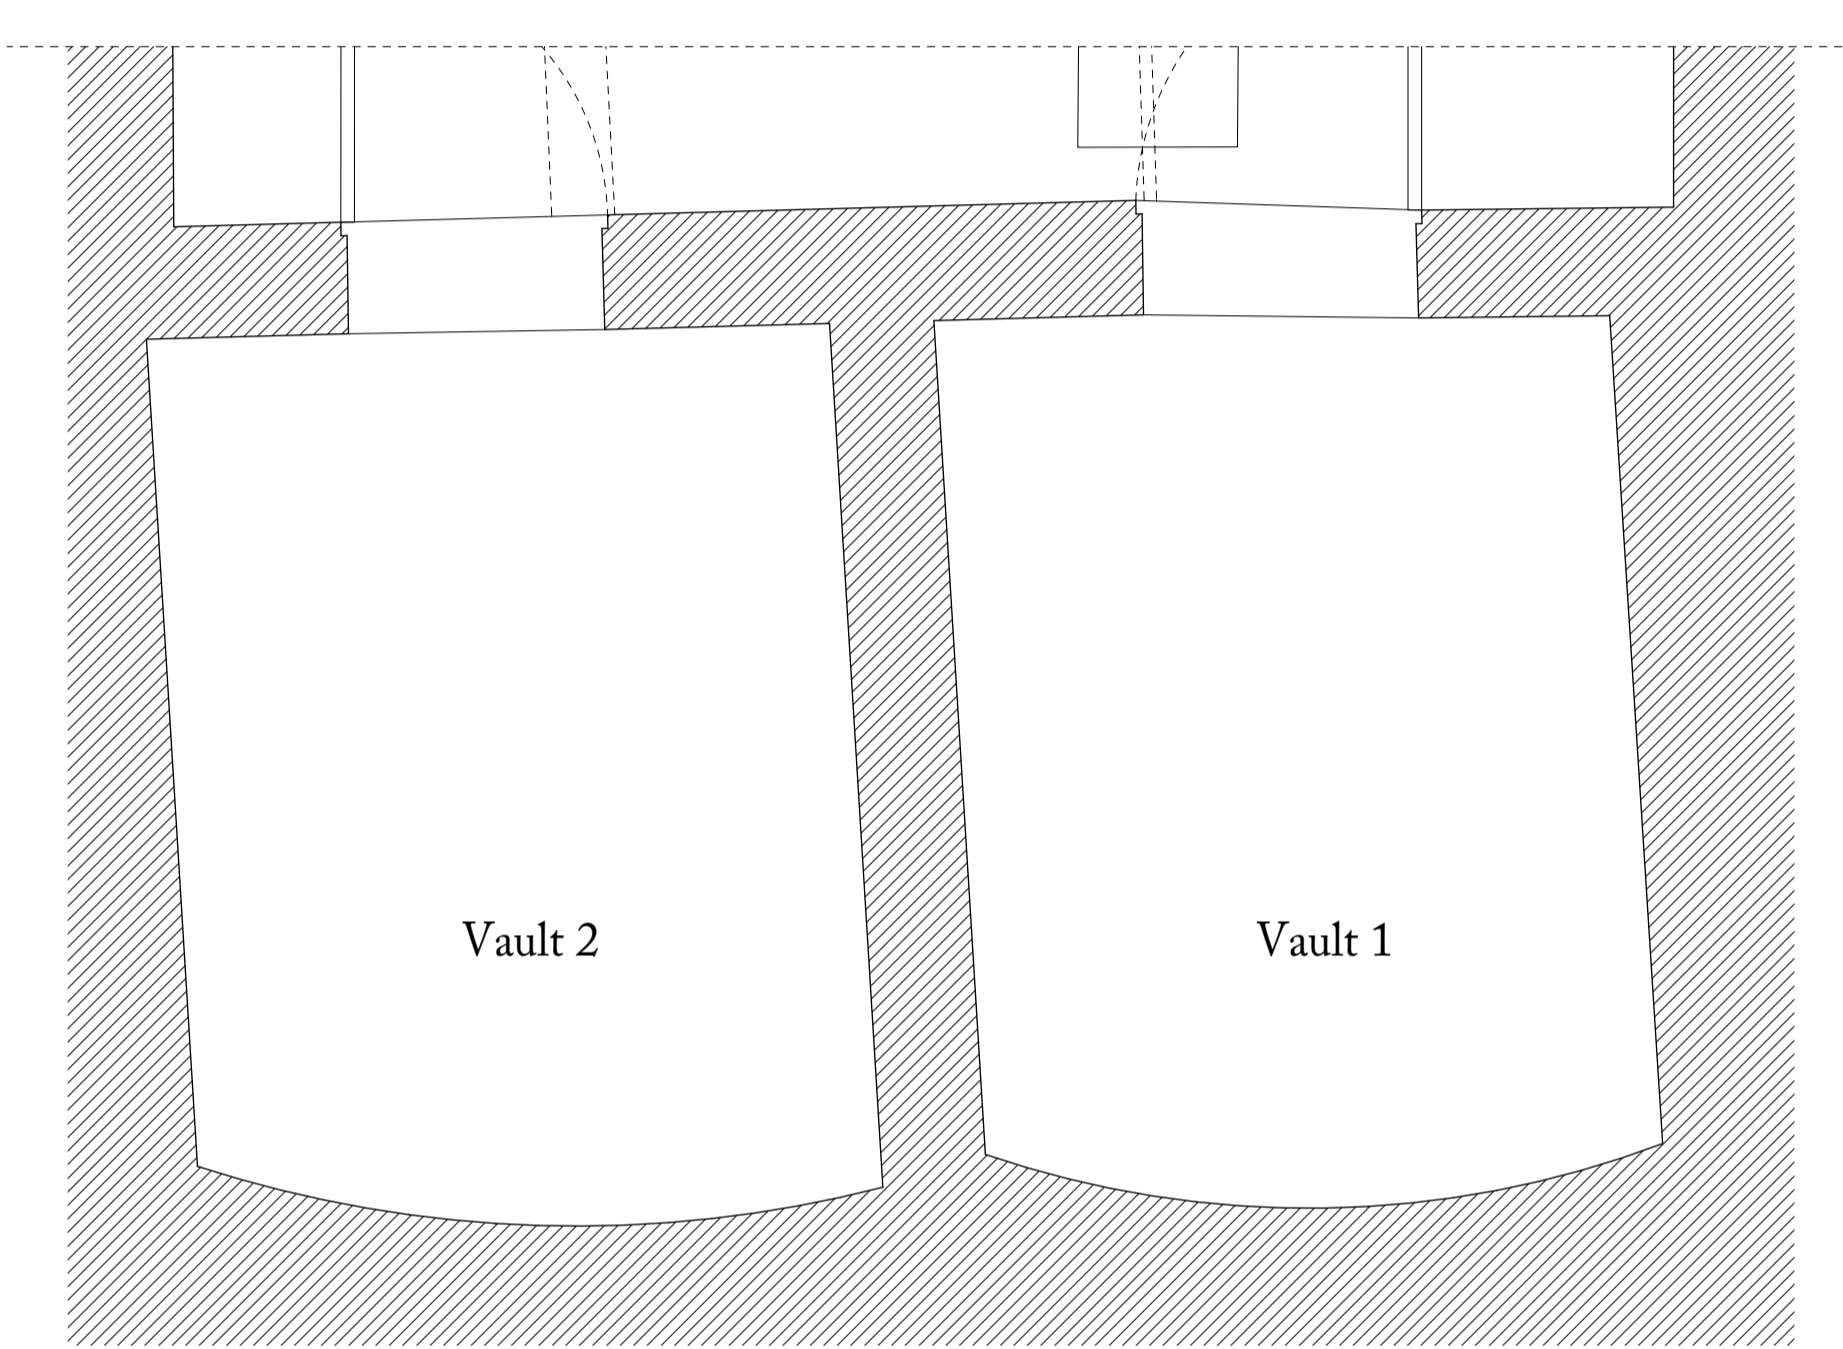

2 VAULT PLAN  
1:25 @ A1 / 1:50 @ A3

Mantlepiece to be reinstated



Ben Pentreath		1-4 Lamp Office Court Lamb's Conduit Street London WC1N 3NF T +44 (0) 20 7430 2424 benpentreath.com	
PROJECT: 8 GROVE TERRACE		REV. NO: -	
TITLE: PROPOSED LOWER GROUND FLOOR PLAN			
DRAWING NO: A-100	REV. NO: -		
SCALE: 1:25 @ A1 1:50 @ A3	DRAWN BY: RH		
DATE: 00.09.22	CHECKED BY: RG		
All dimensions to be checked on site. All designs © Ben Pentreath Ltd 2022. Not to be reproduced without permission			